


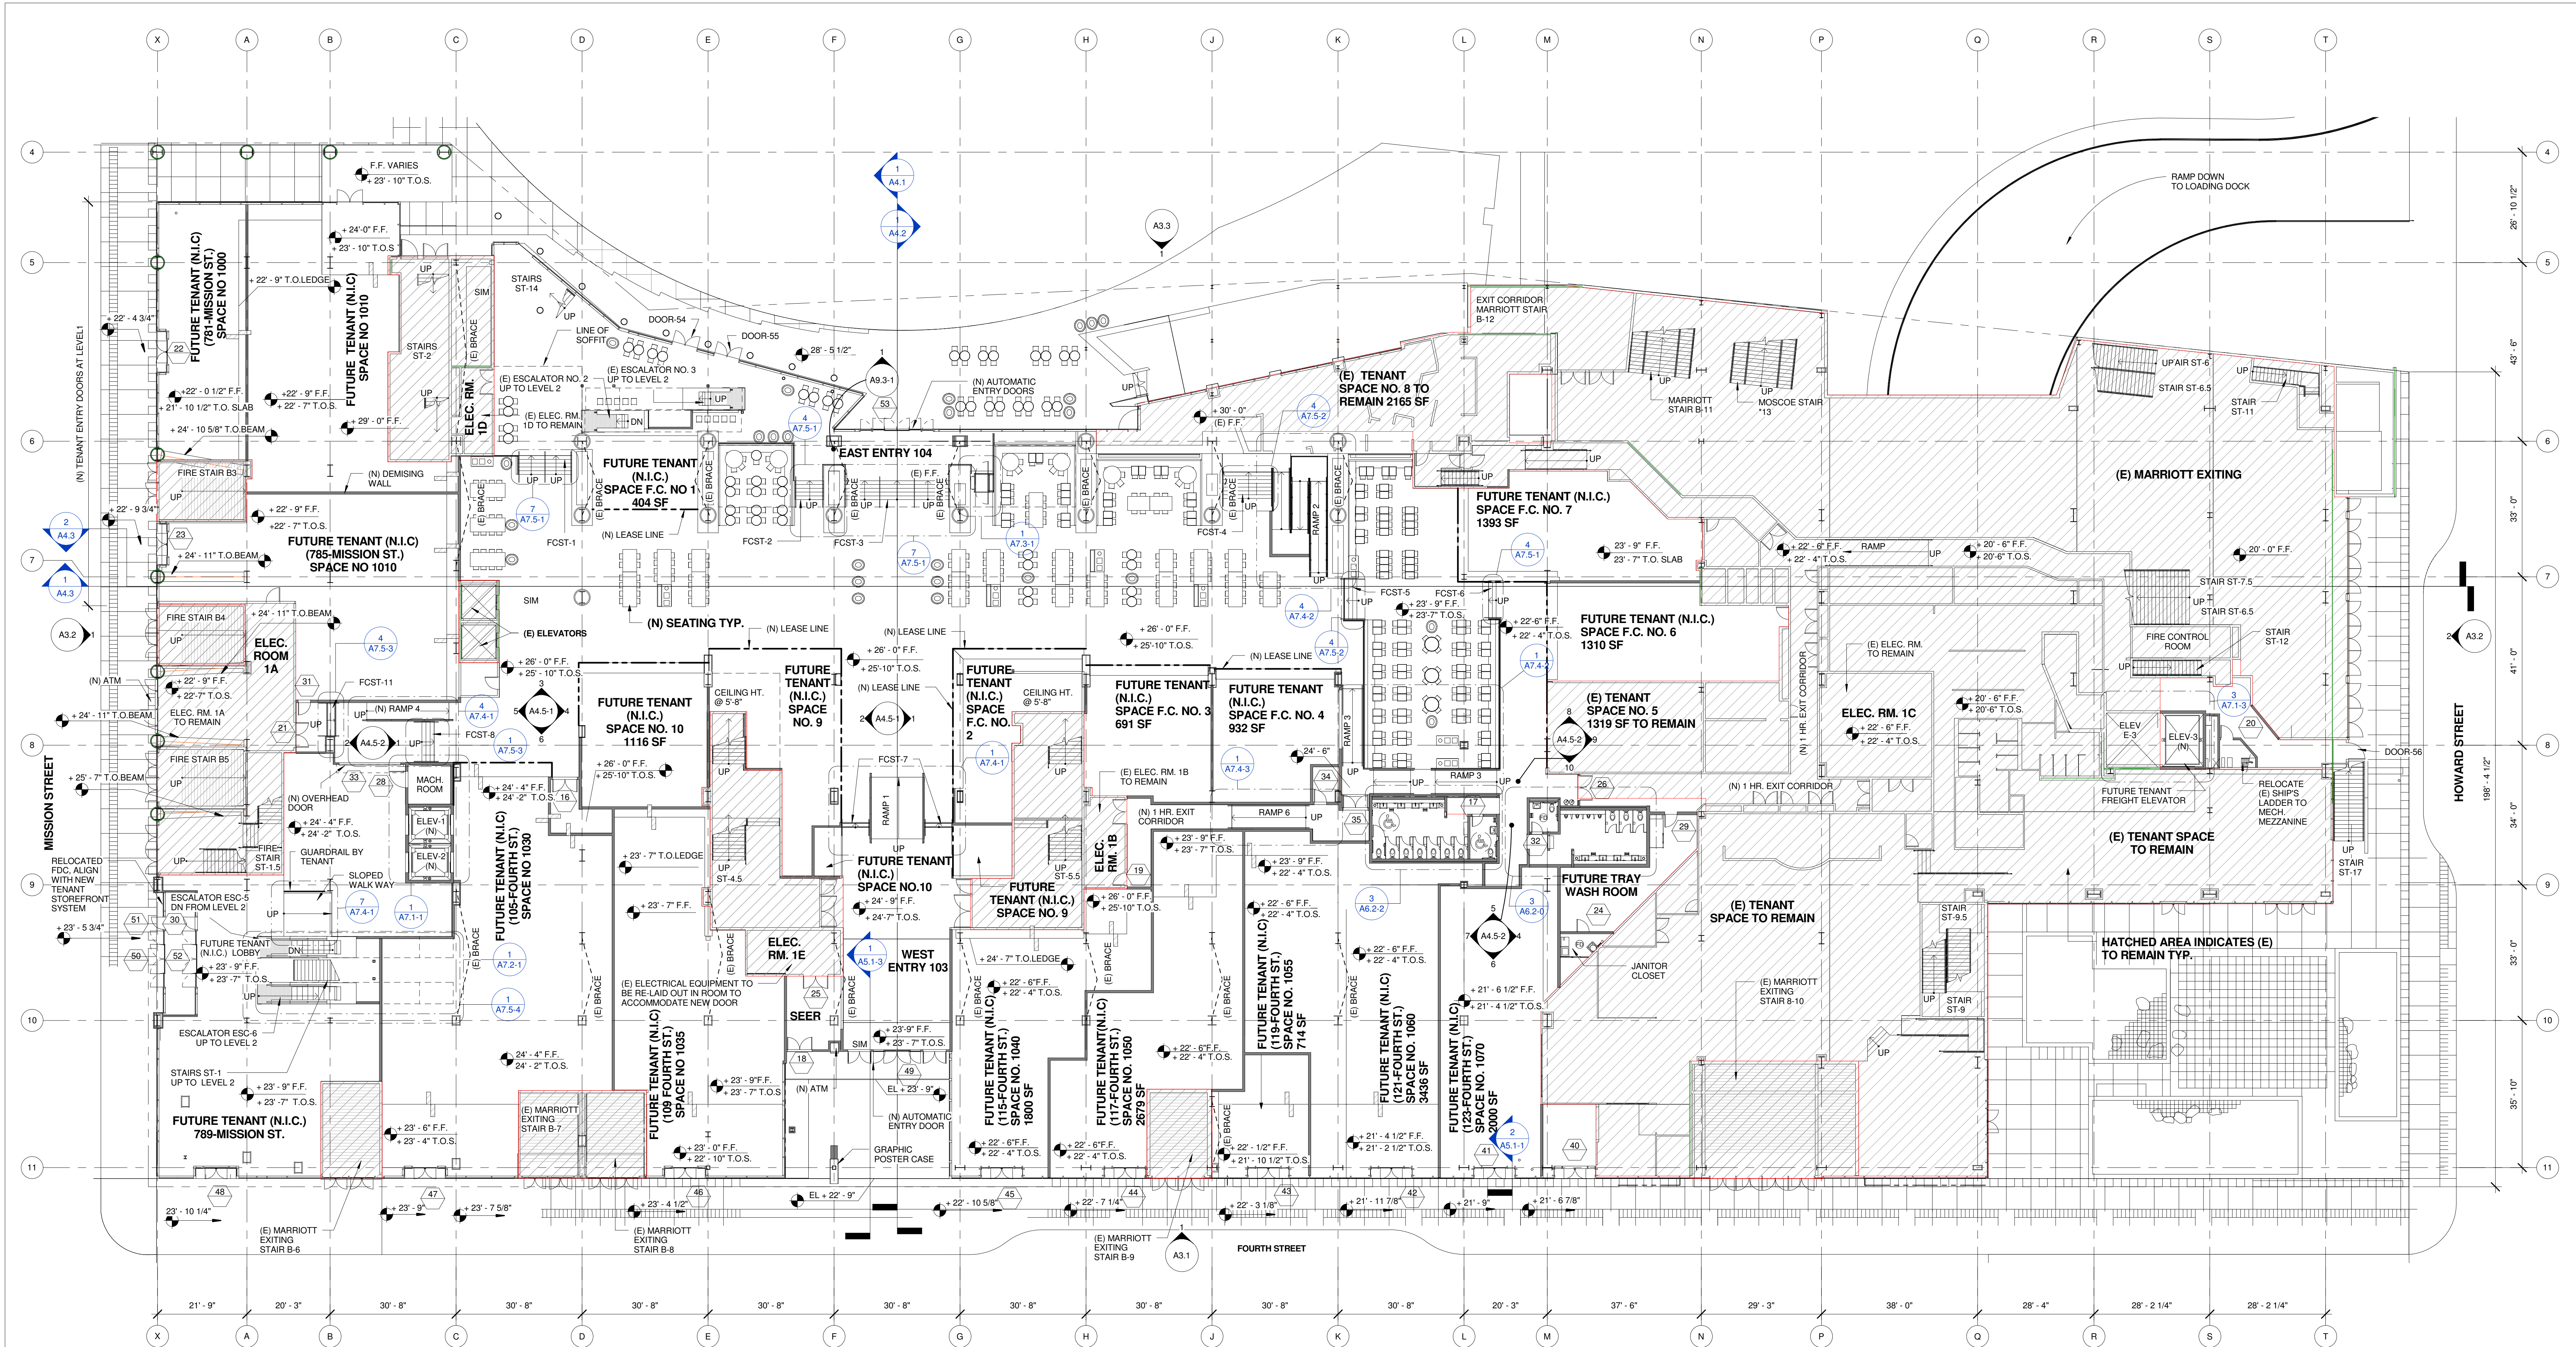

GENERAL NOTES

1. ARCHITECTURAL 0'-0" DATUM IS EQUAL TO ... ALL SPOT ELEVATIONS ARE COORDINATED TO THE ARCHITECTURAL 0'-0" DATUM.
 2. SEE LIGHTING CONSULTANTS LIGHTING PLANS, SCHEDULES, AND CUT SHEETS FOR LIGHTING INFORMATION.
 3. SEE SHEET A8.1-1 & A8.1-2 FOR WALL TYPES.
 4. SEE SHEET A2.1A FOR LOCATION OF NEW LEASE LINES & NEW WALLS.
- SEE SHEET A6.1 FOR ENLARGED FOOD COURT PLAN


FLOOR PLAN LEGEND

	EXISTING WALL
	NEW WALL
	NOT IN AREA OF WORK

Consultants:

Registration No.

Key Plan

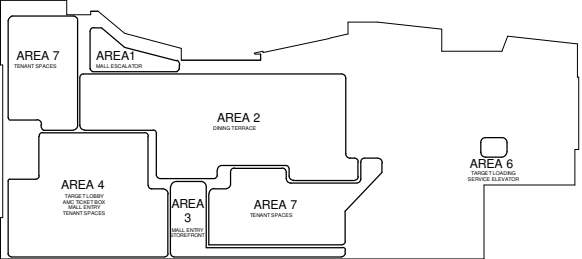


Sheet Title

**PROPOSED
GROUND FLOOR
PLAN**

Job No. Date Scale
1295 SEPT 01, 2010. 1/16" = 1'-0"

A2.1

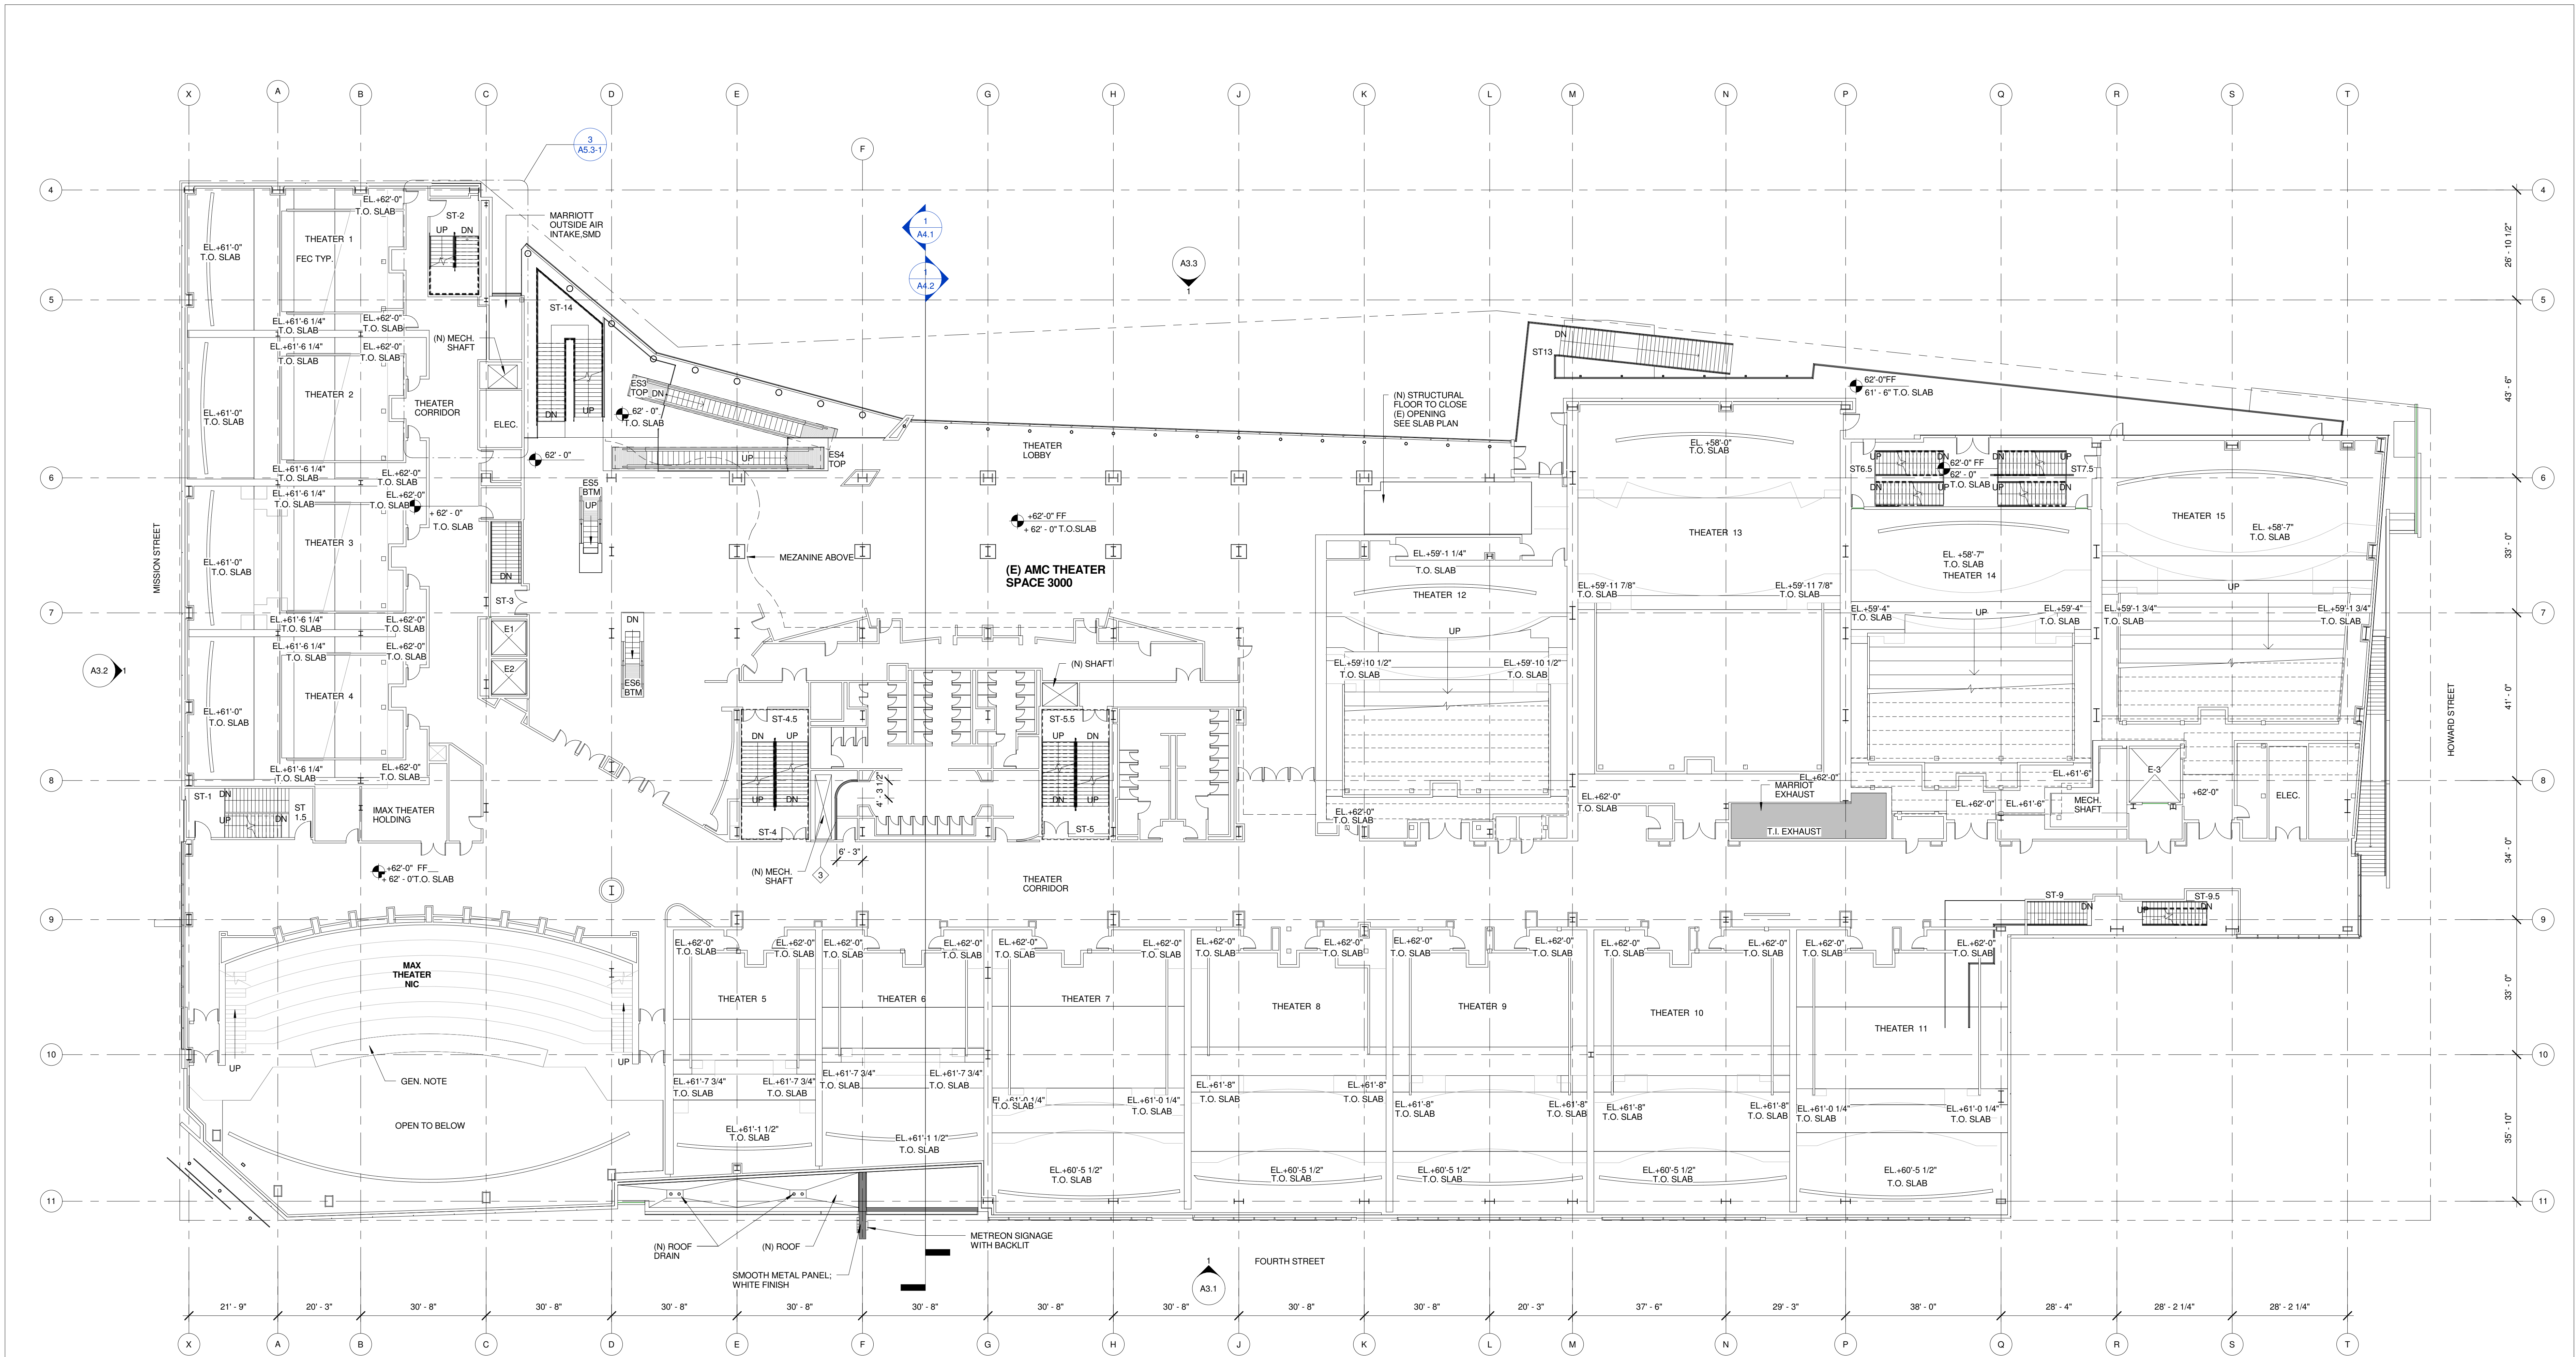

GENERAL NOTES

1. ARCHITECTURAL 0'-0" DATUM IS EQUAL TO --- ALL SPOT ELEVATIONS ARE COORDINATED TO THE ARCHITECTURAL 0'-0" DATUM.
2. SEE LIGHTING CONSULTANTS LIGHTING PLANS, SCHEDULES, AND CUT SHEETS FOR LIGHTING INFORMATION.
3. SEE SHEET A8.1-1 & A8.1-2 FOR WALL TYPES.
4. SEE SHEET A2.1A FOR LOCATION OF NEW LEASE LINES & NEW WALLS. ENGINEER, ACOUSTICS AND ARCHITECT FOR GRILL AND LOCATION


FLOOR PLAN LEGEND

	EXISTING WALL
	NEW WALL
	NOT IN AREA OF WORK

Consultants:

Registration No.

Key Plan

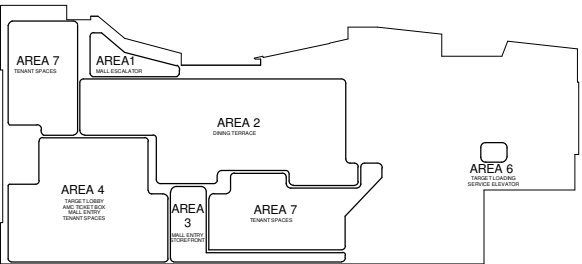




































































































































































Sheet Title


PROPOSED THIRD FLOOR PLAN

Job No. 1295 Date SEPT 01, 2010. Scale 1/16" = 1'-0"

A2.3

YERBA BUENA PARK ENTRY

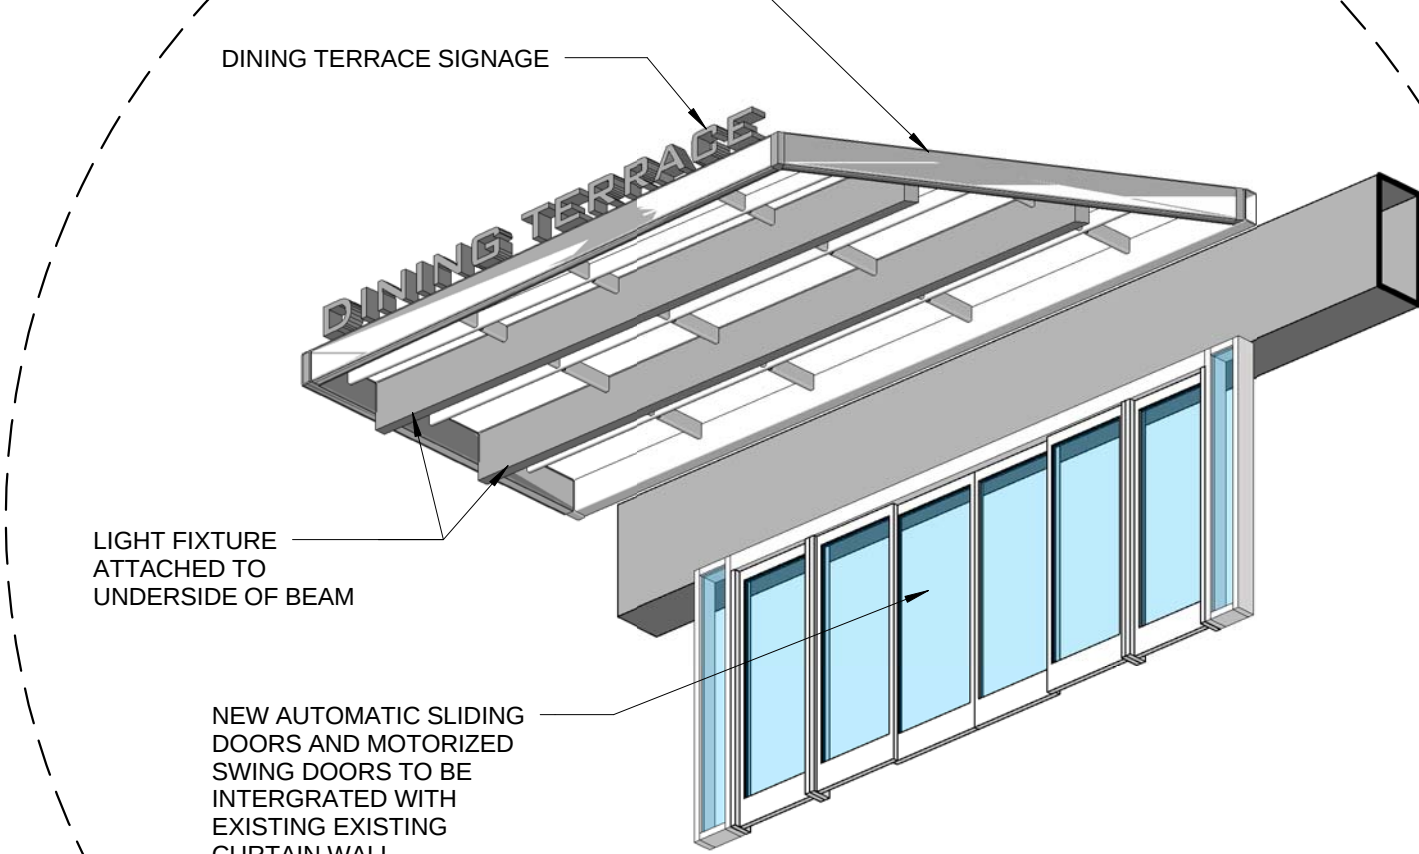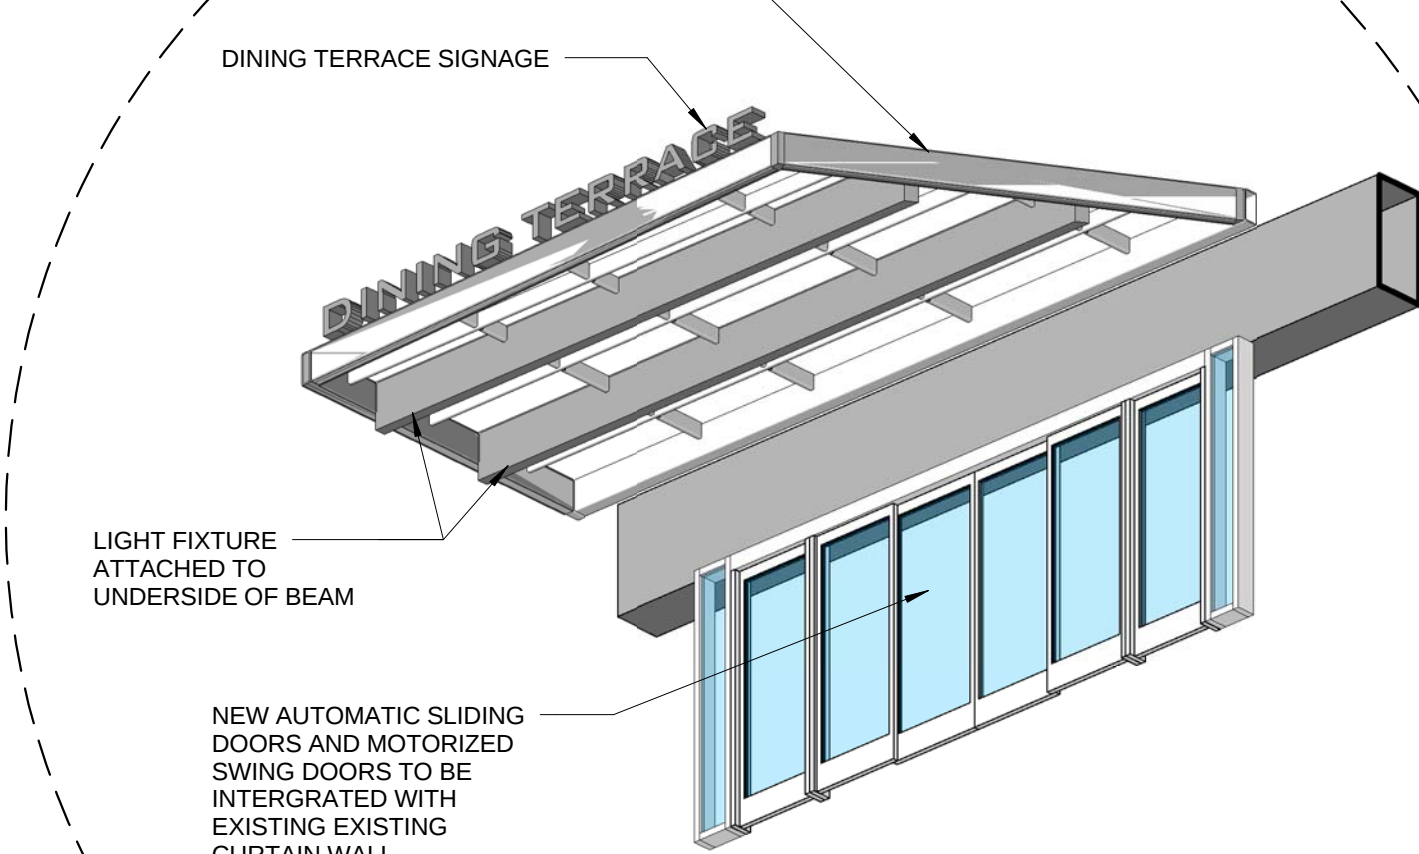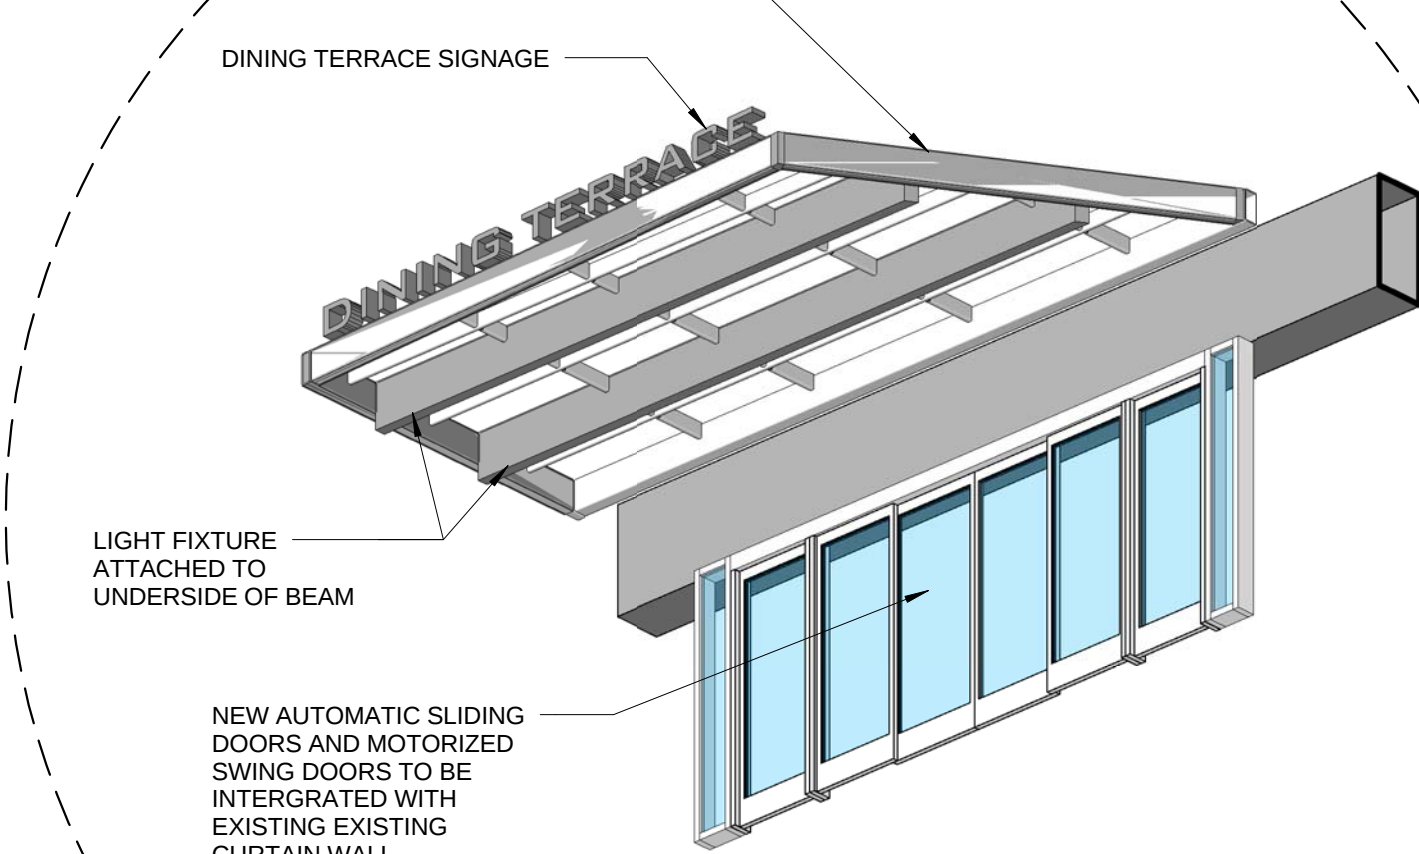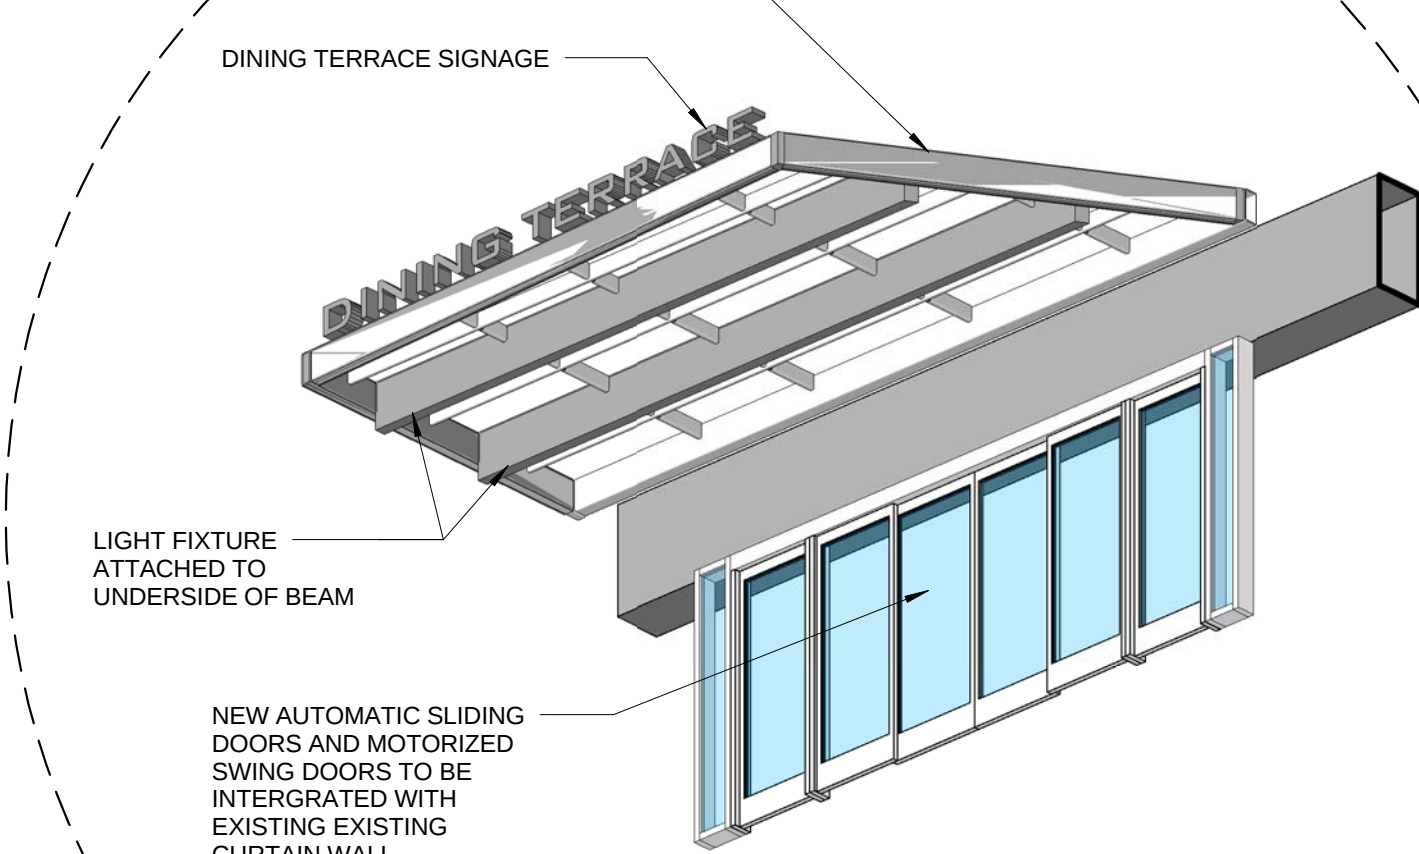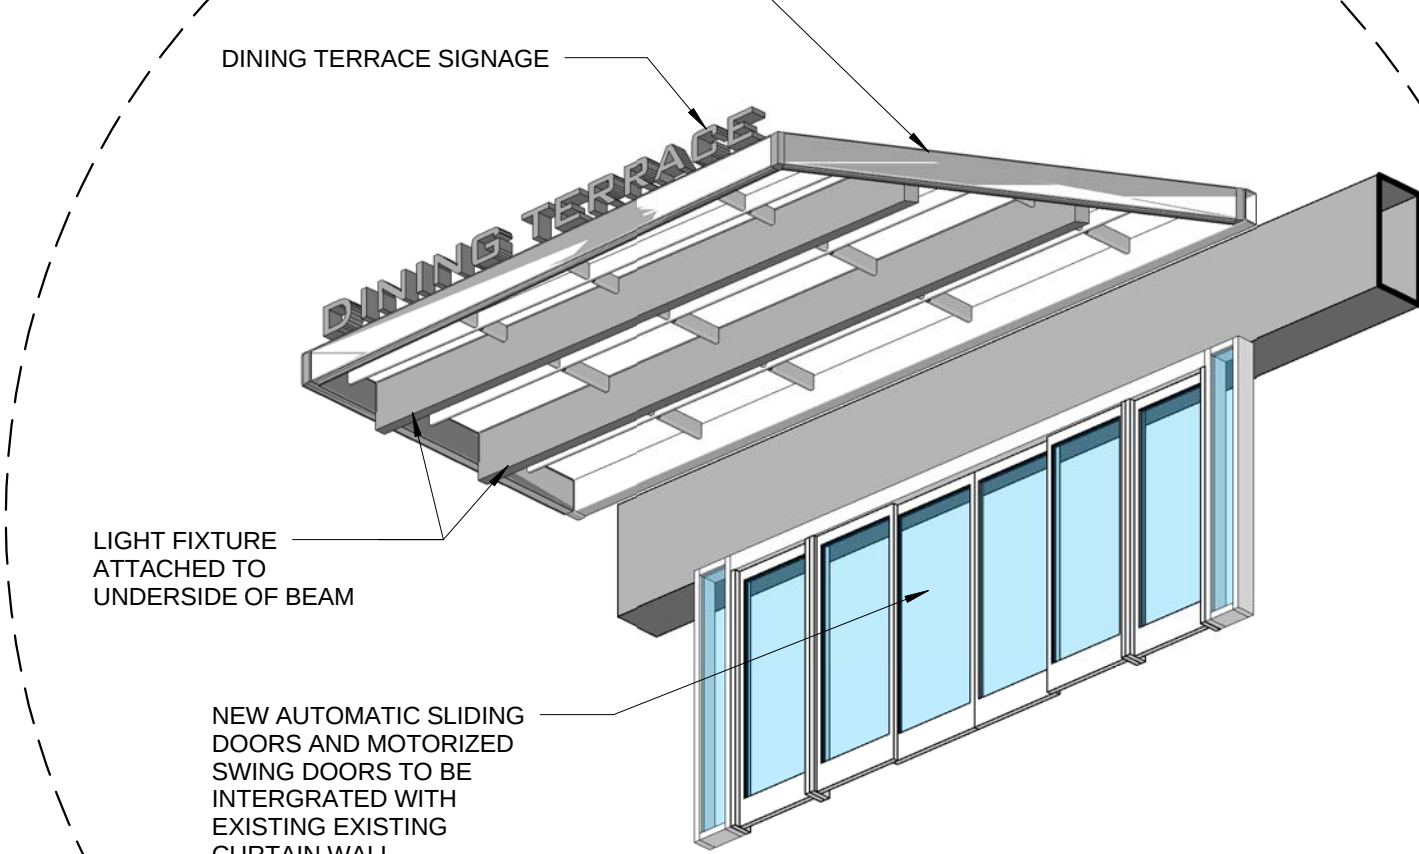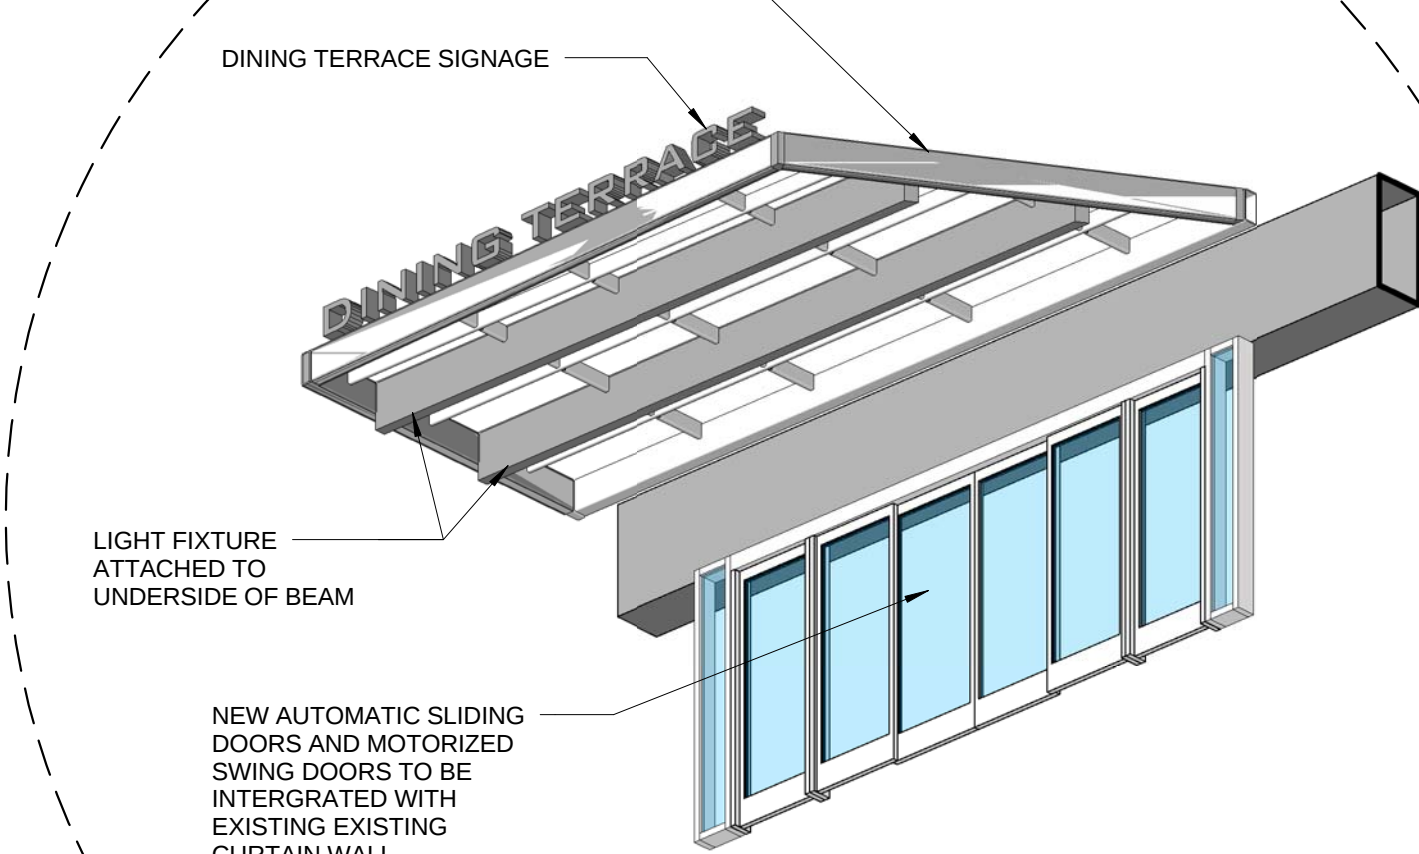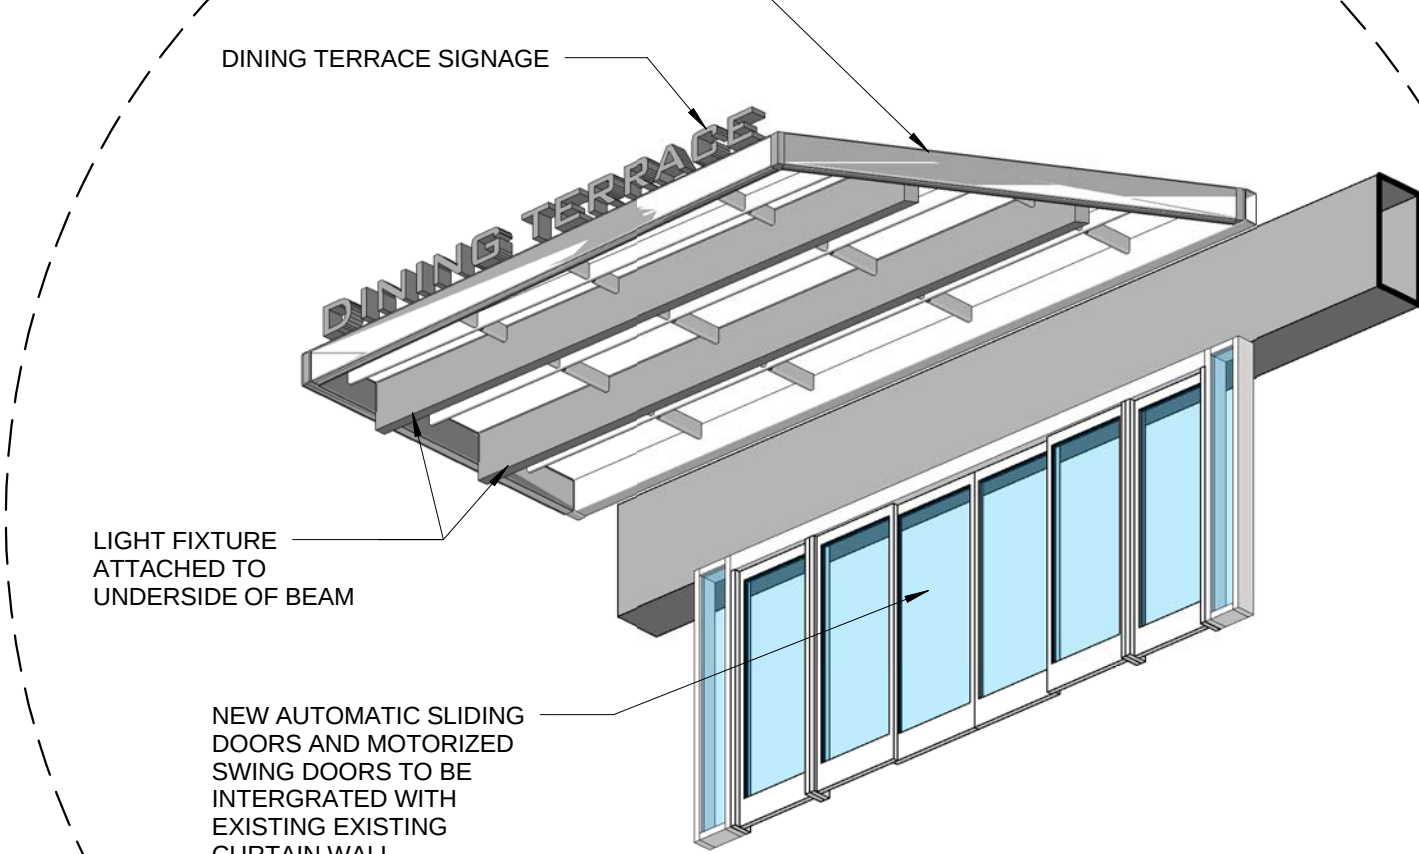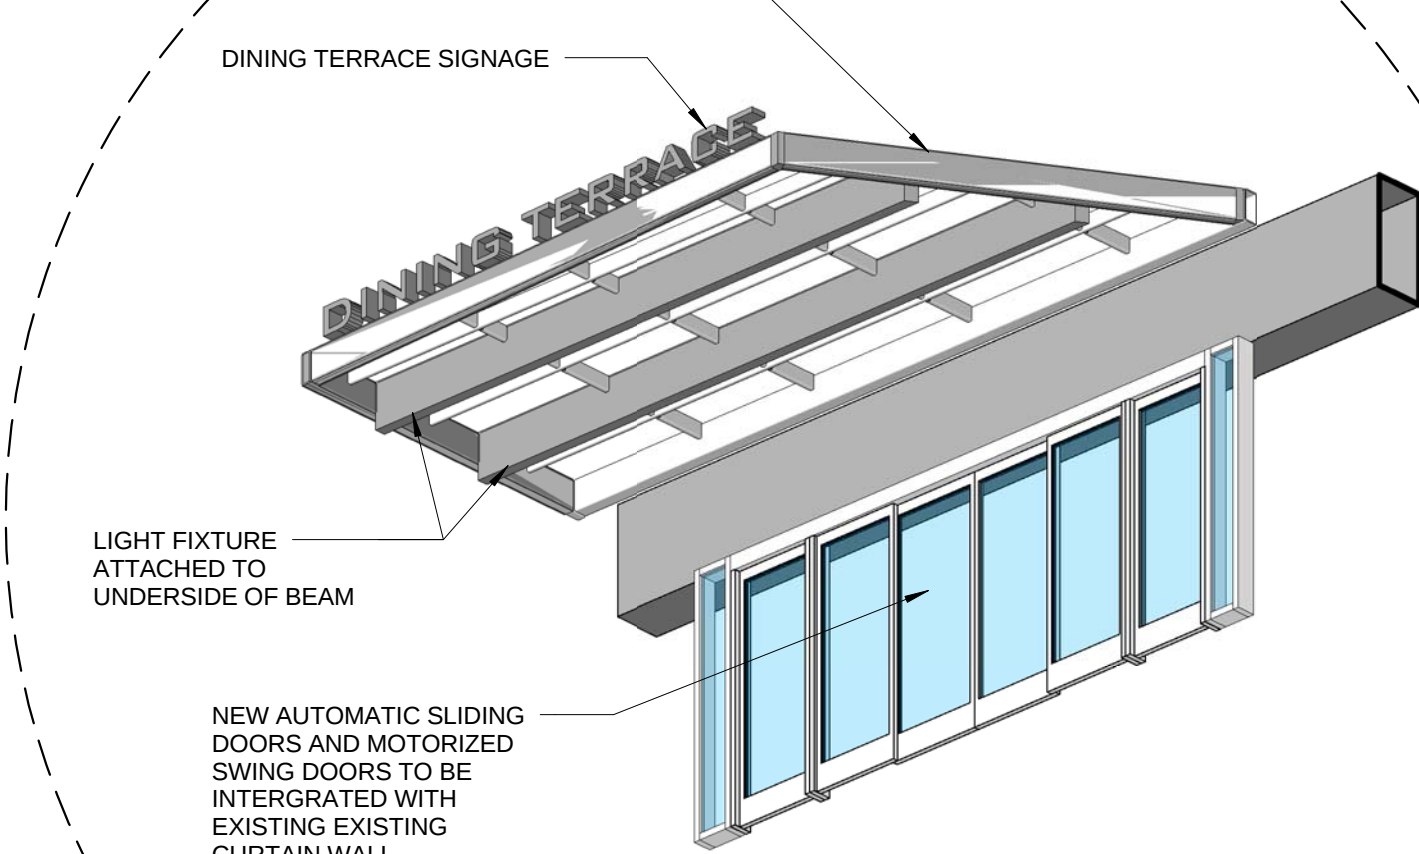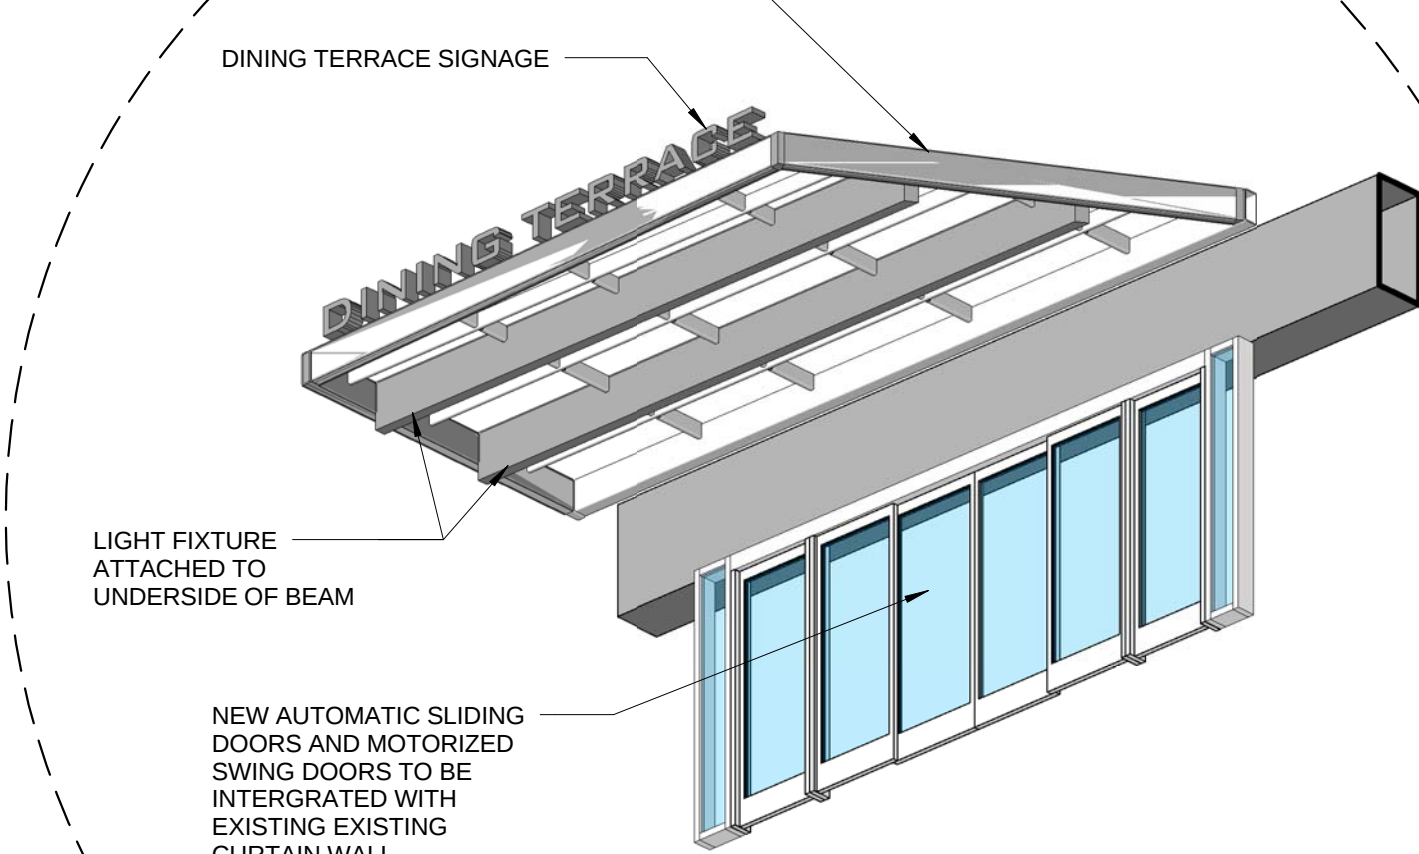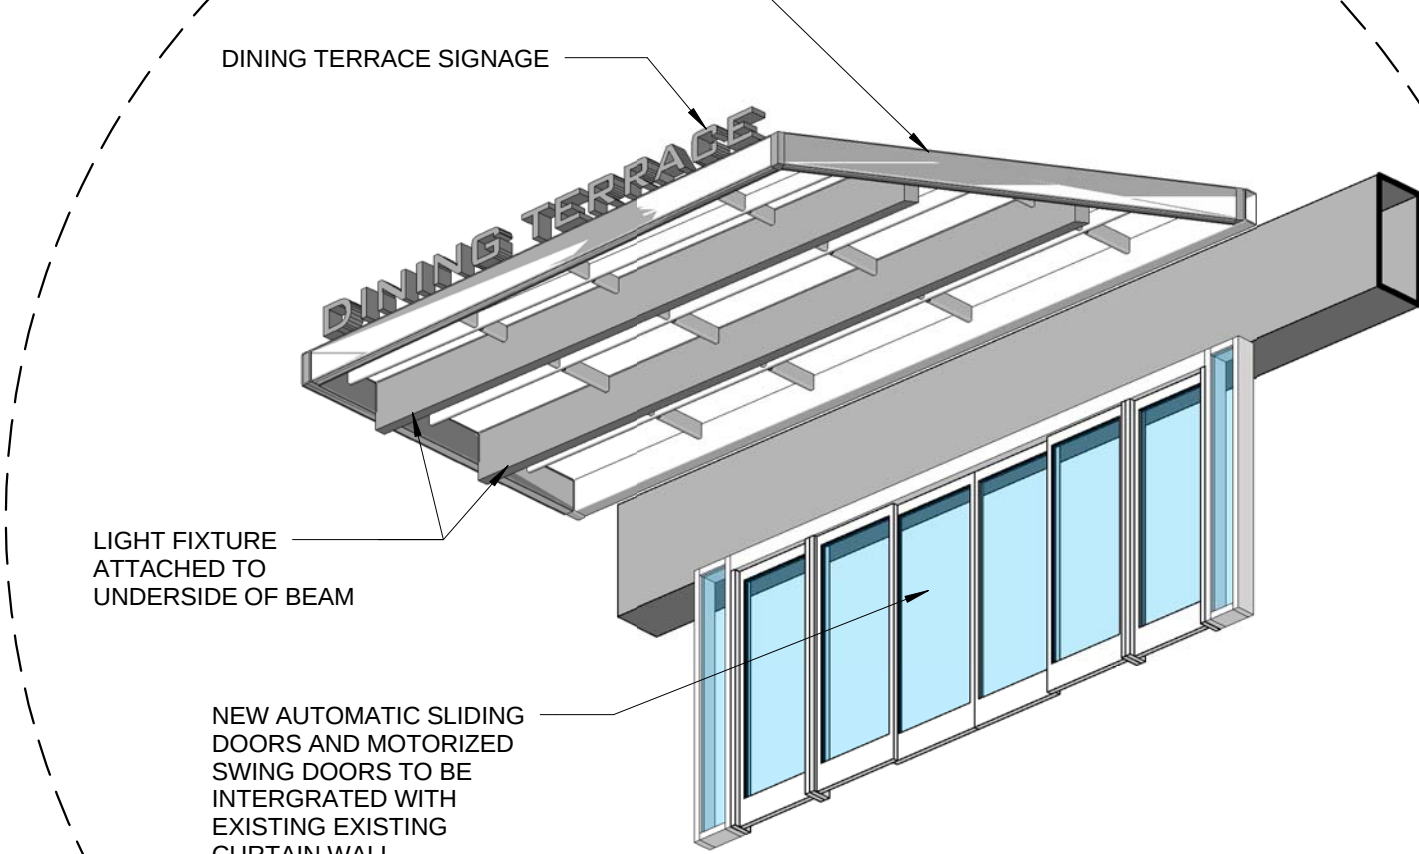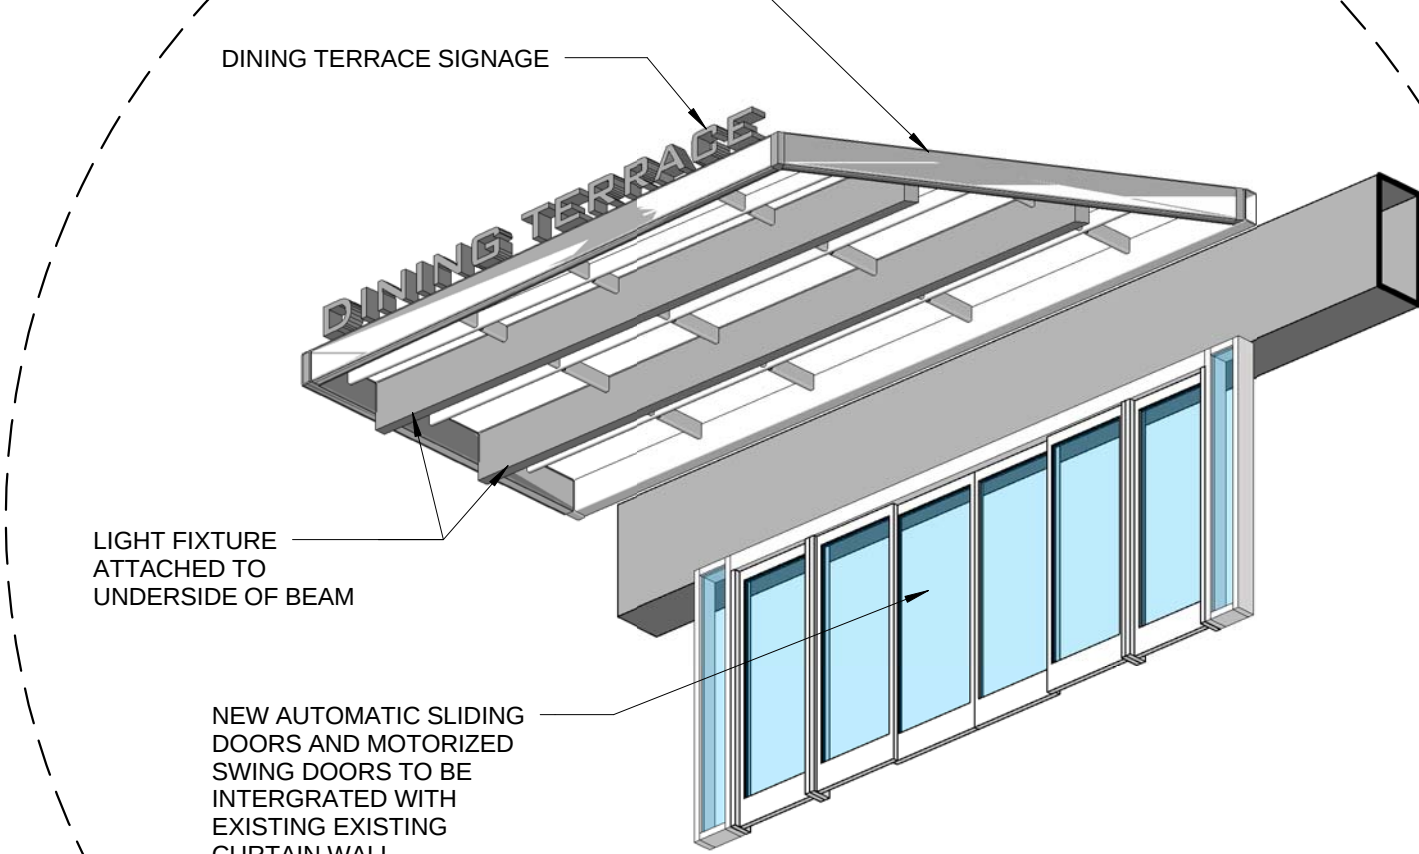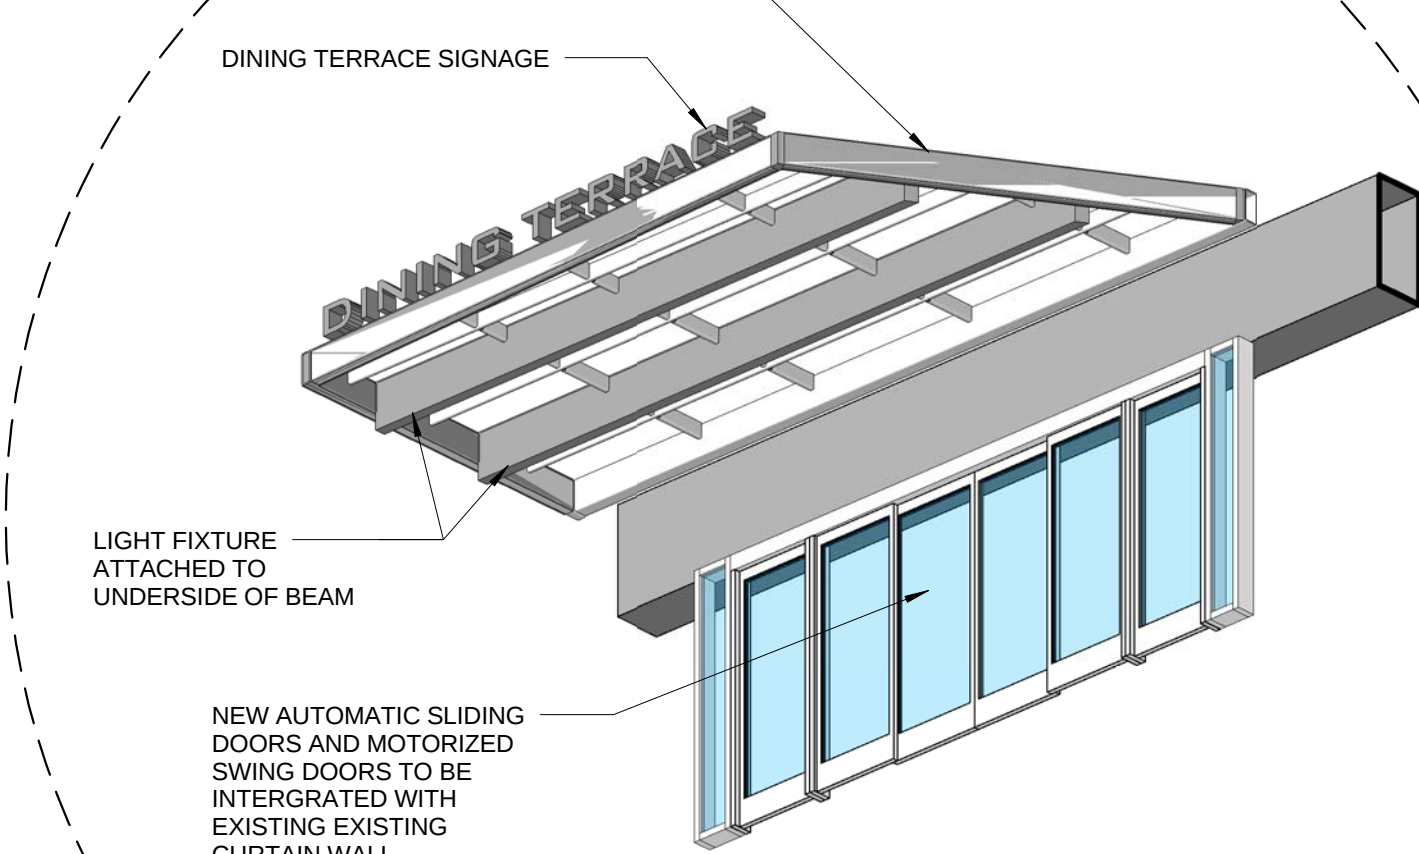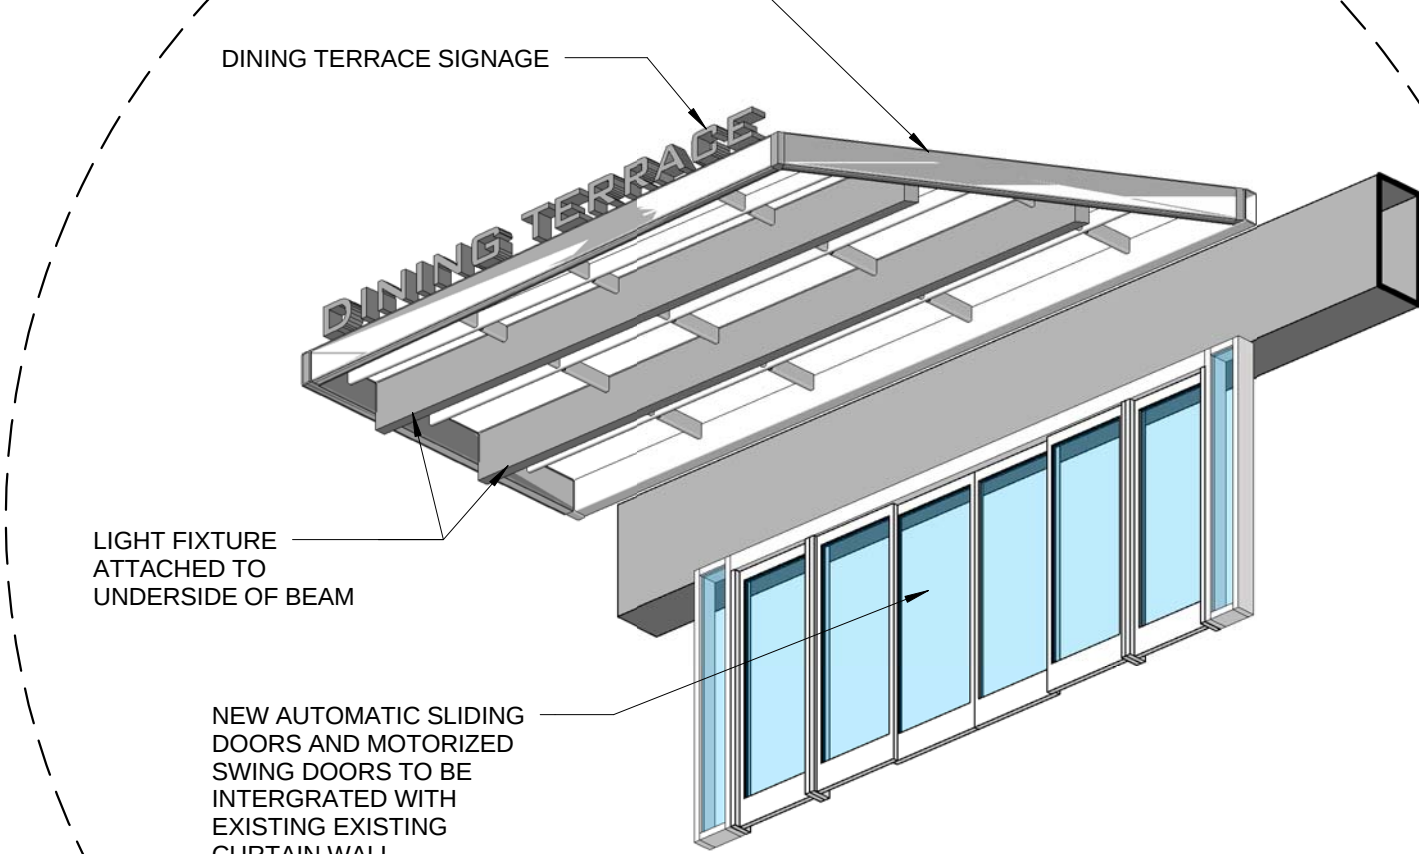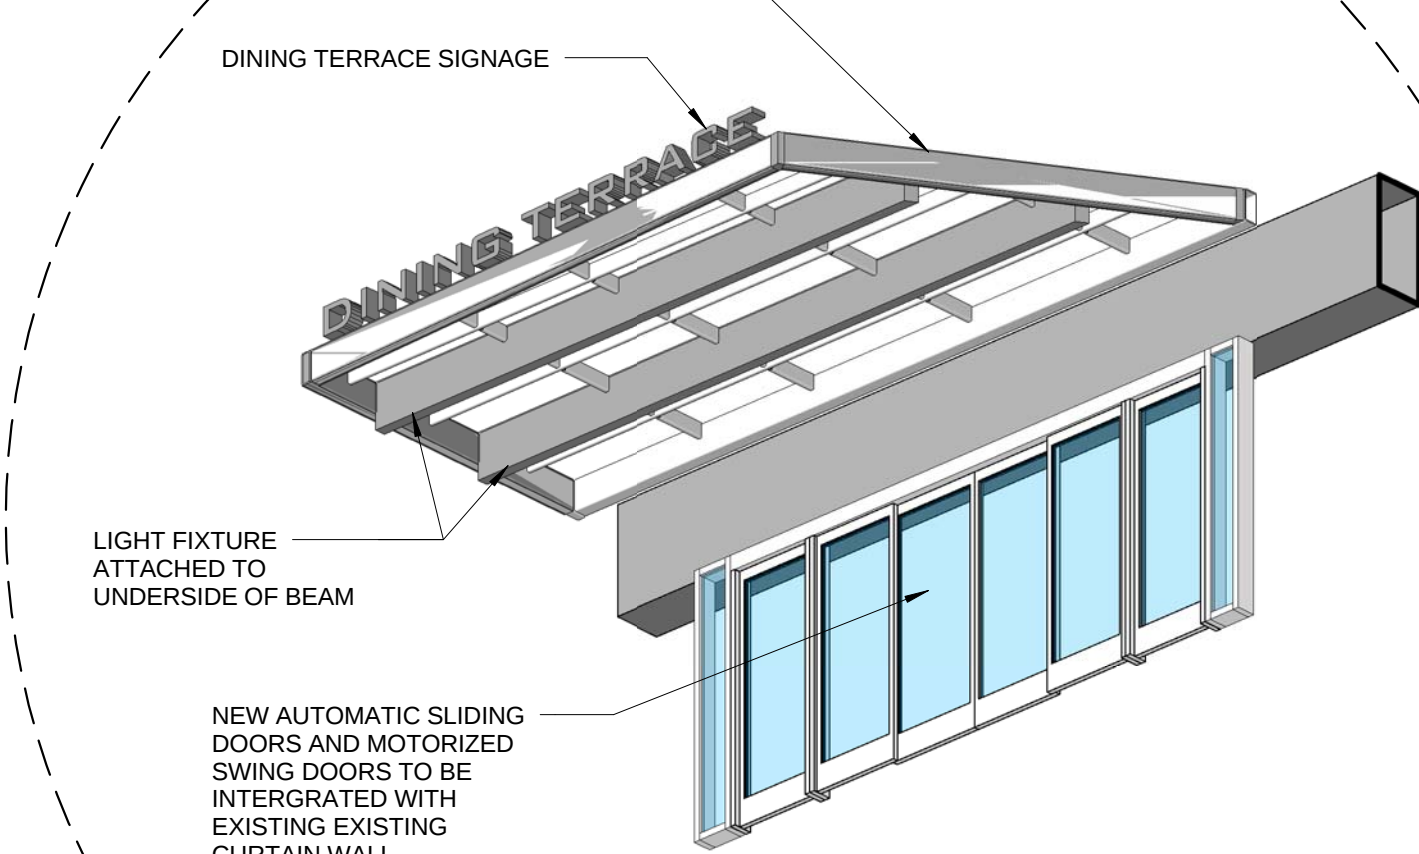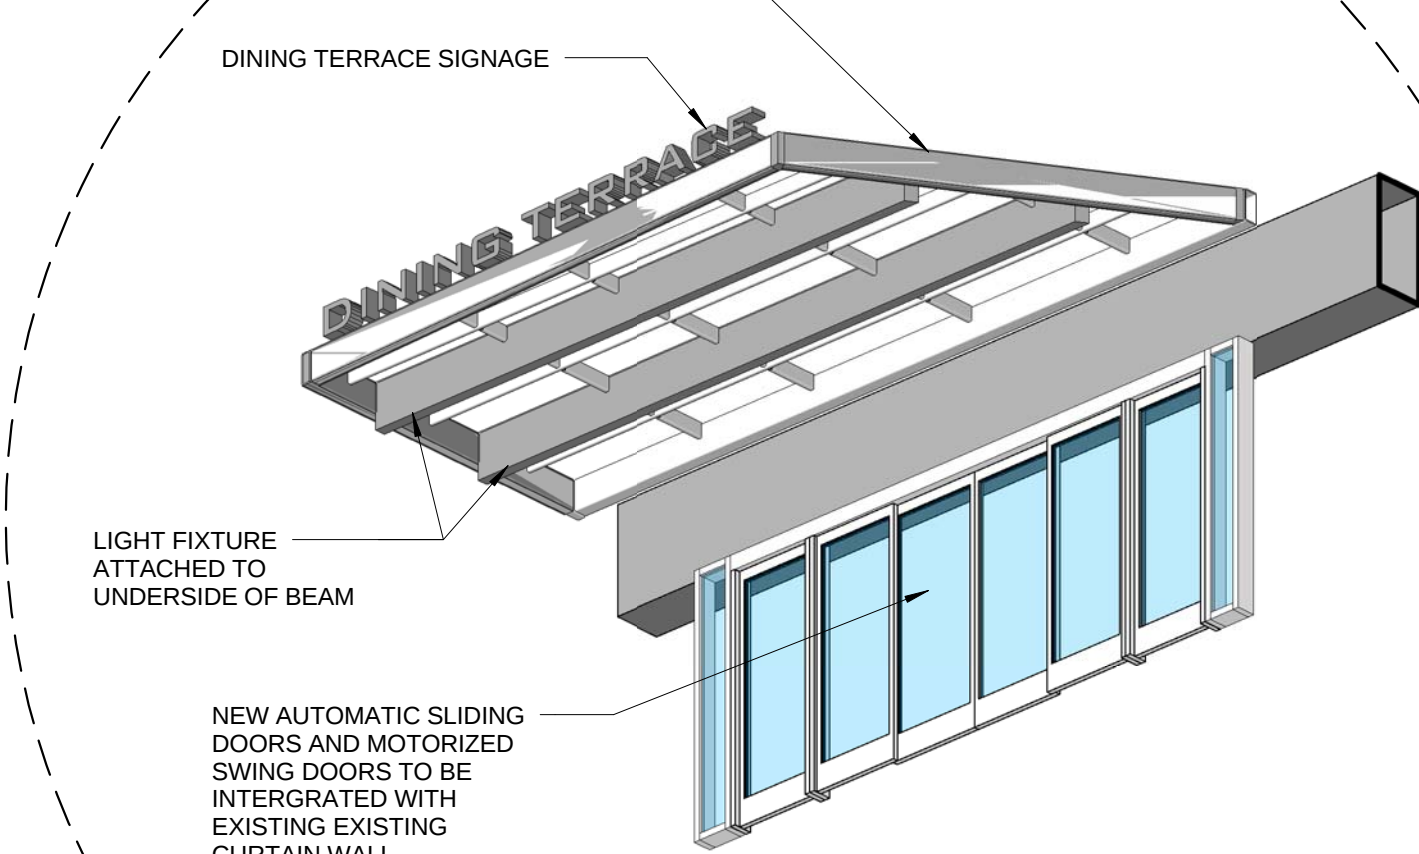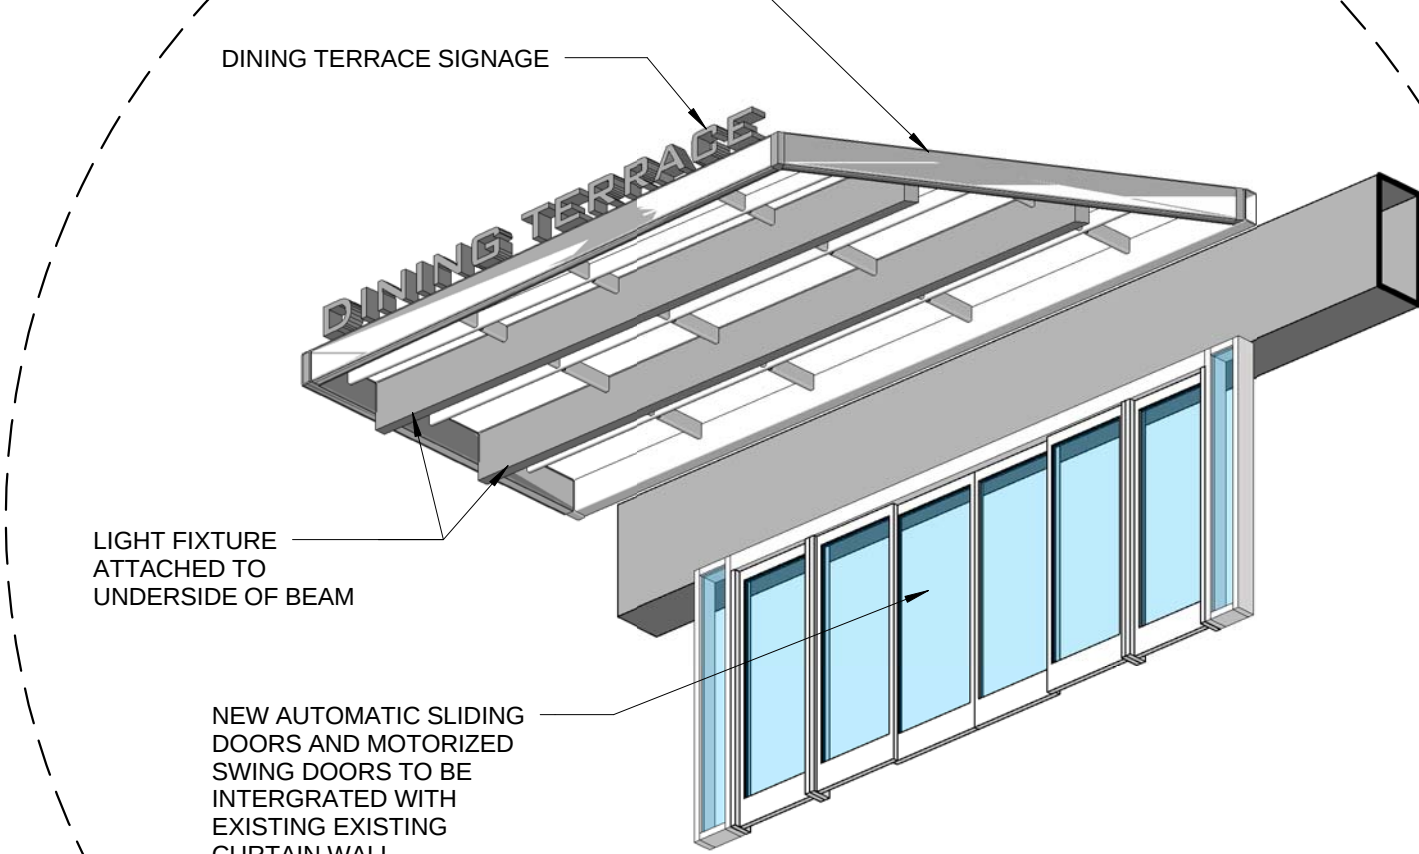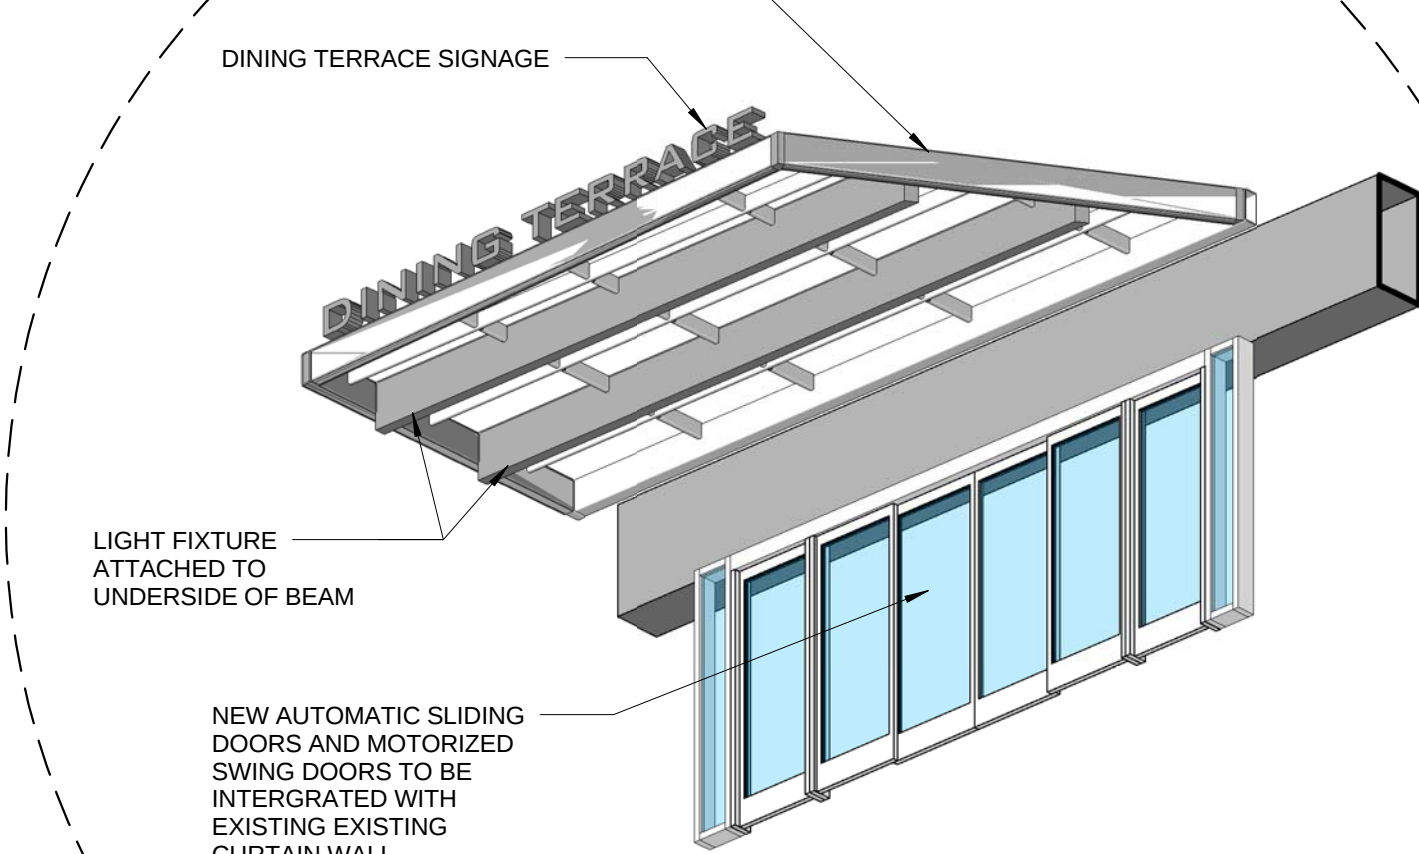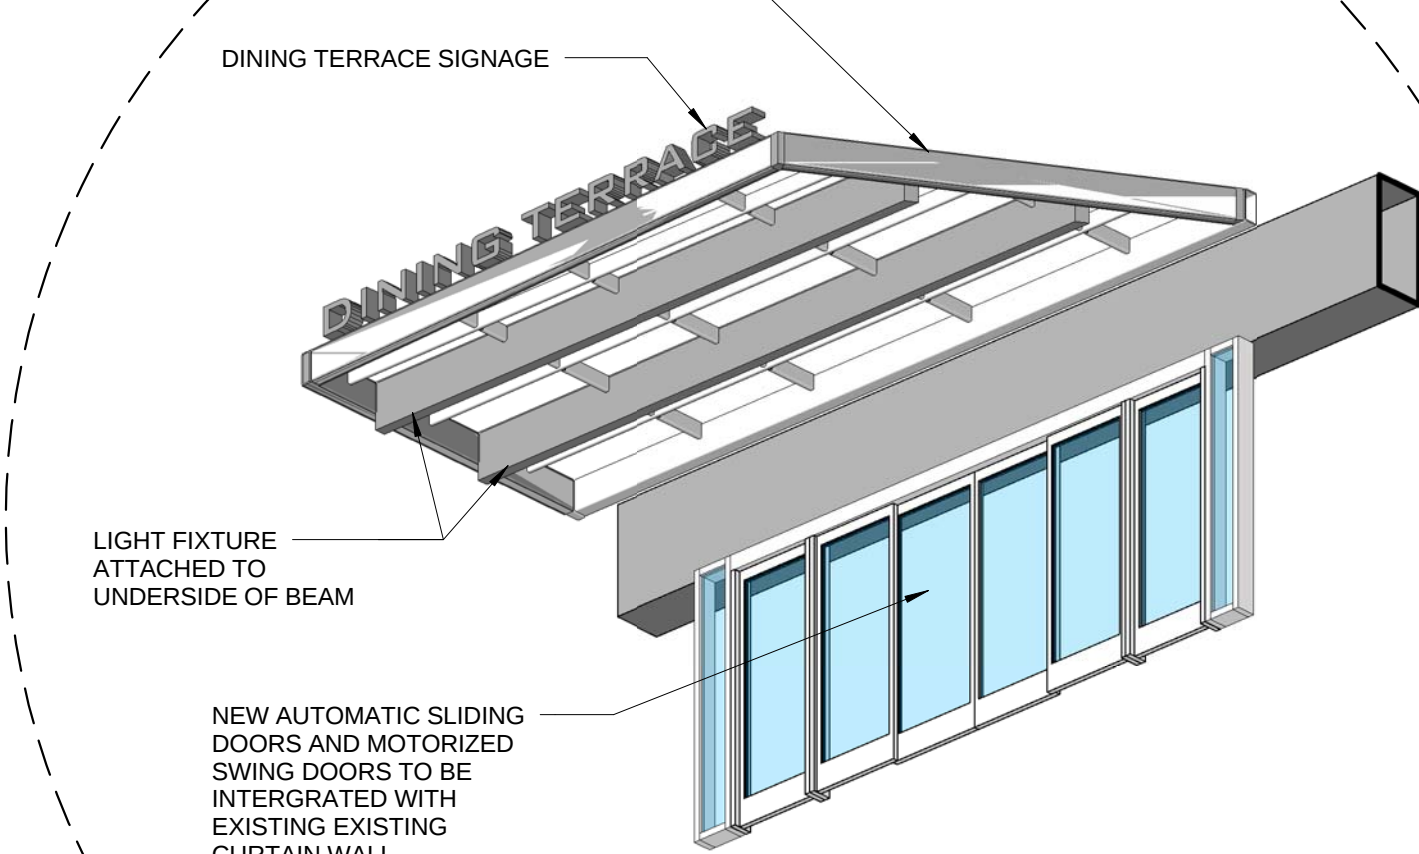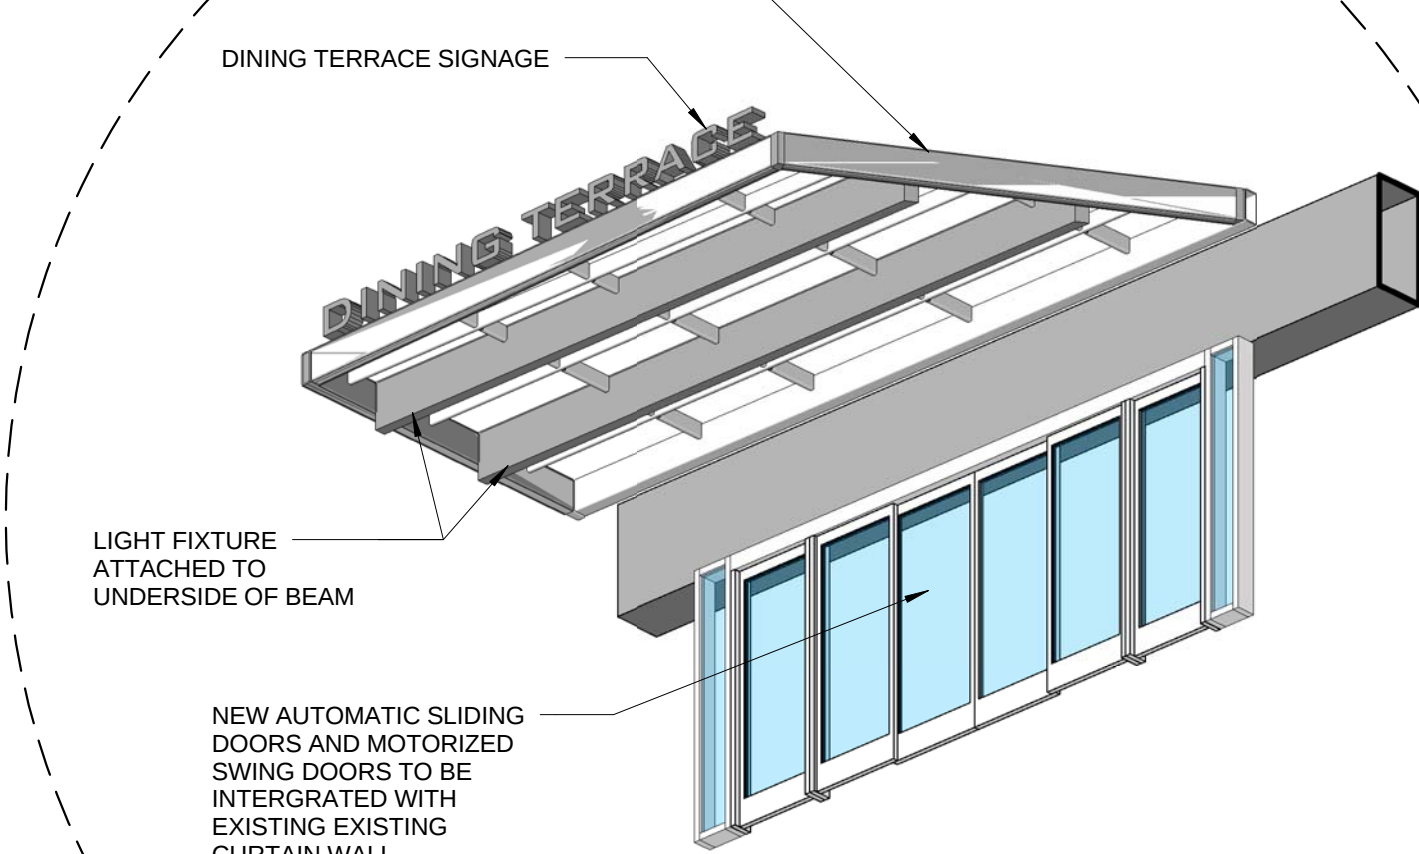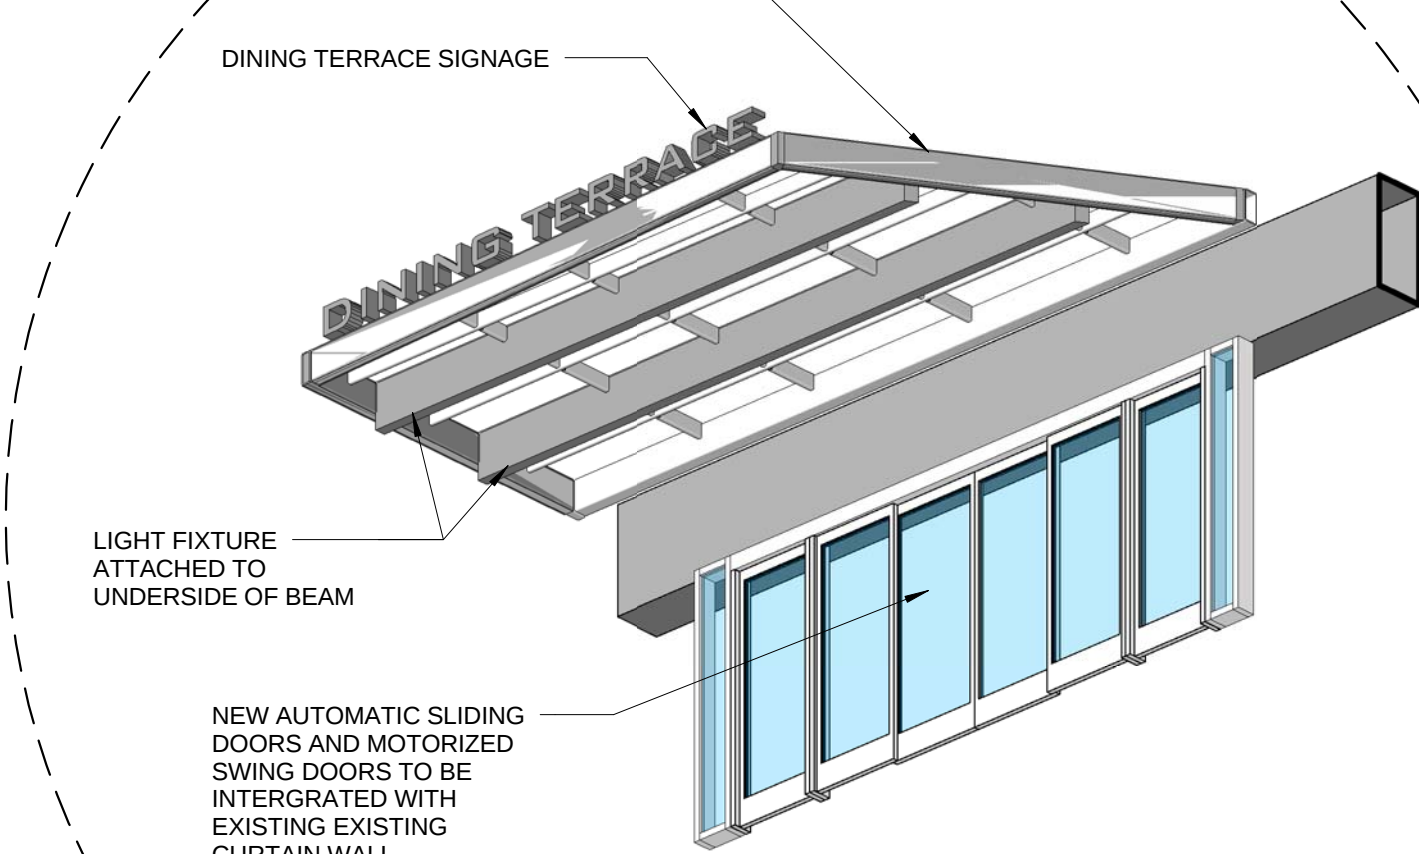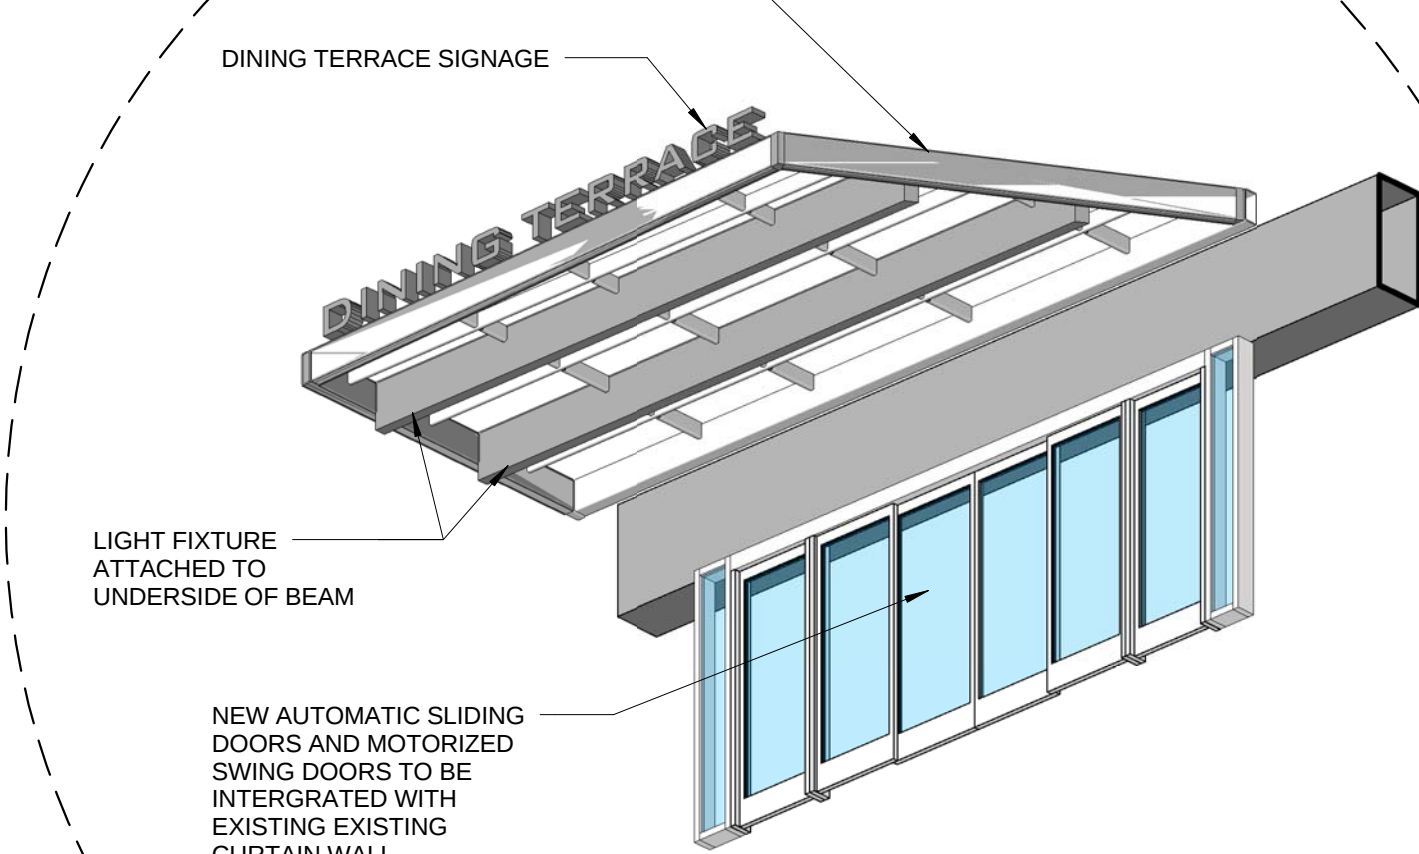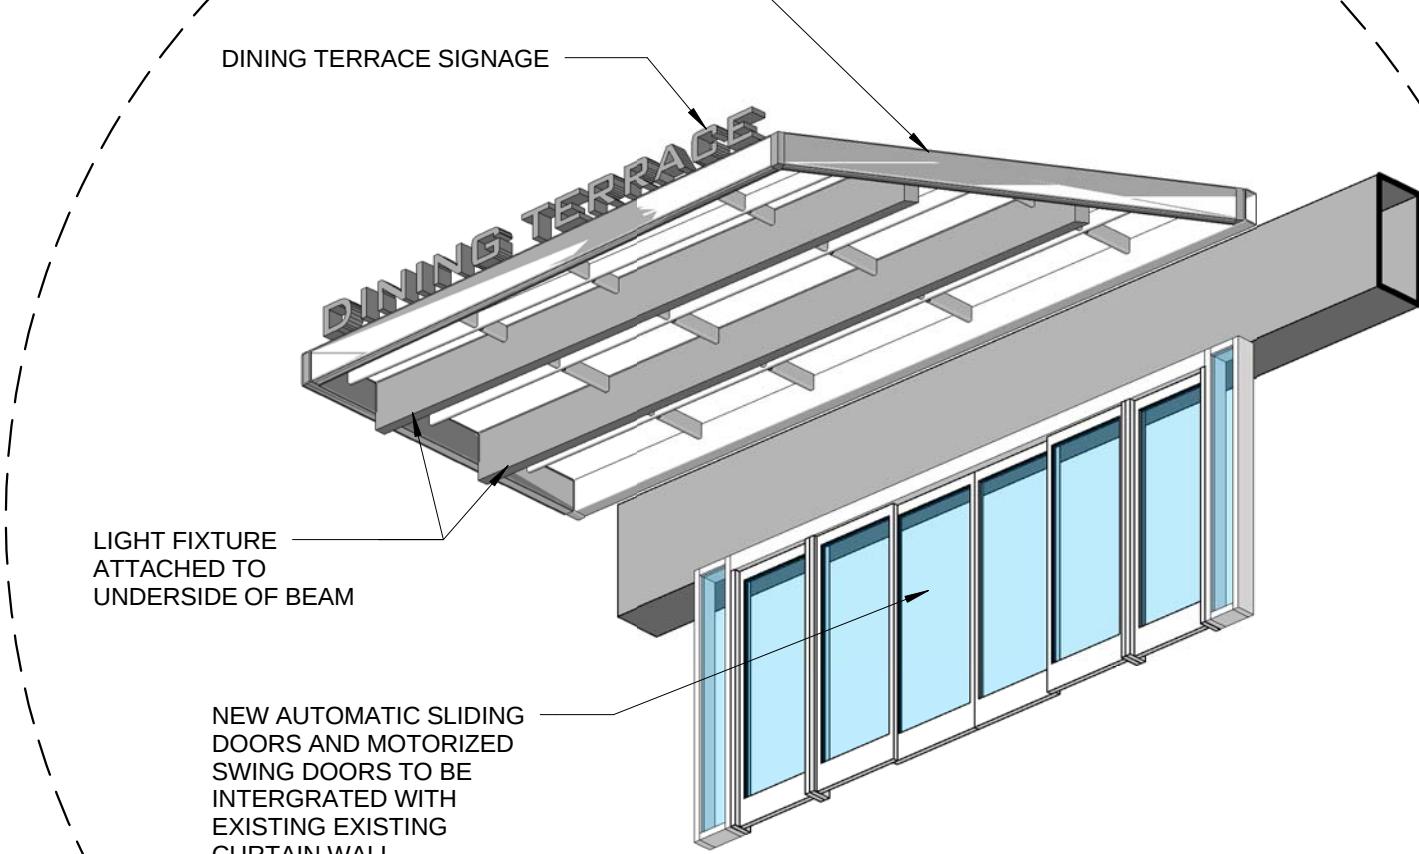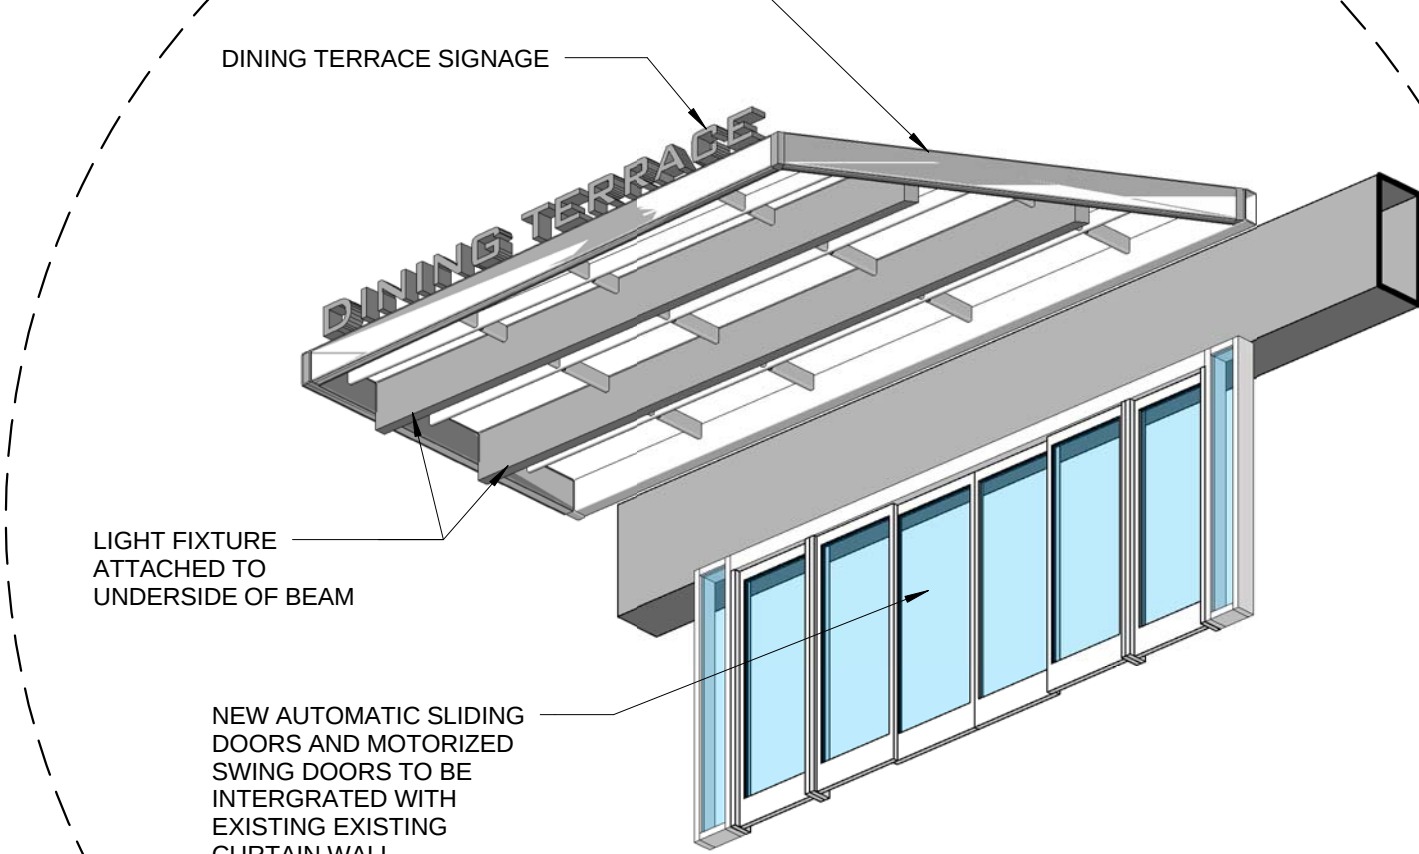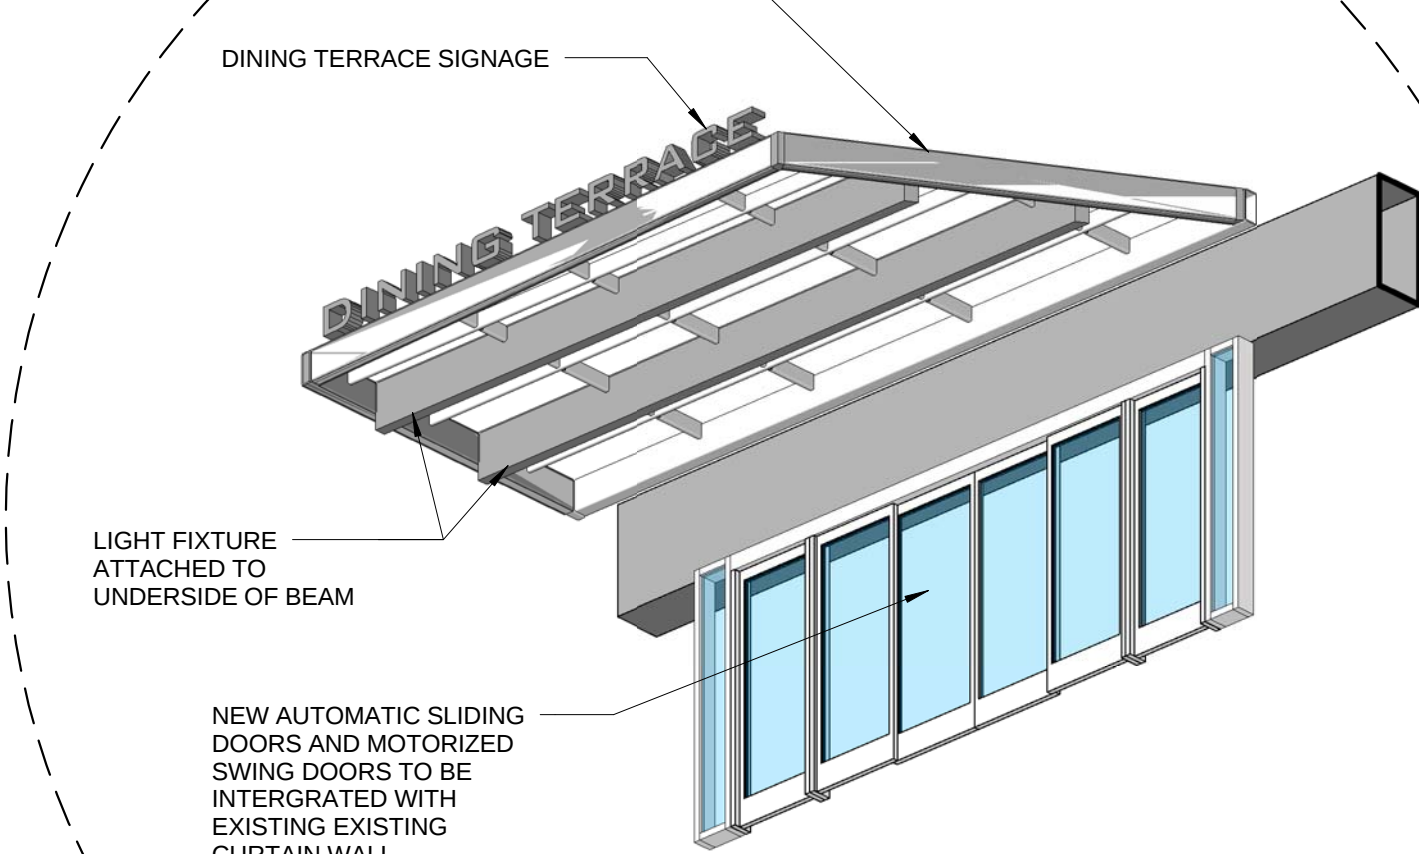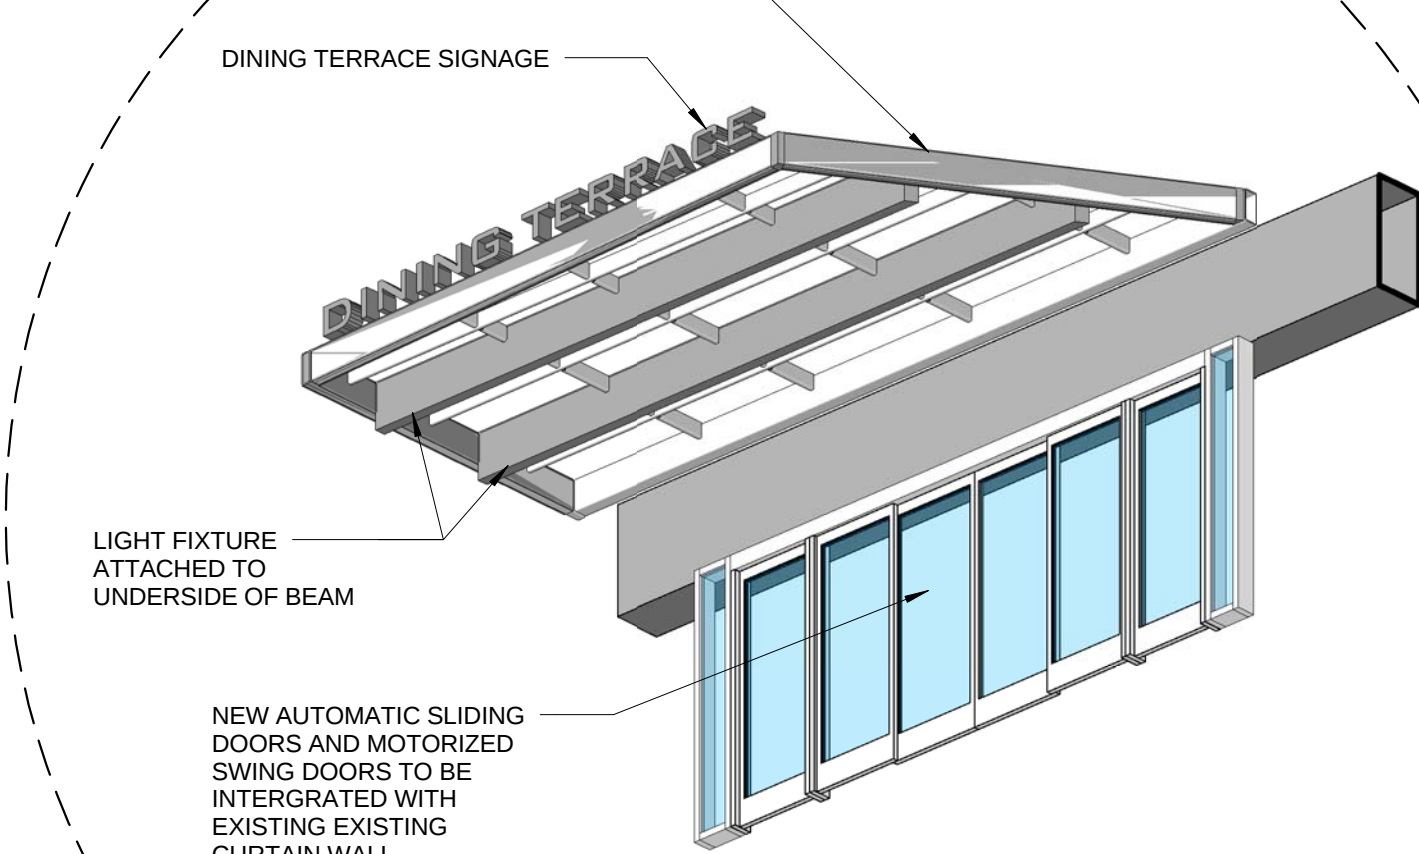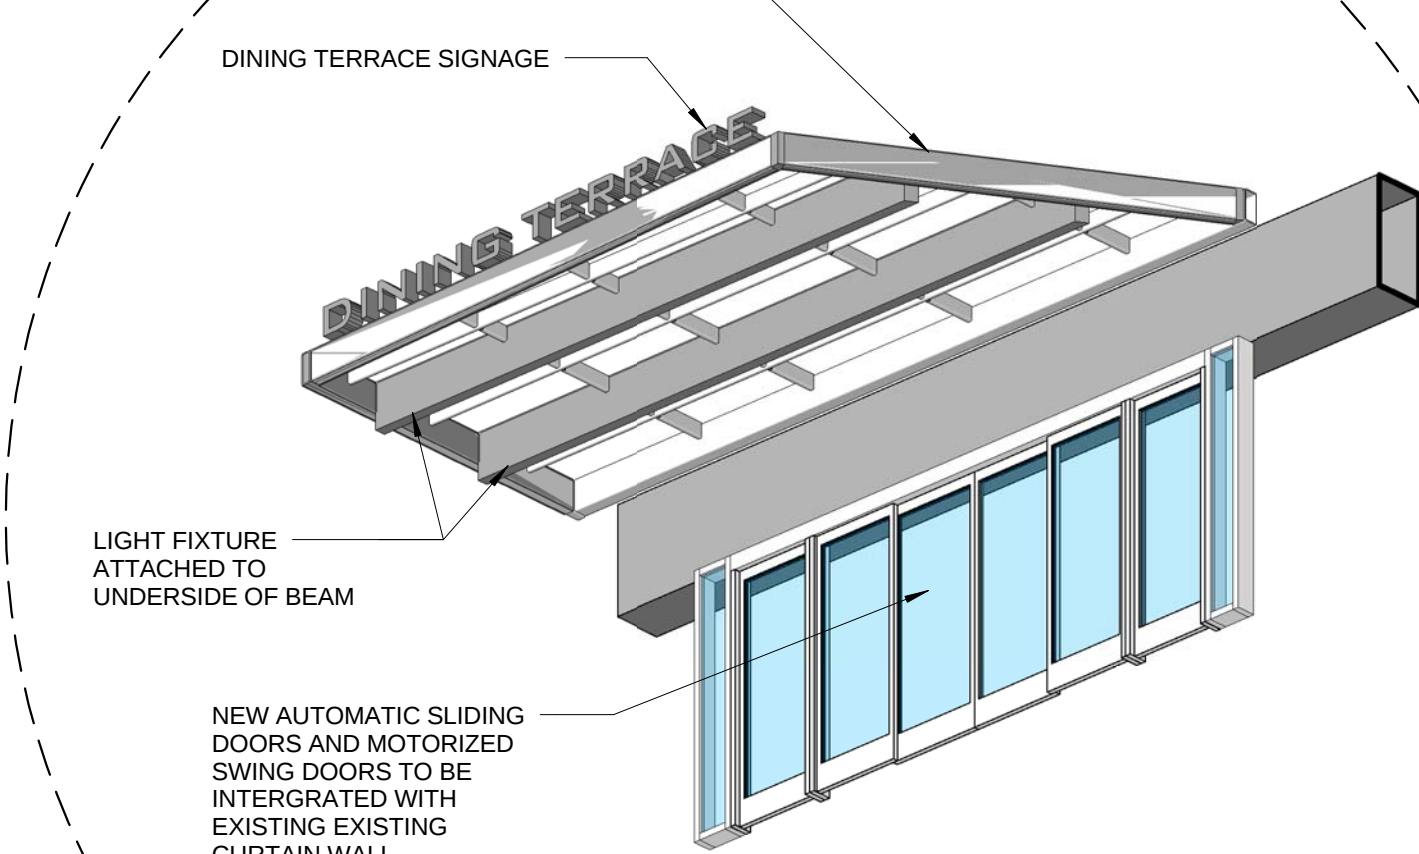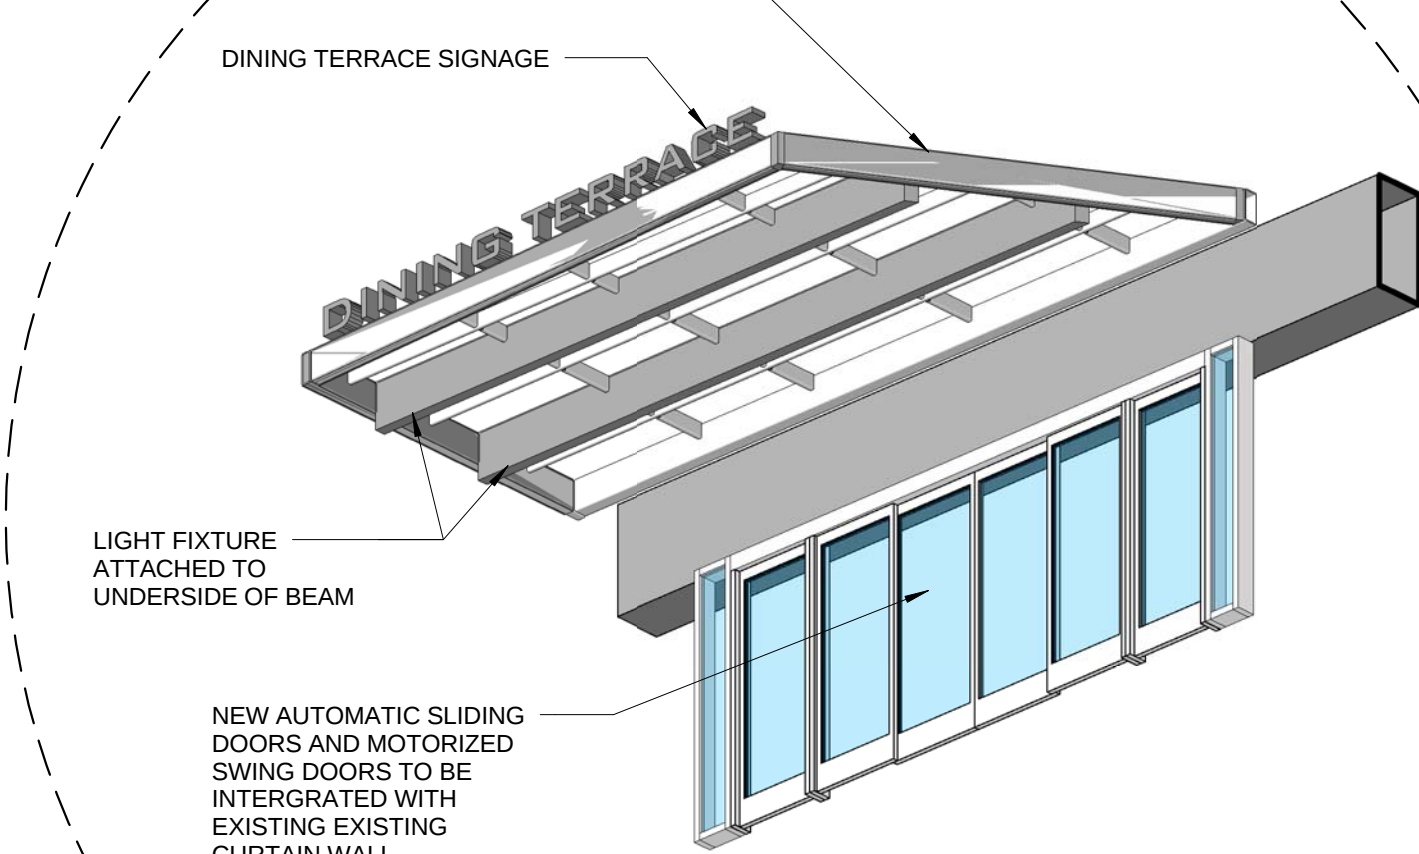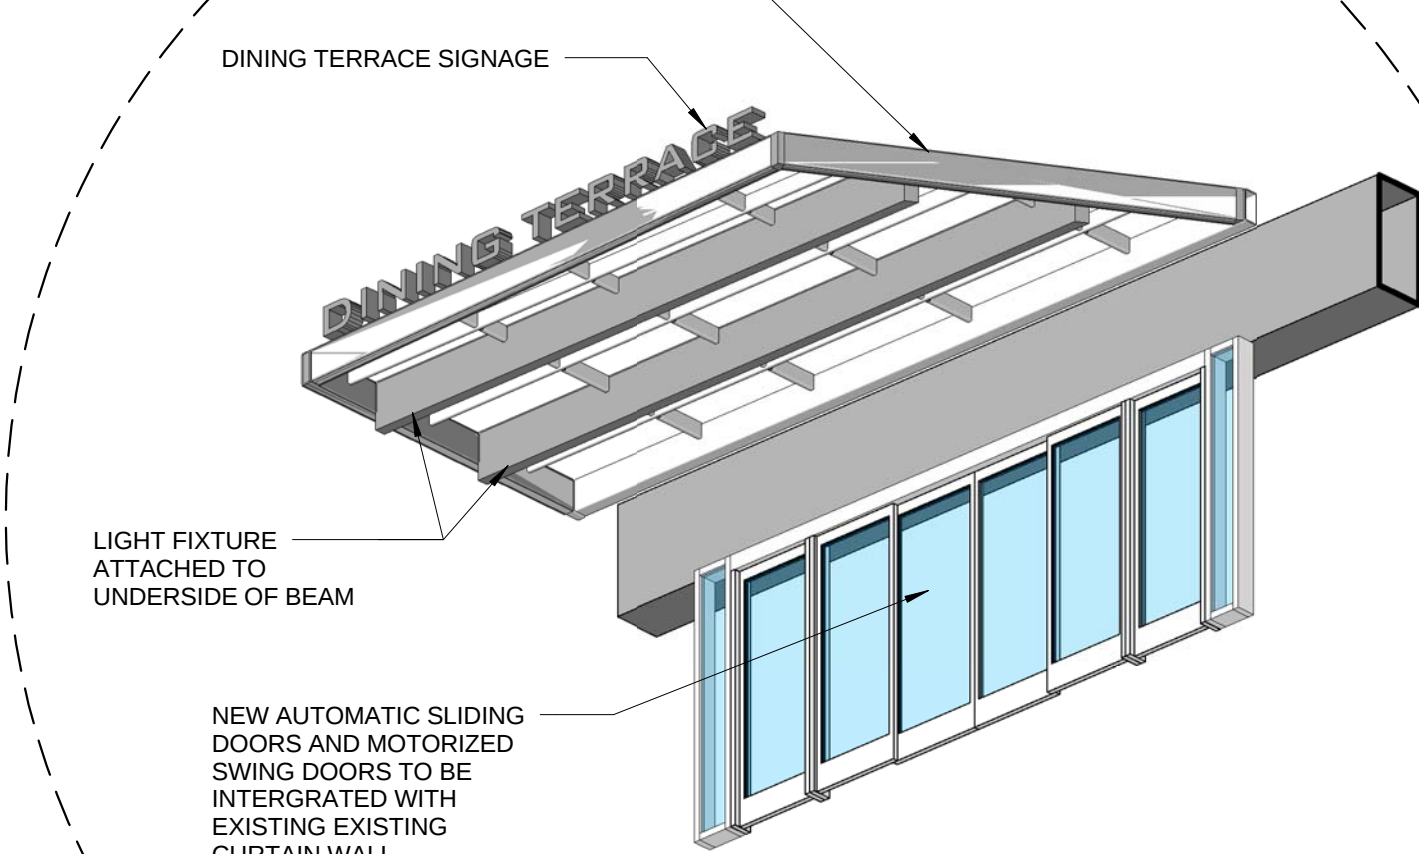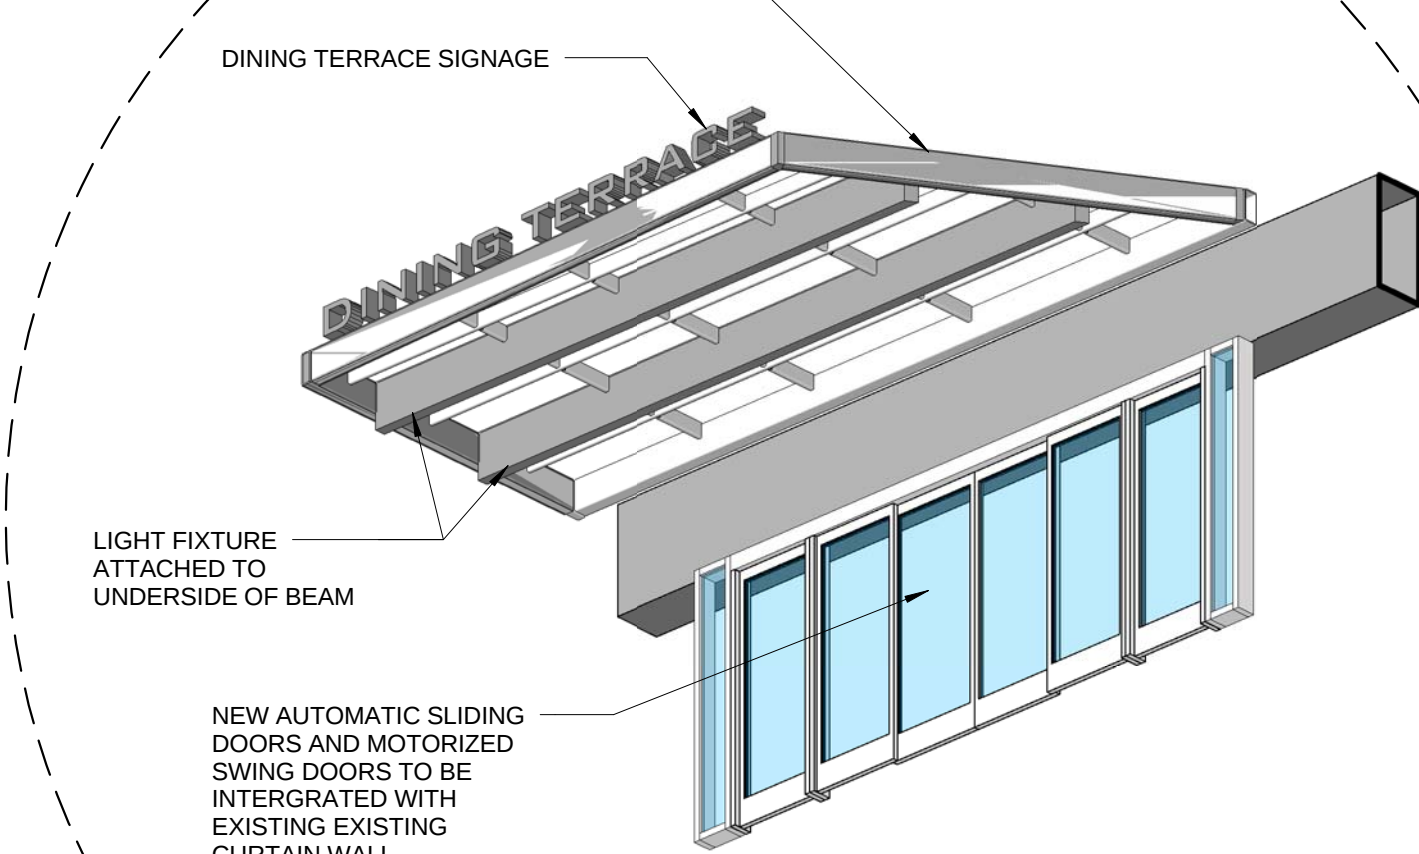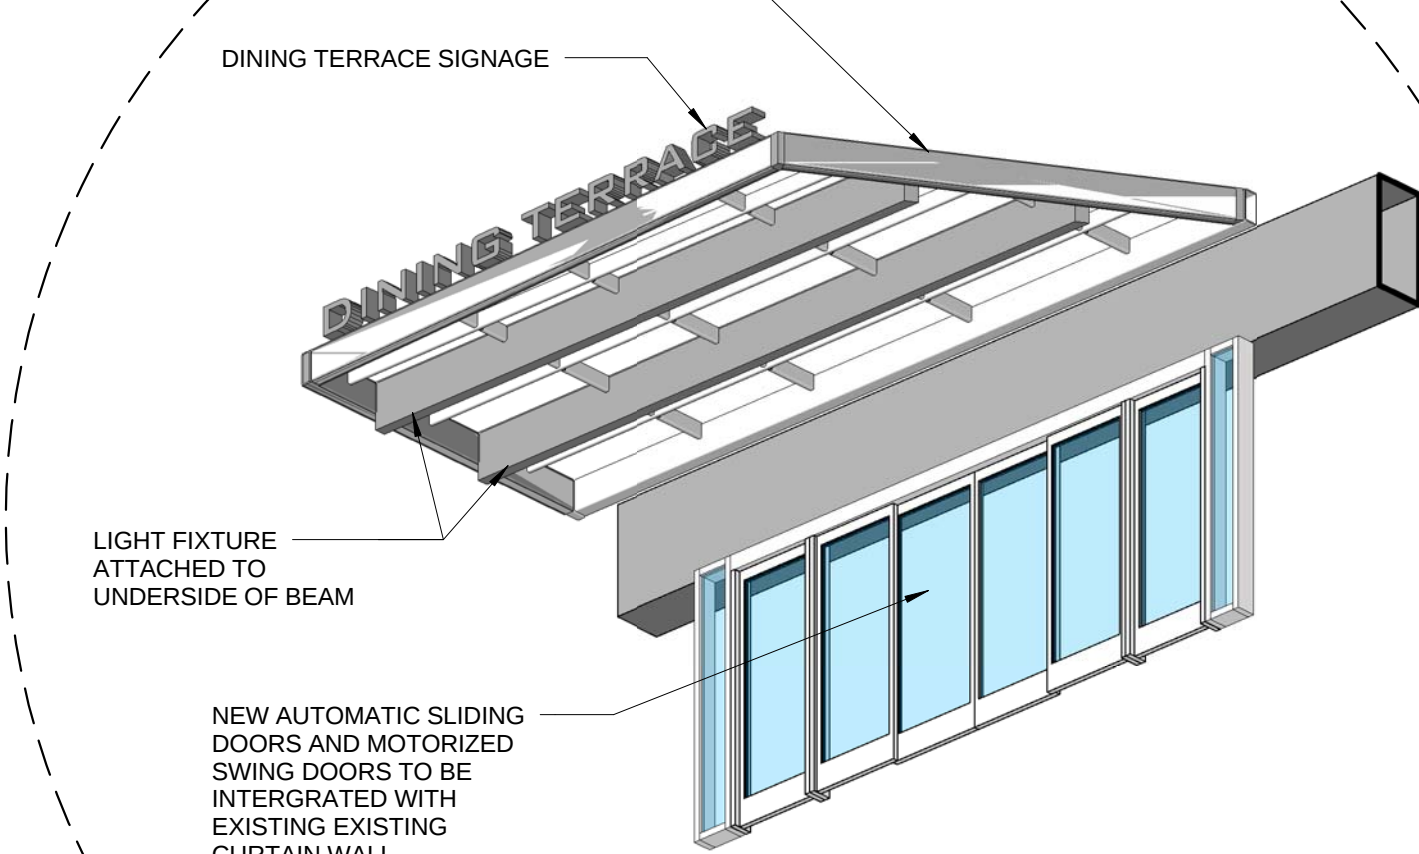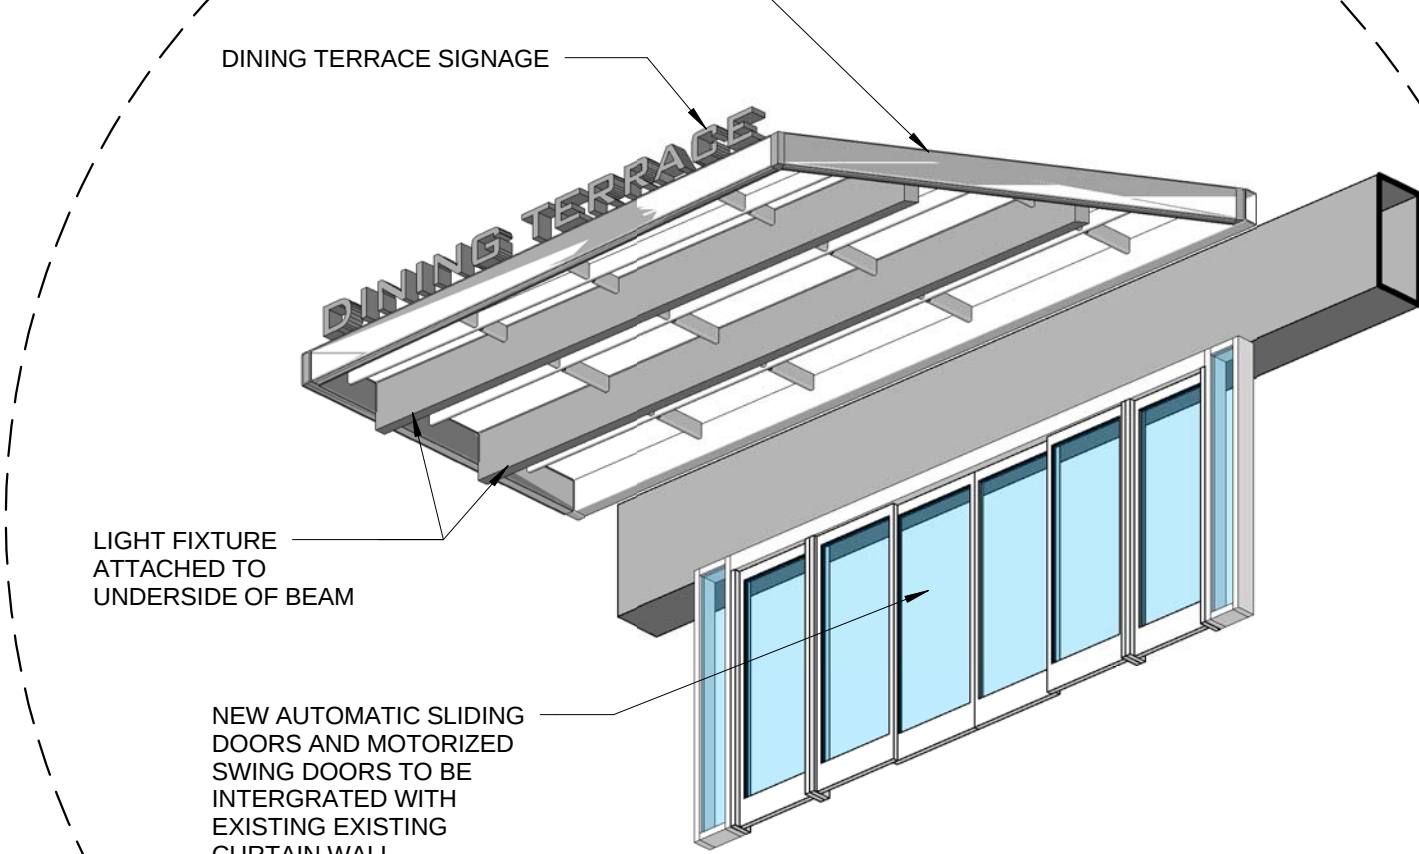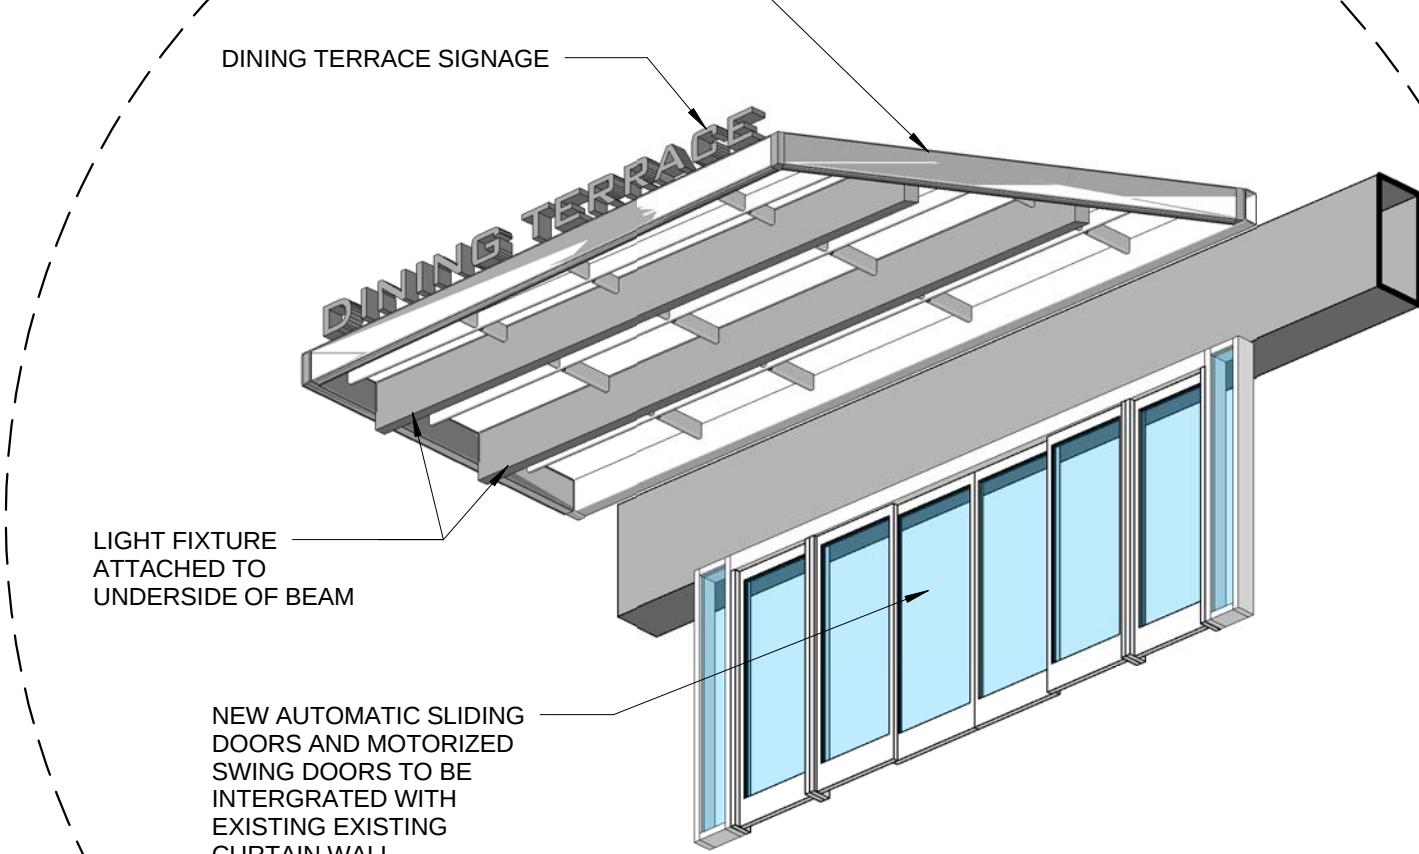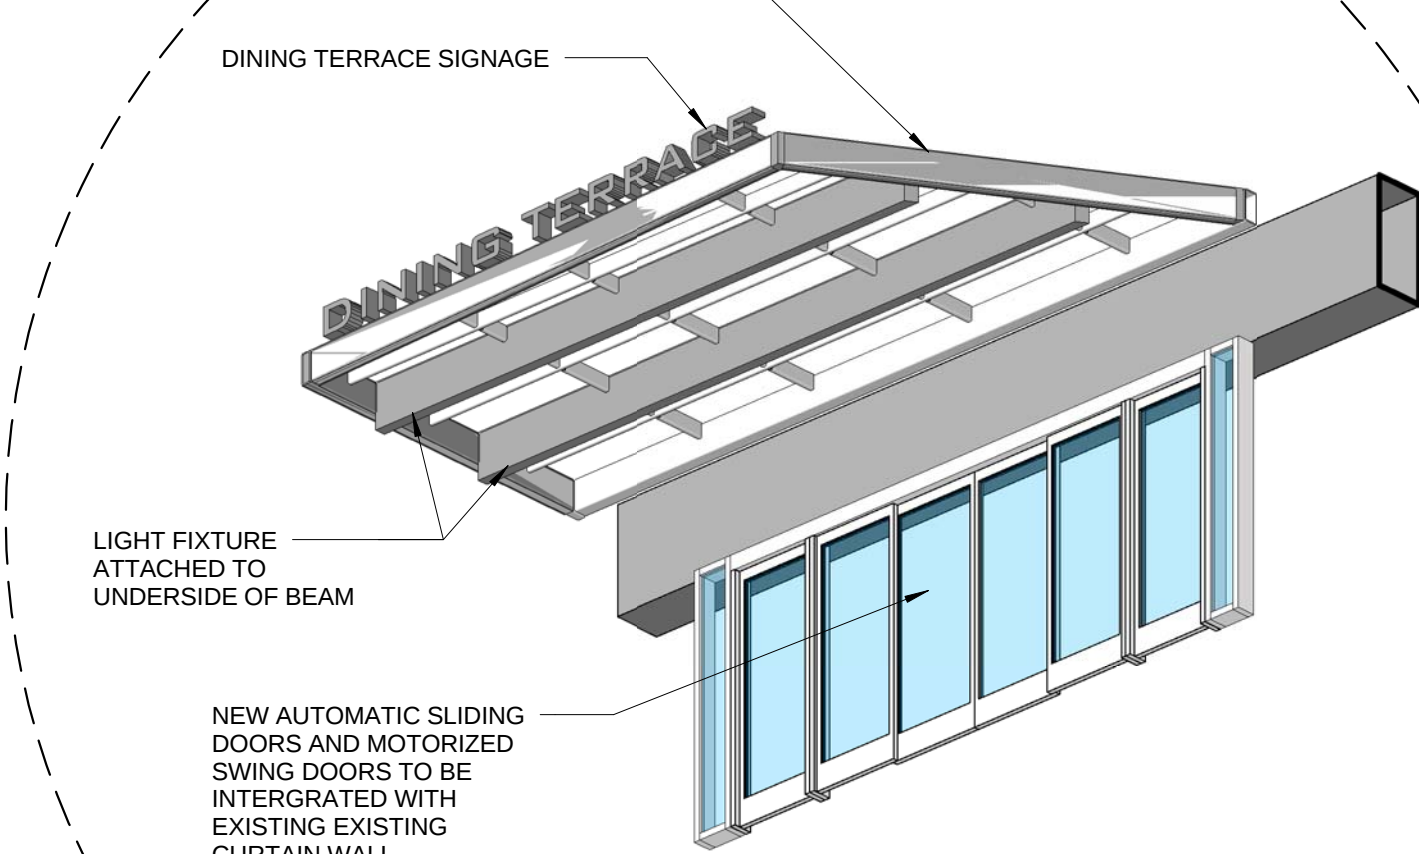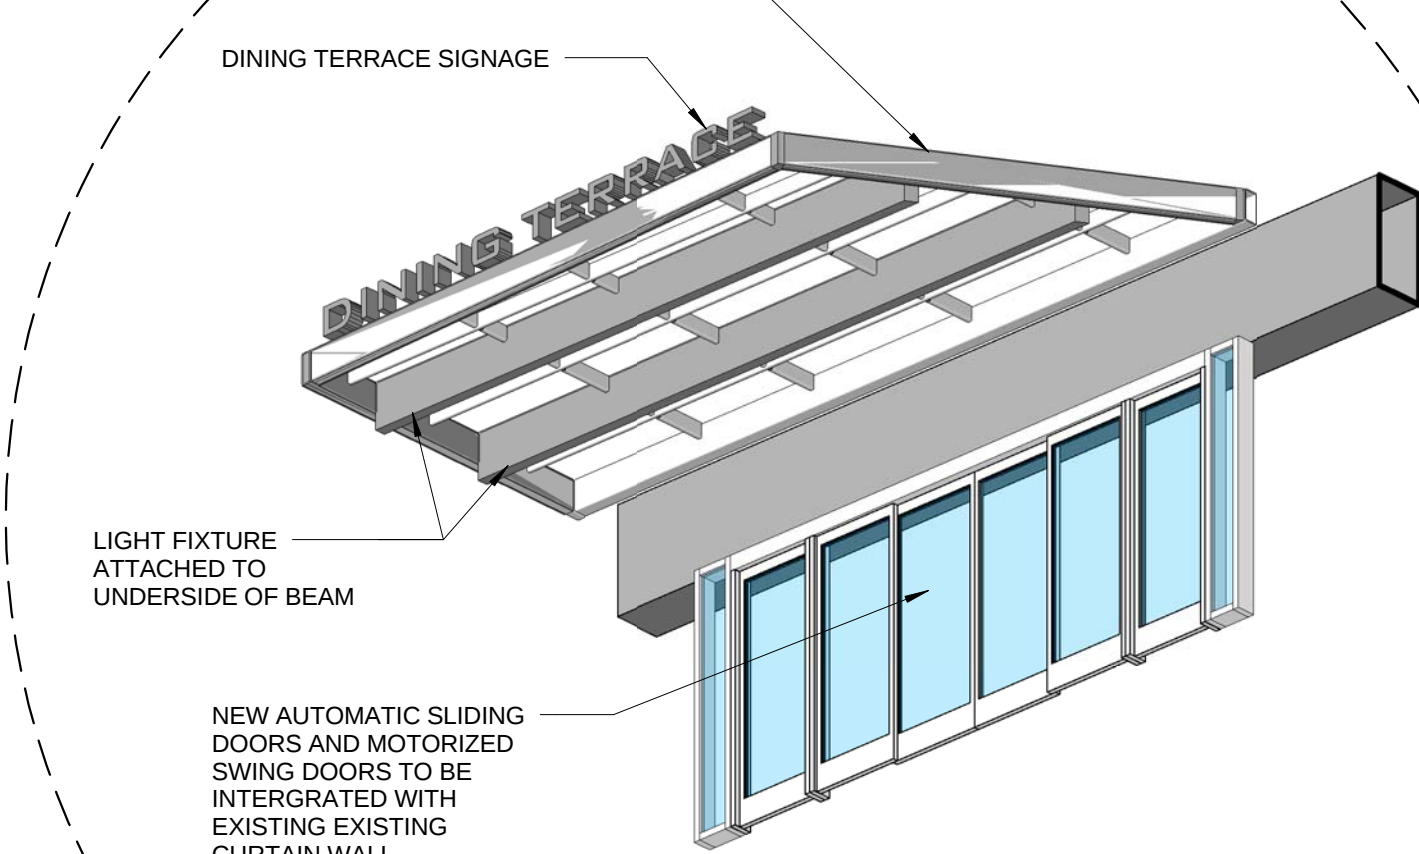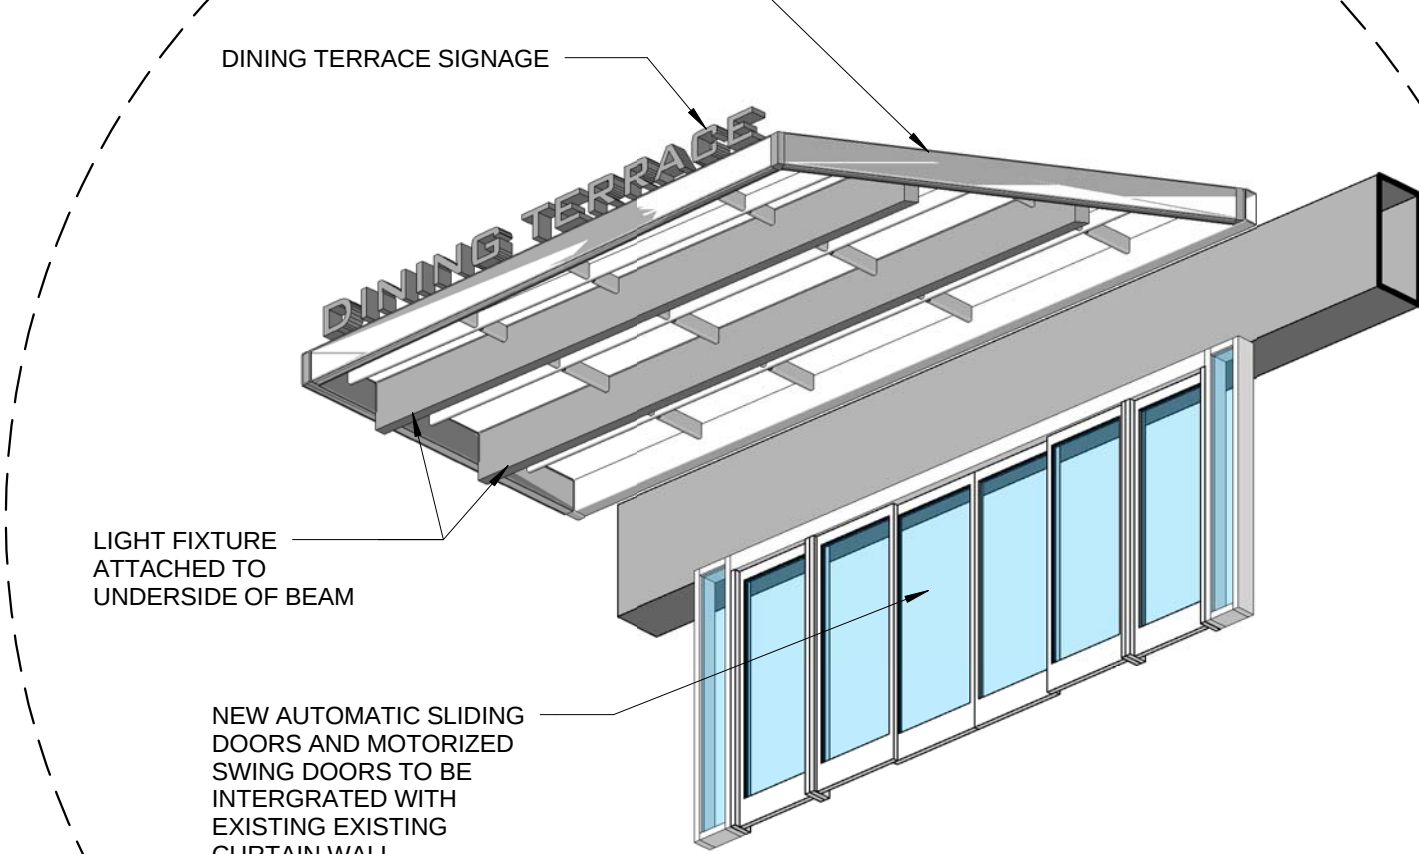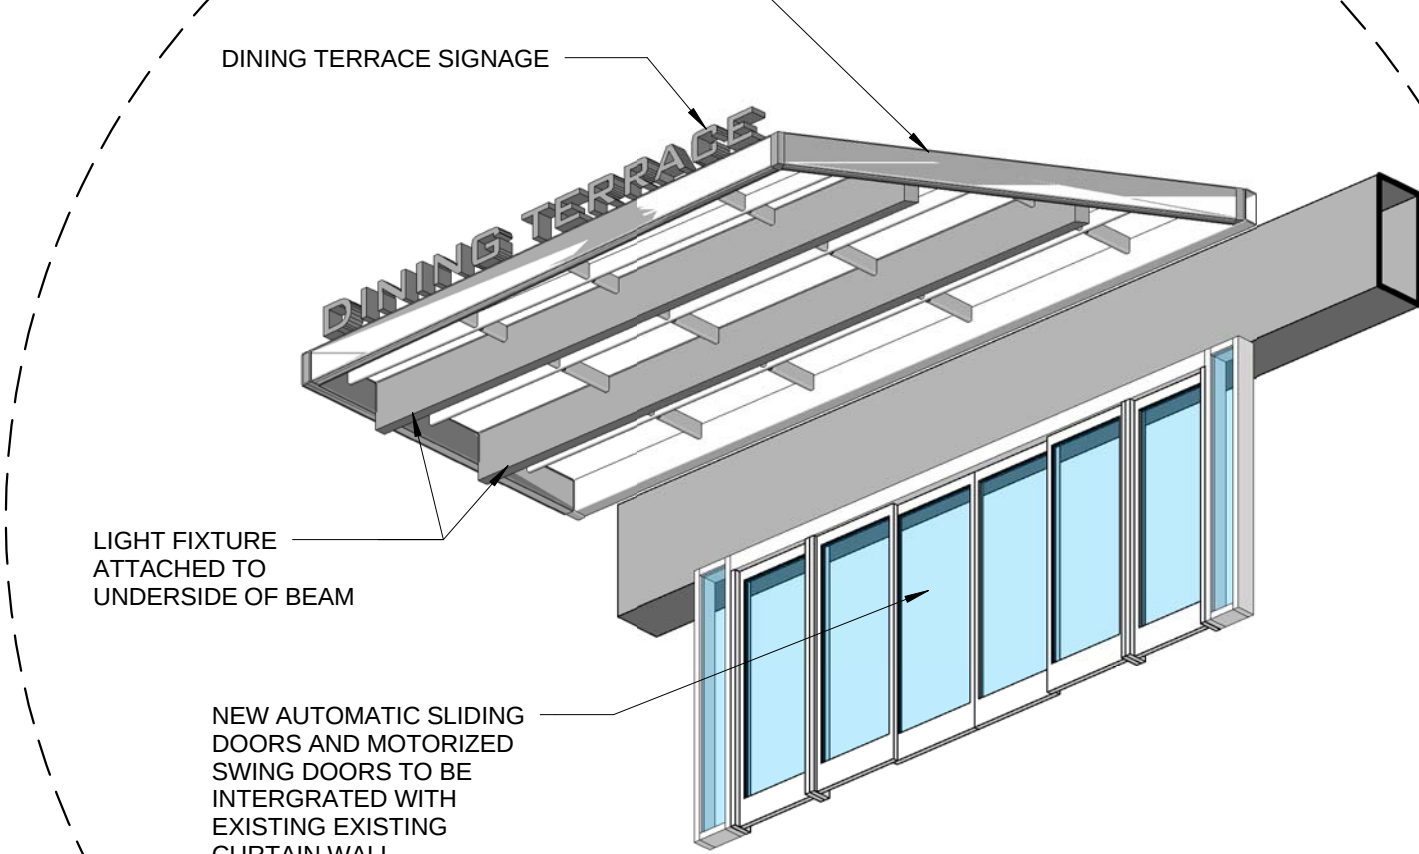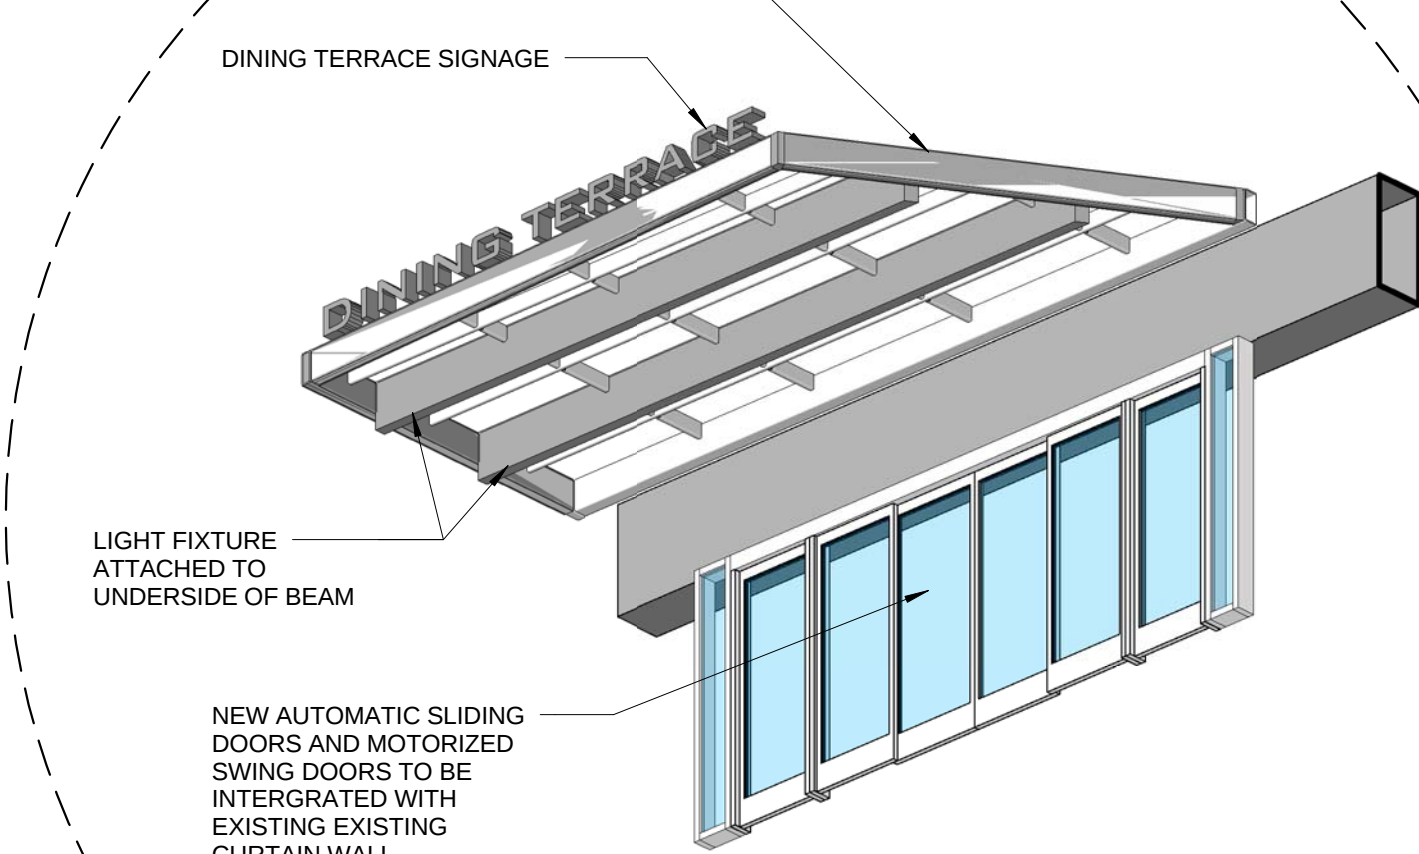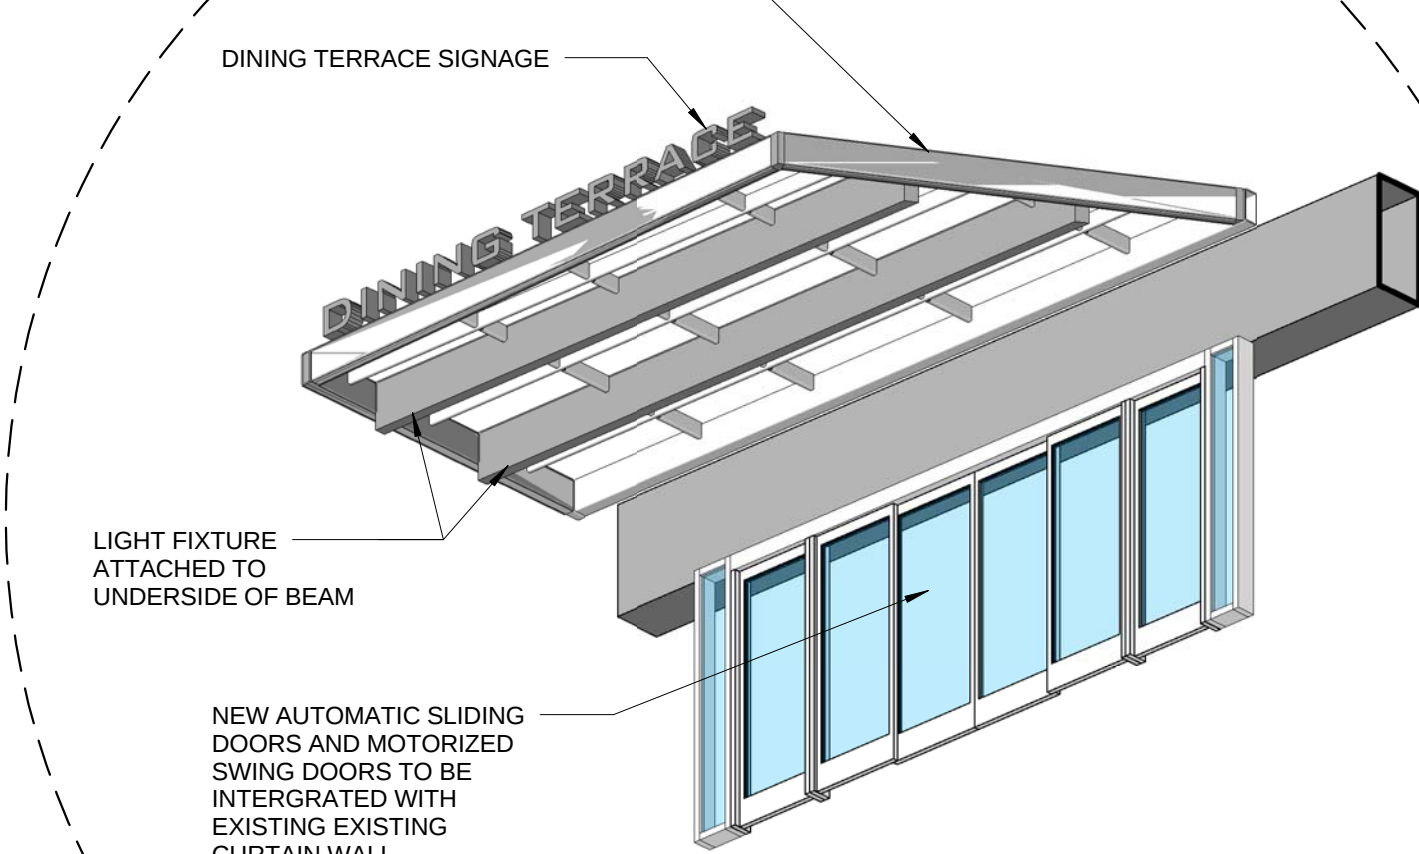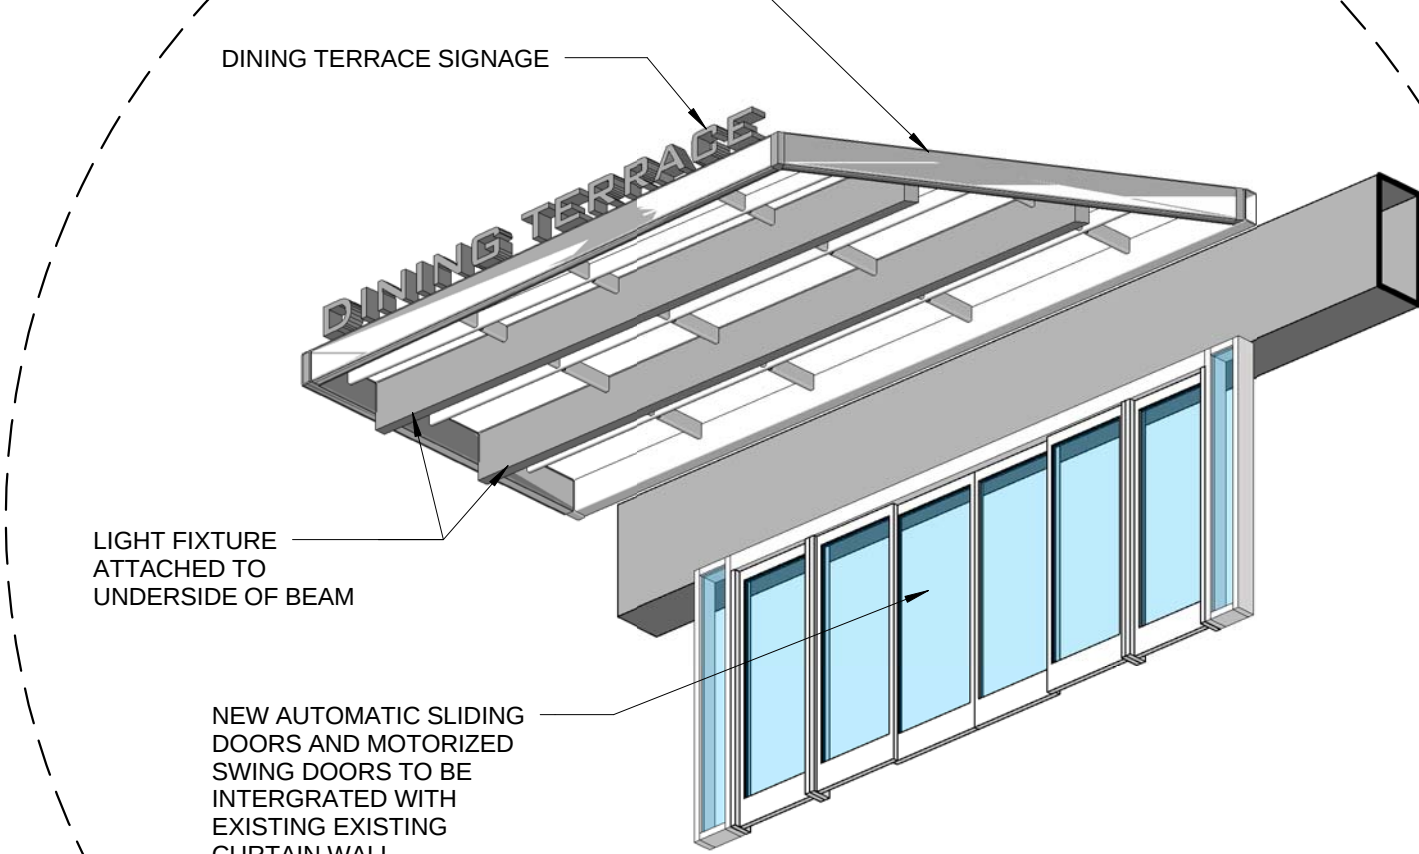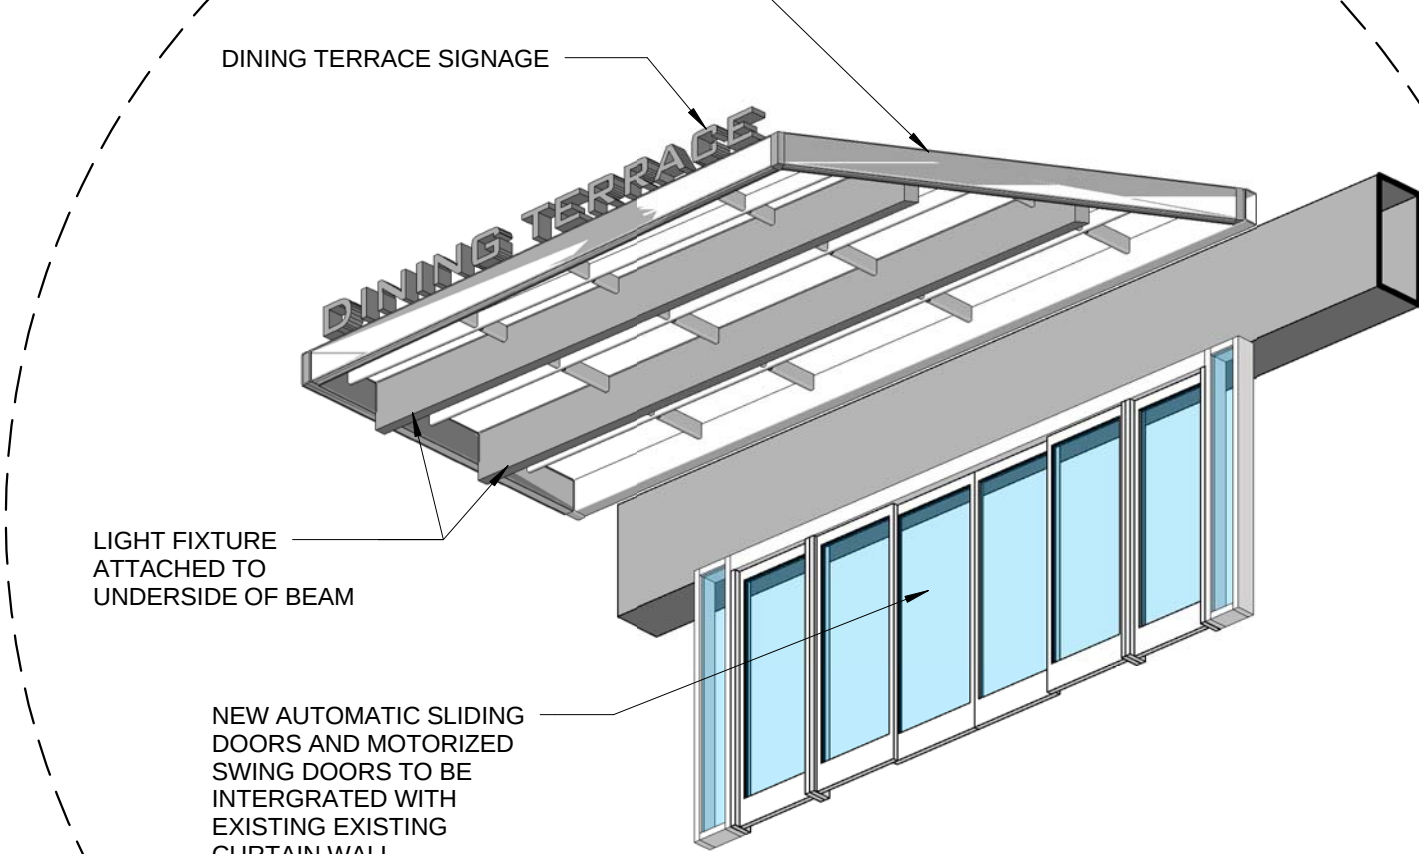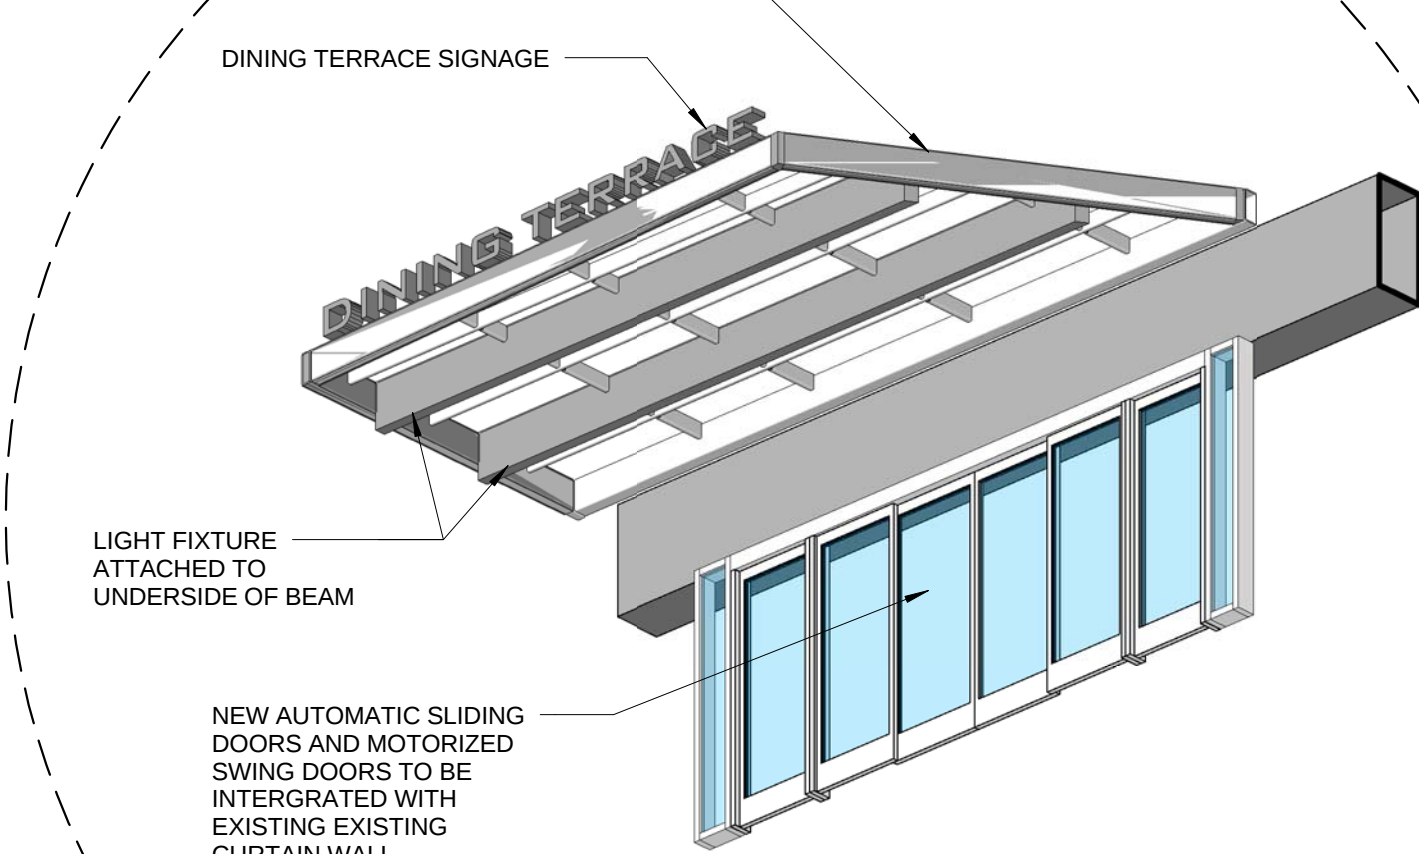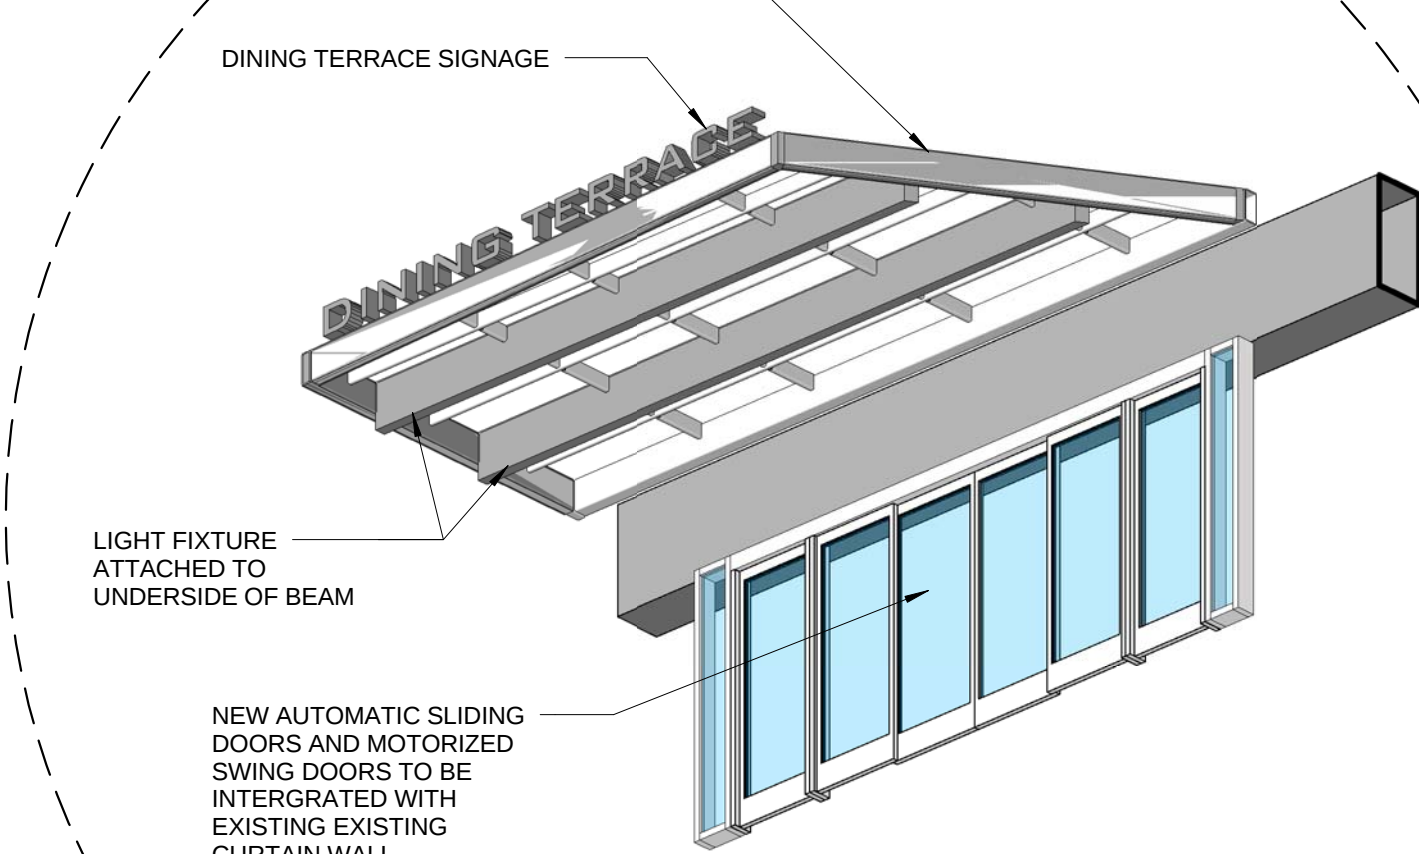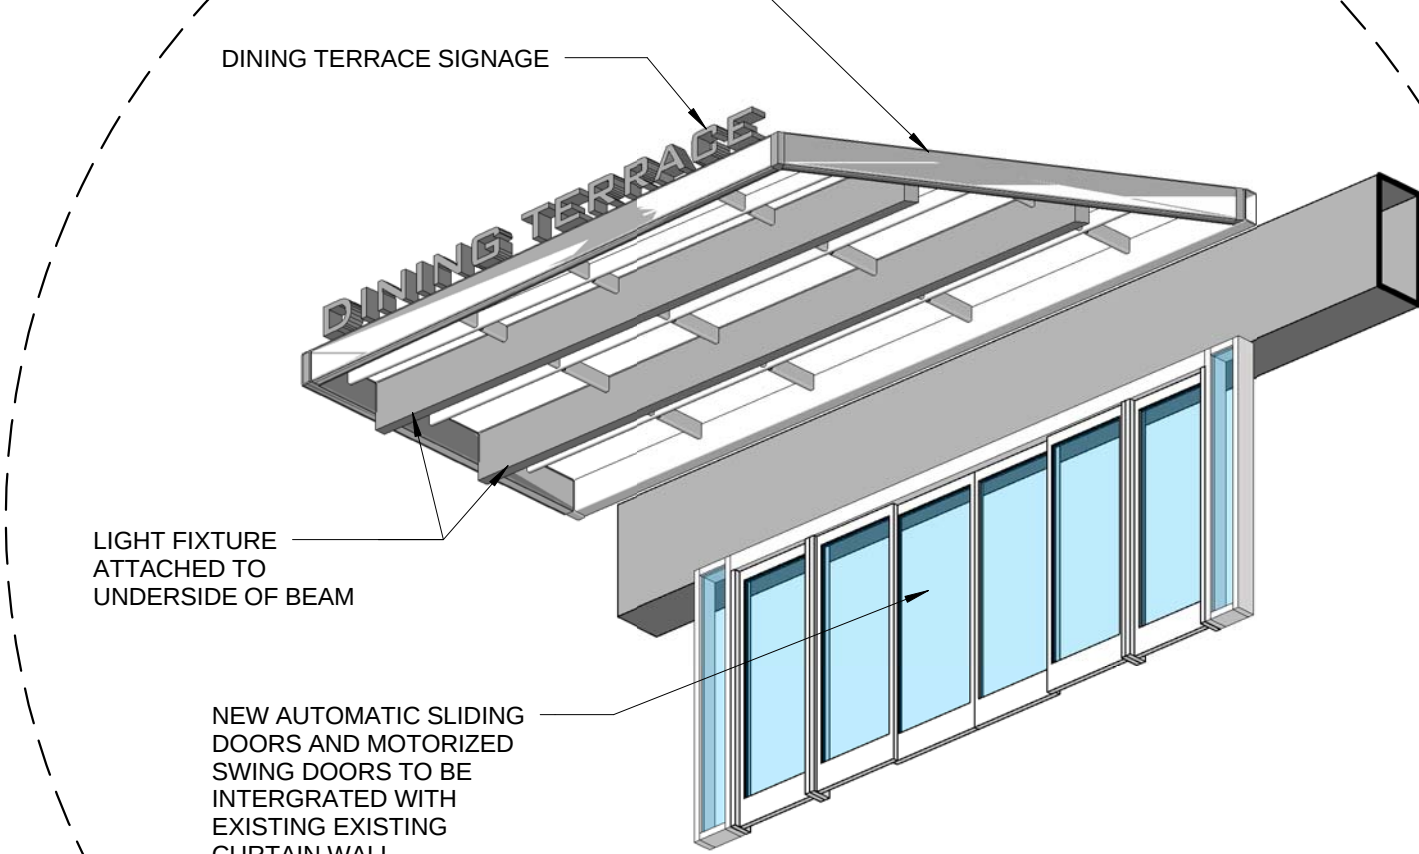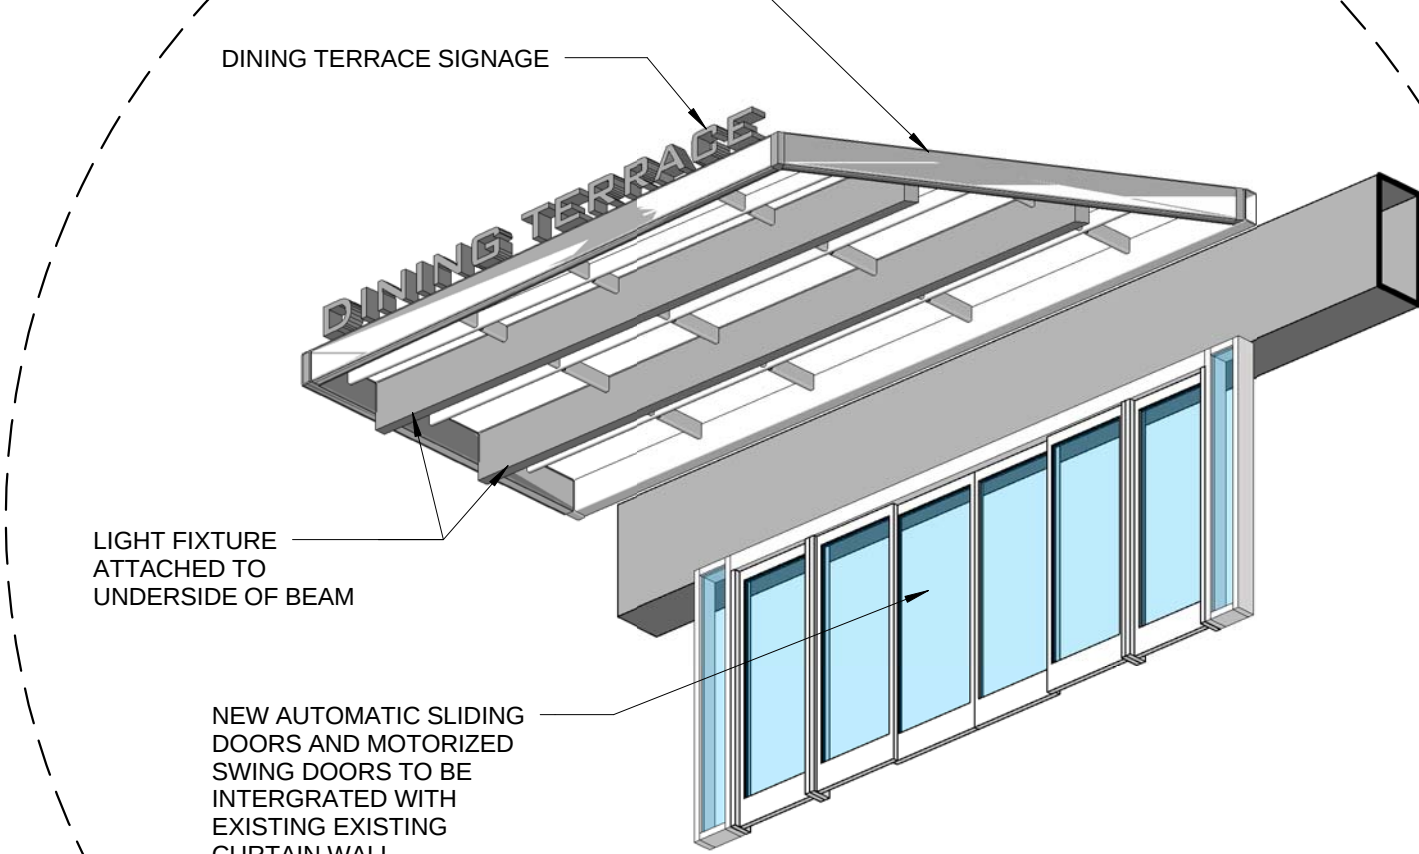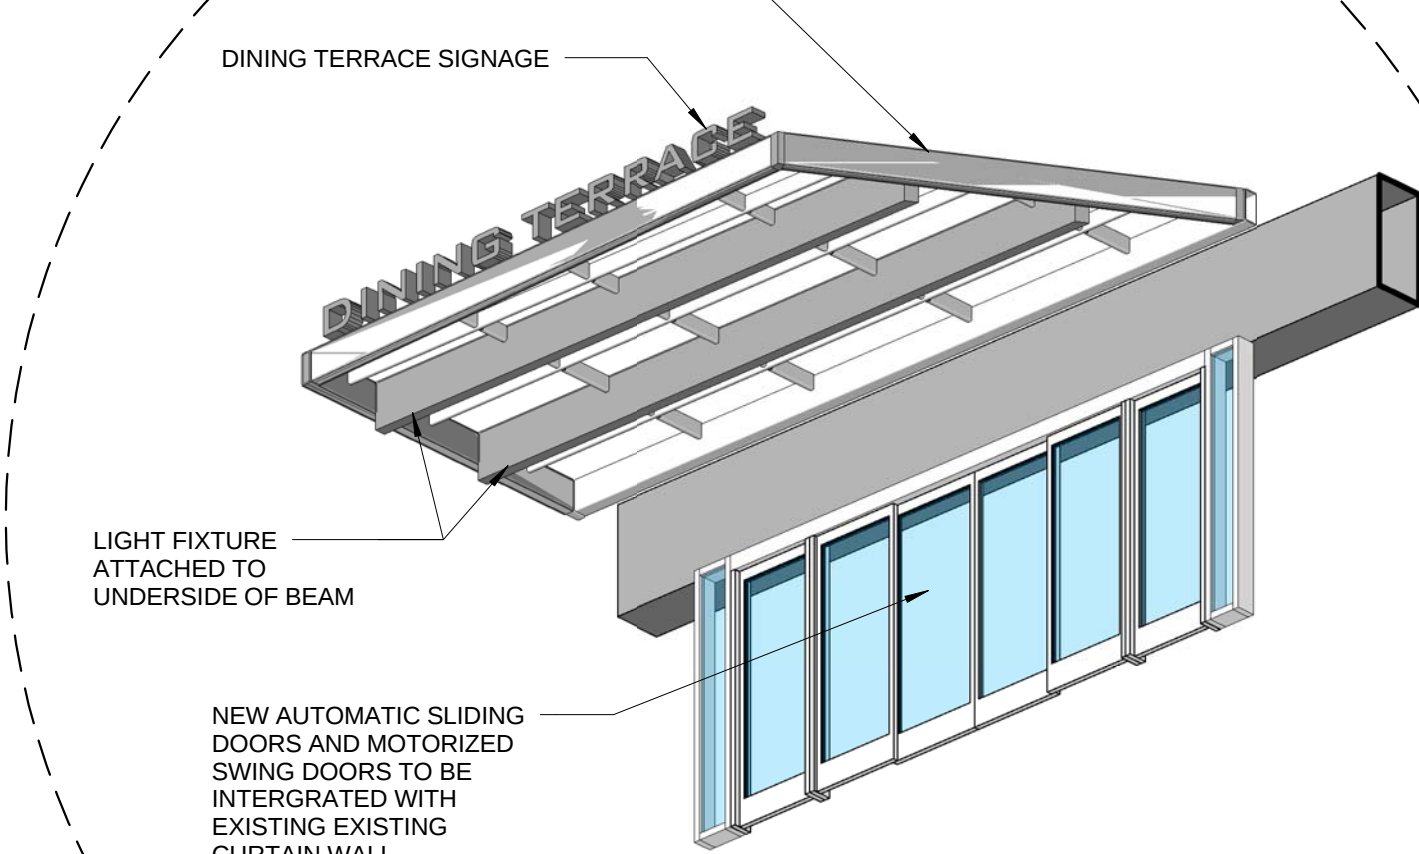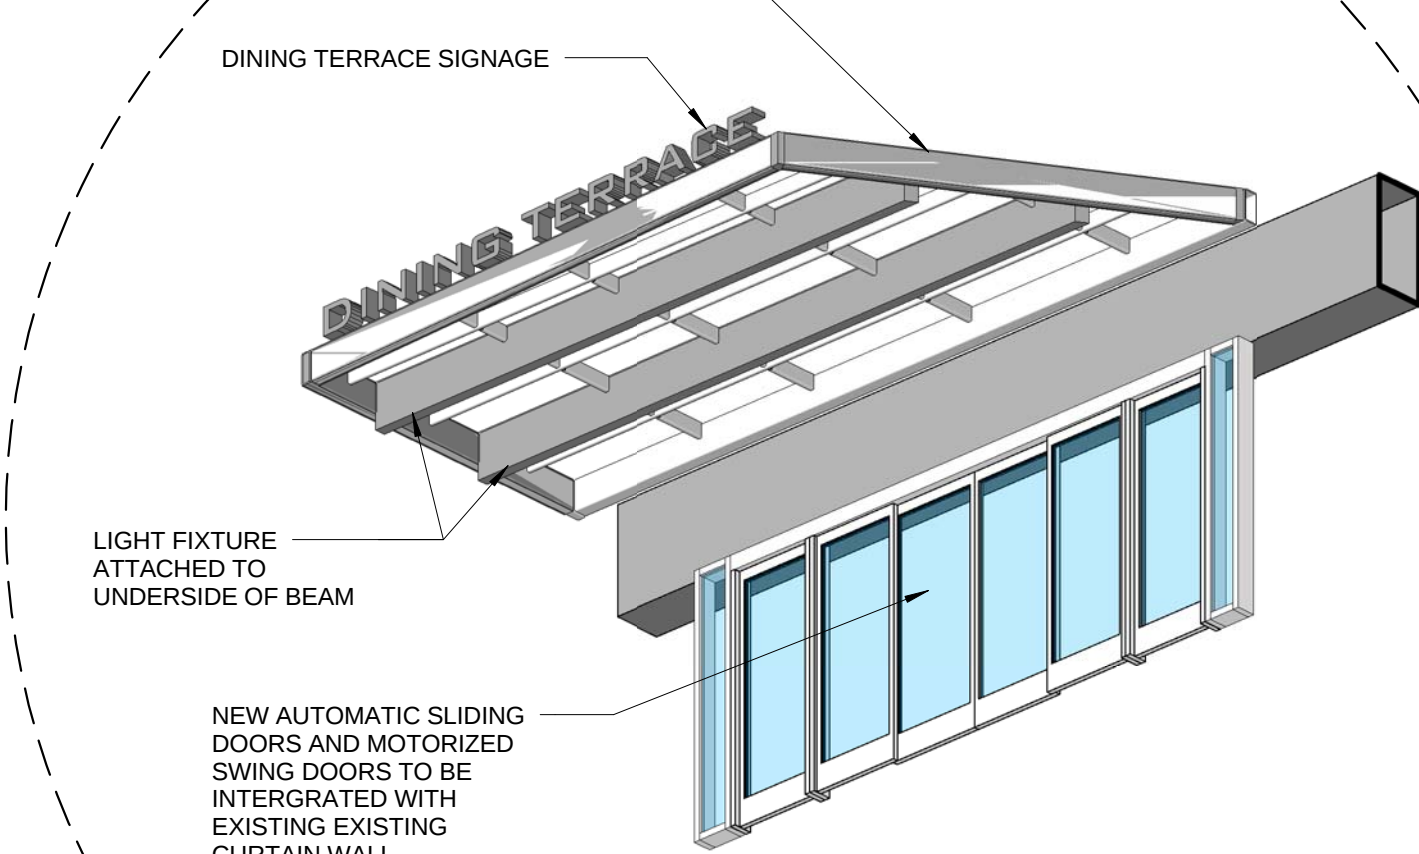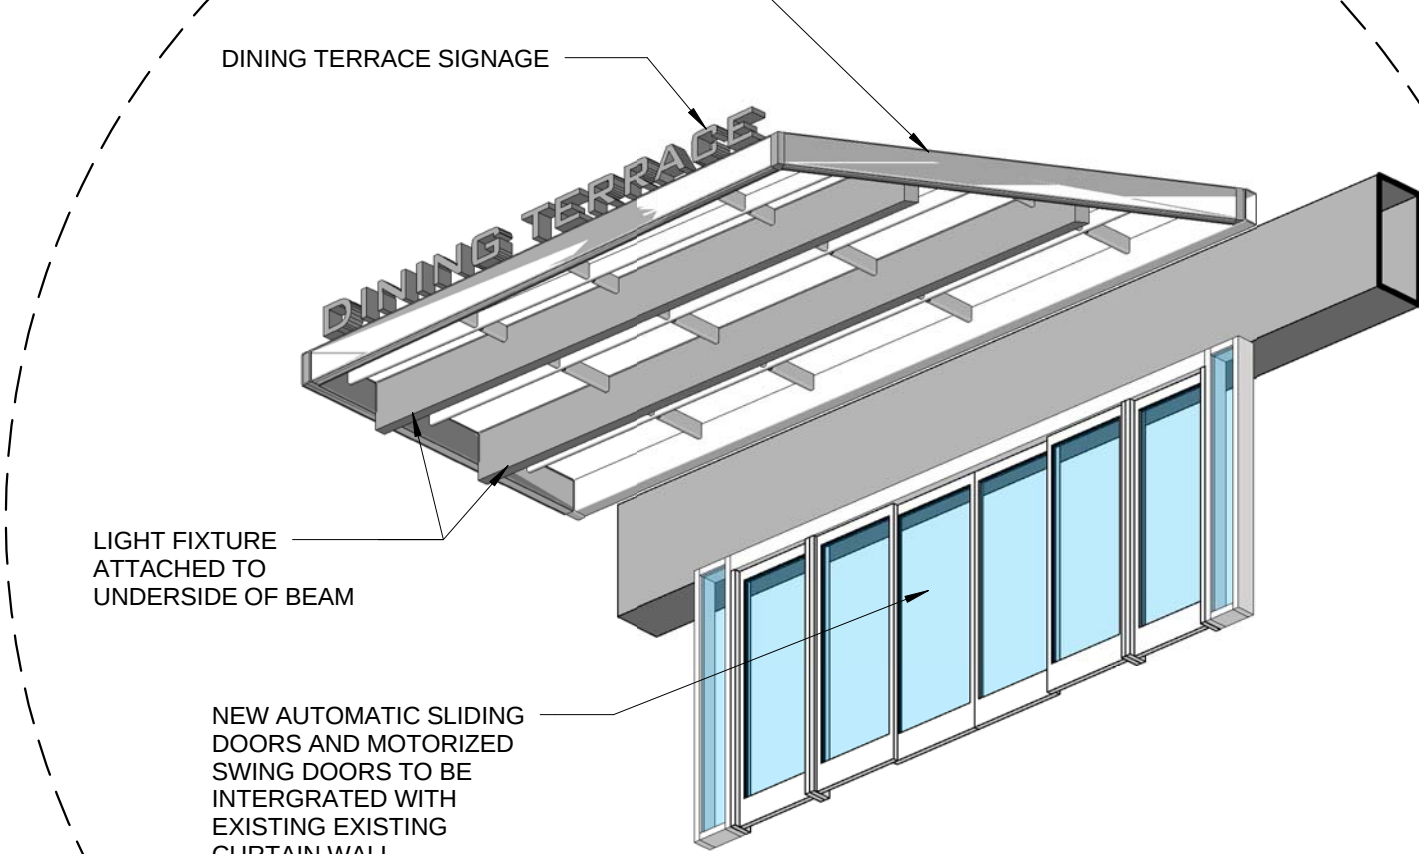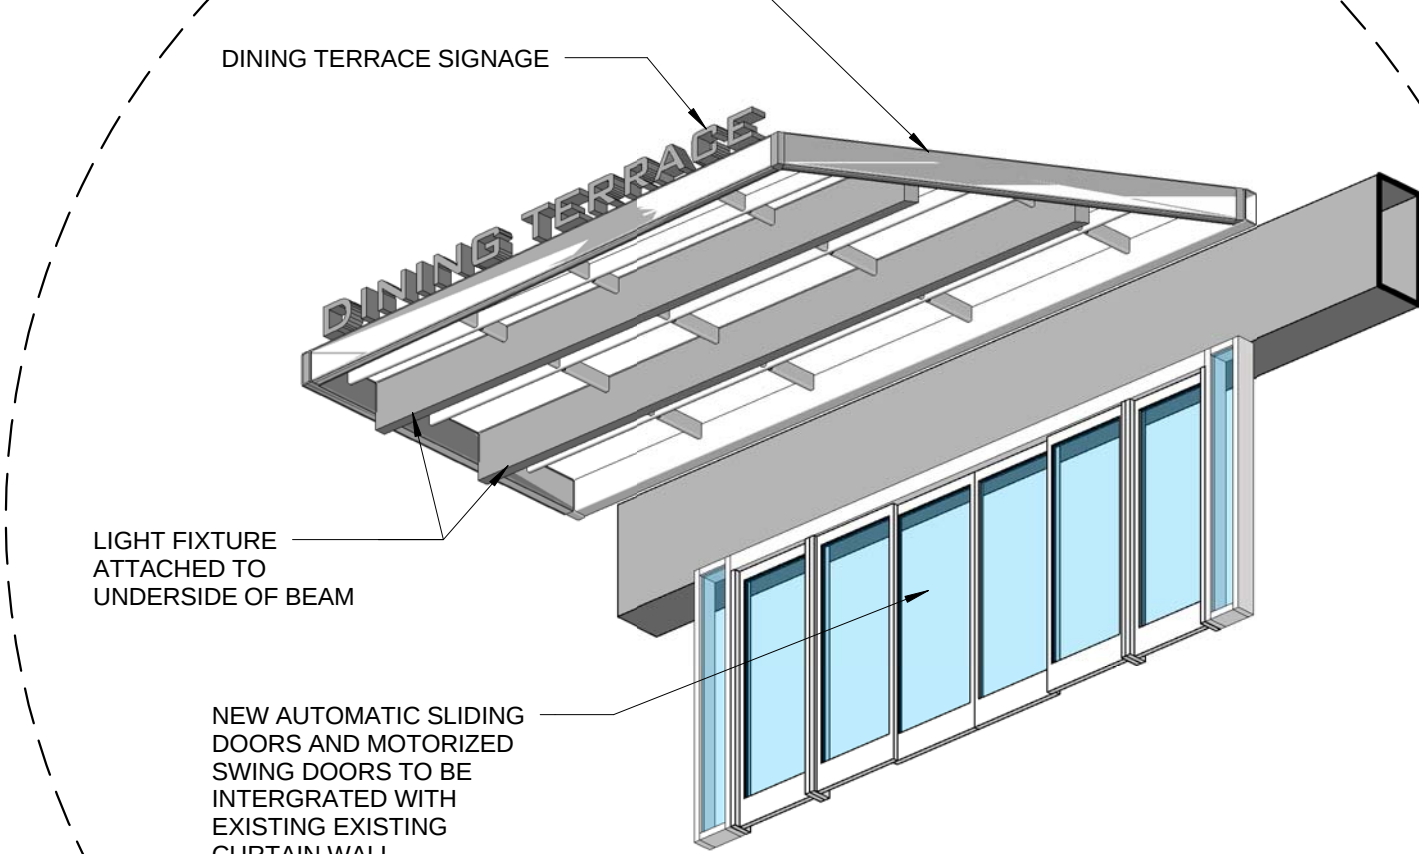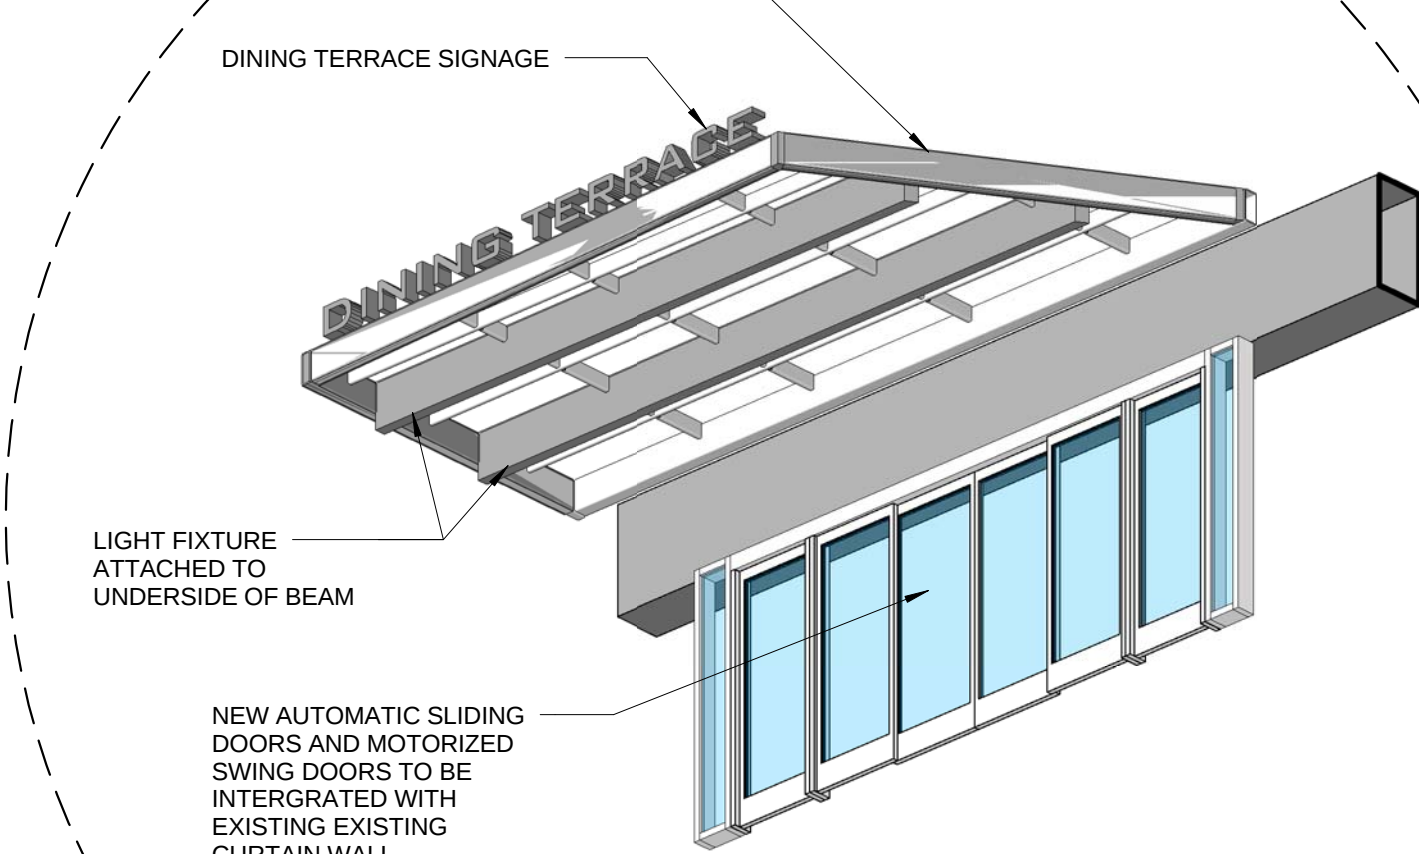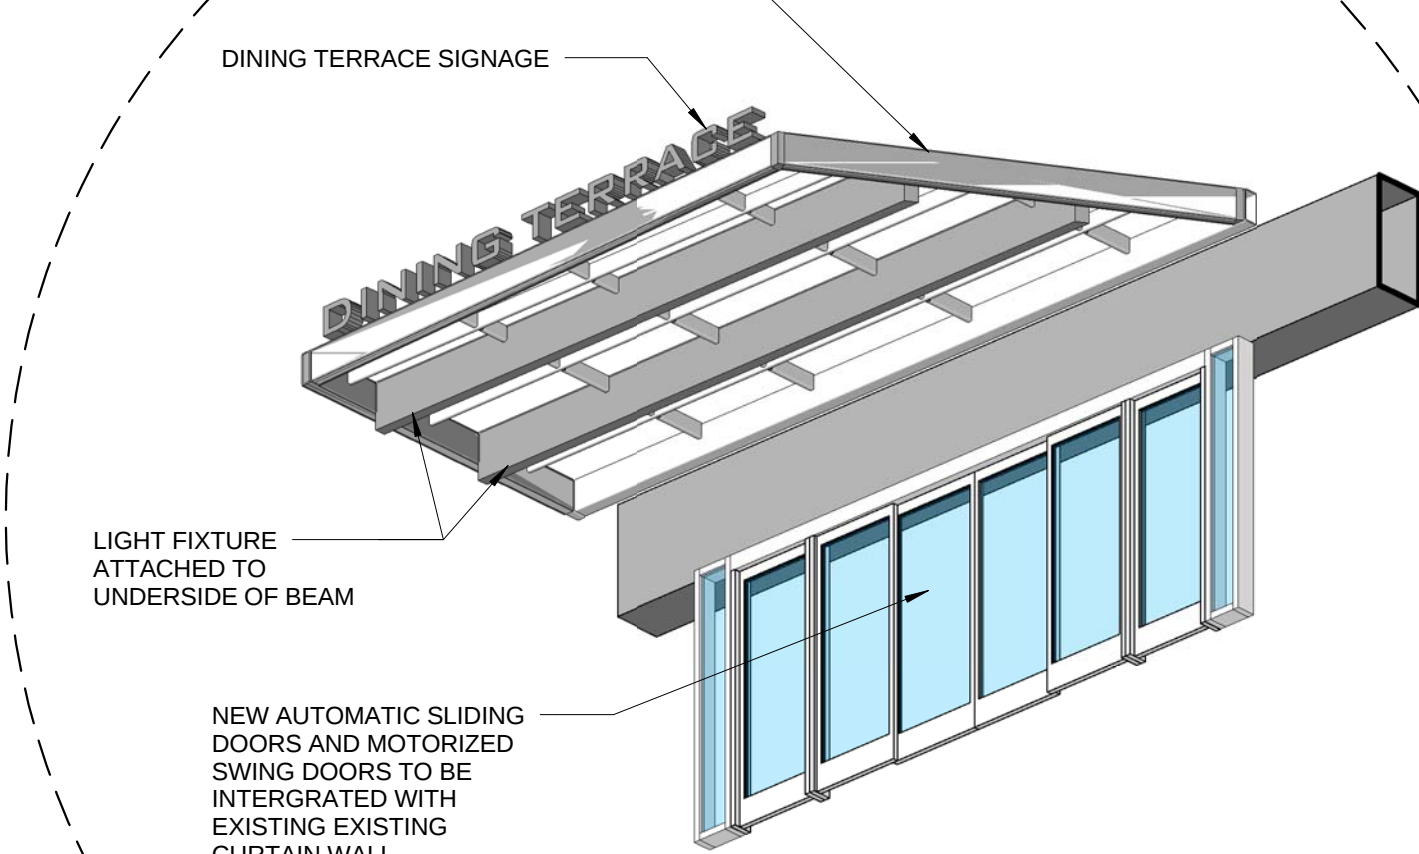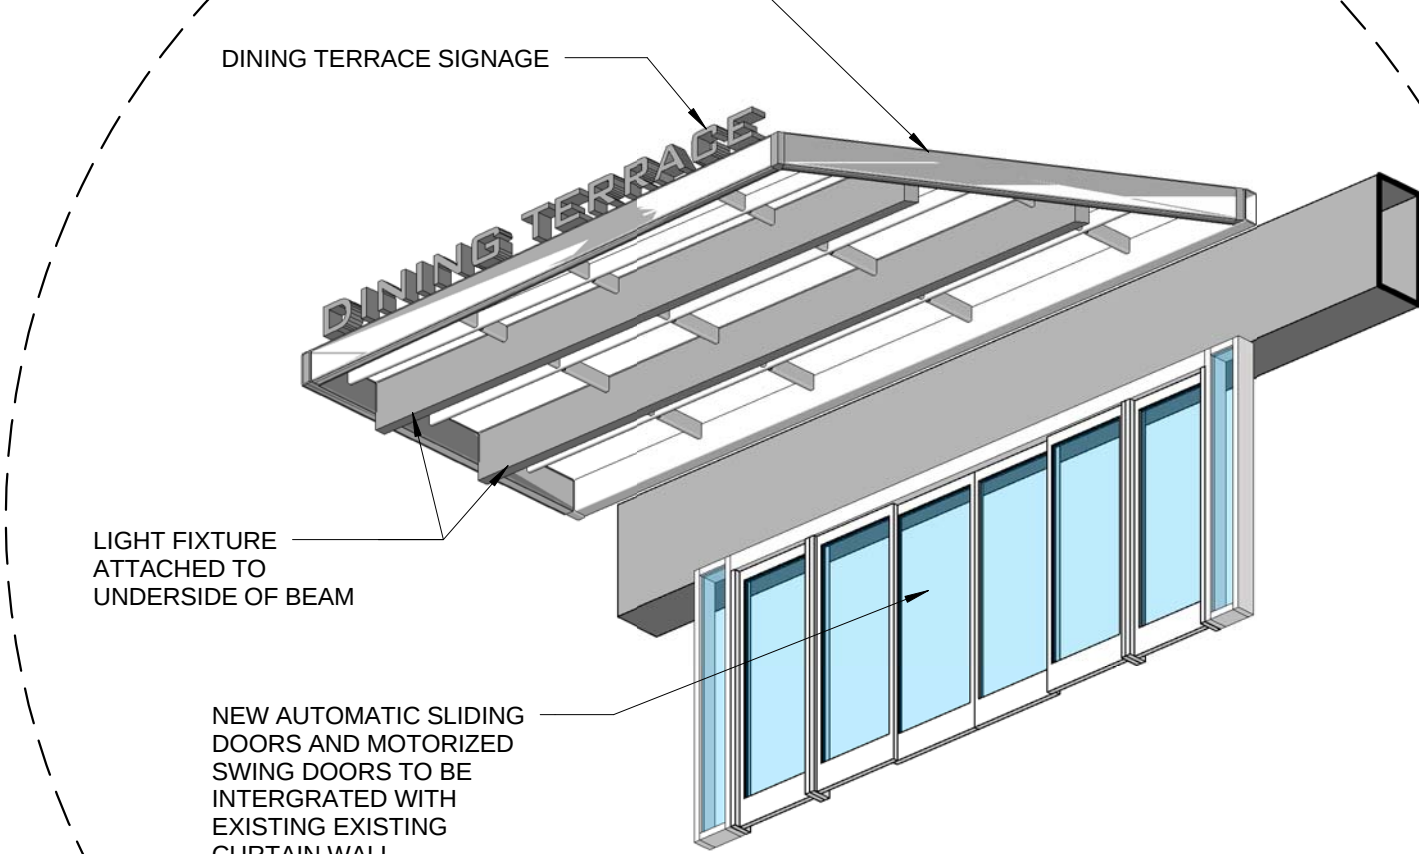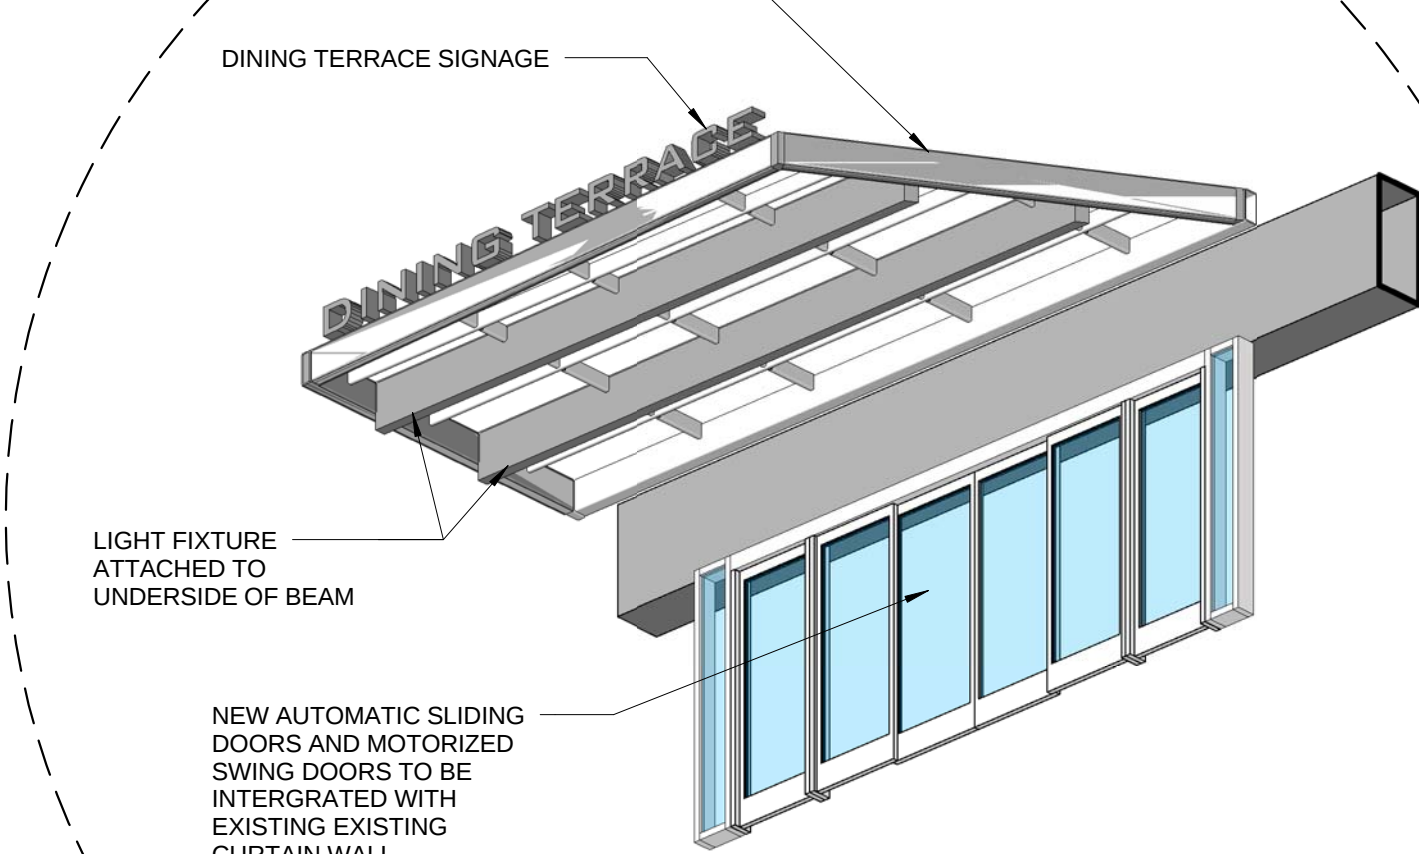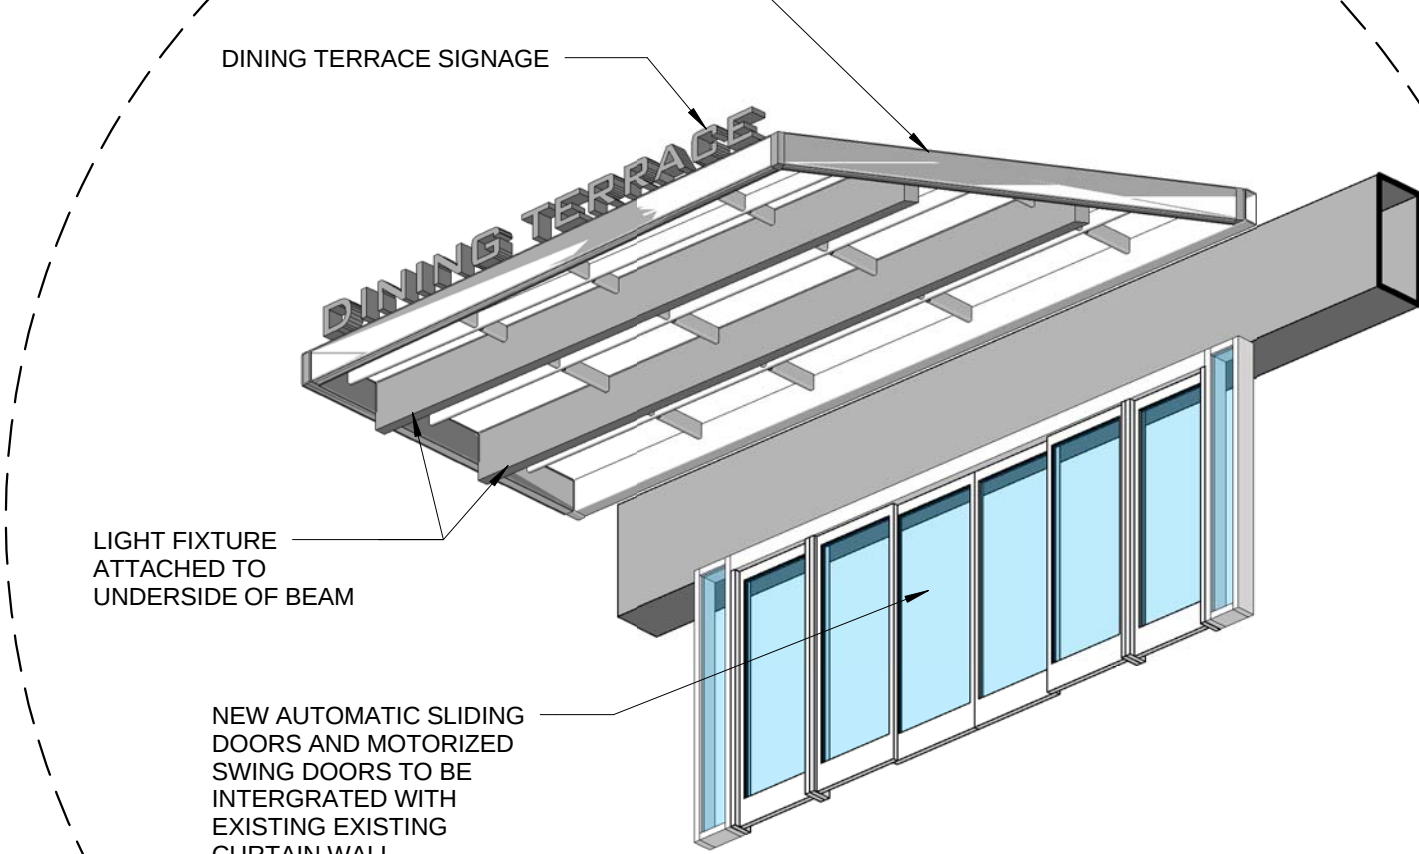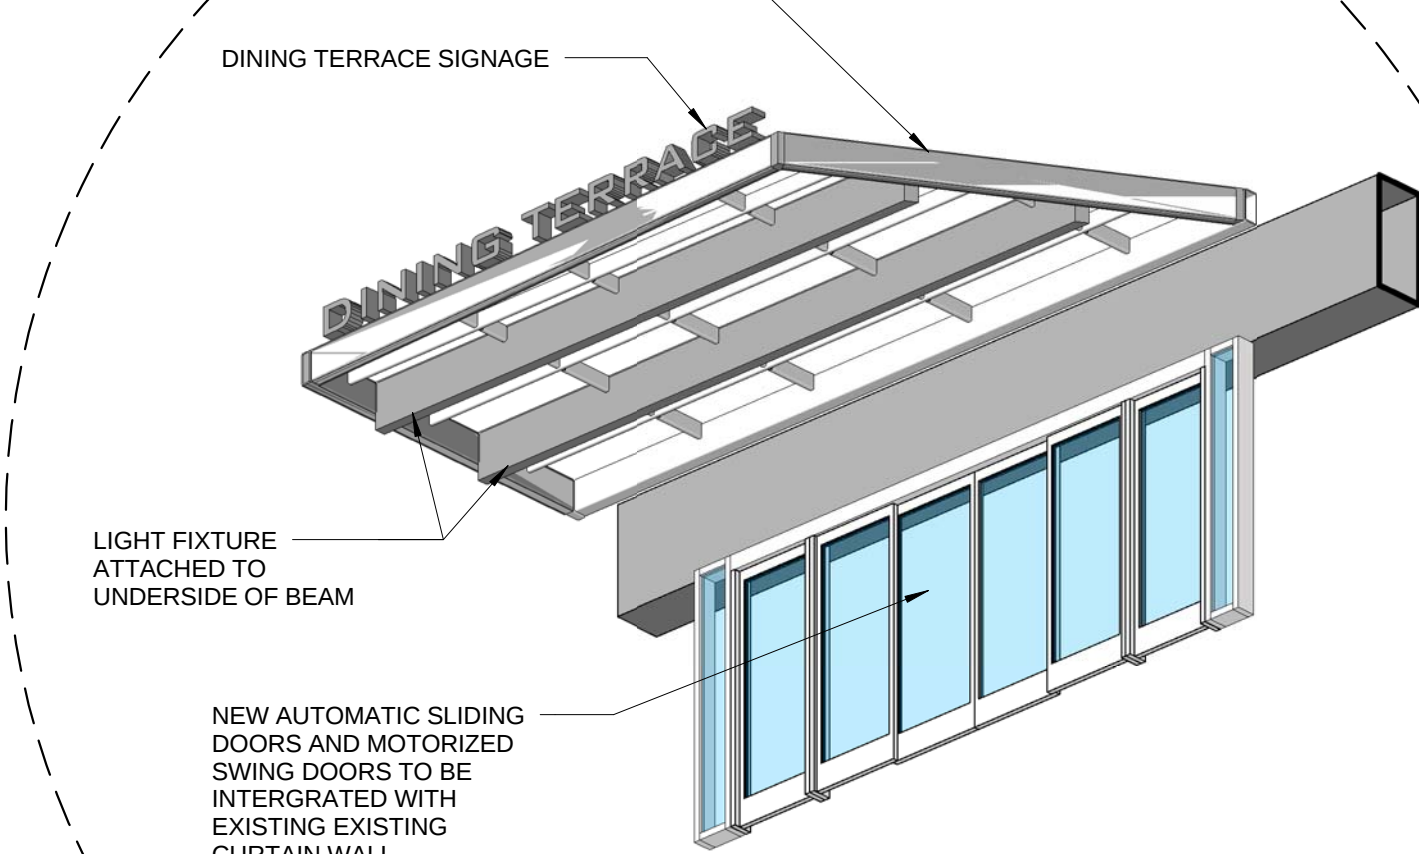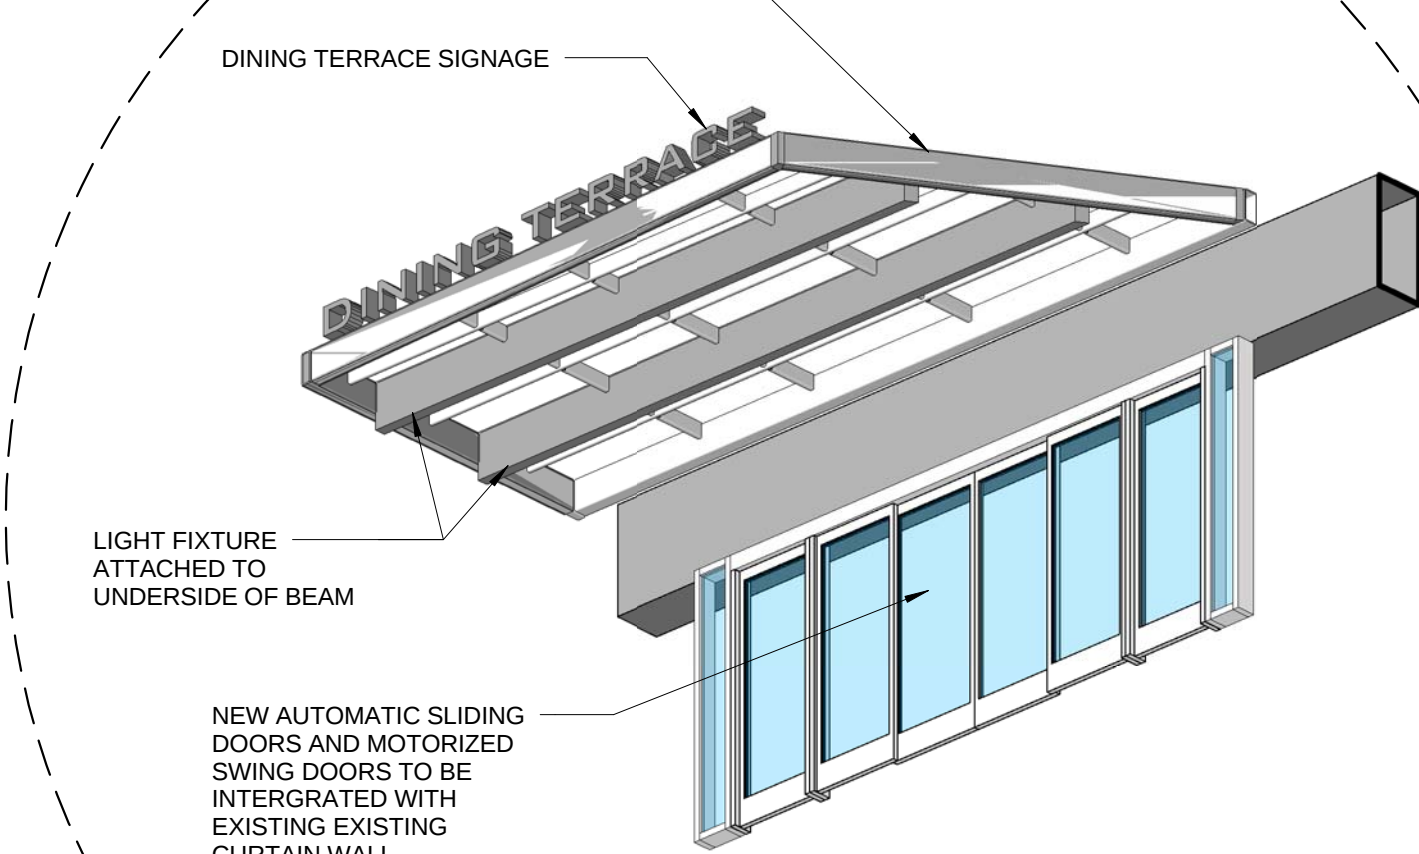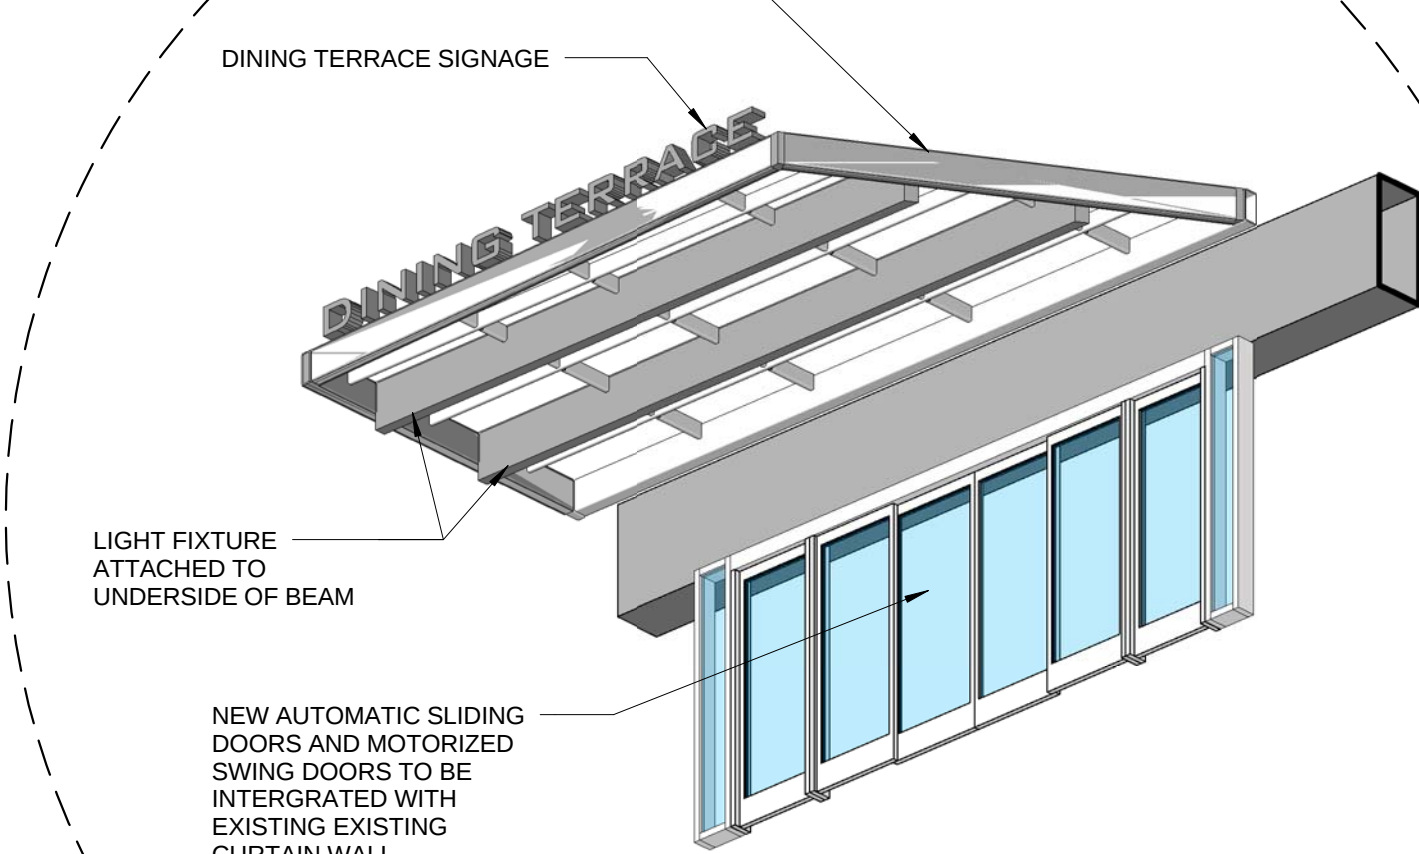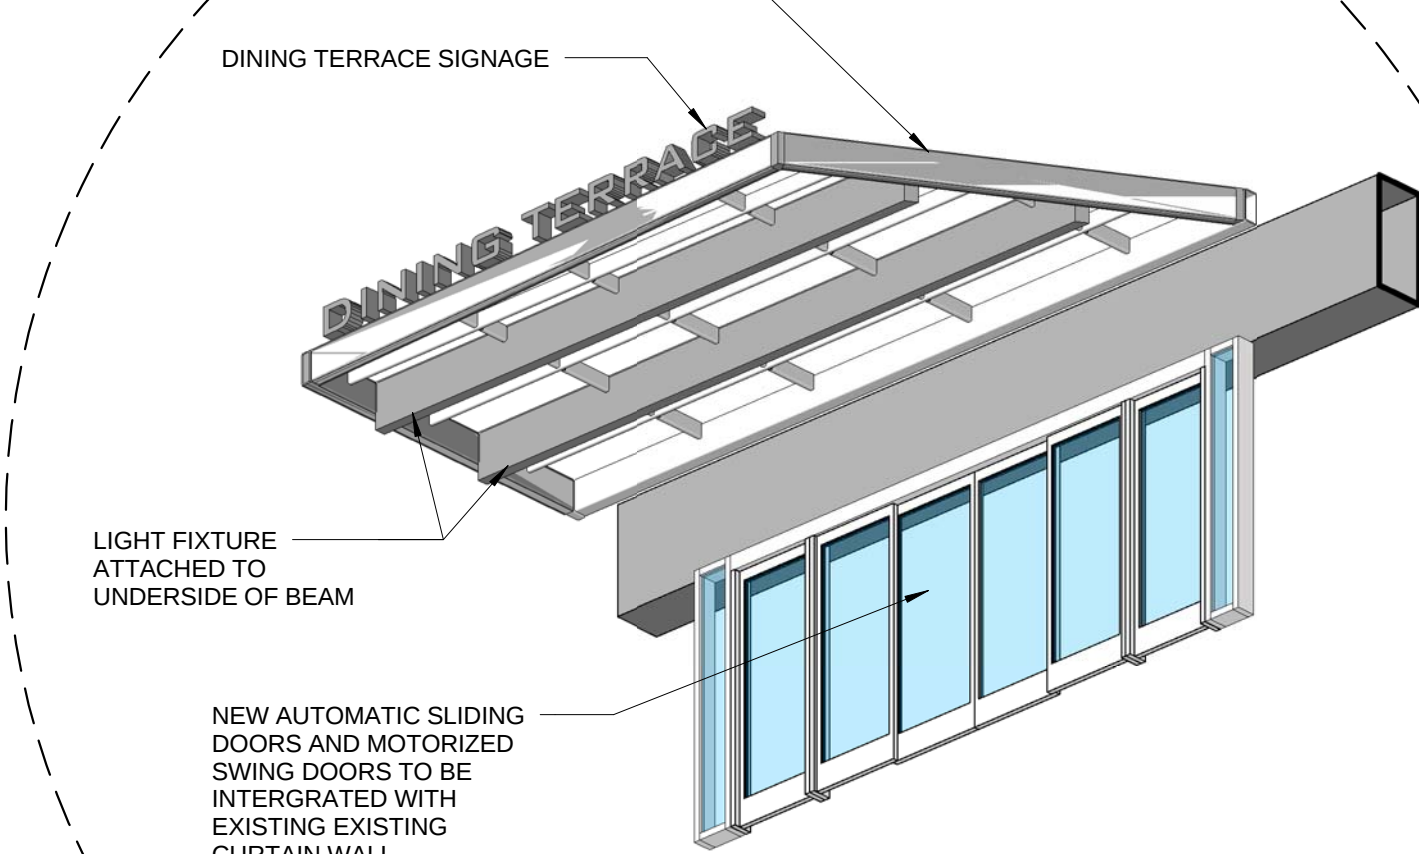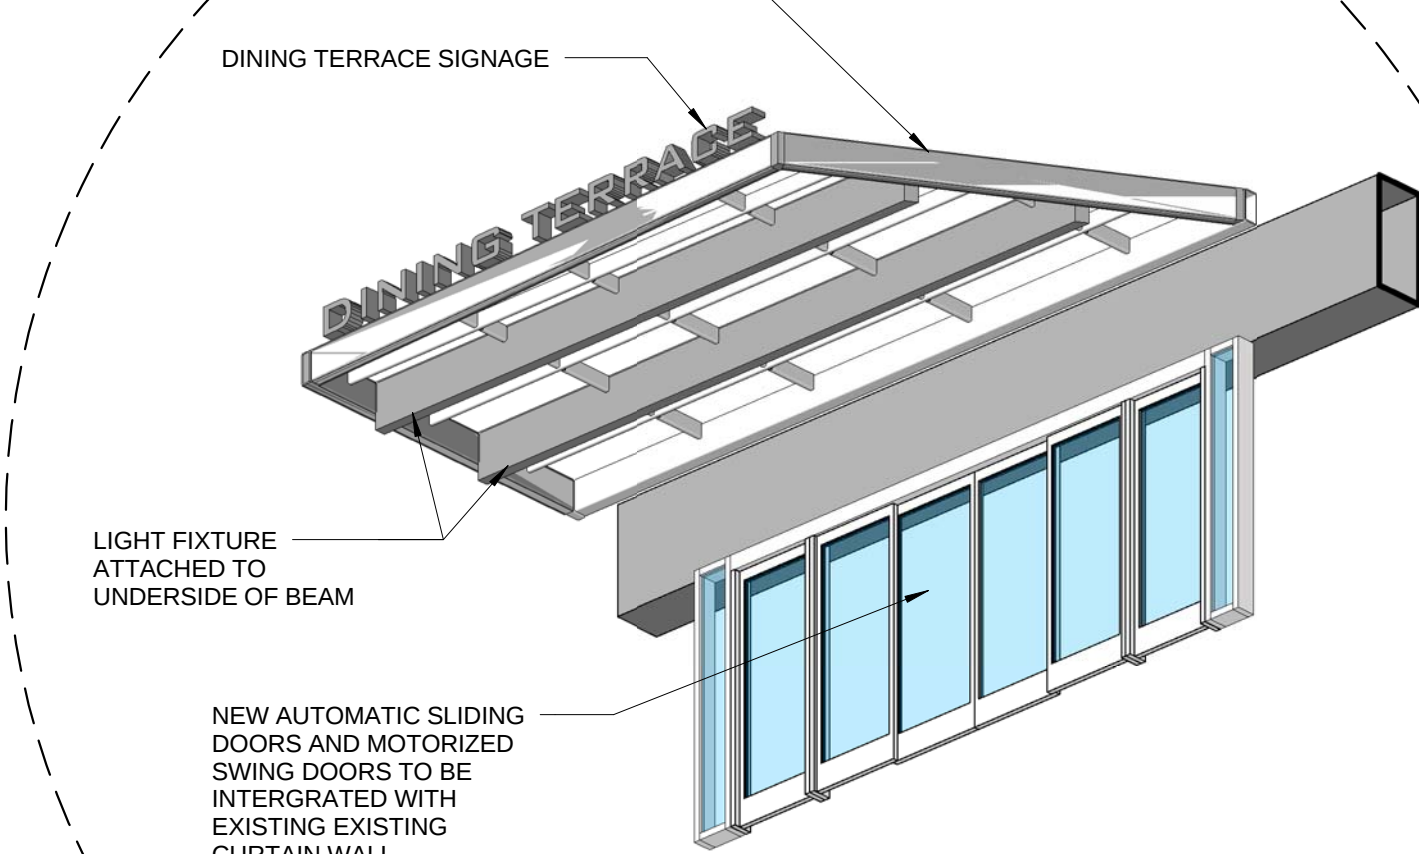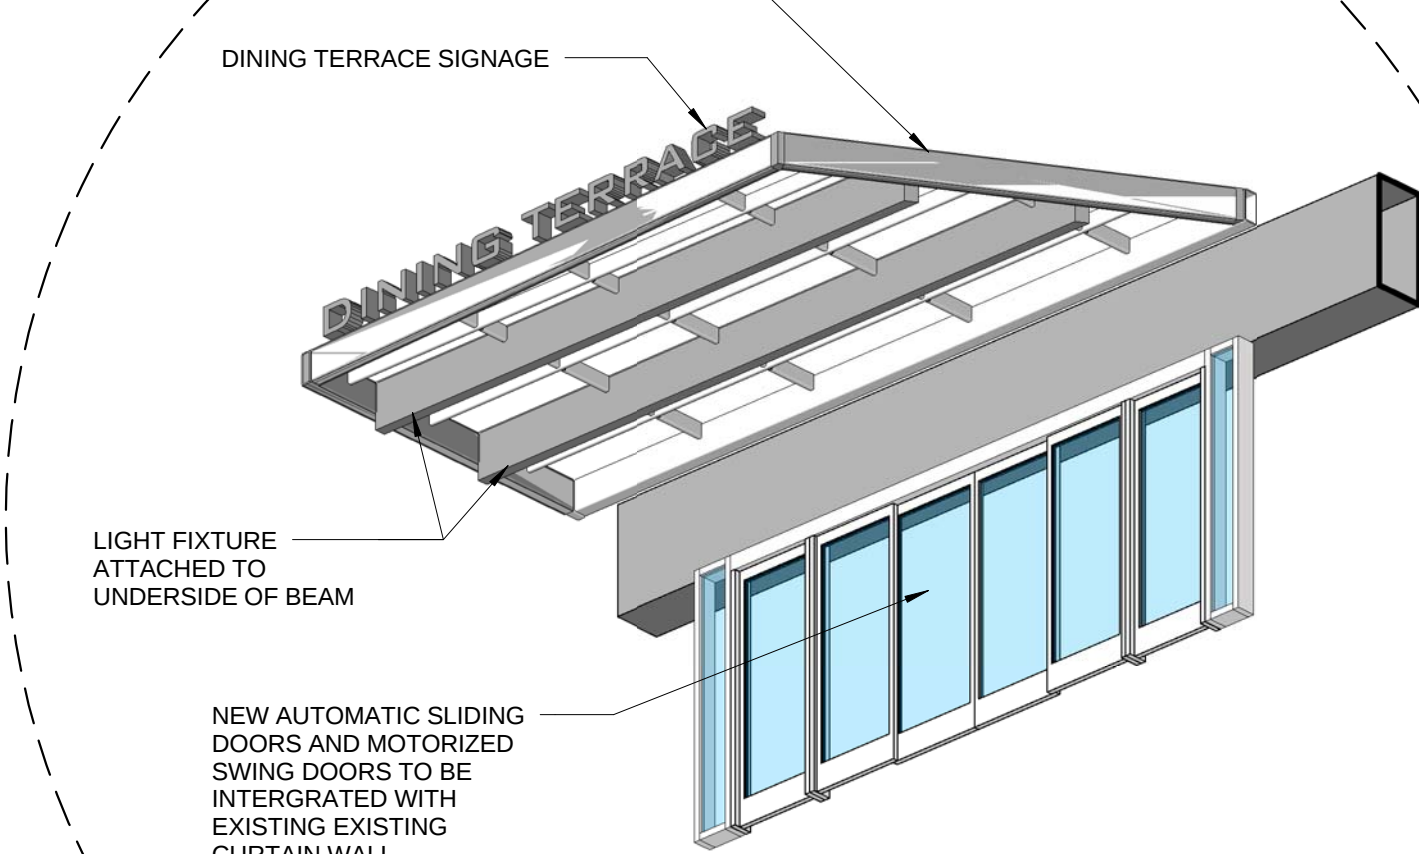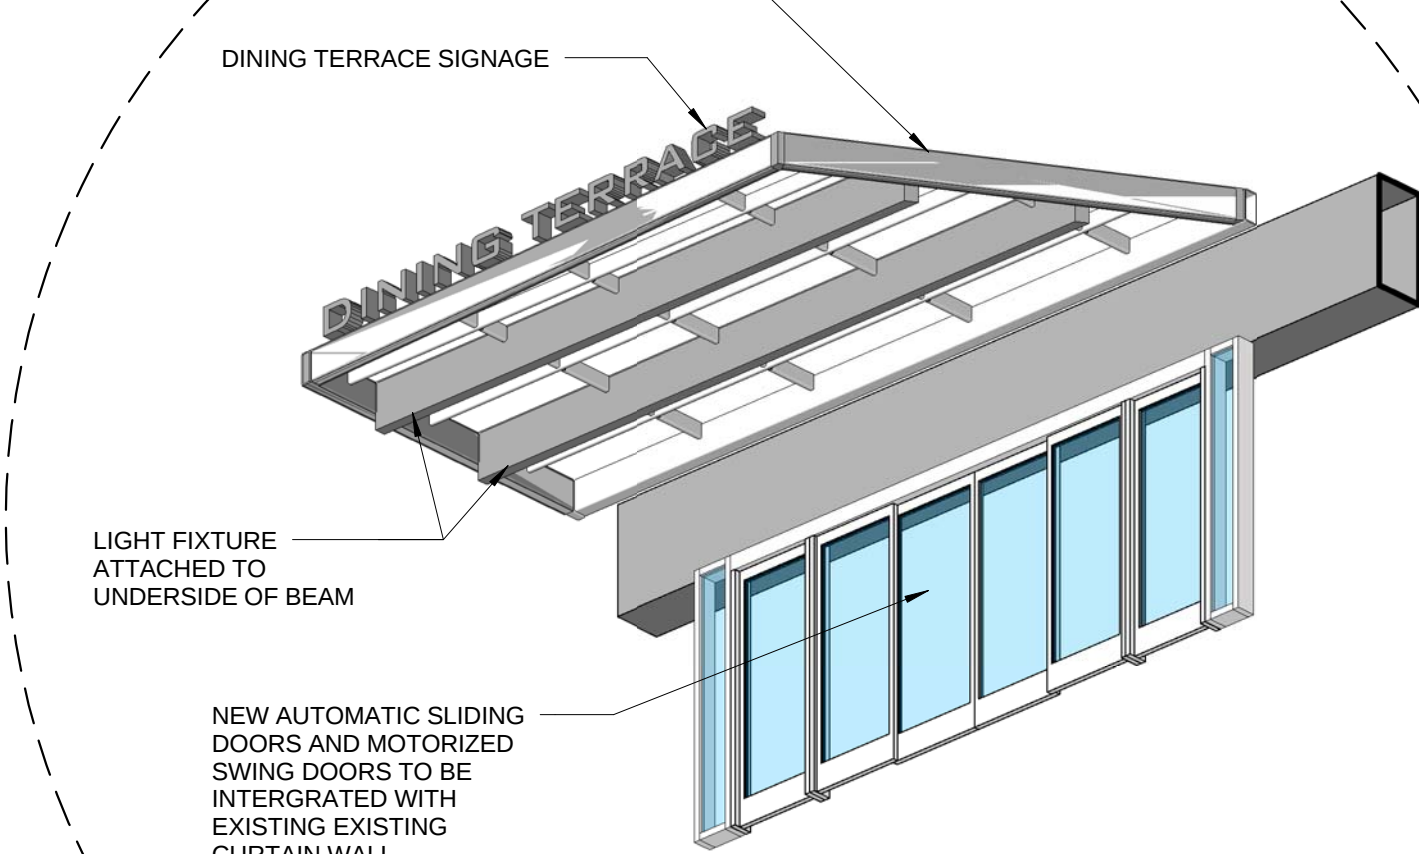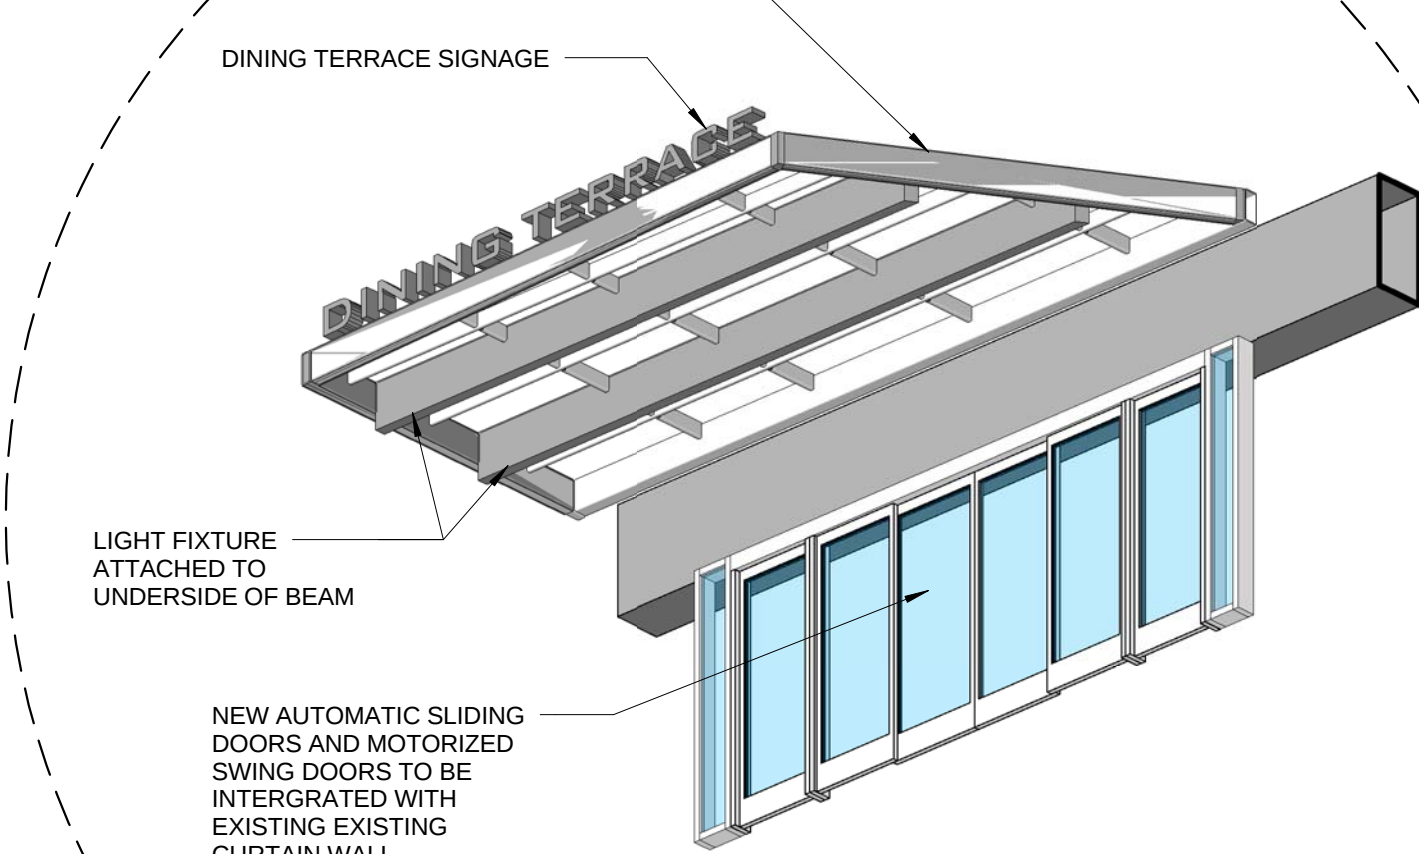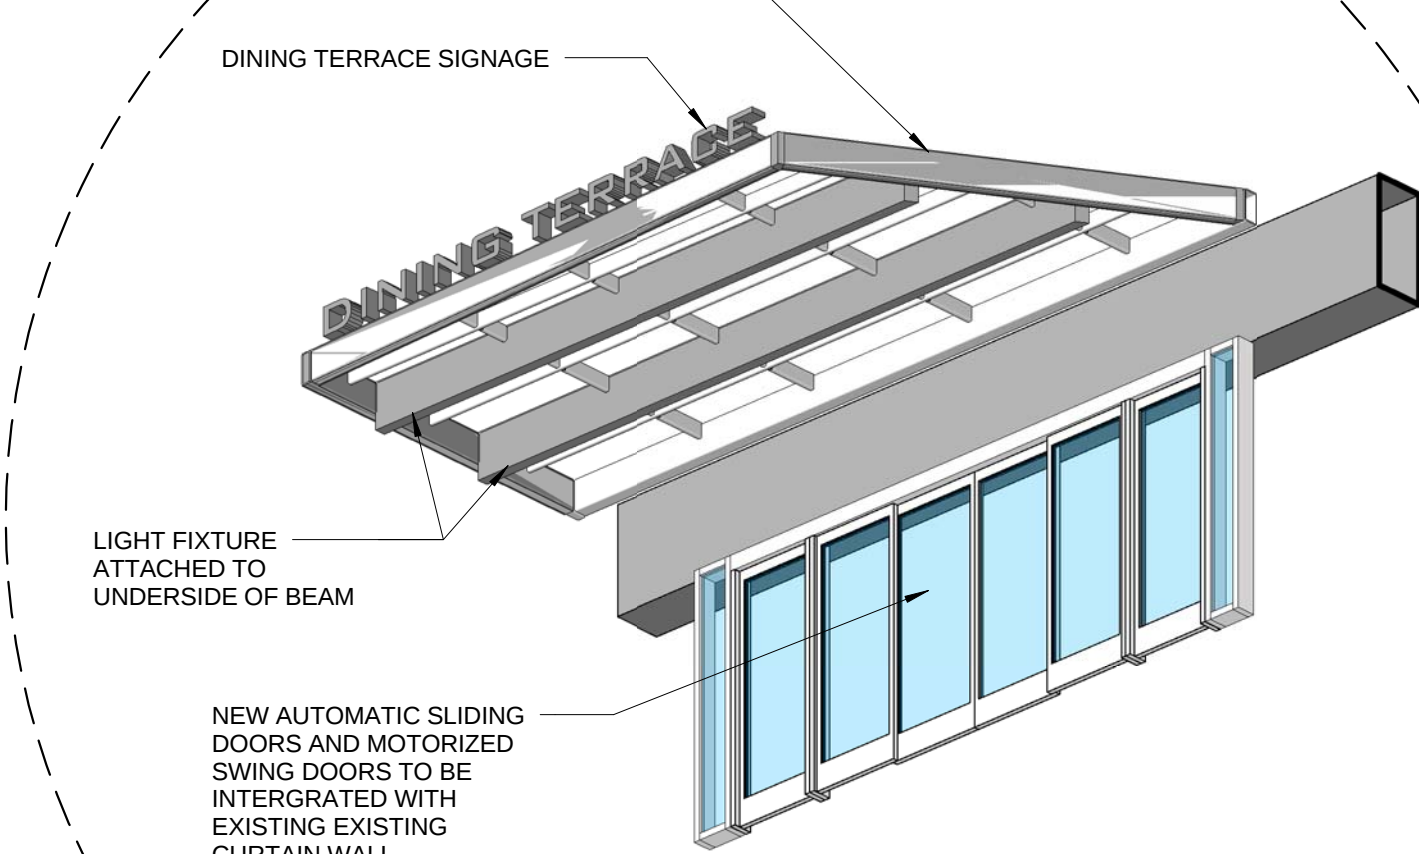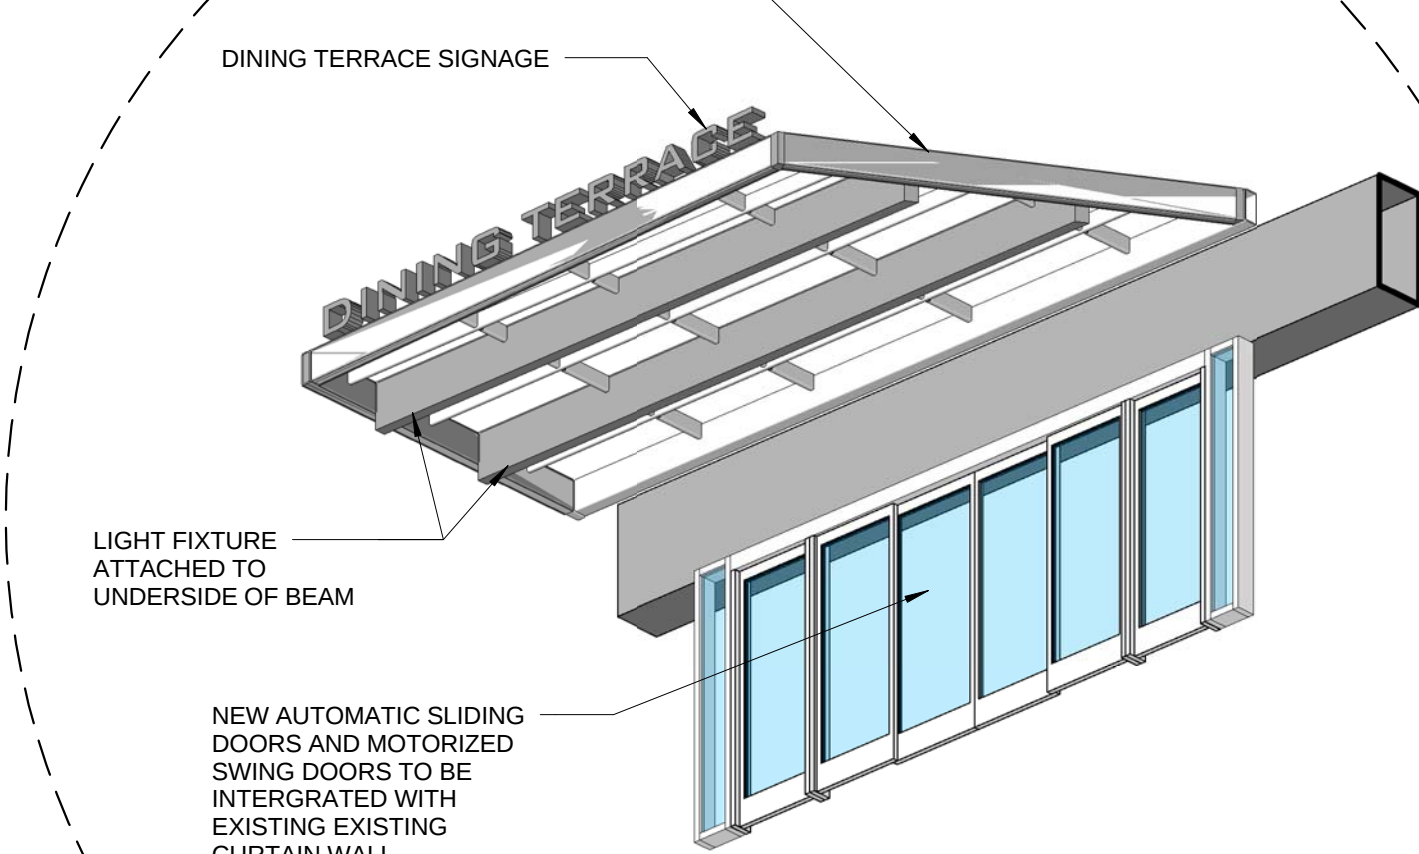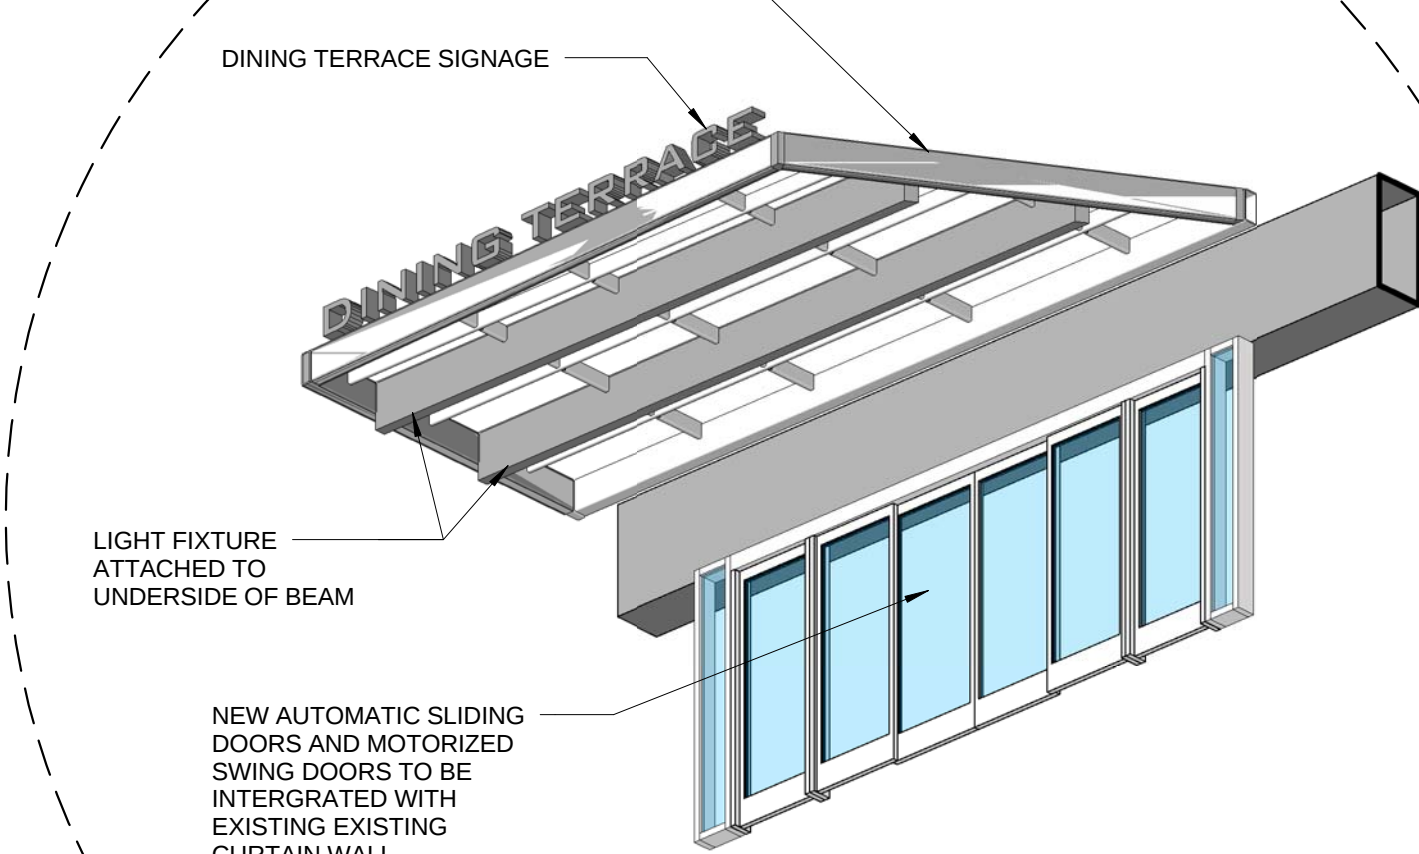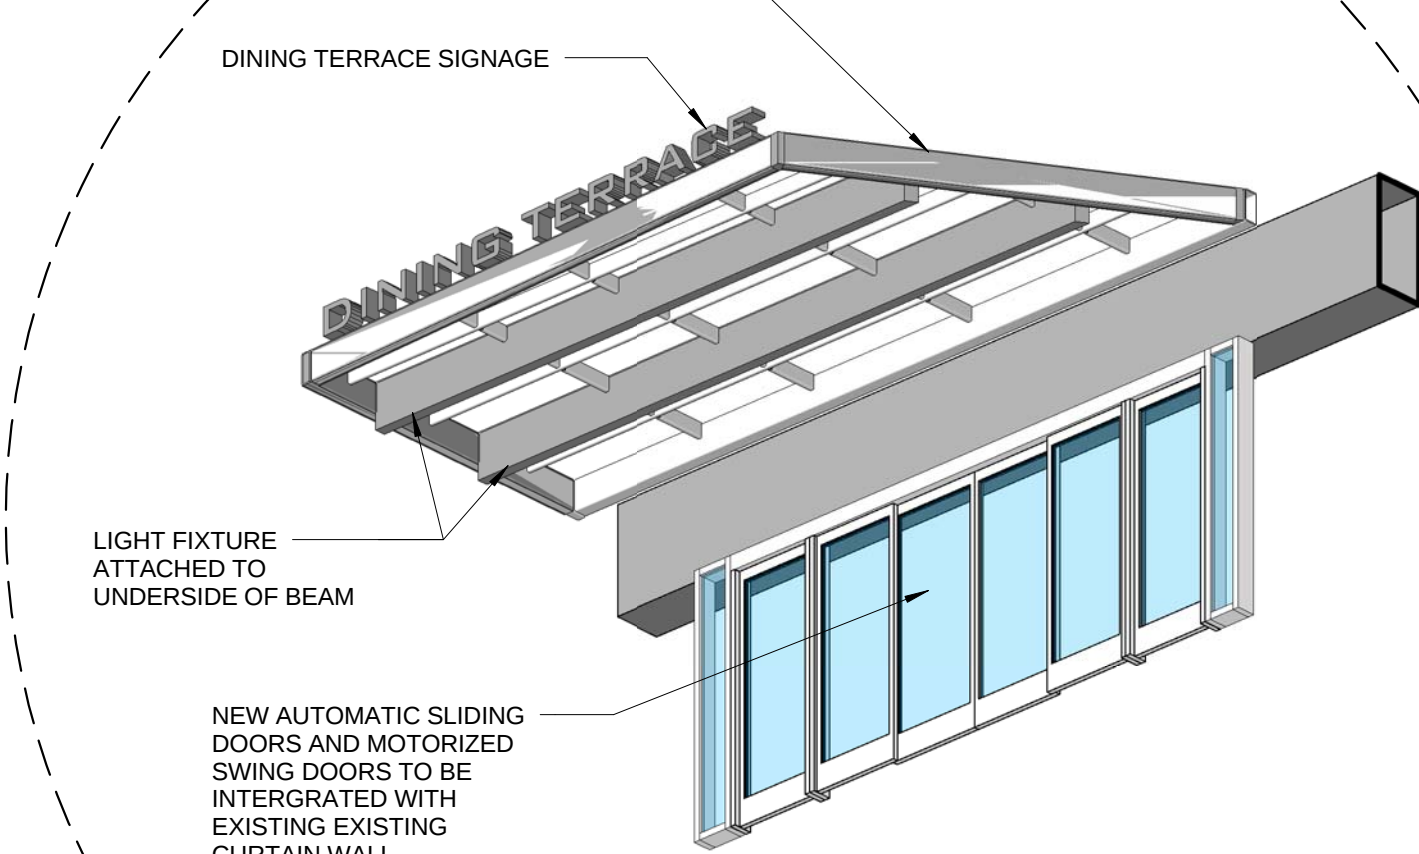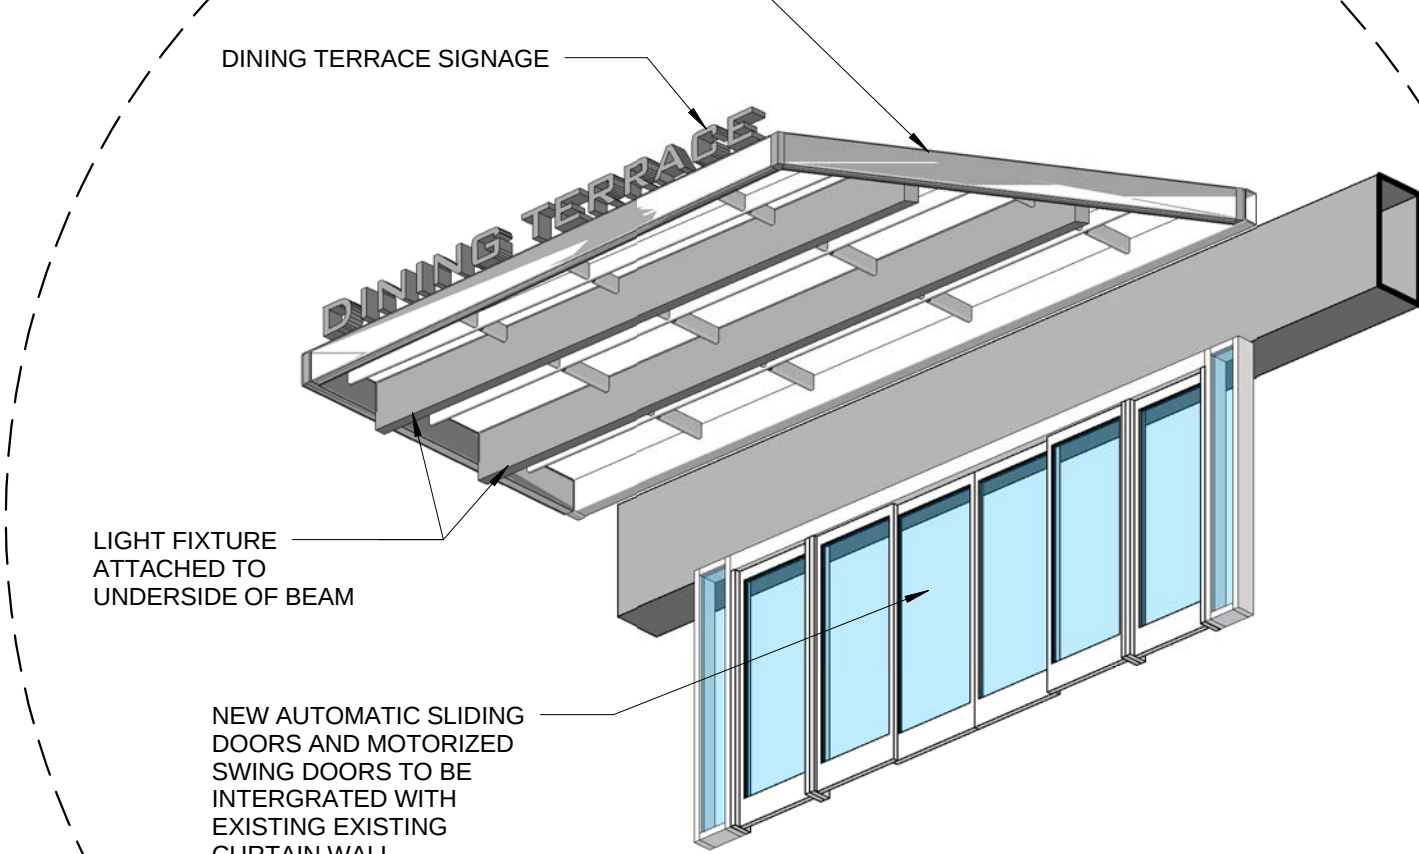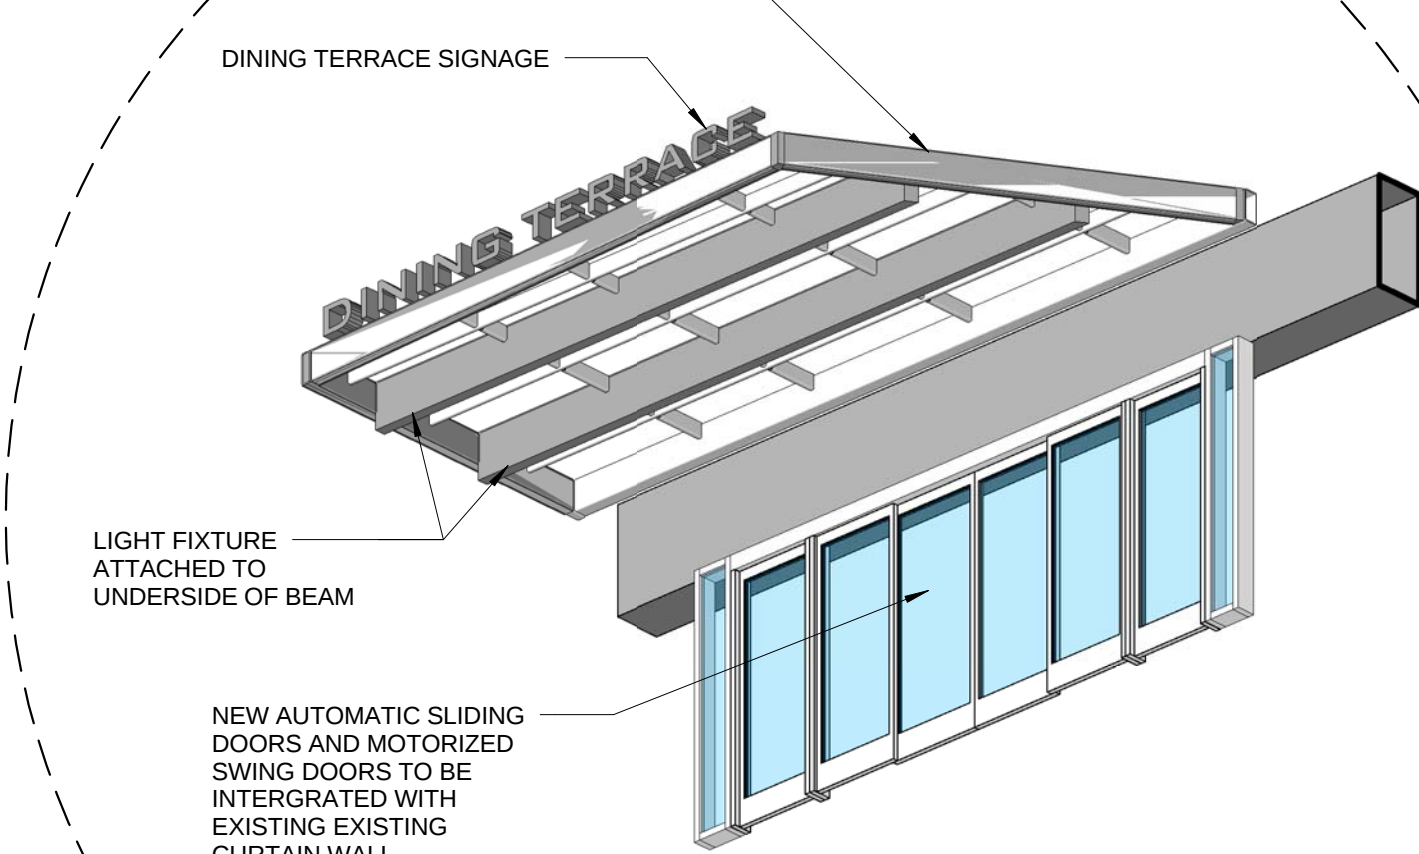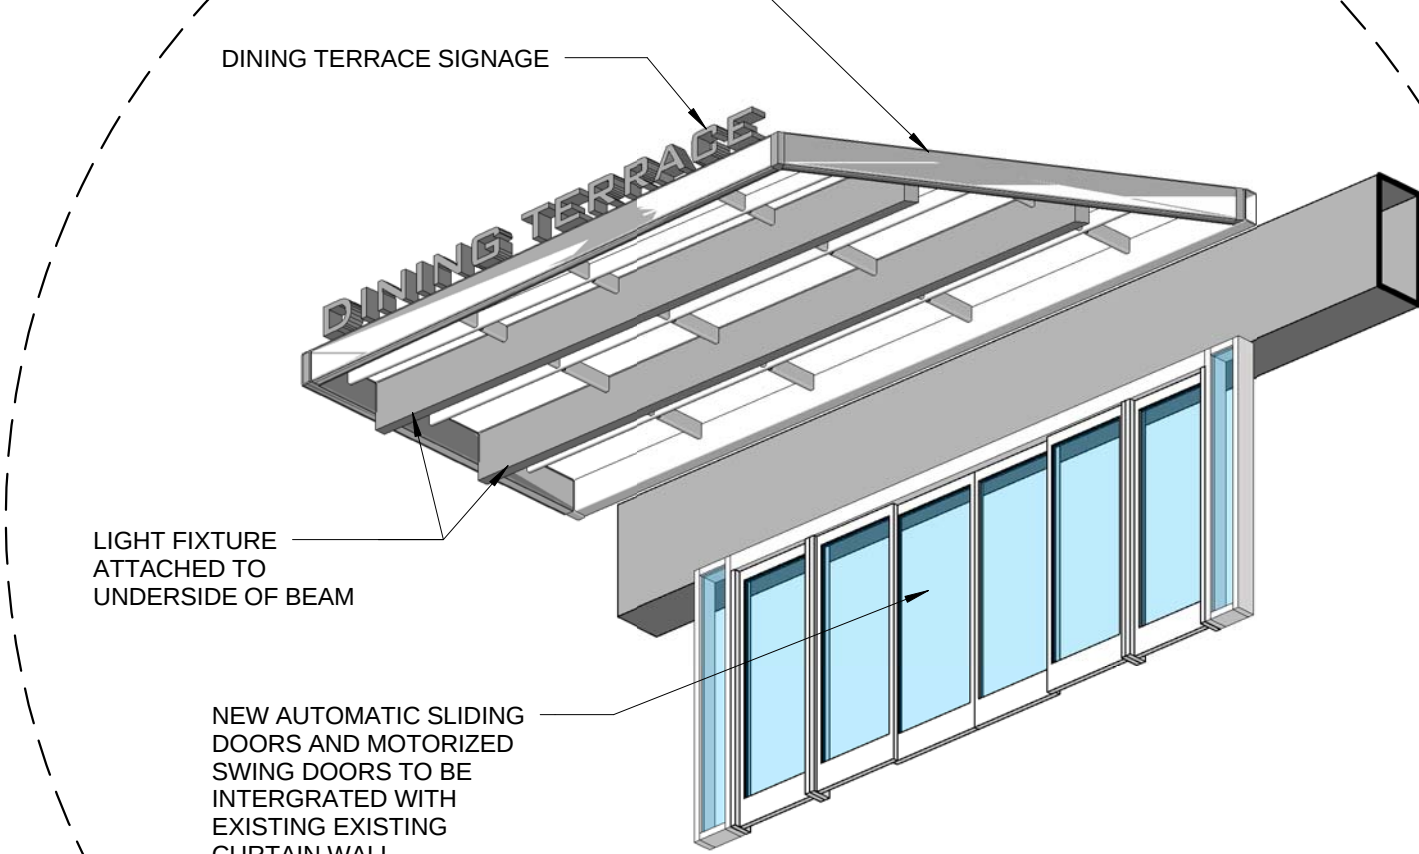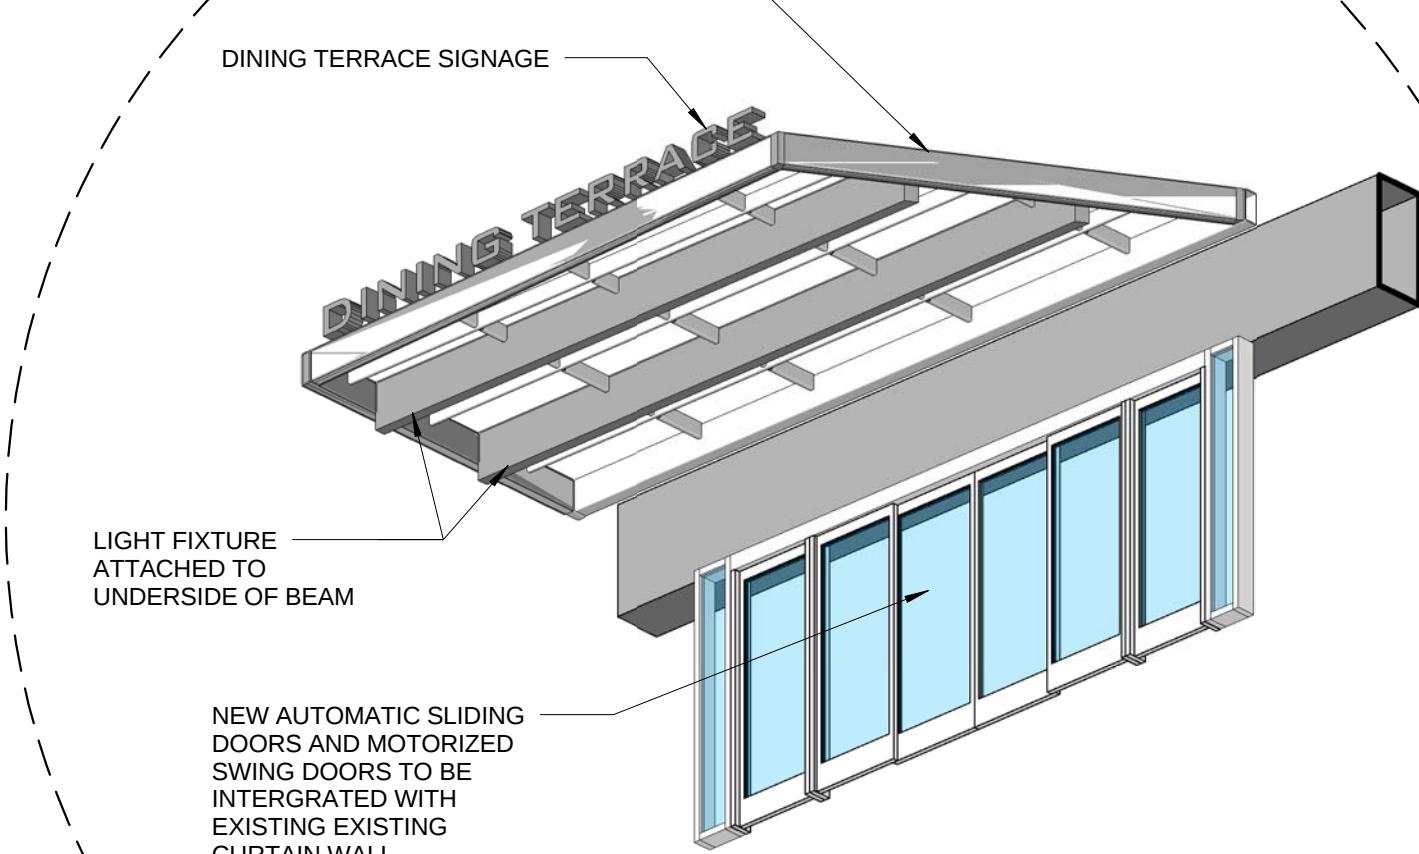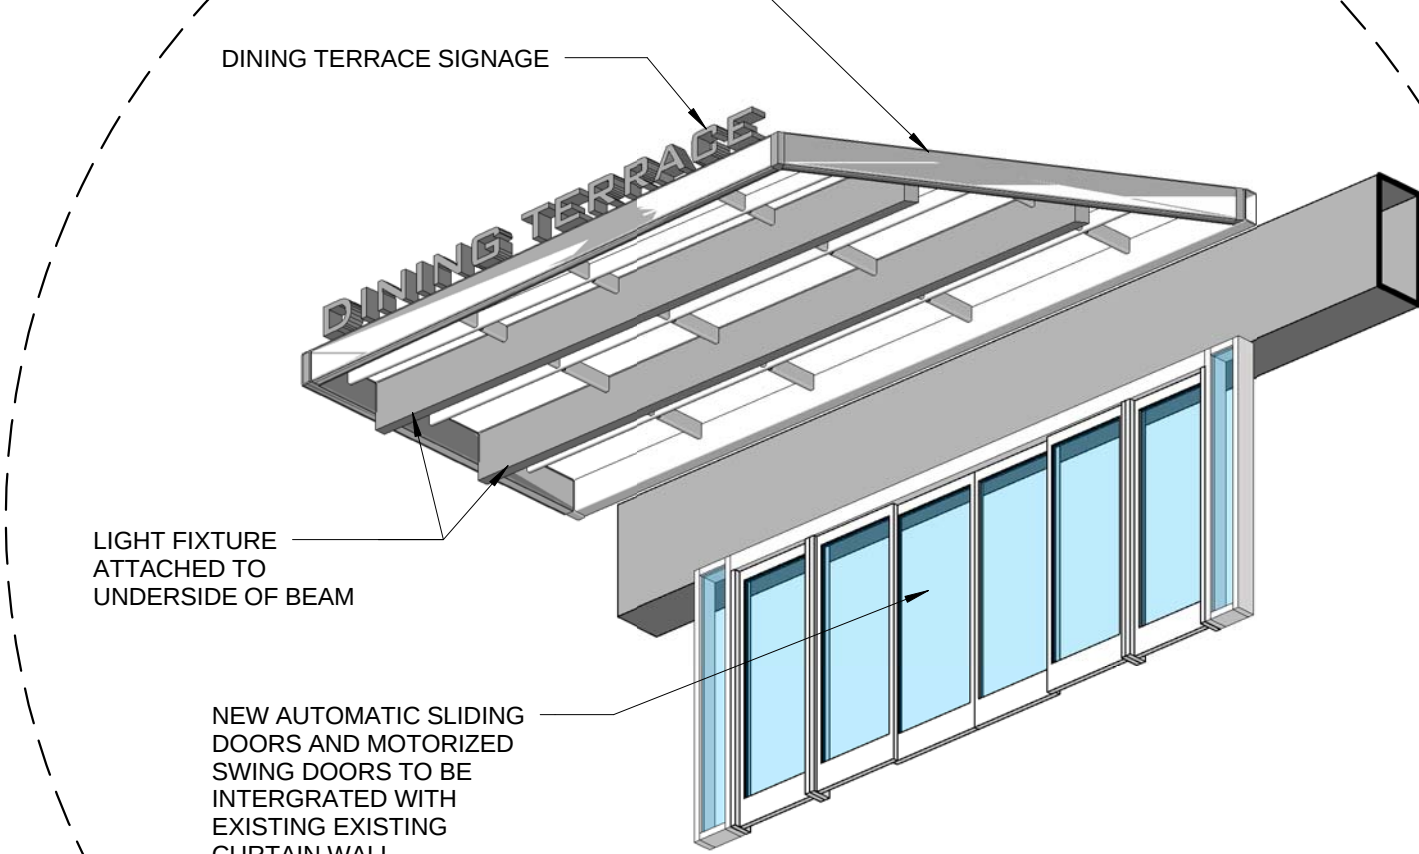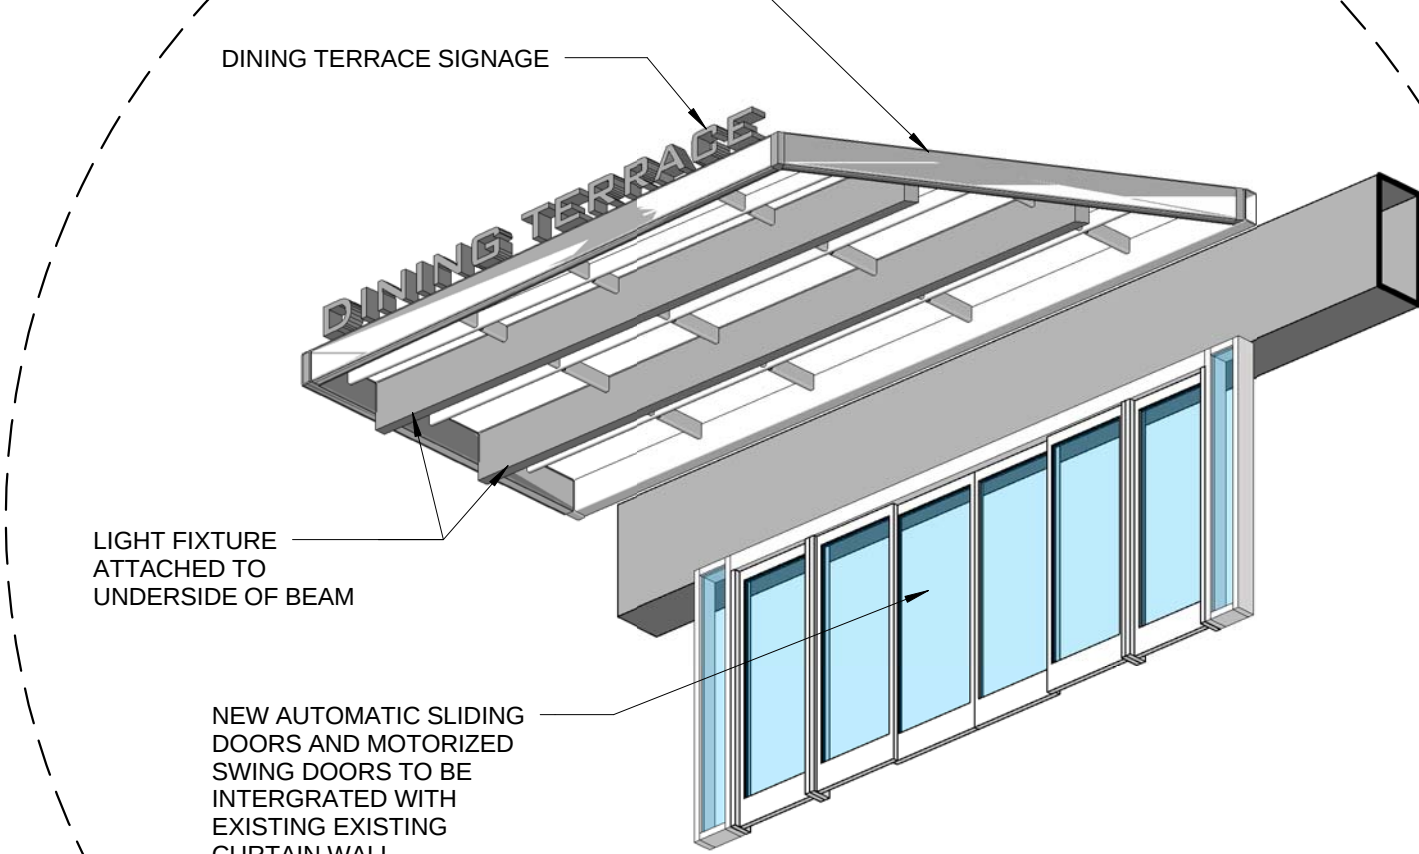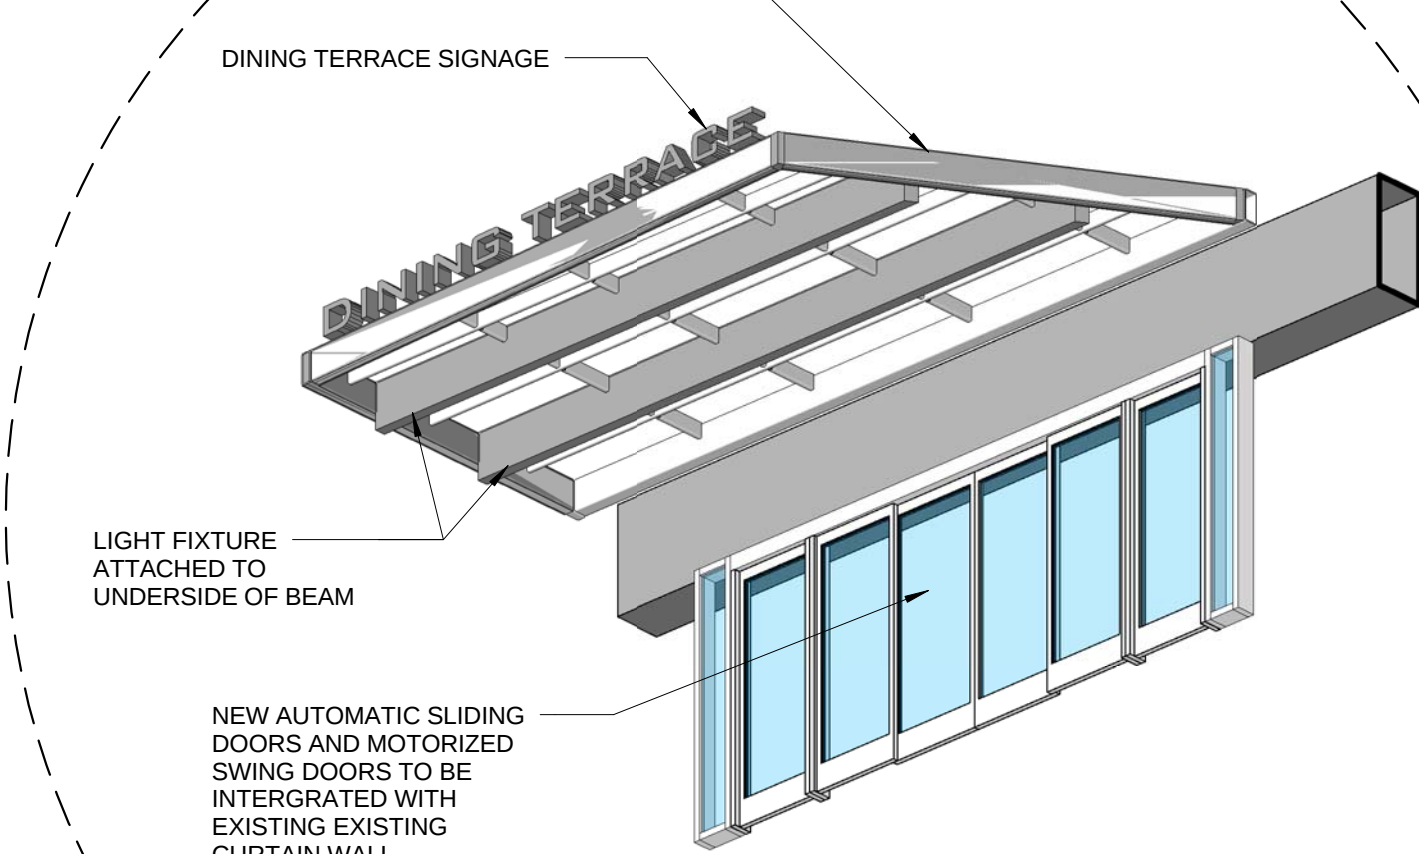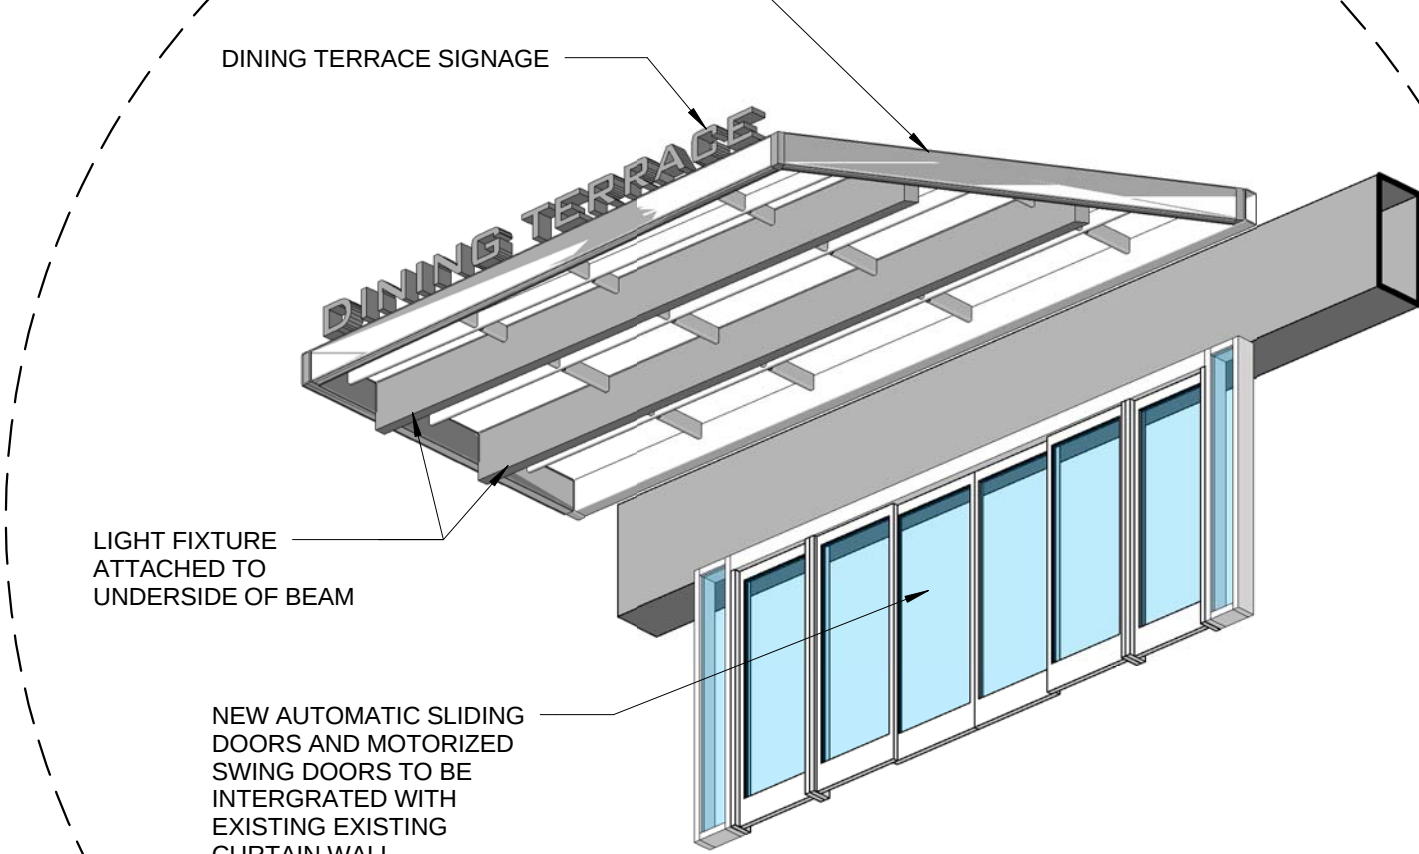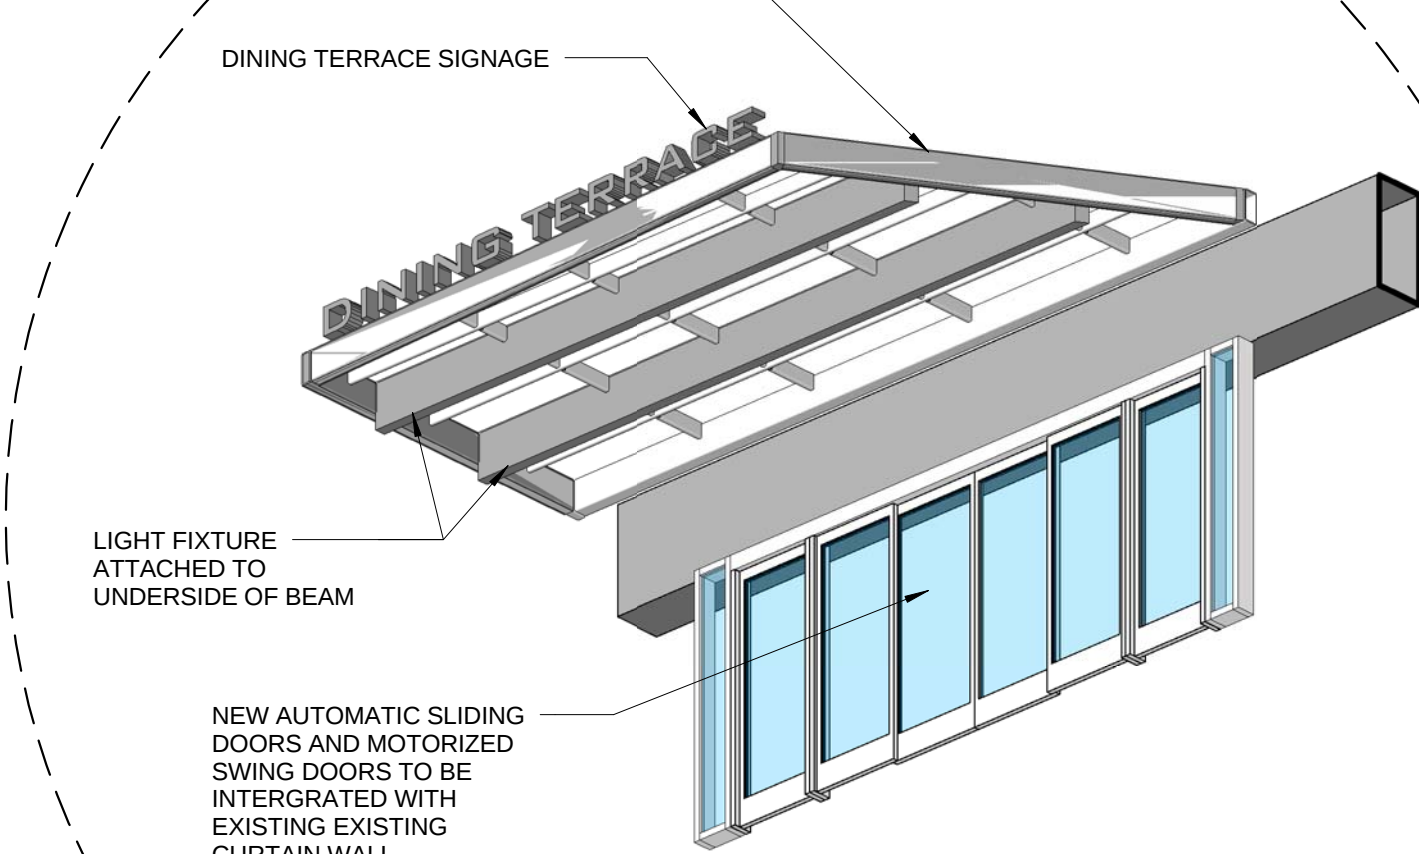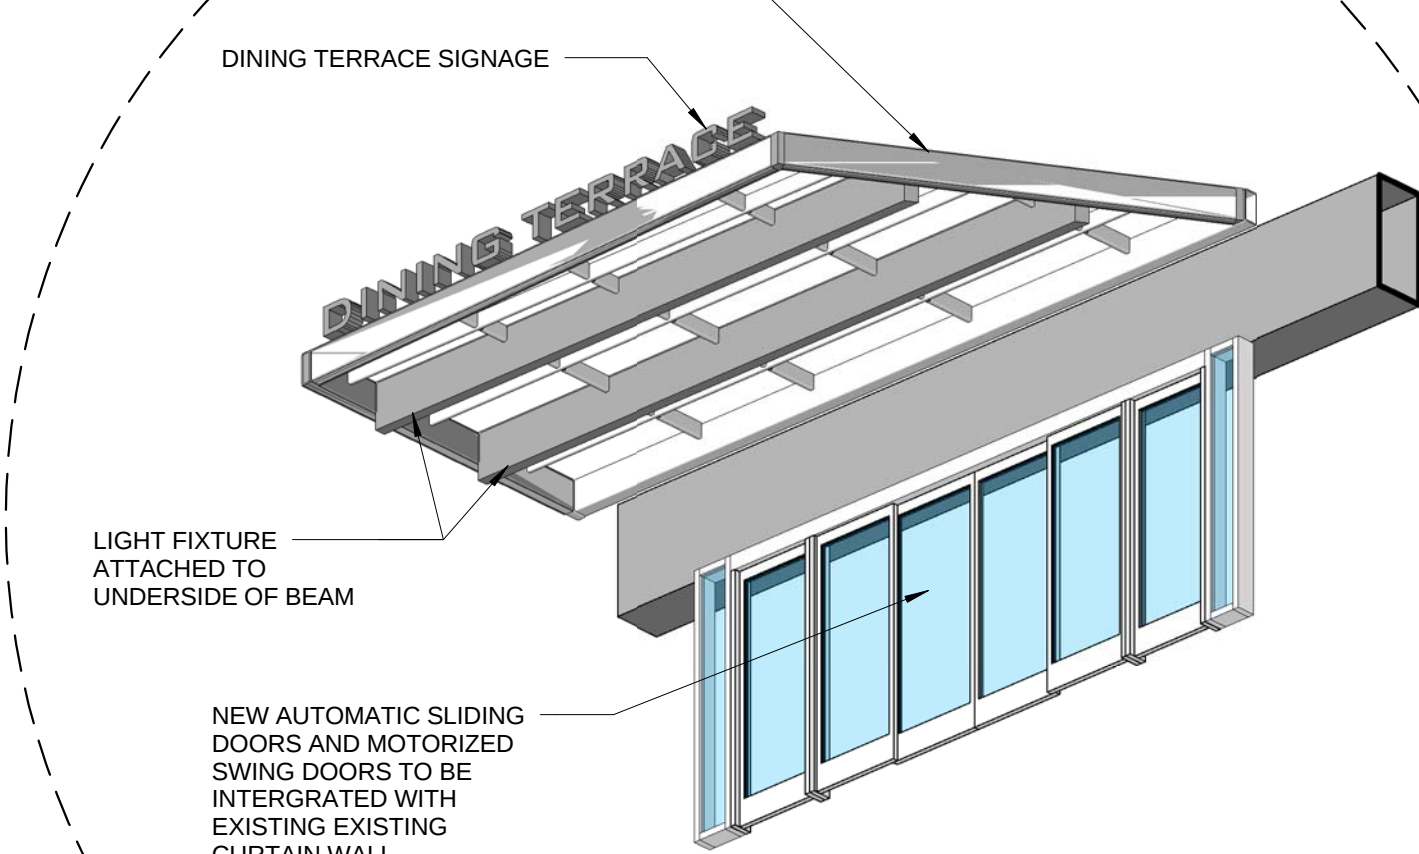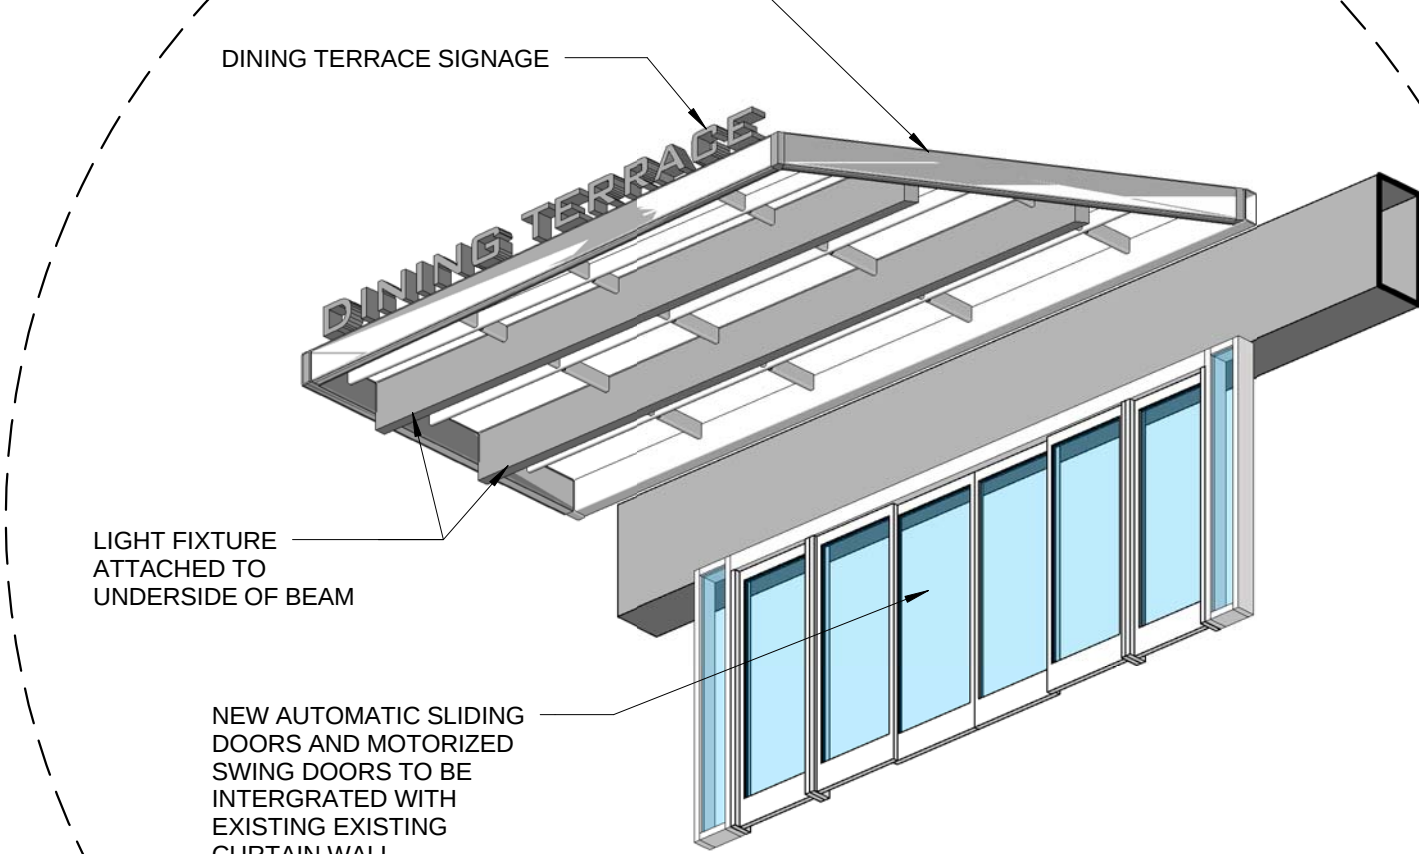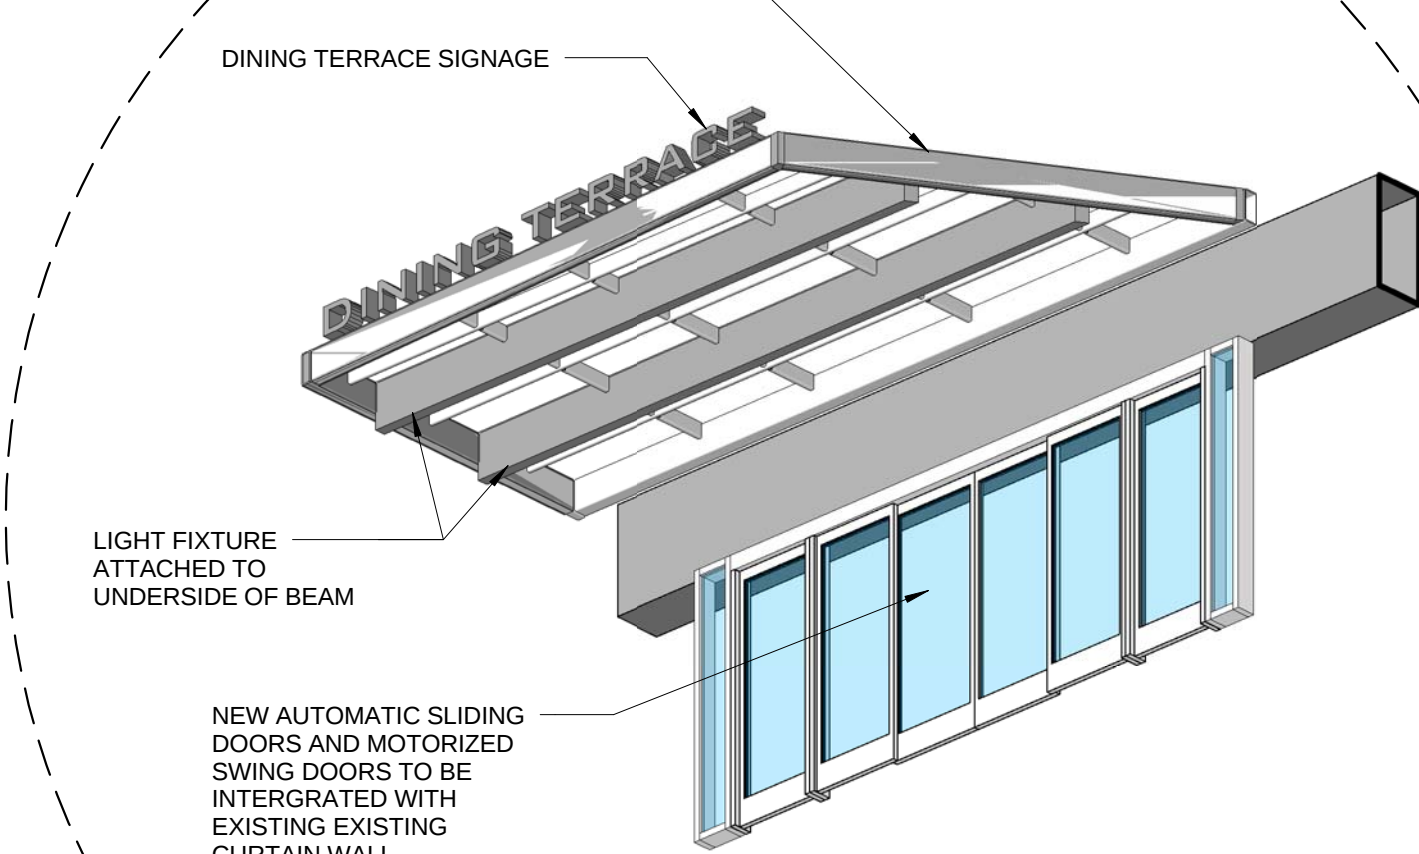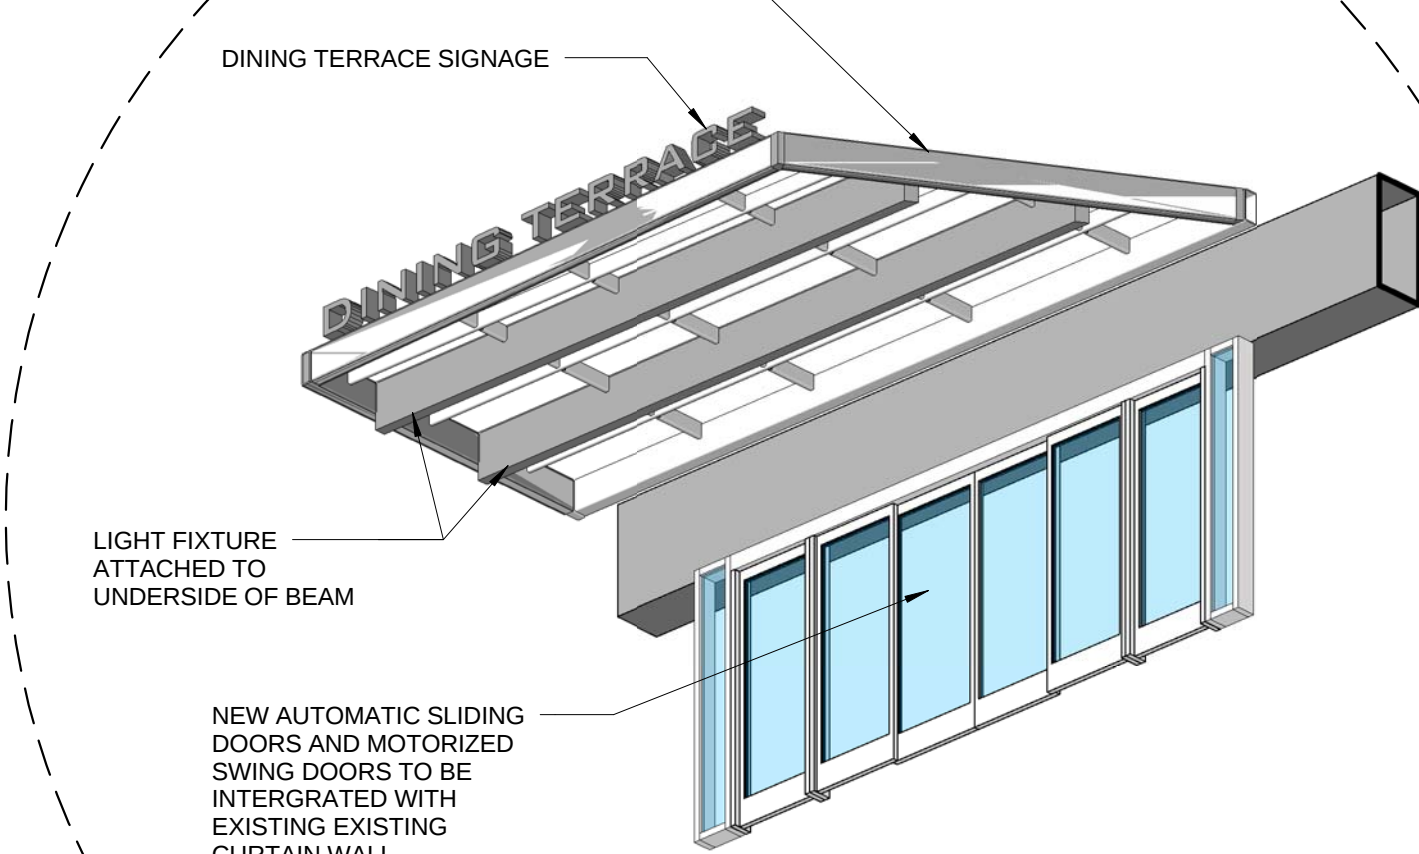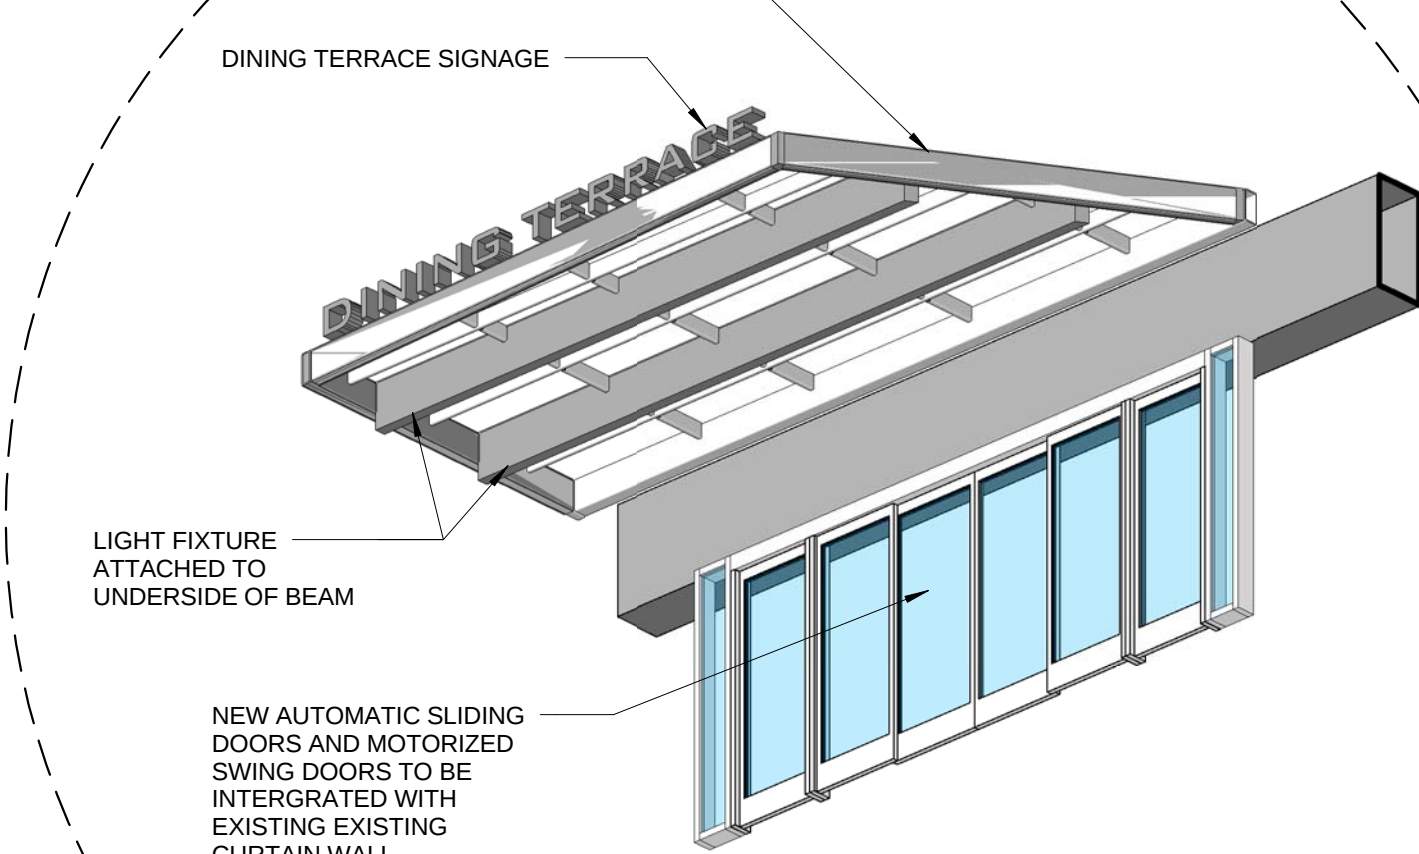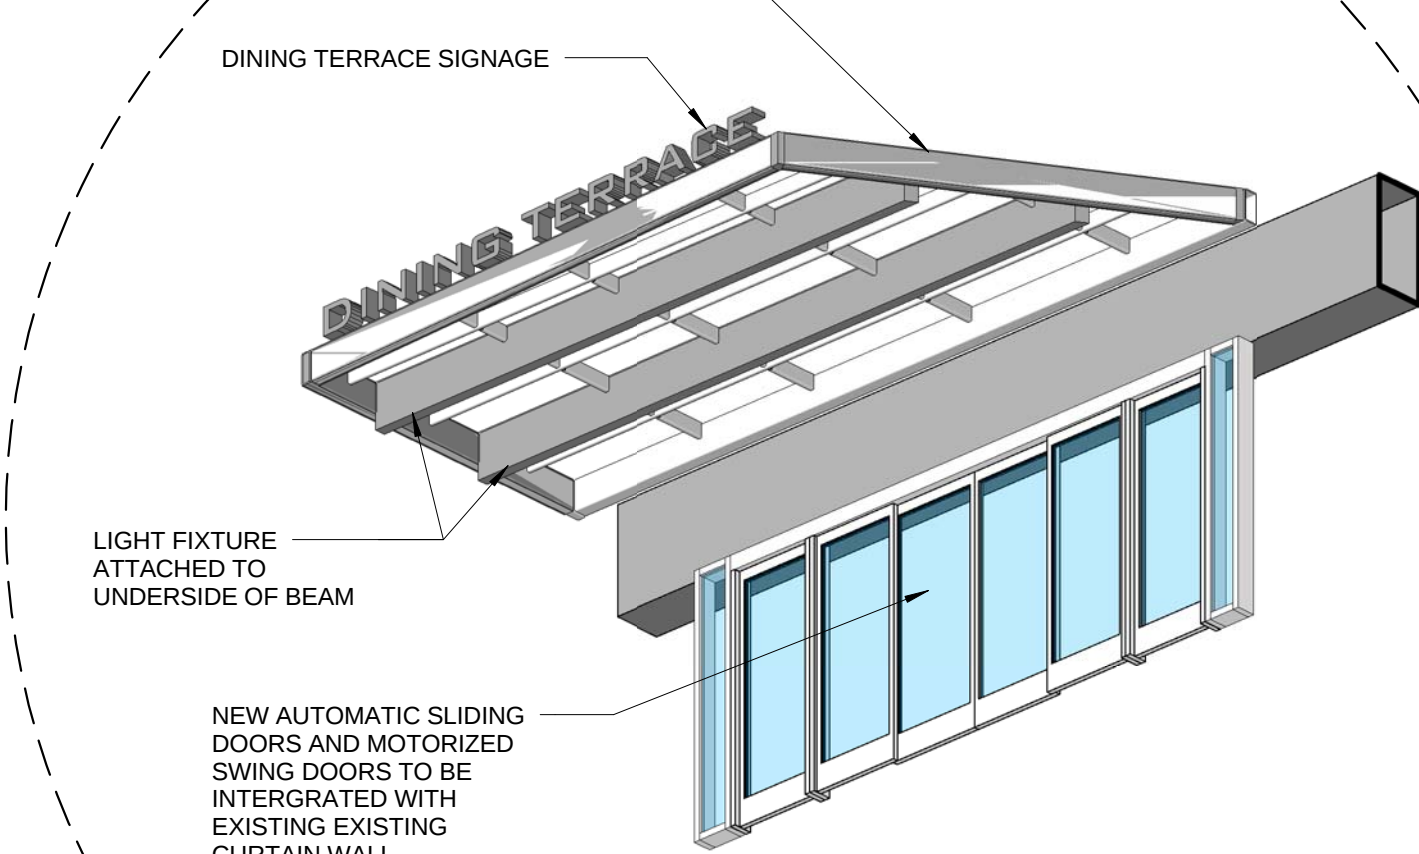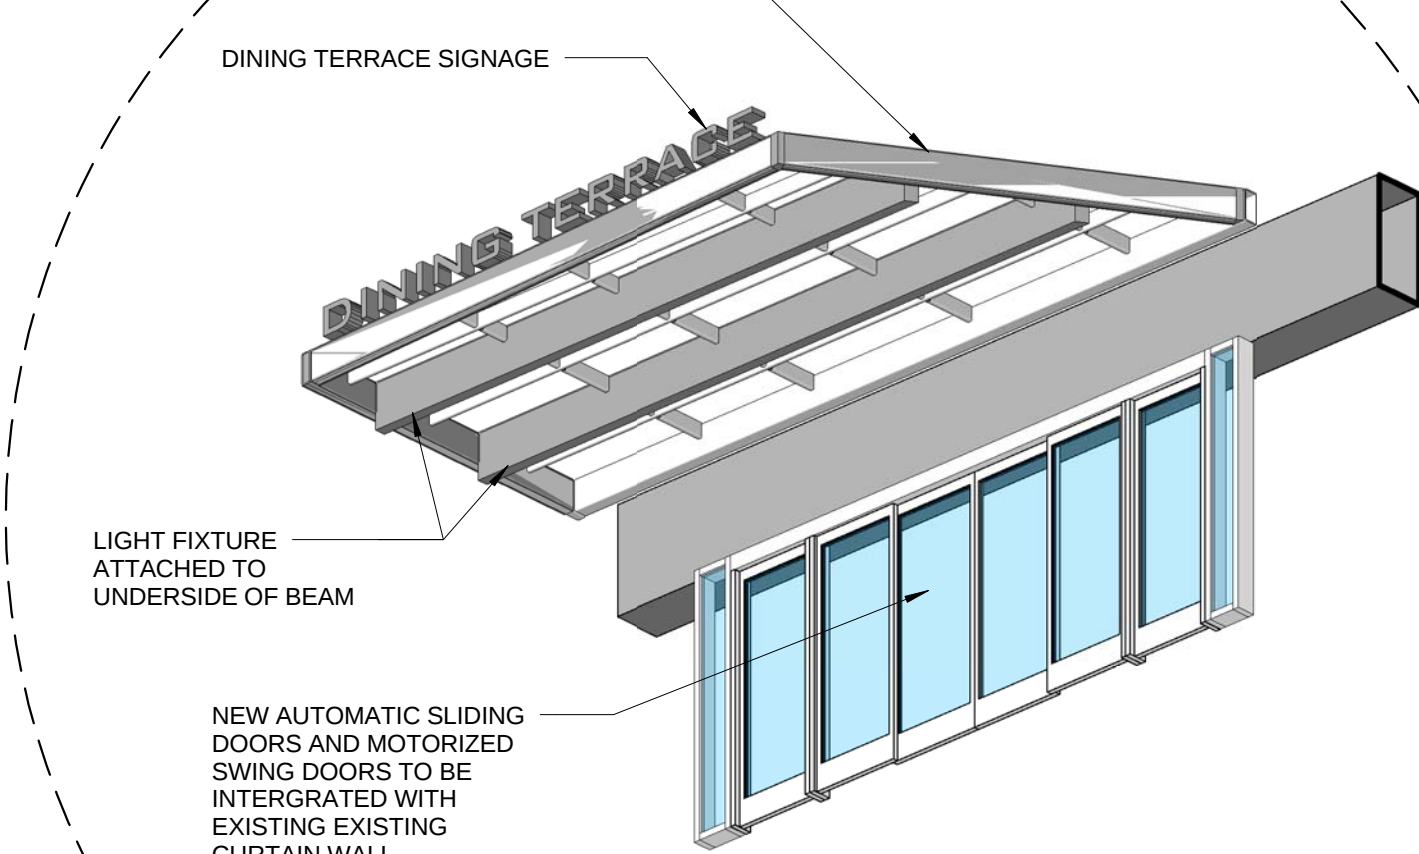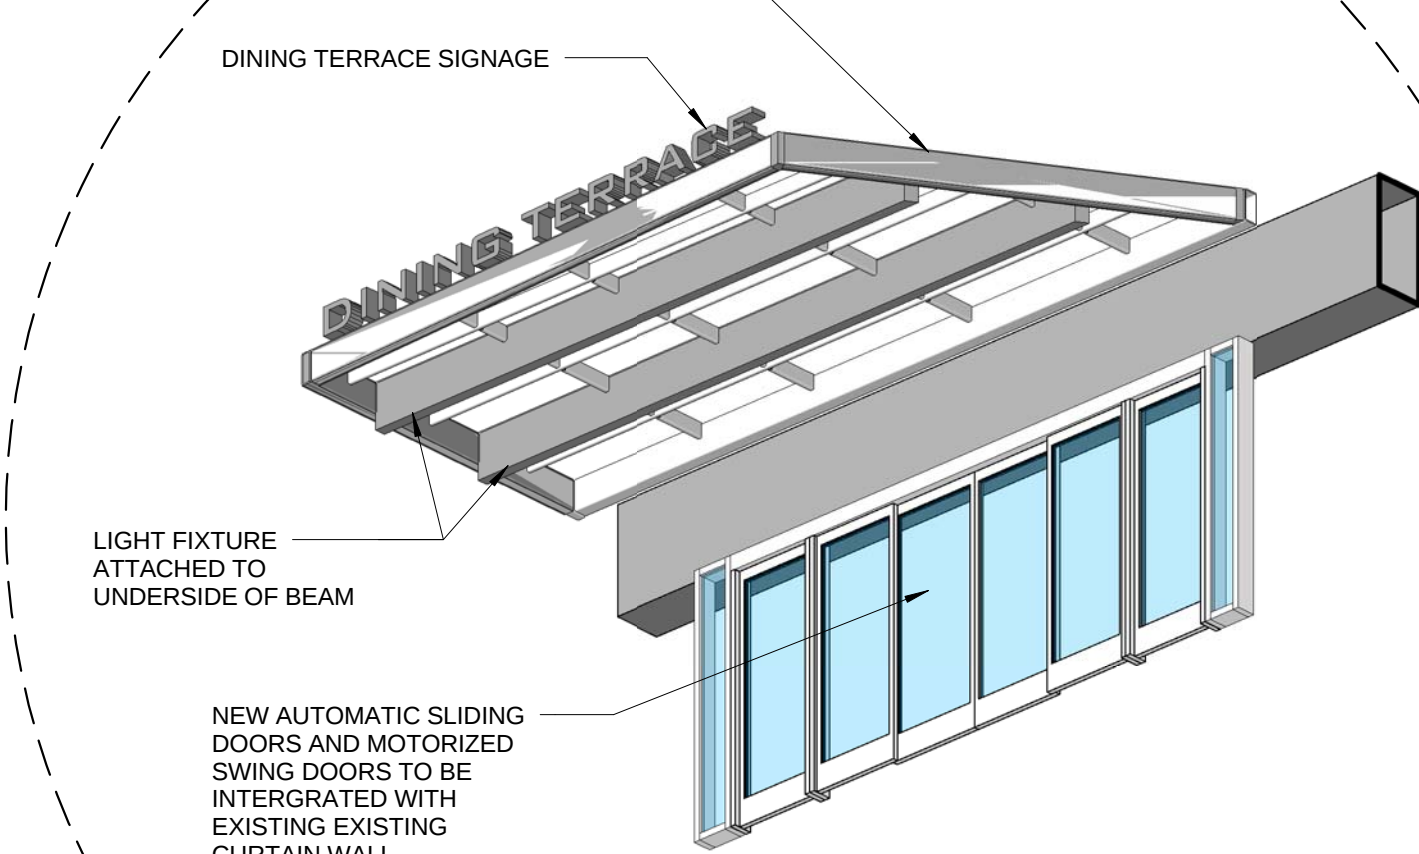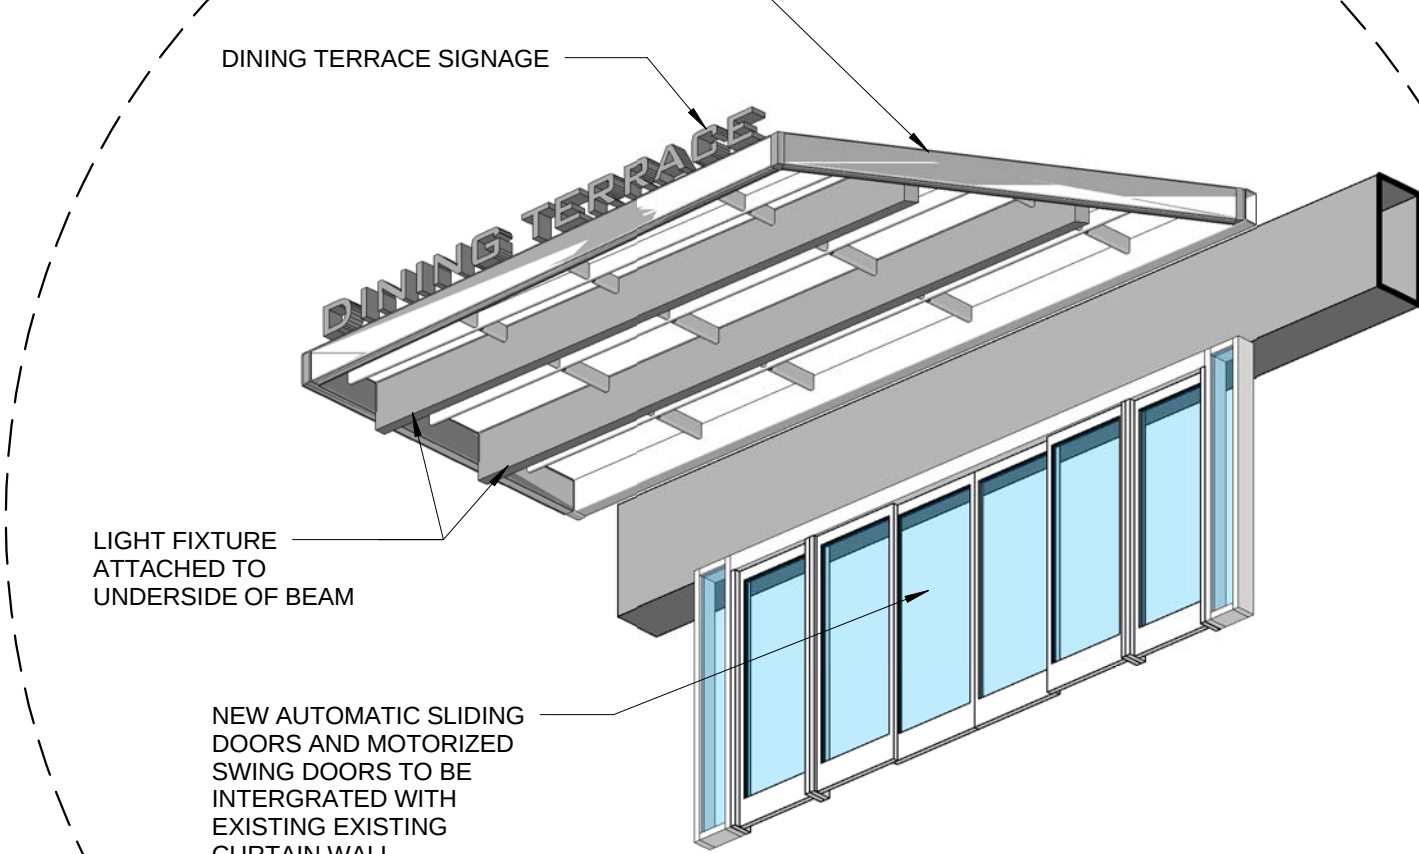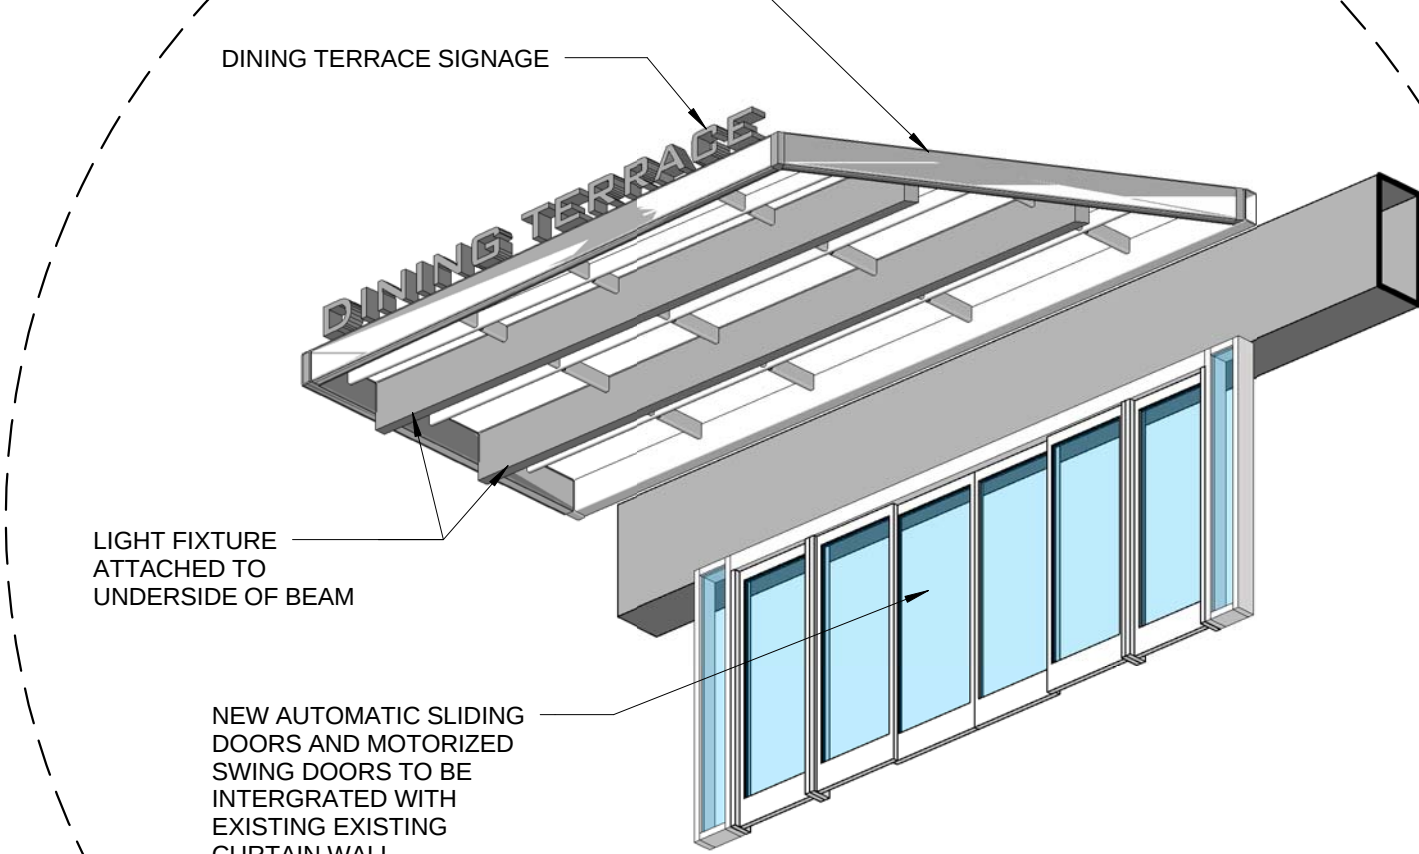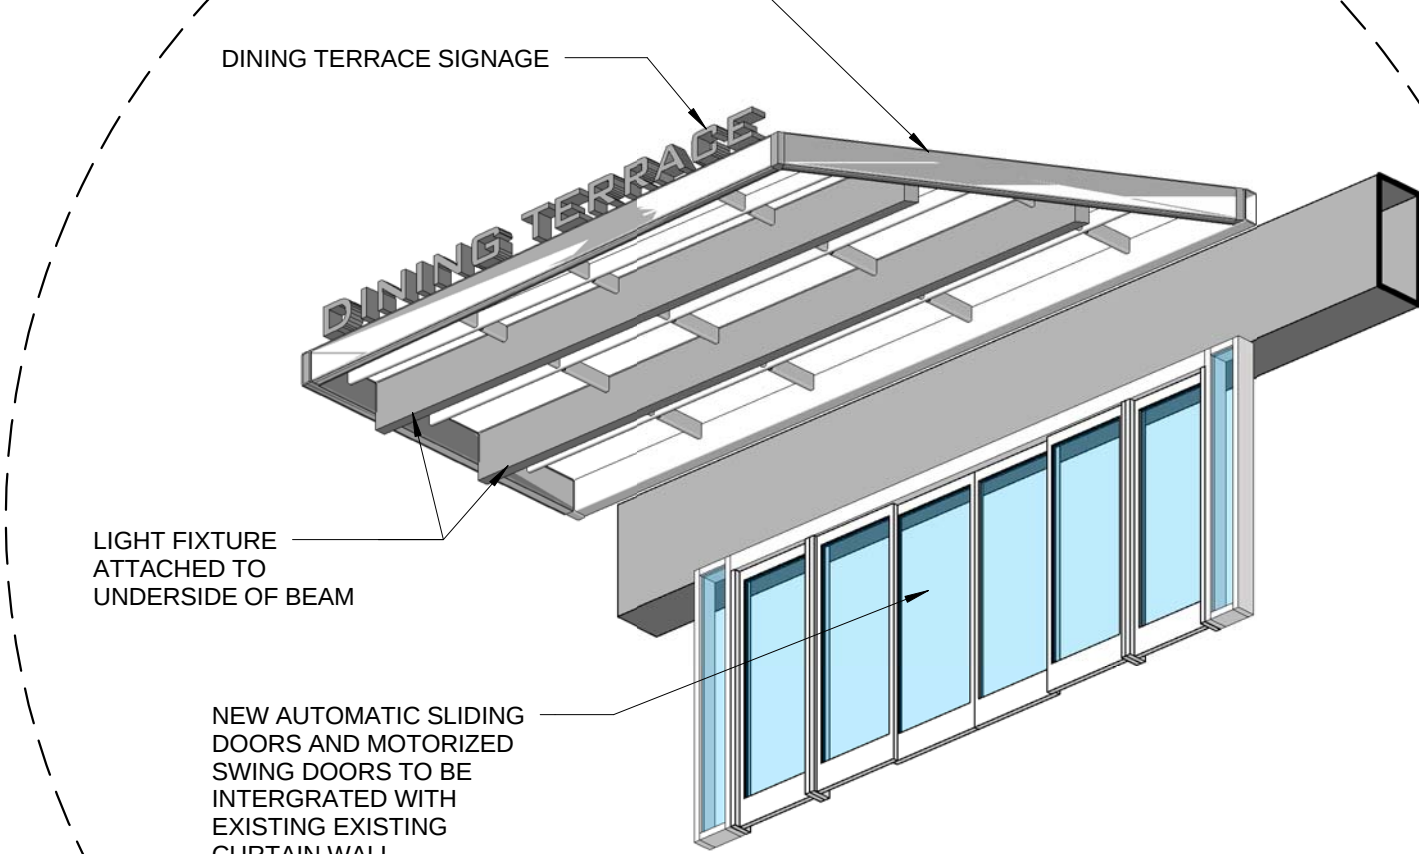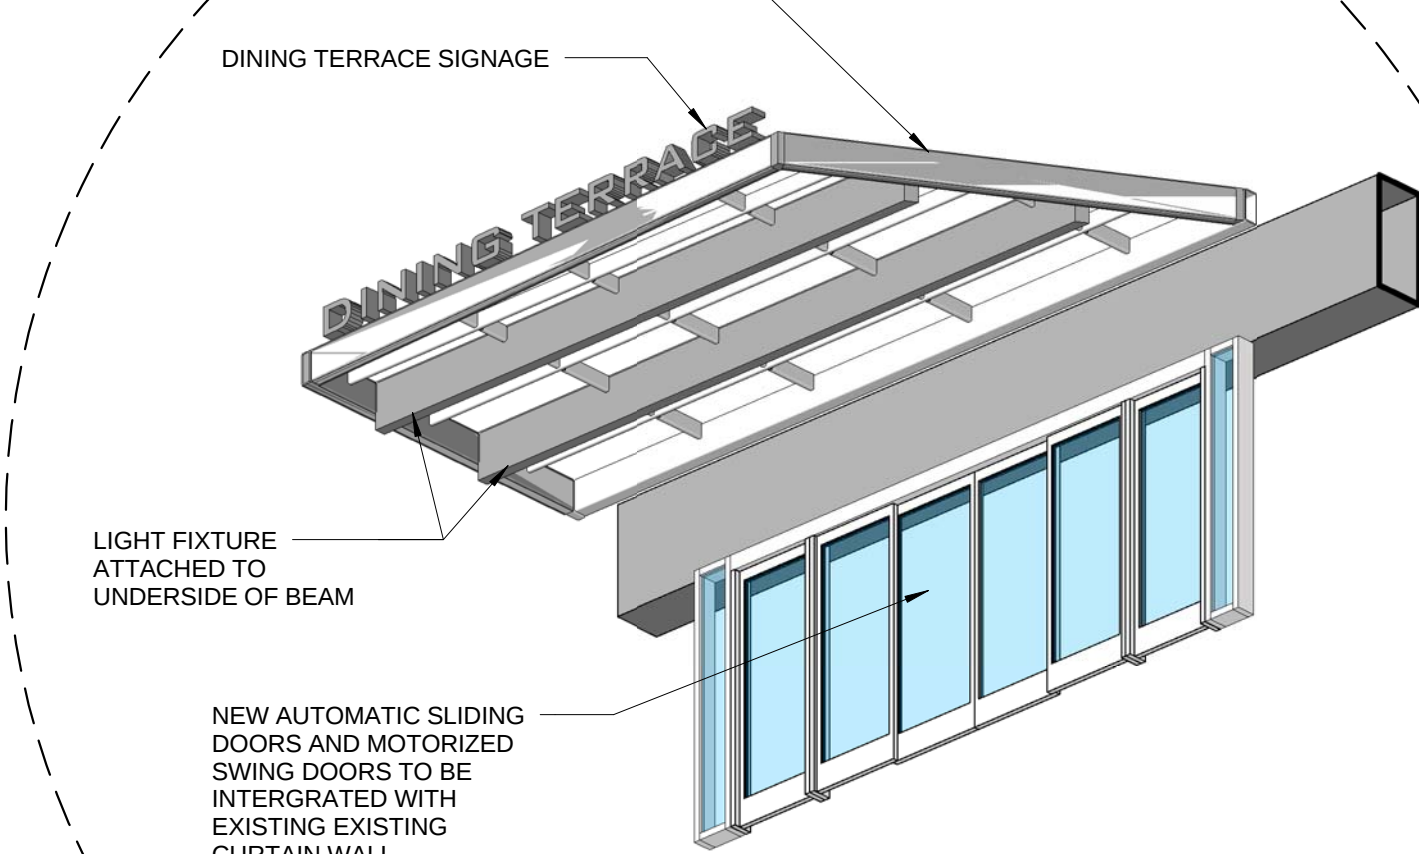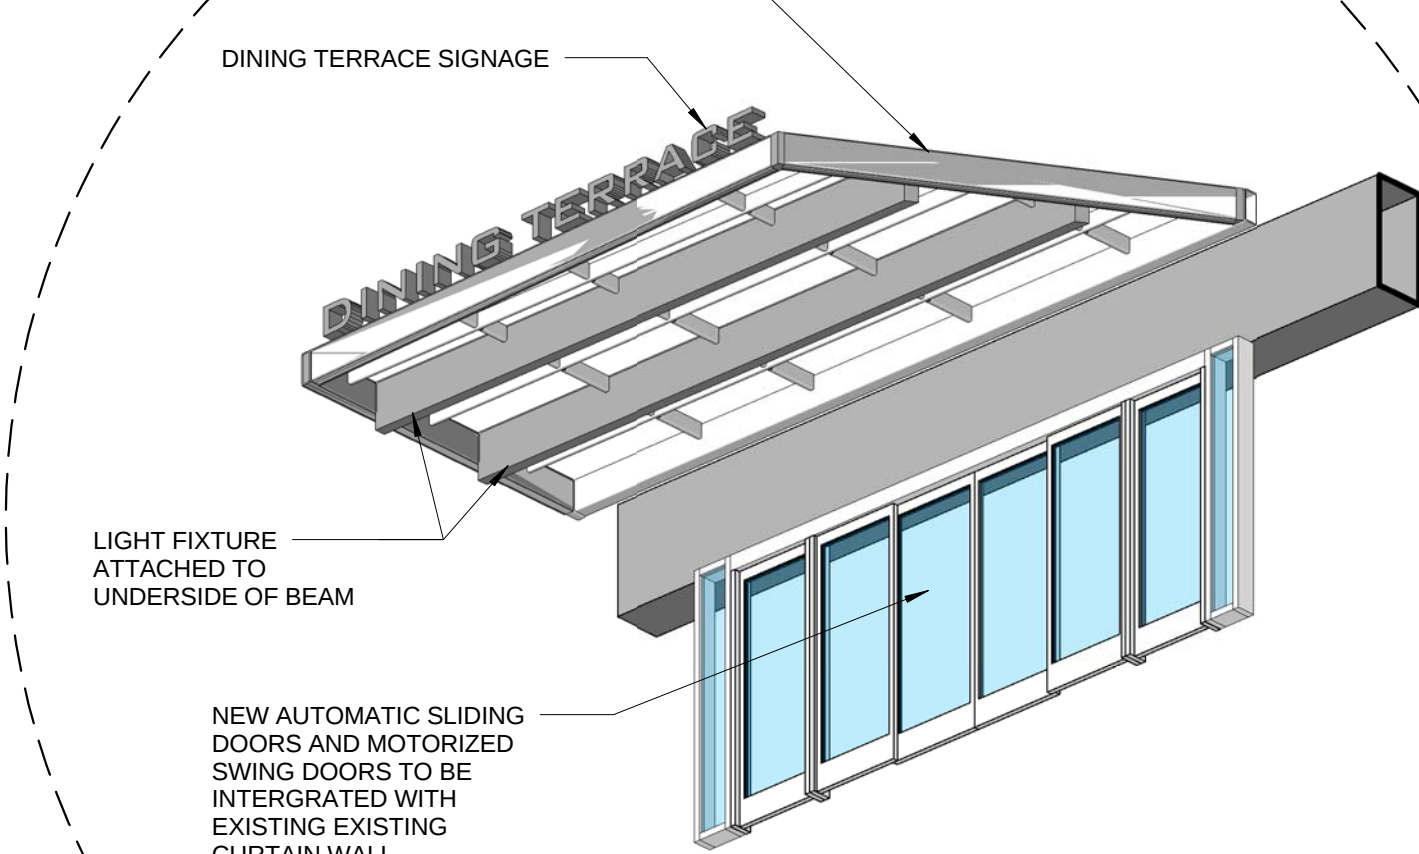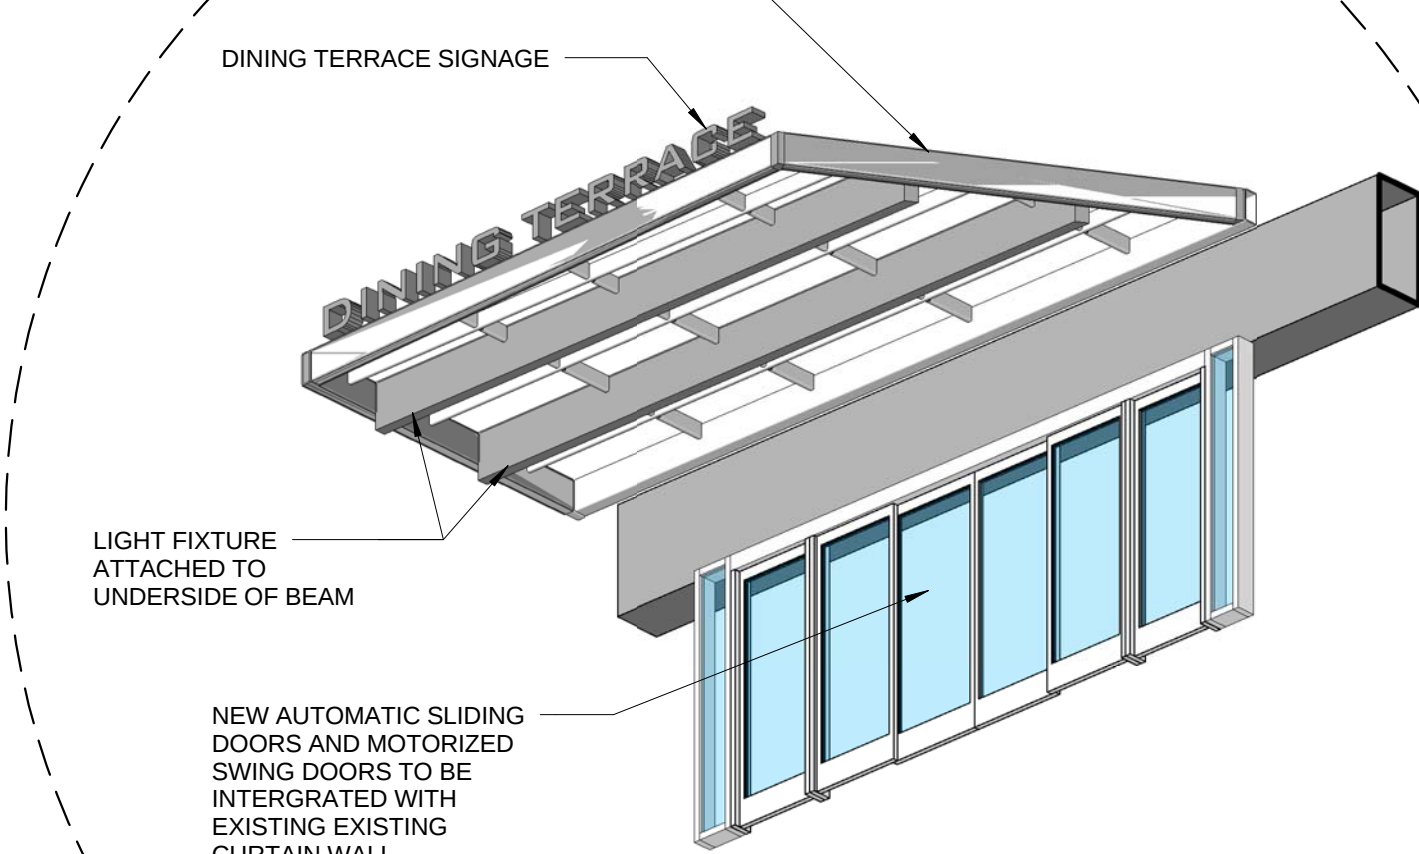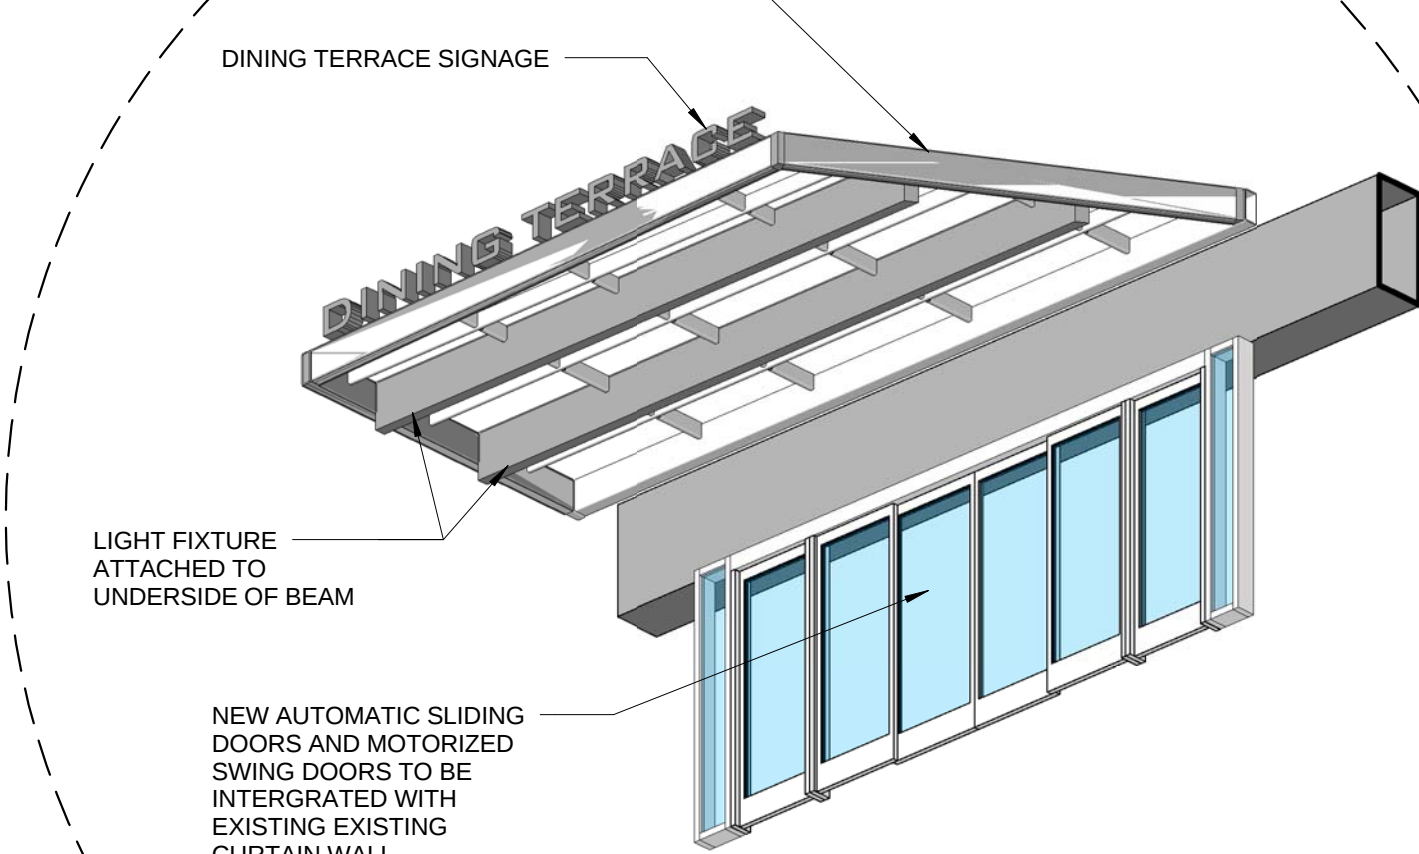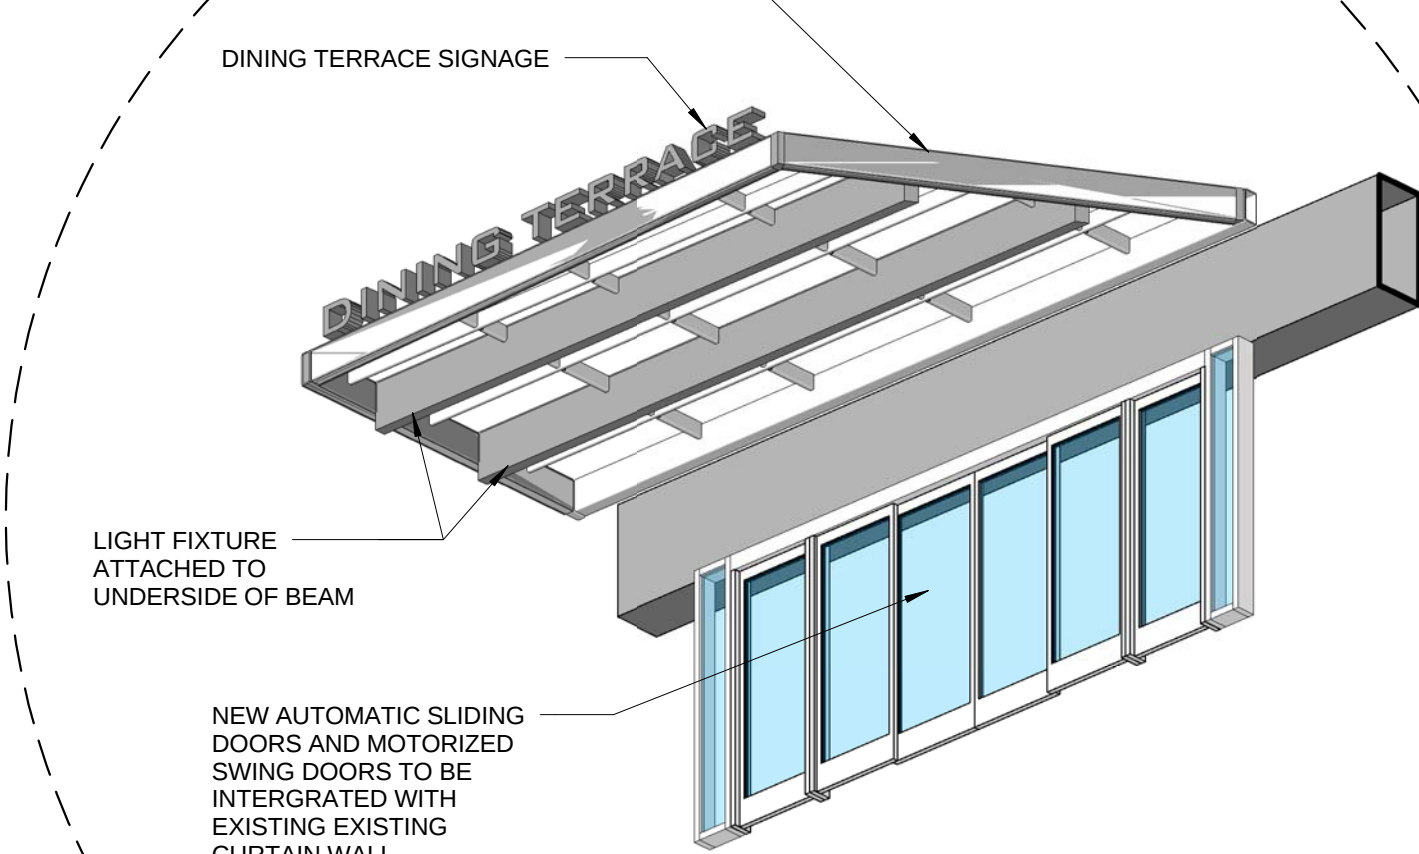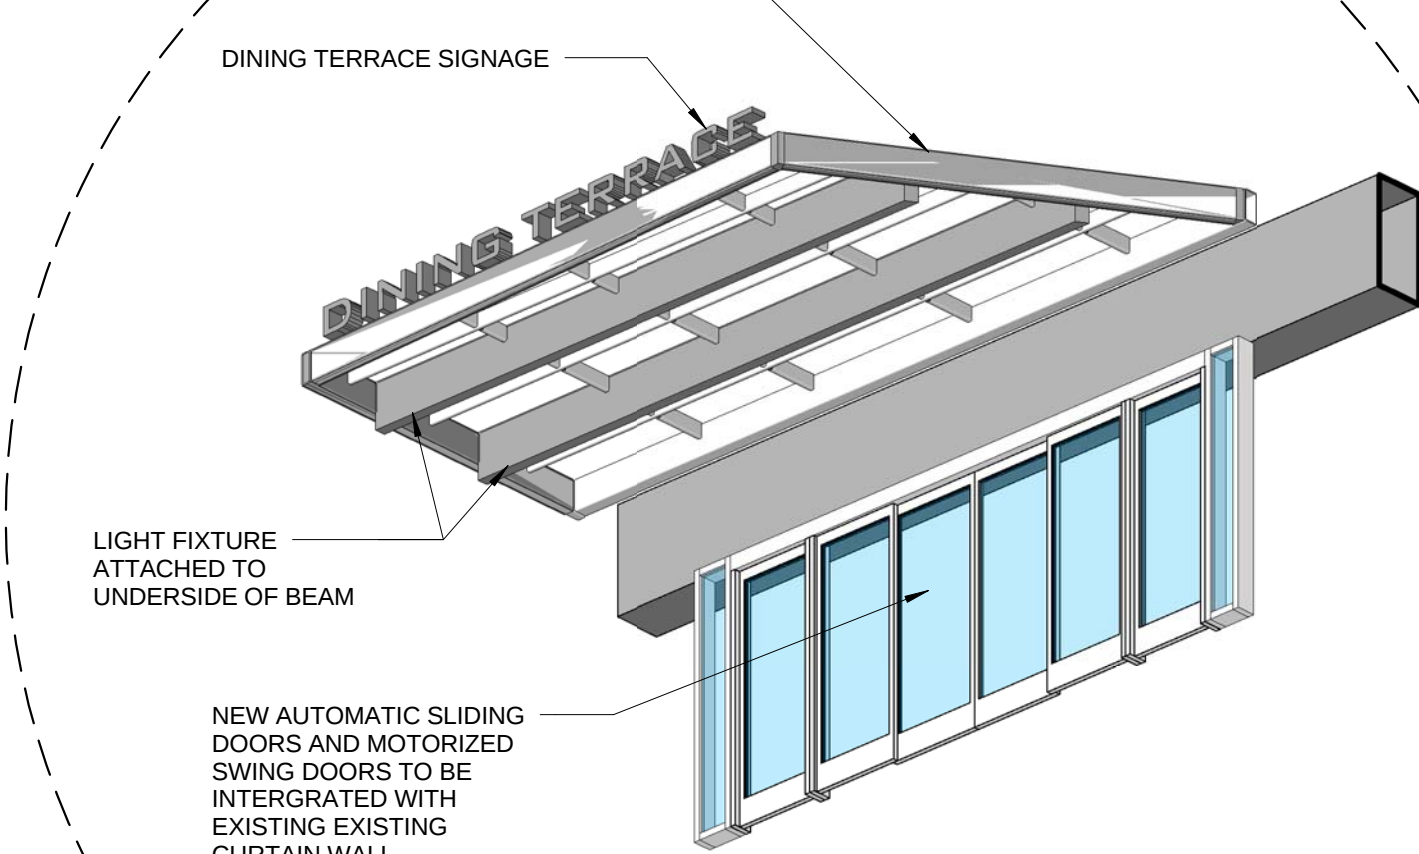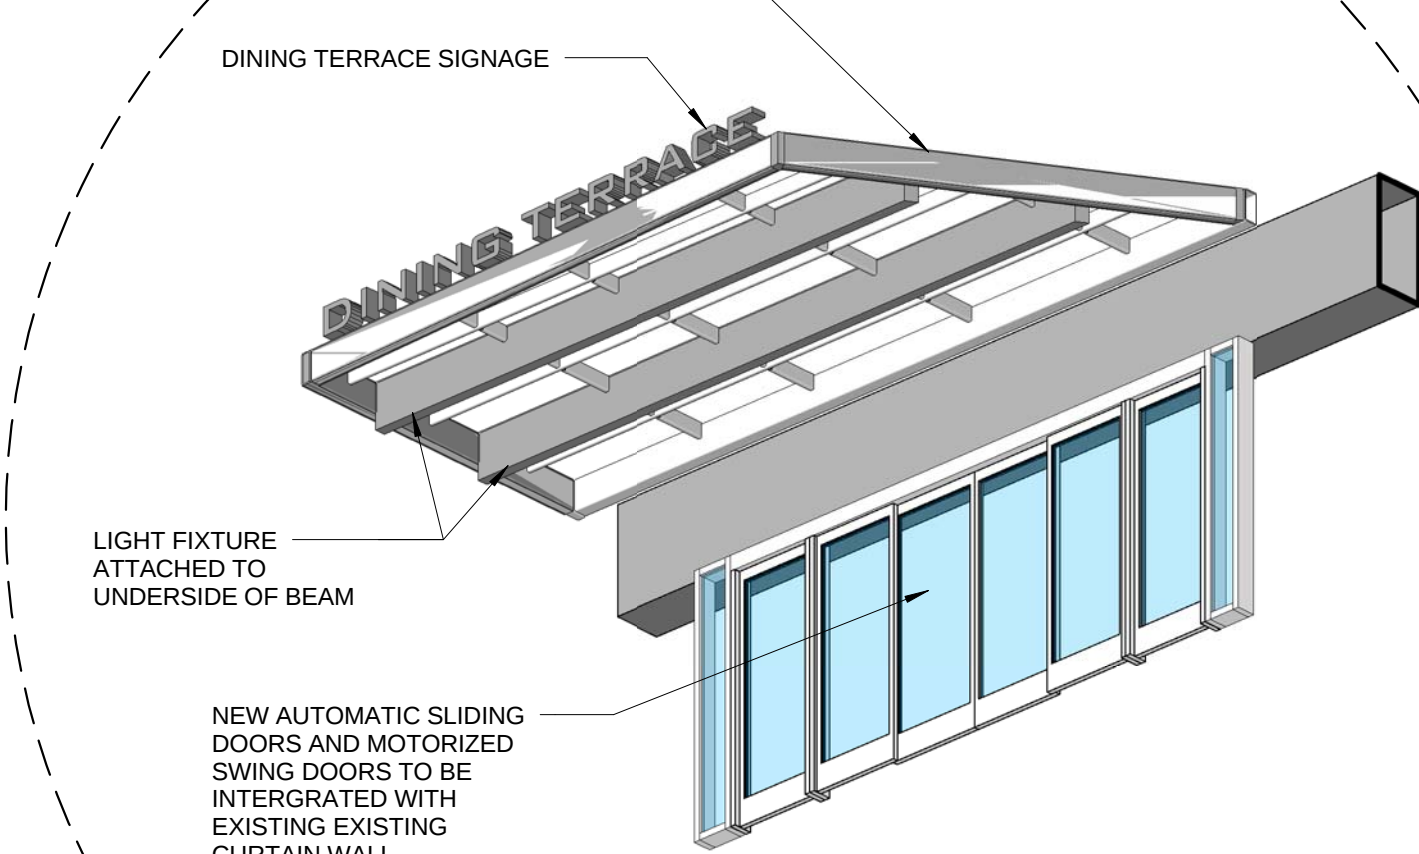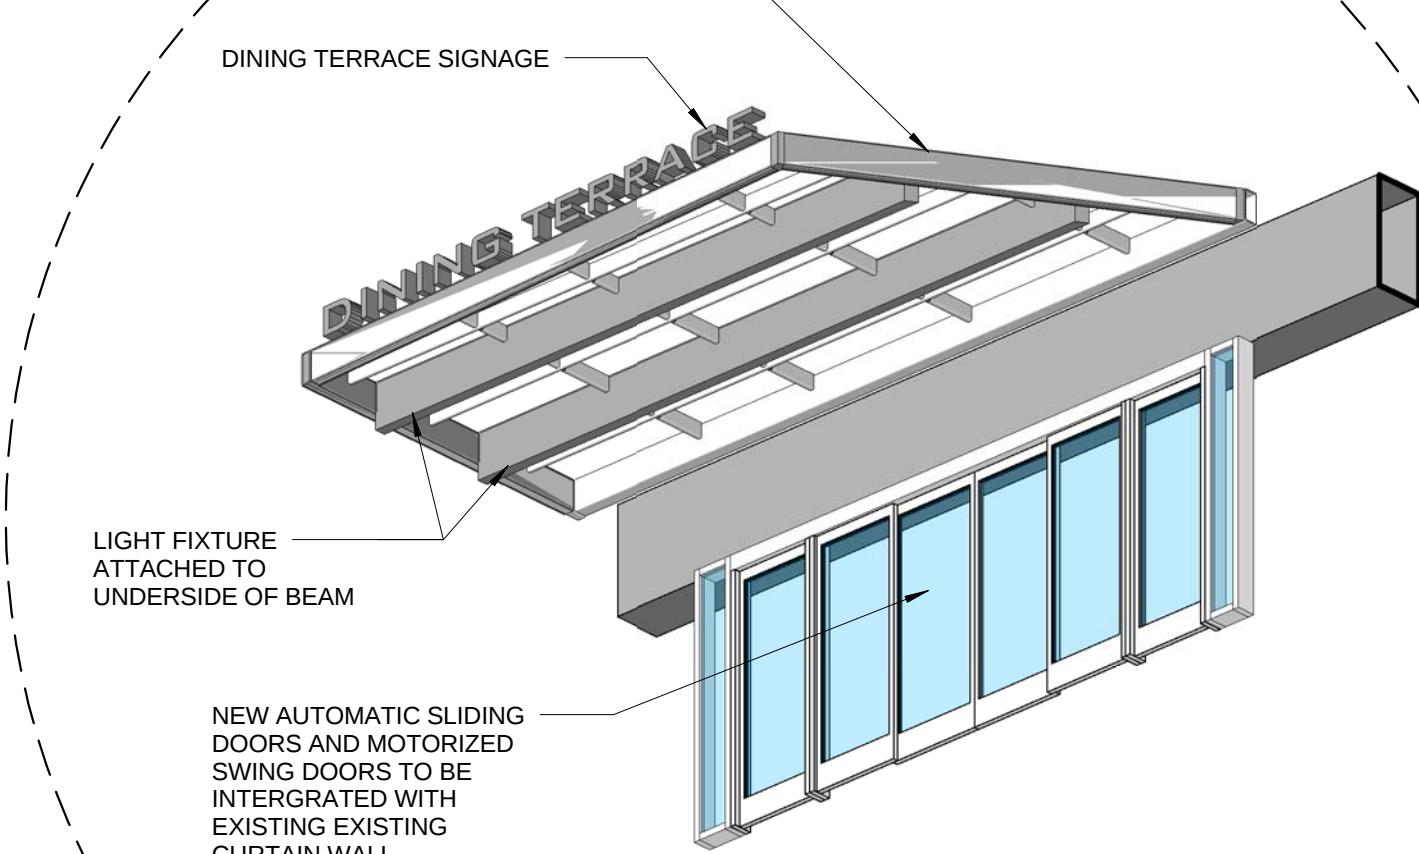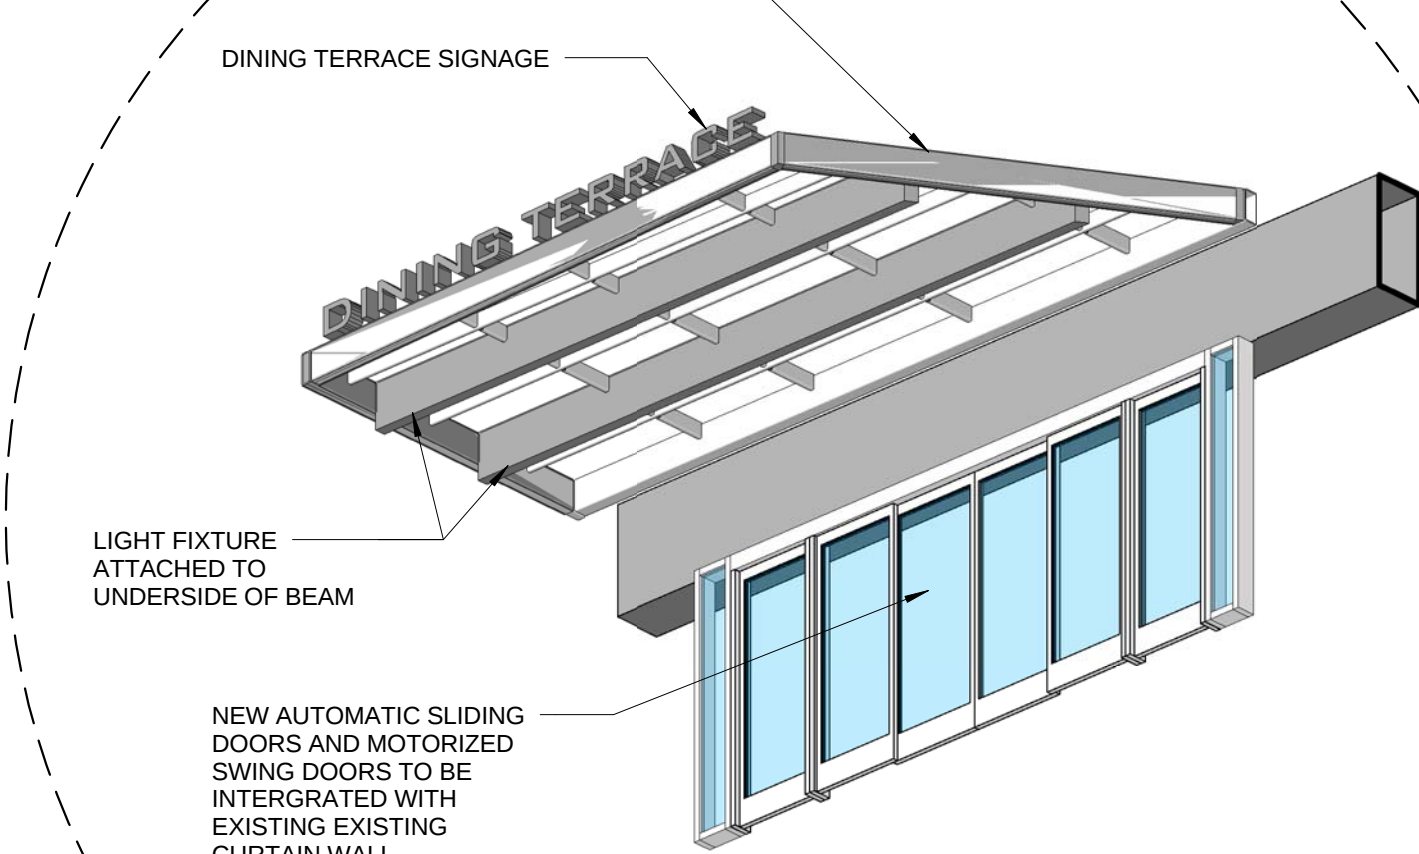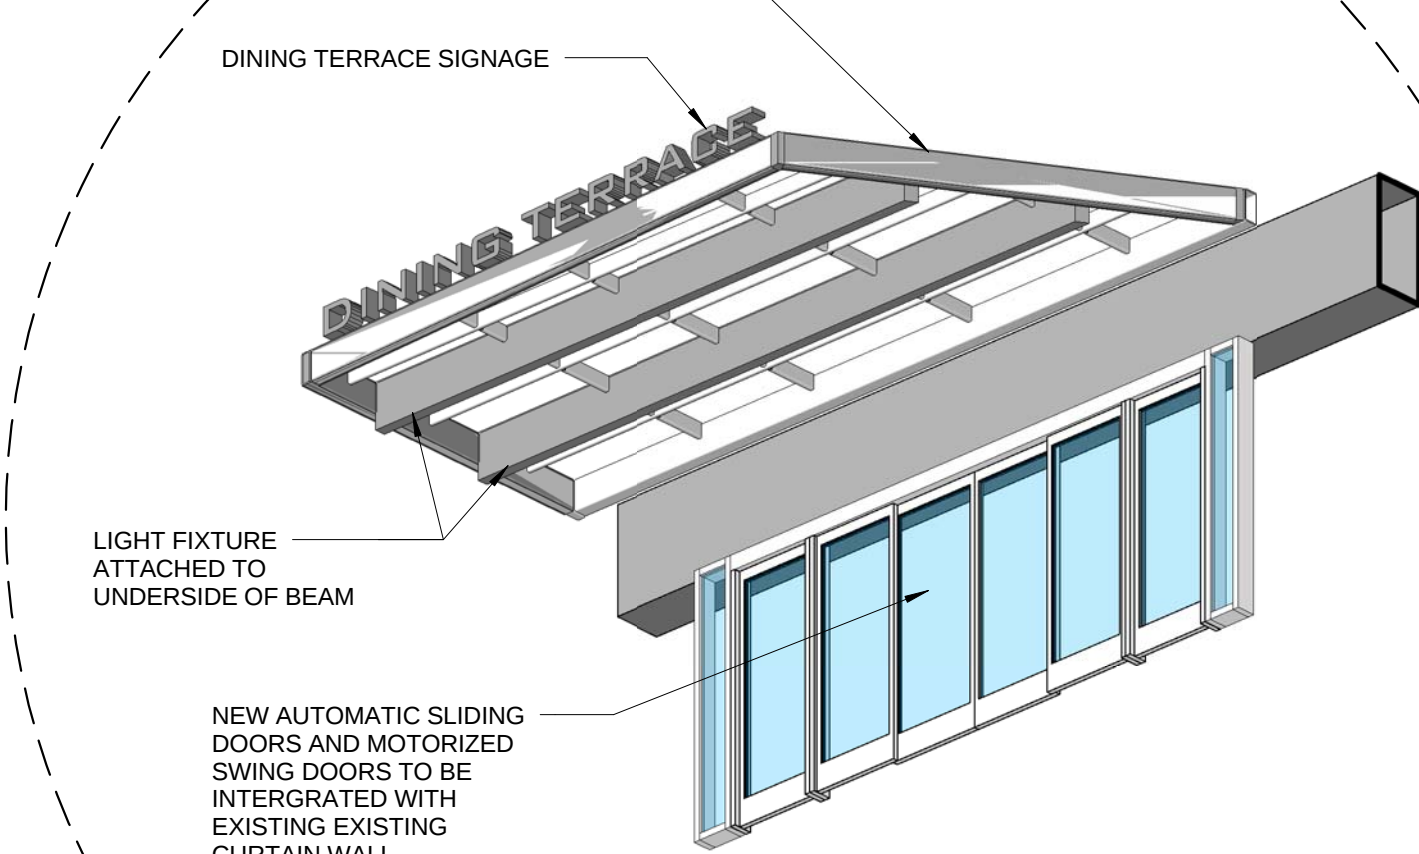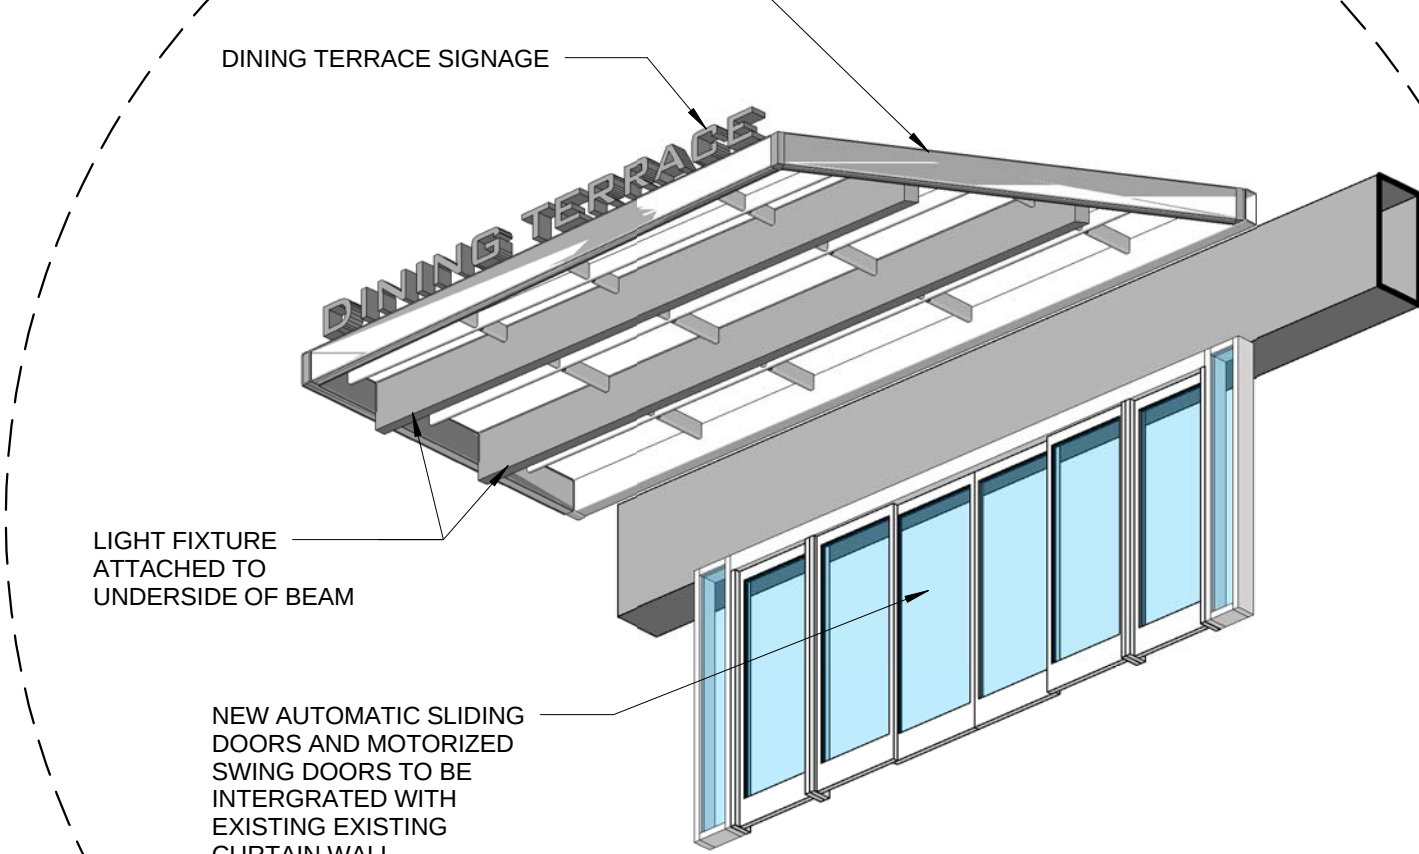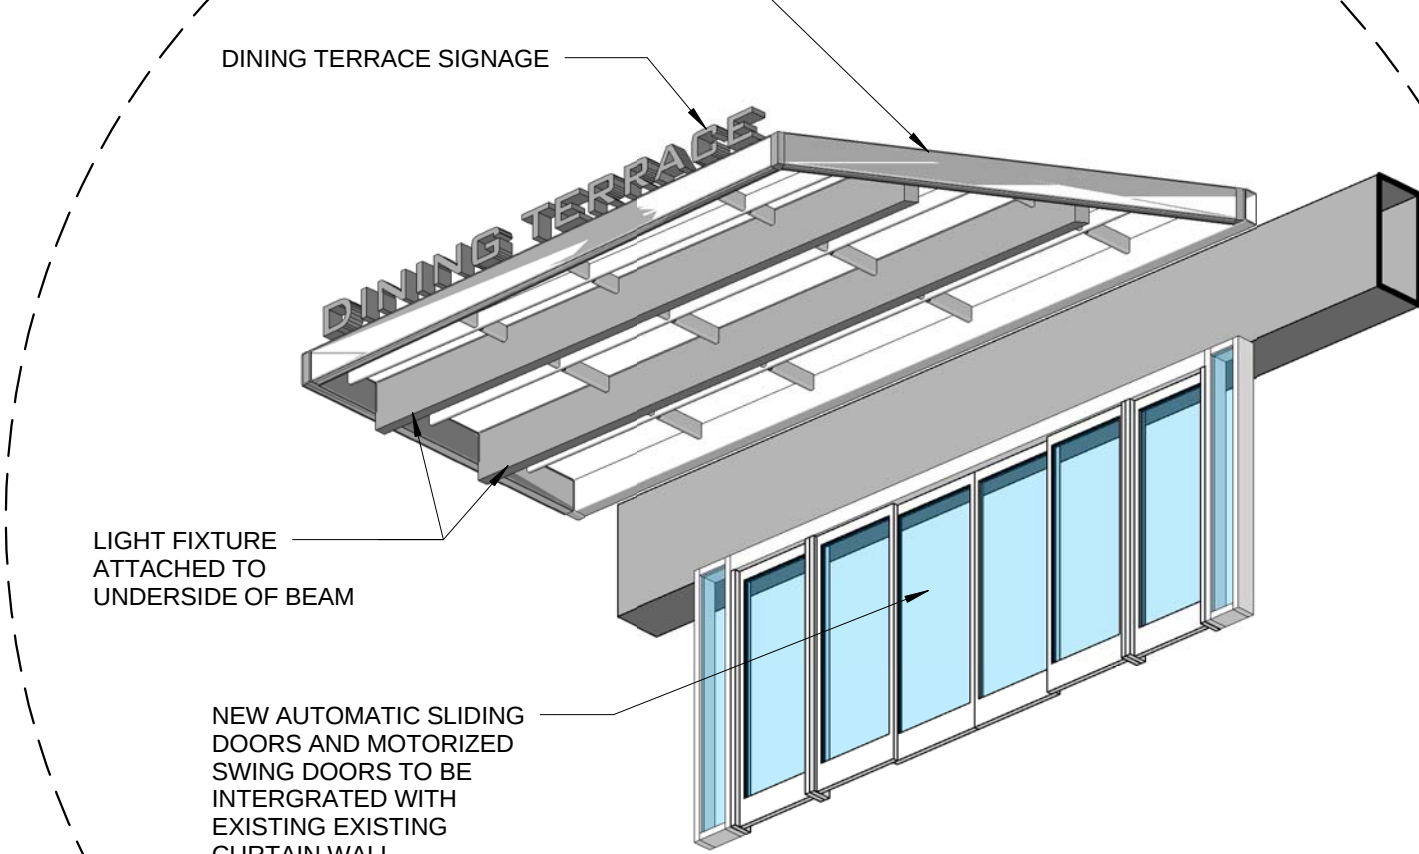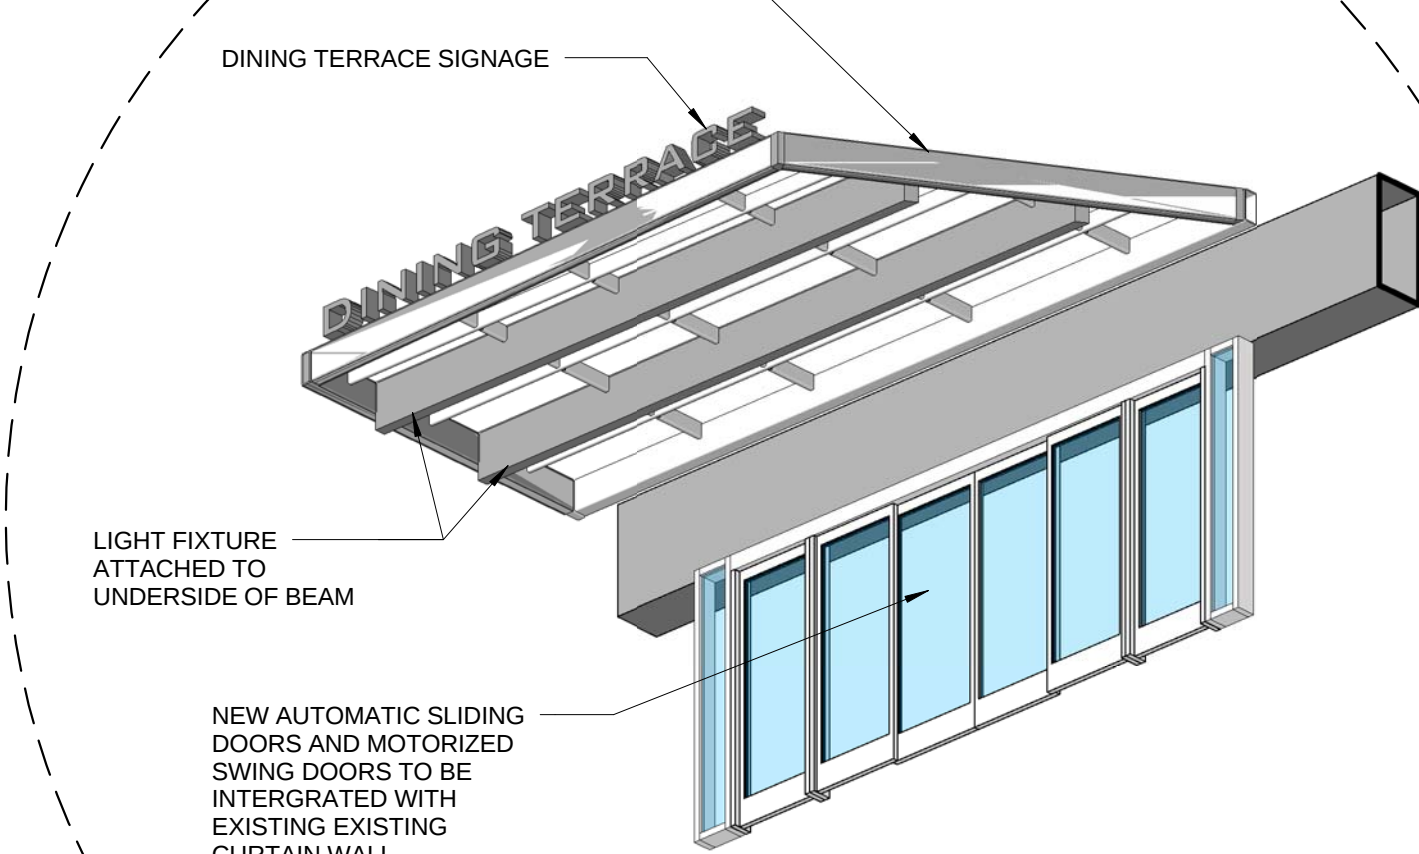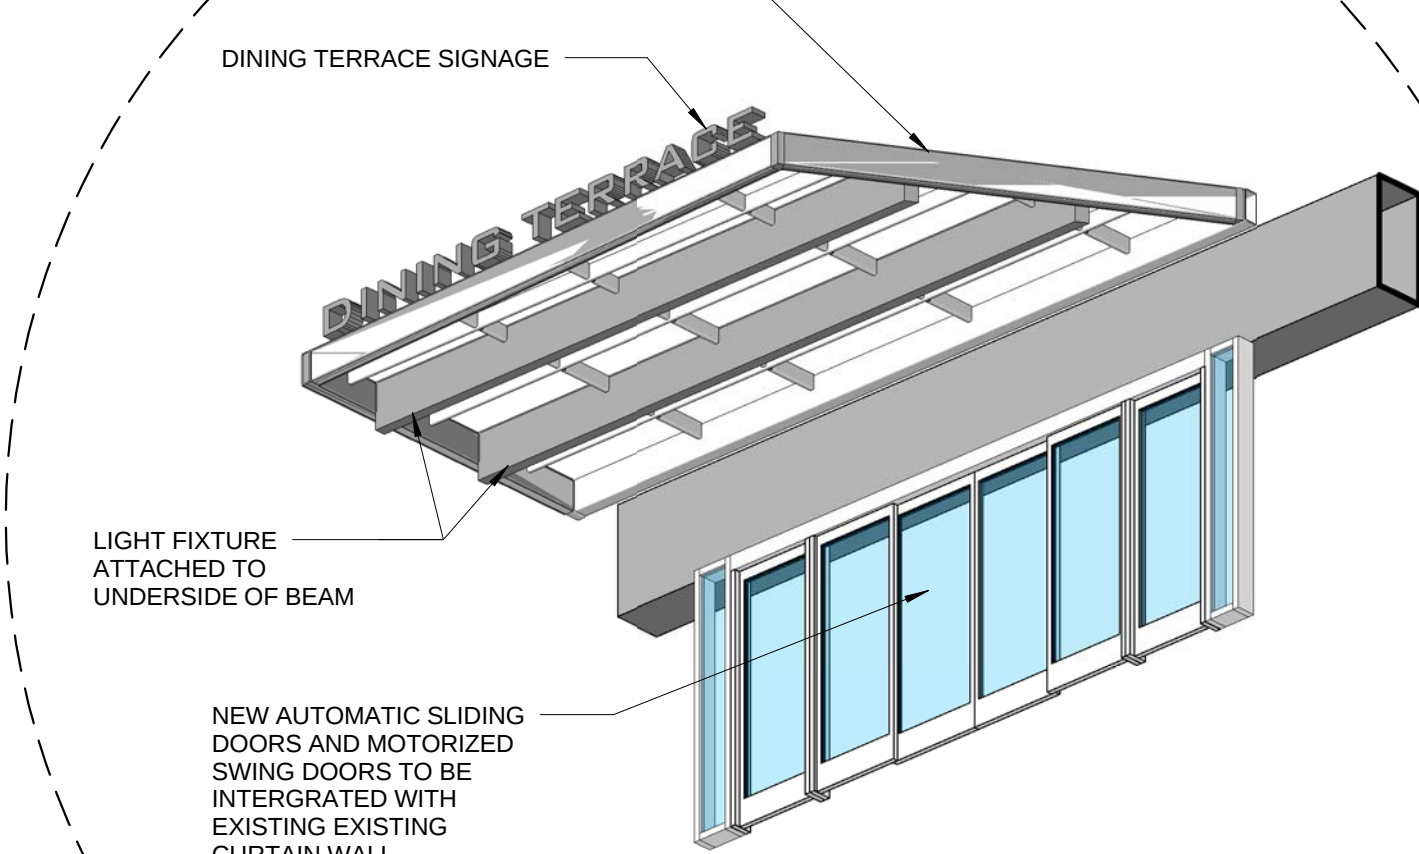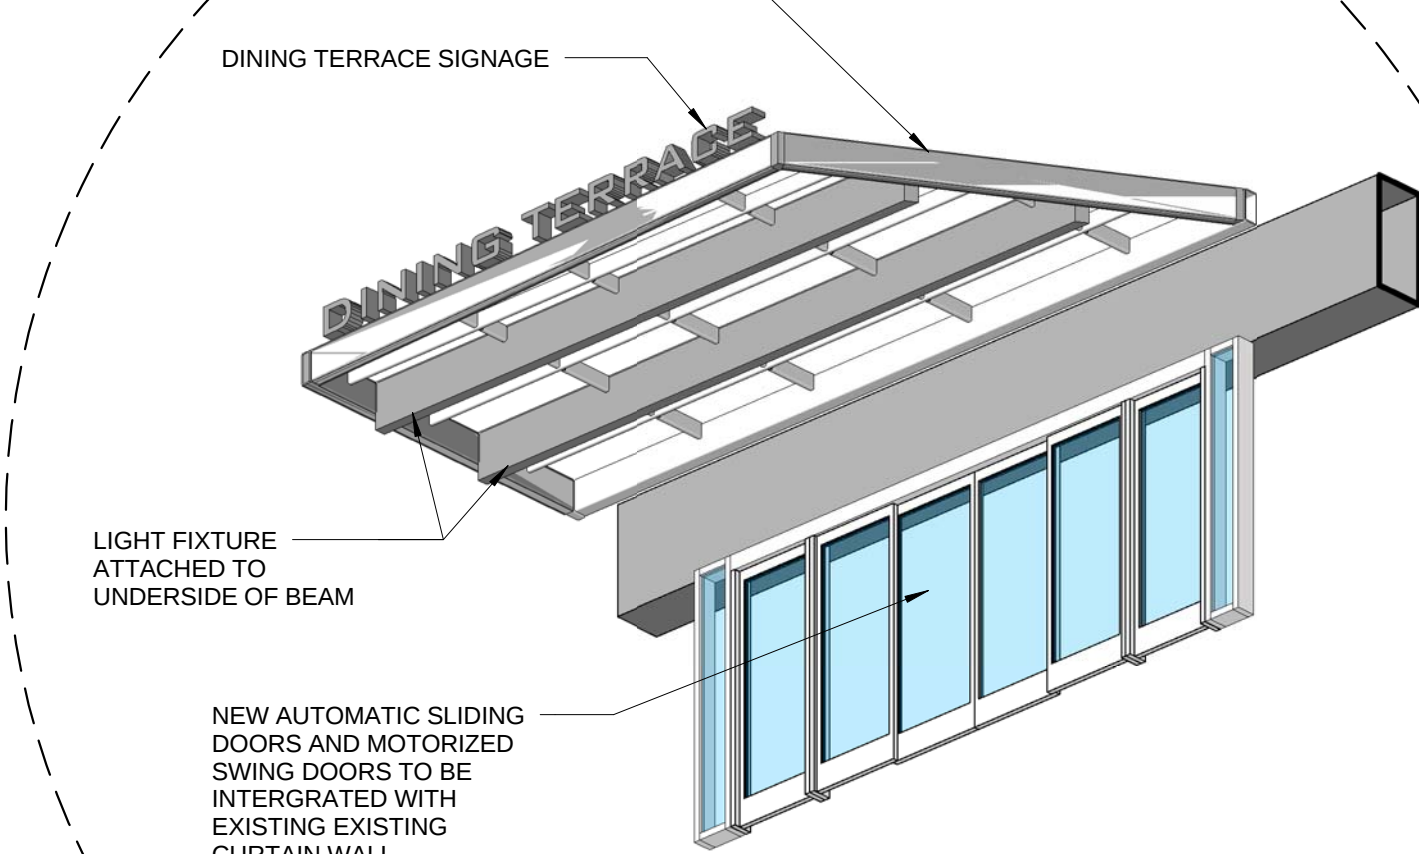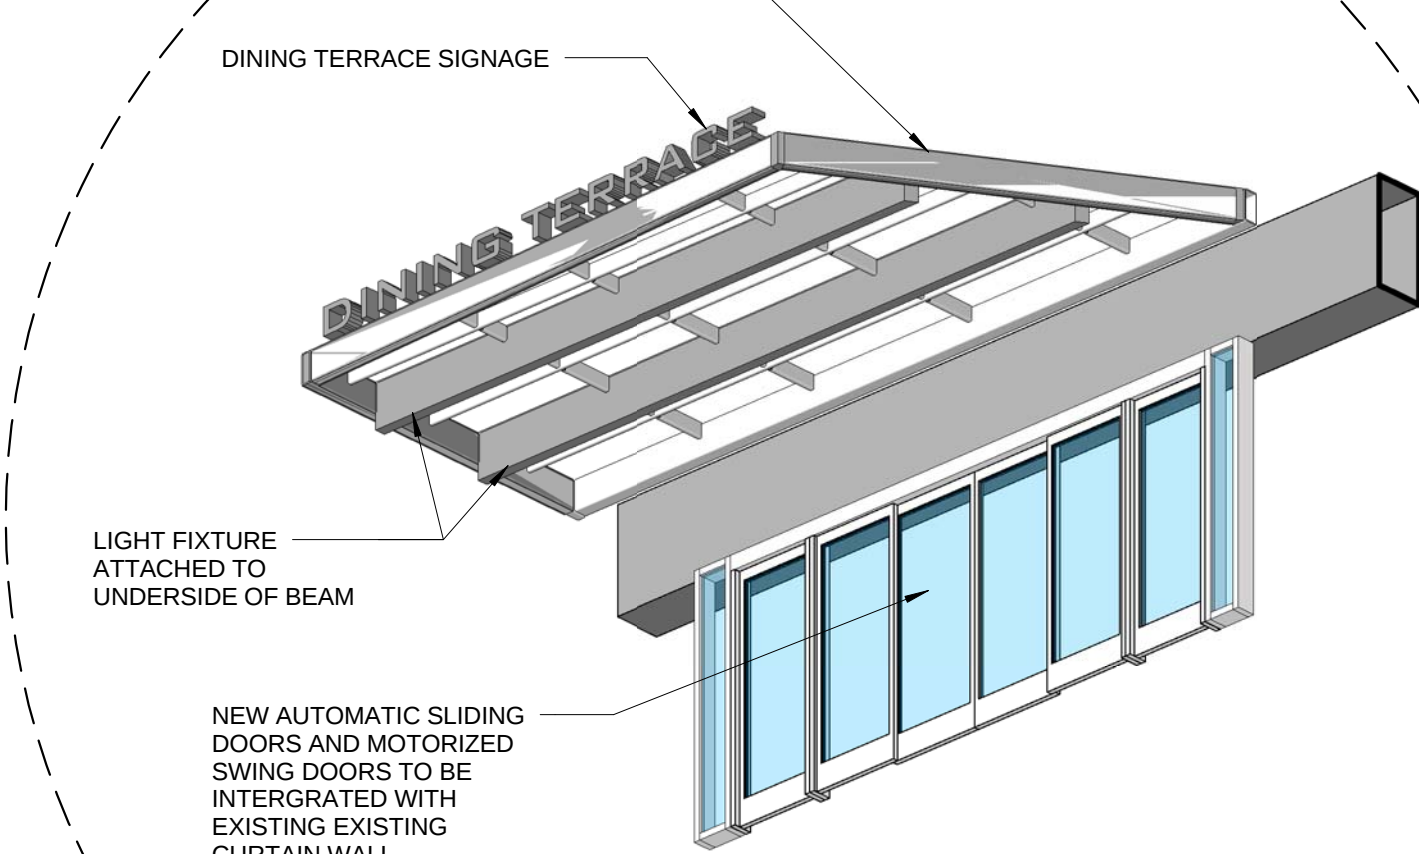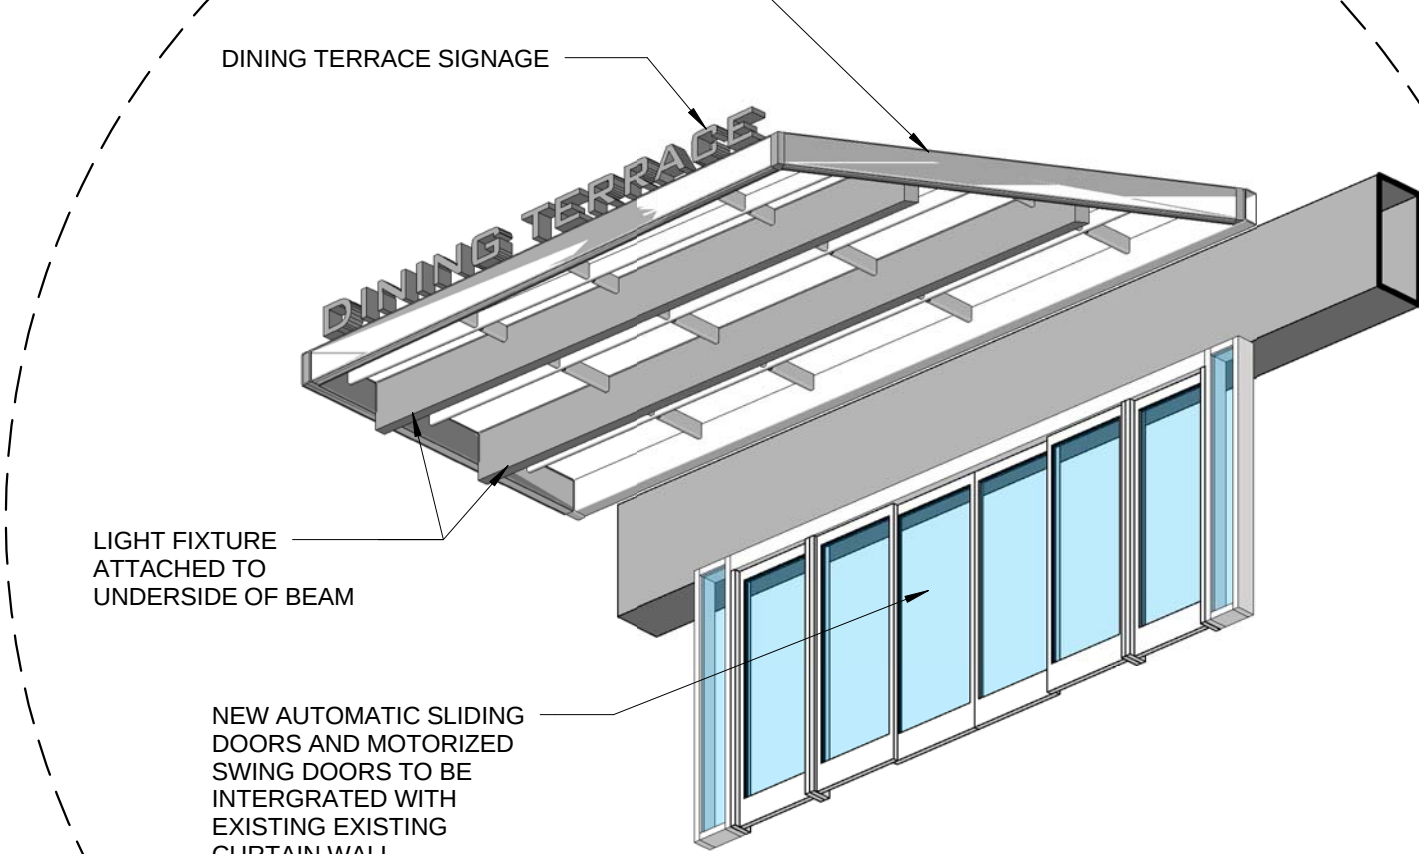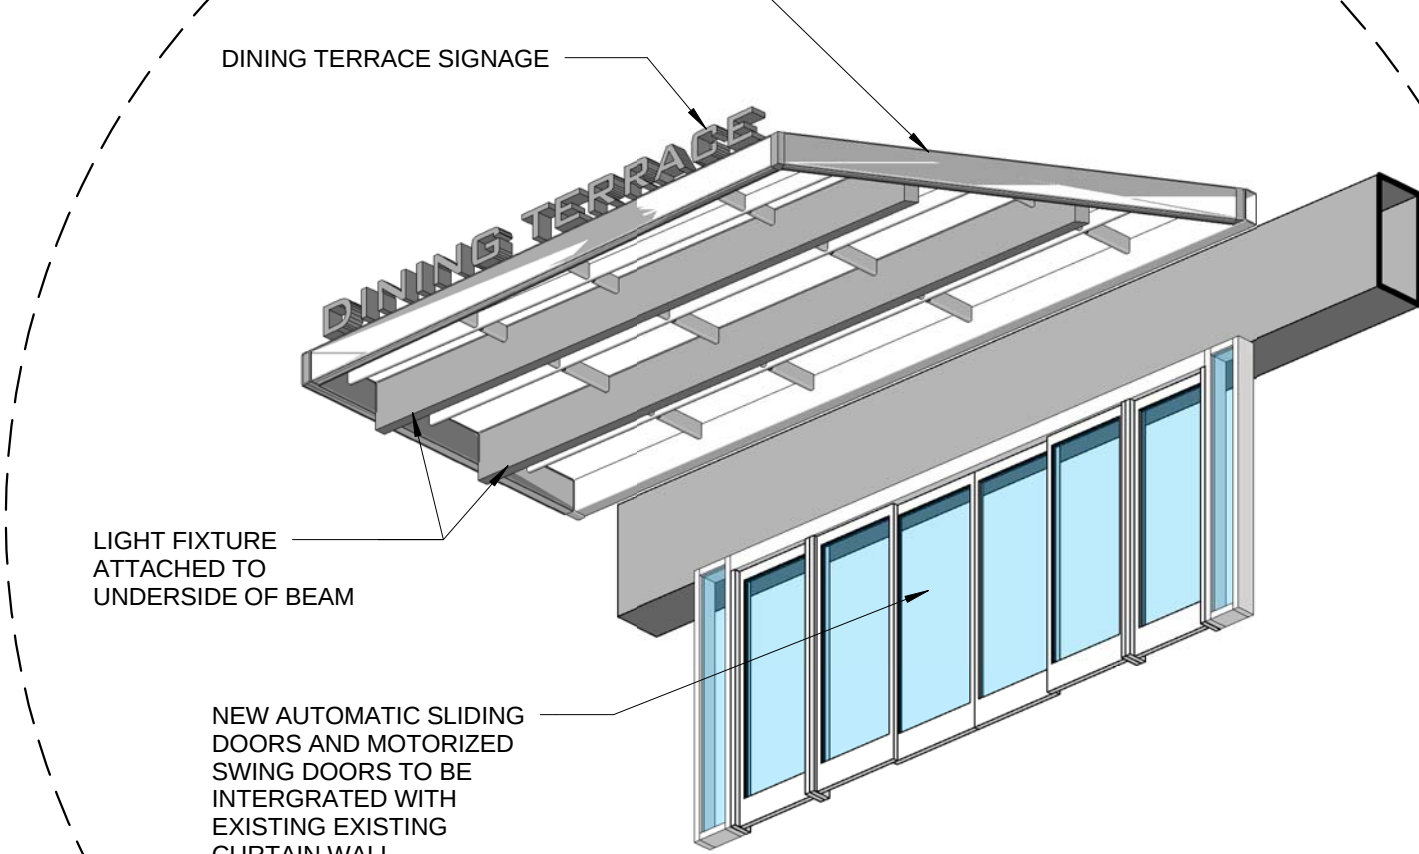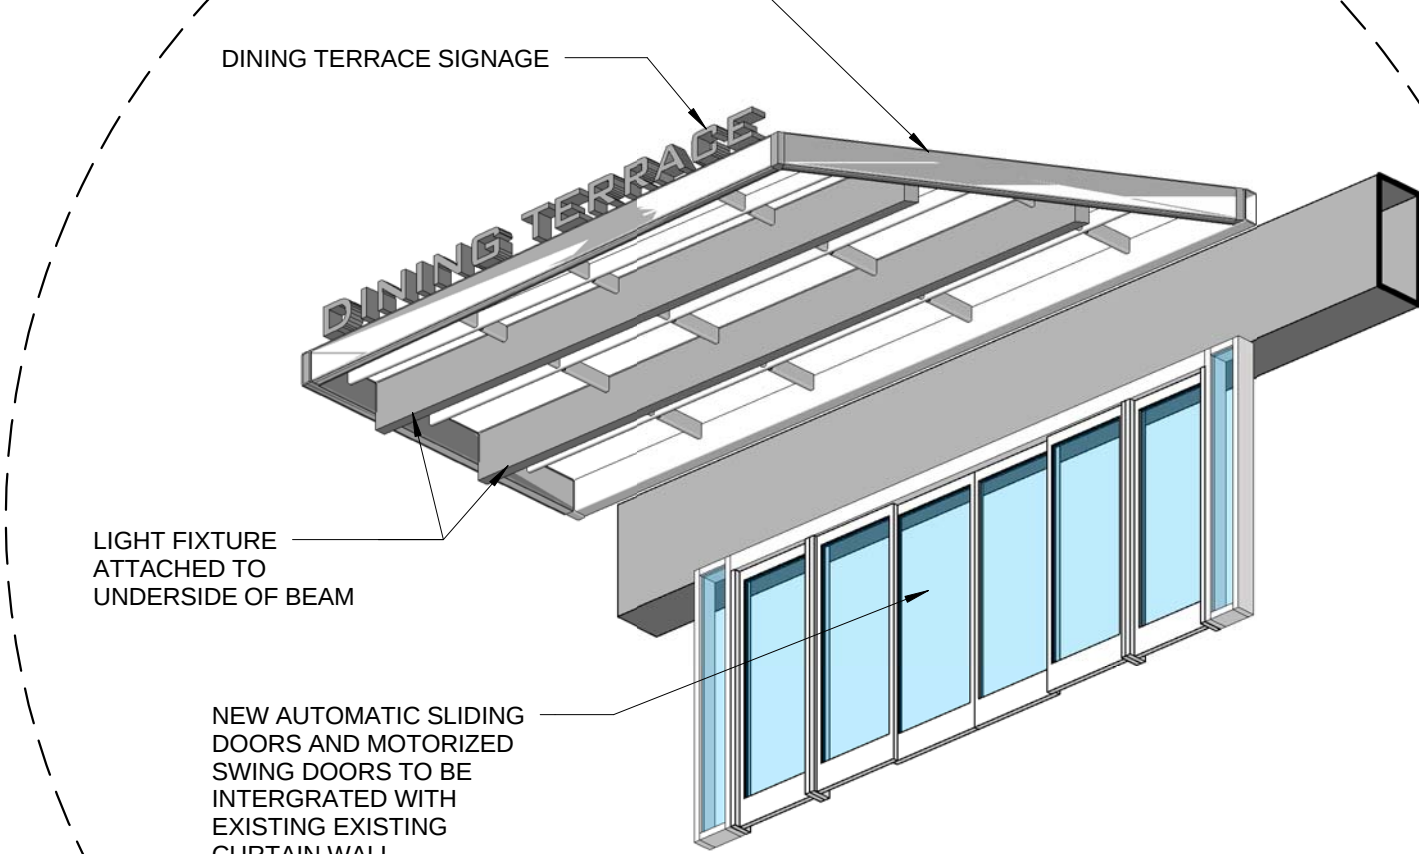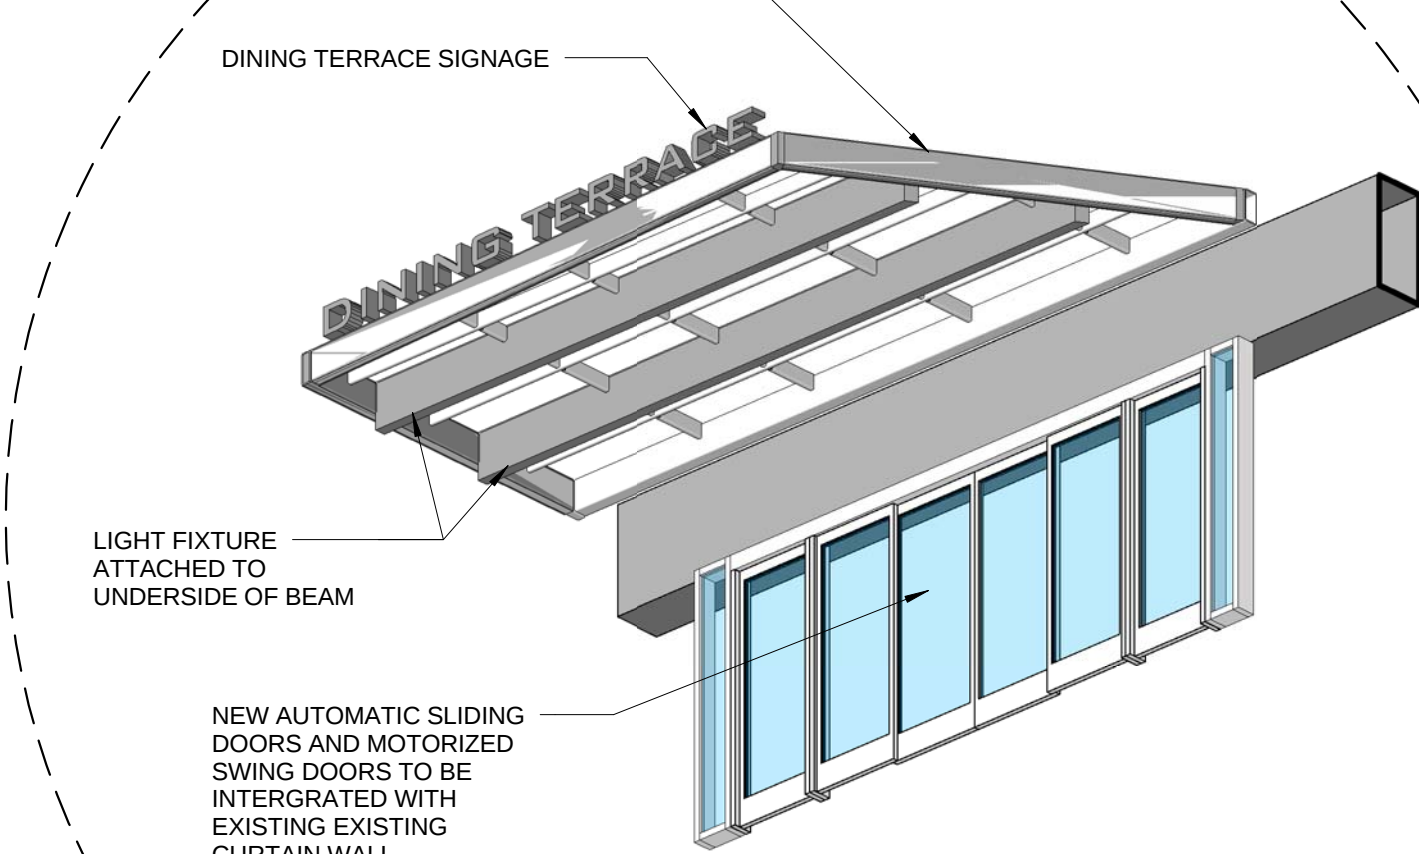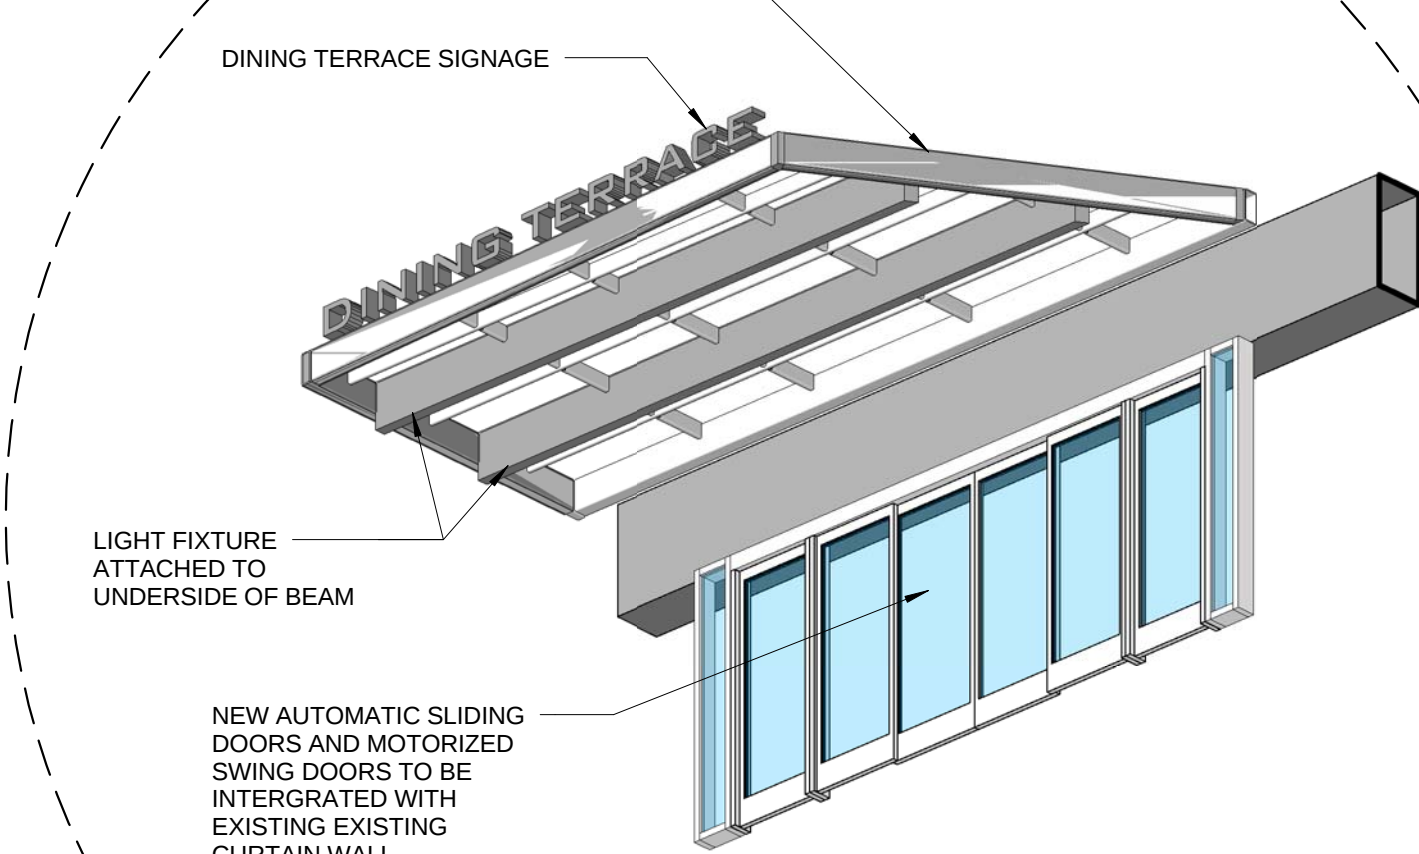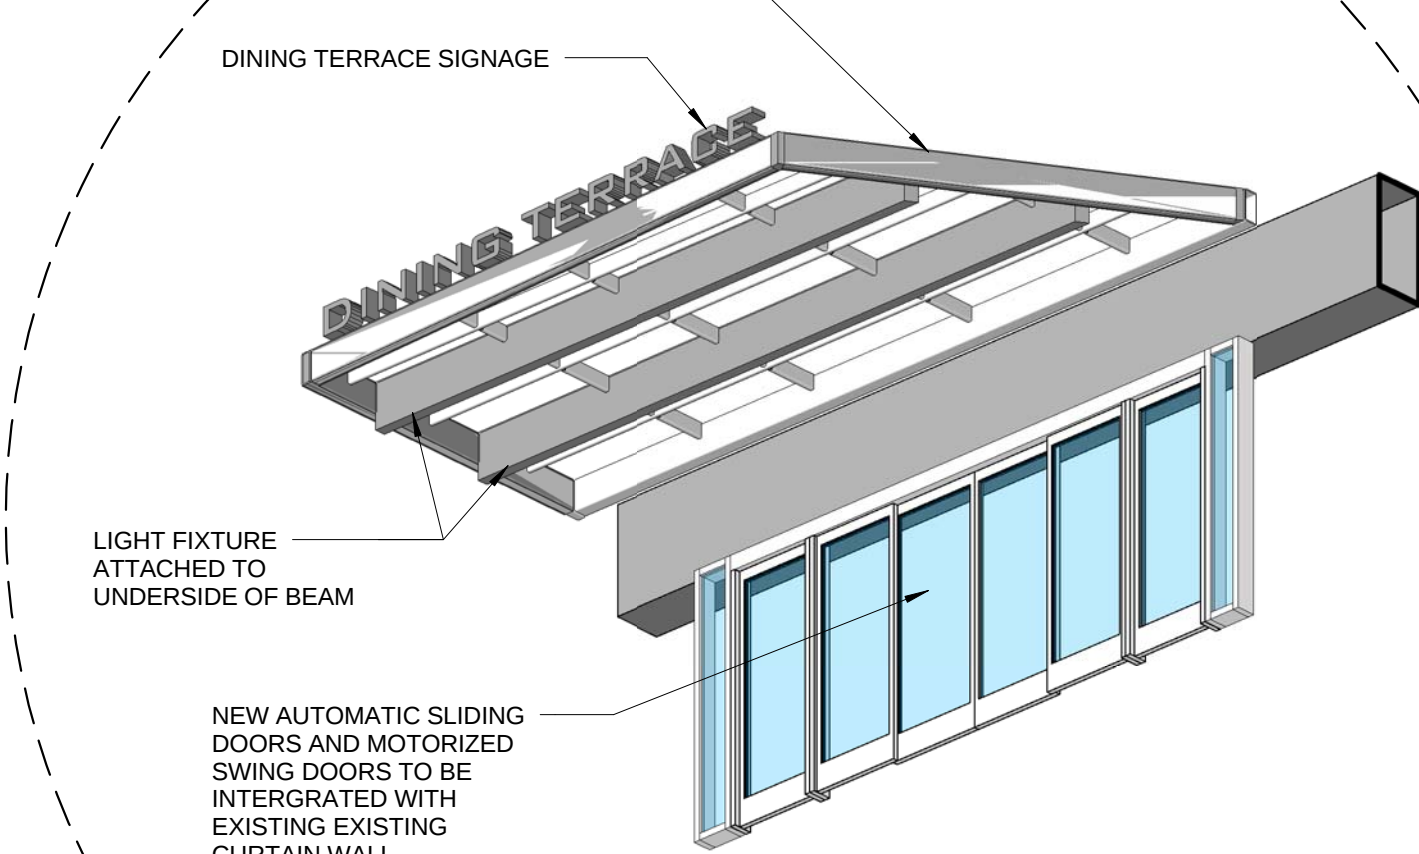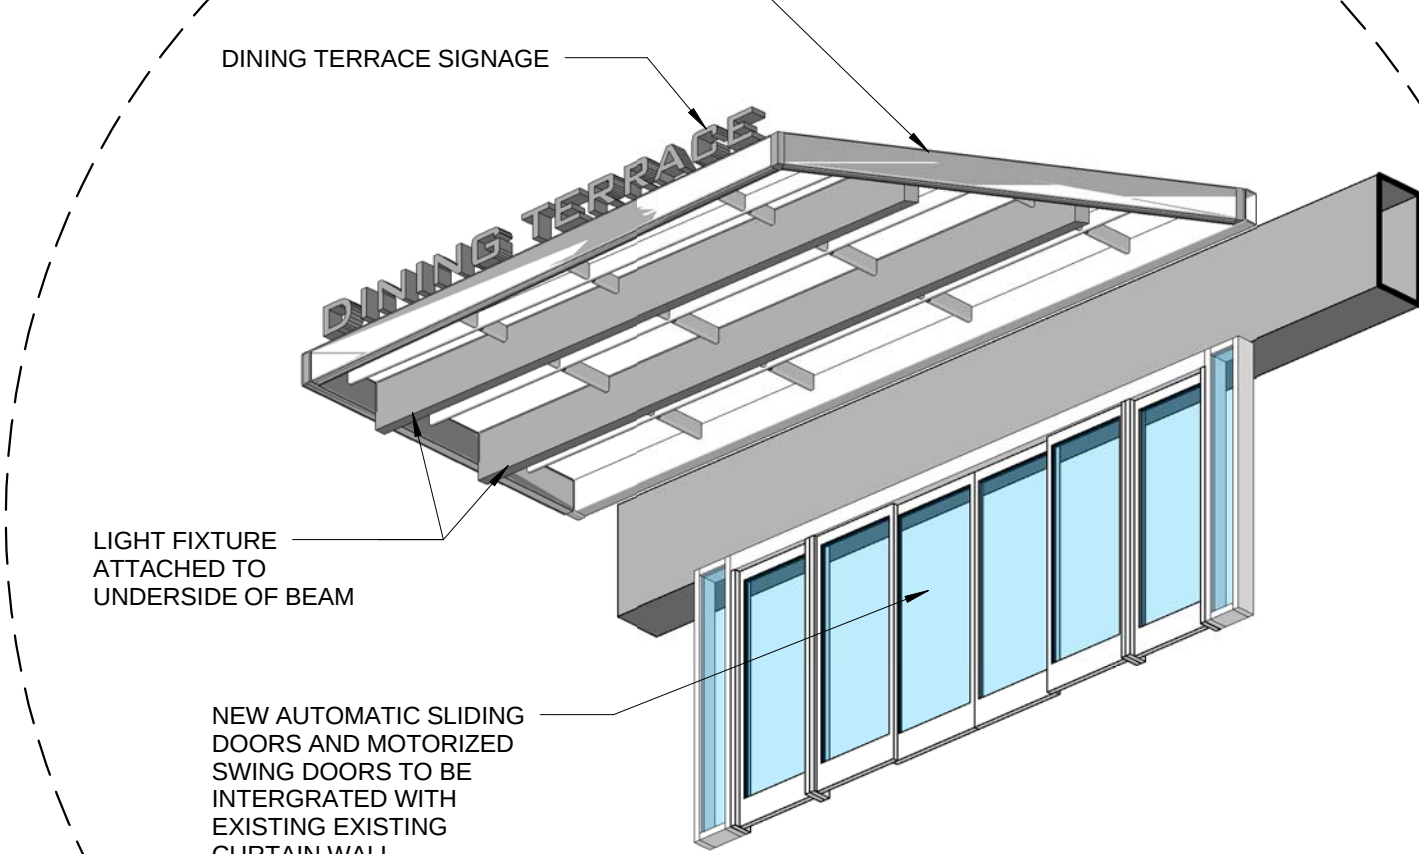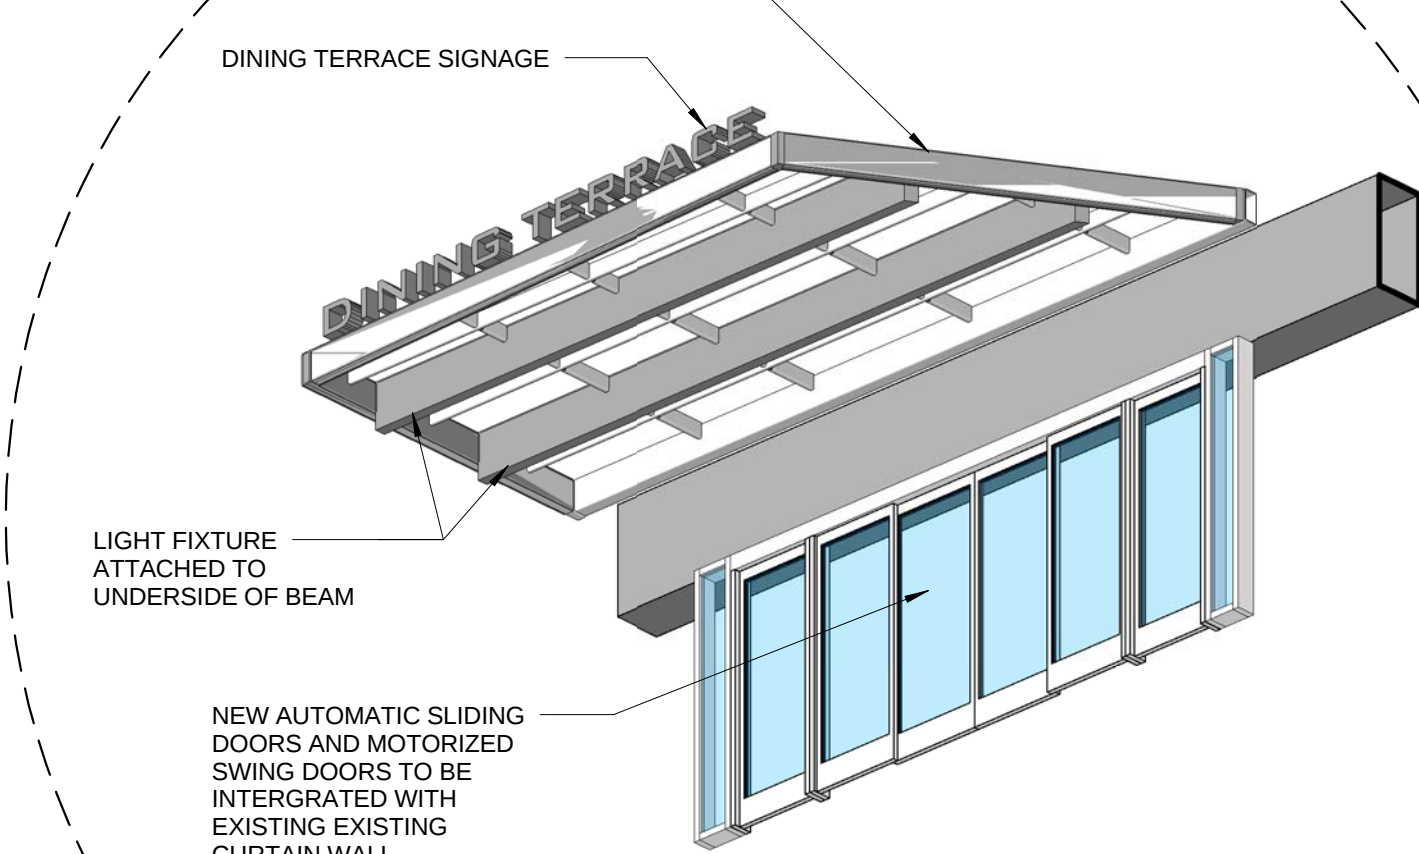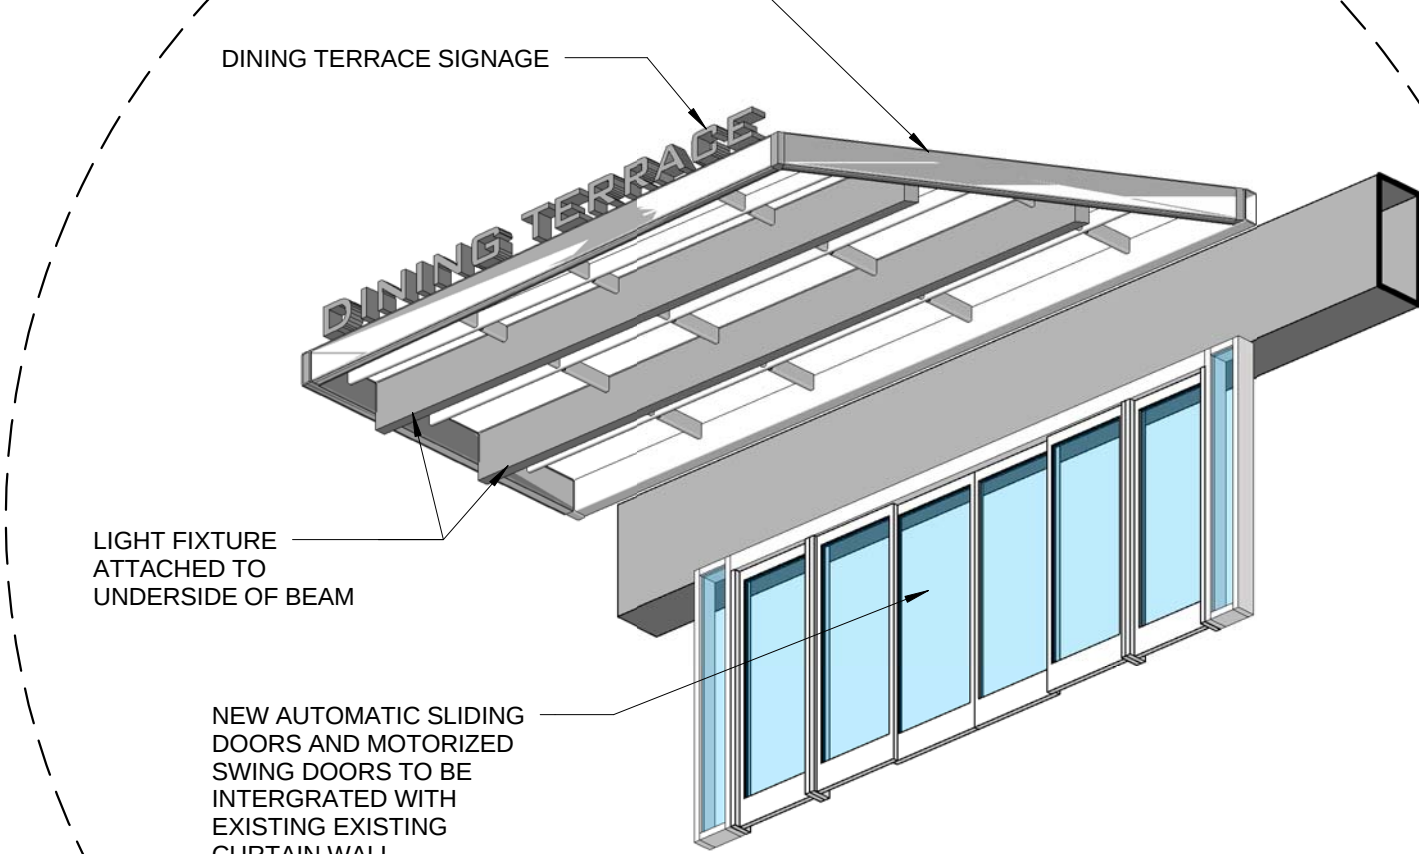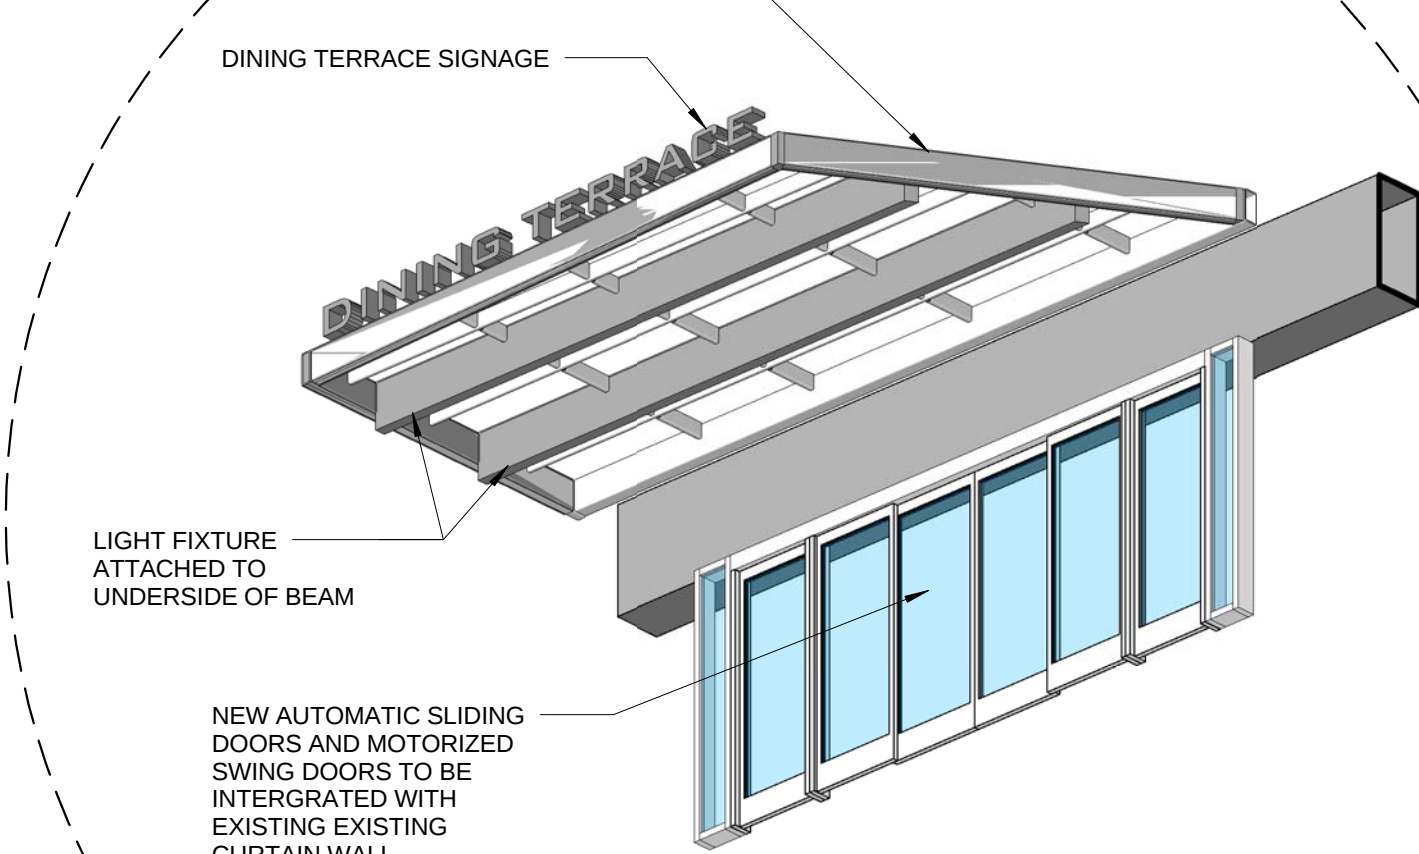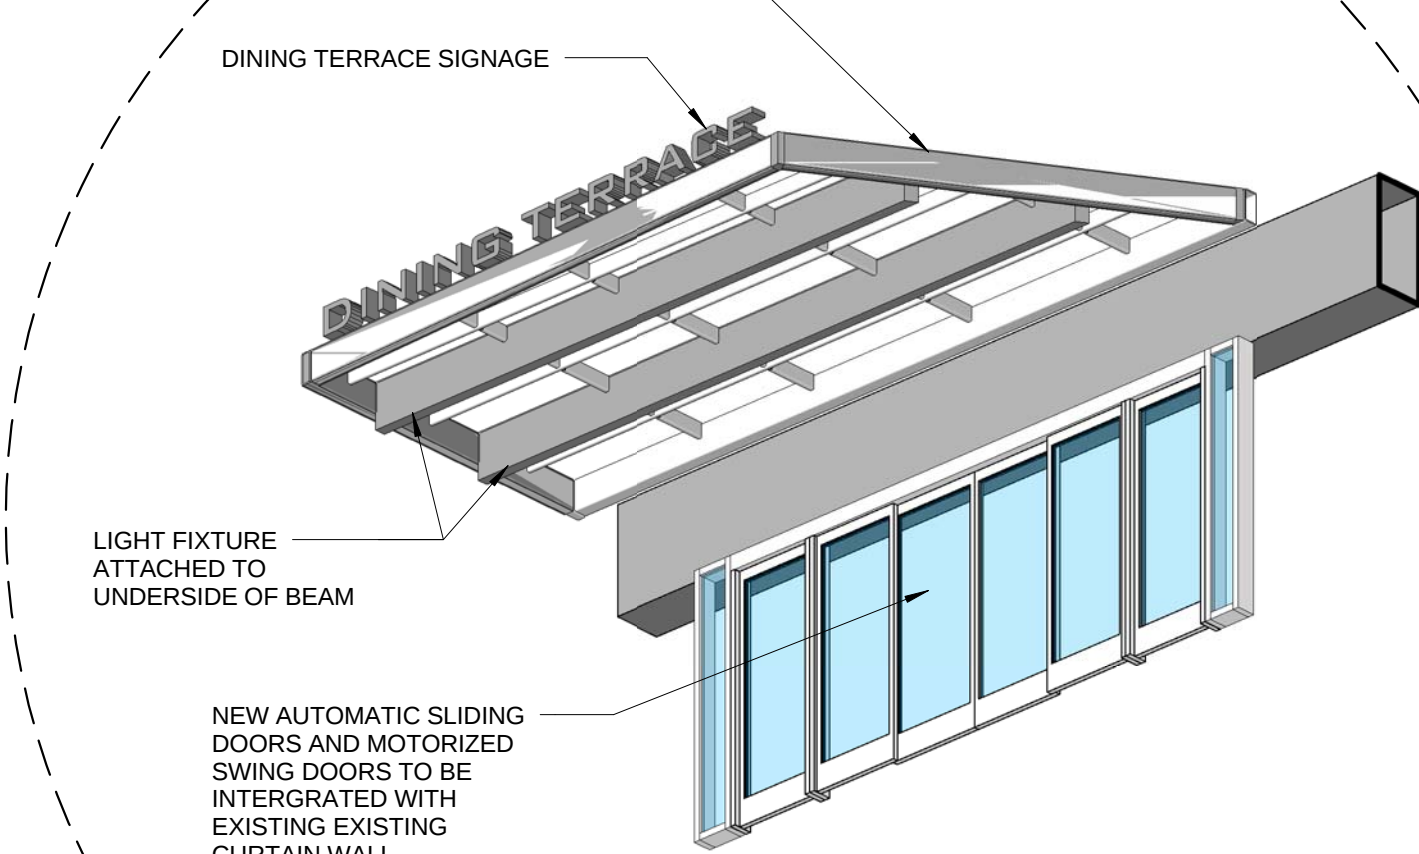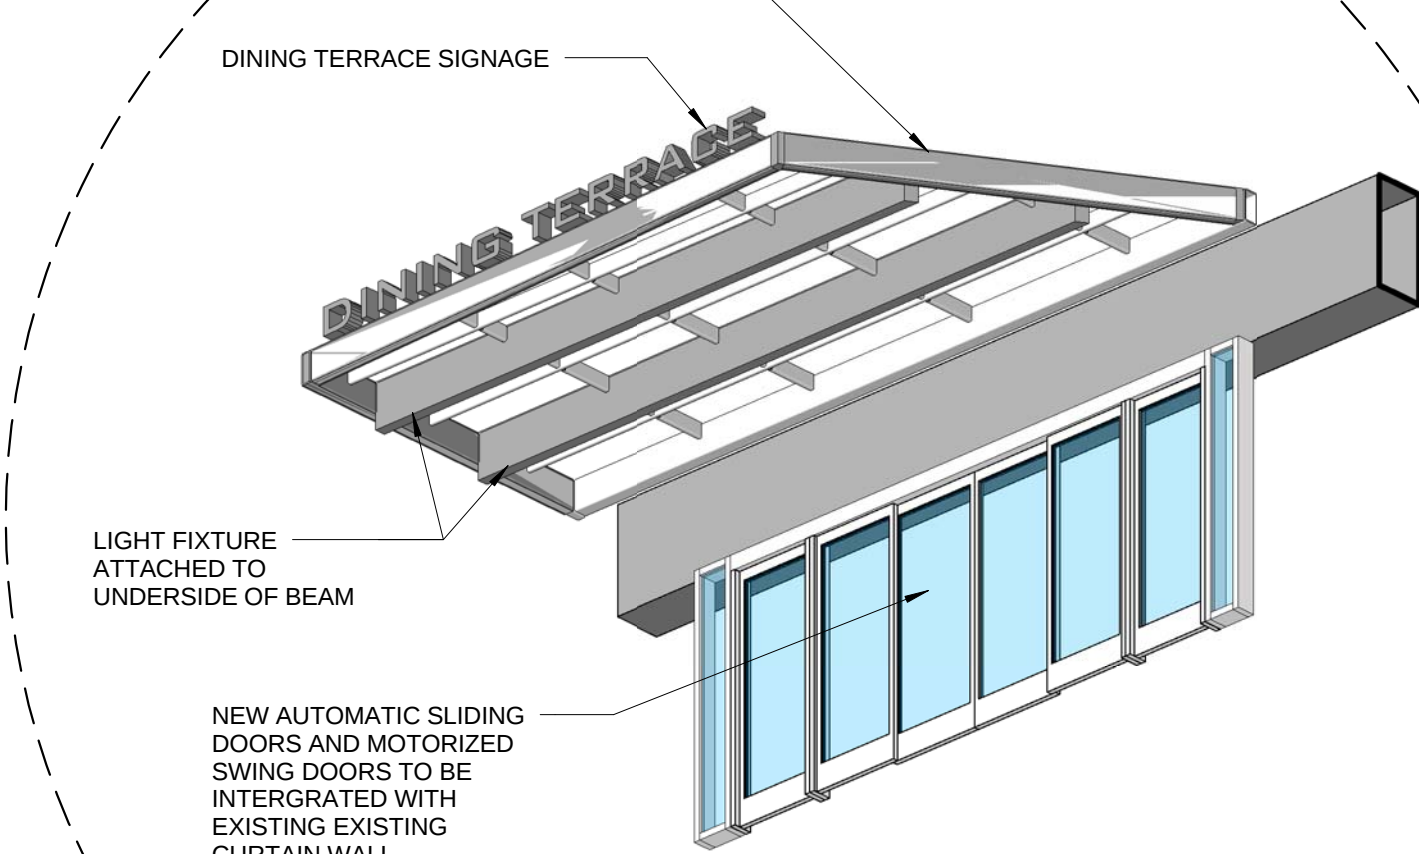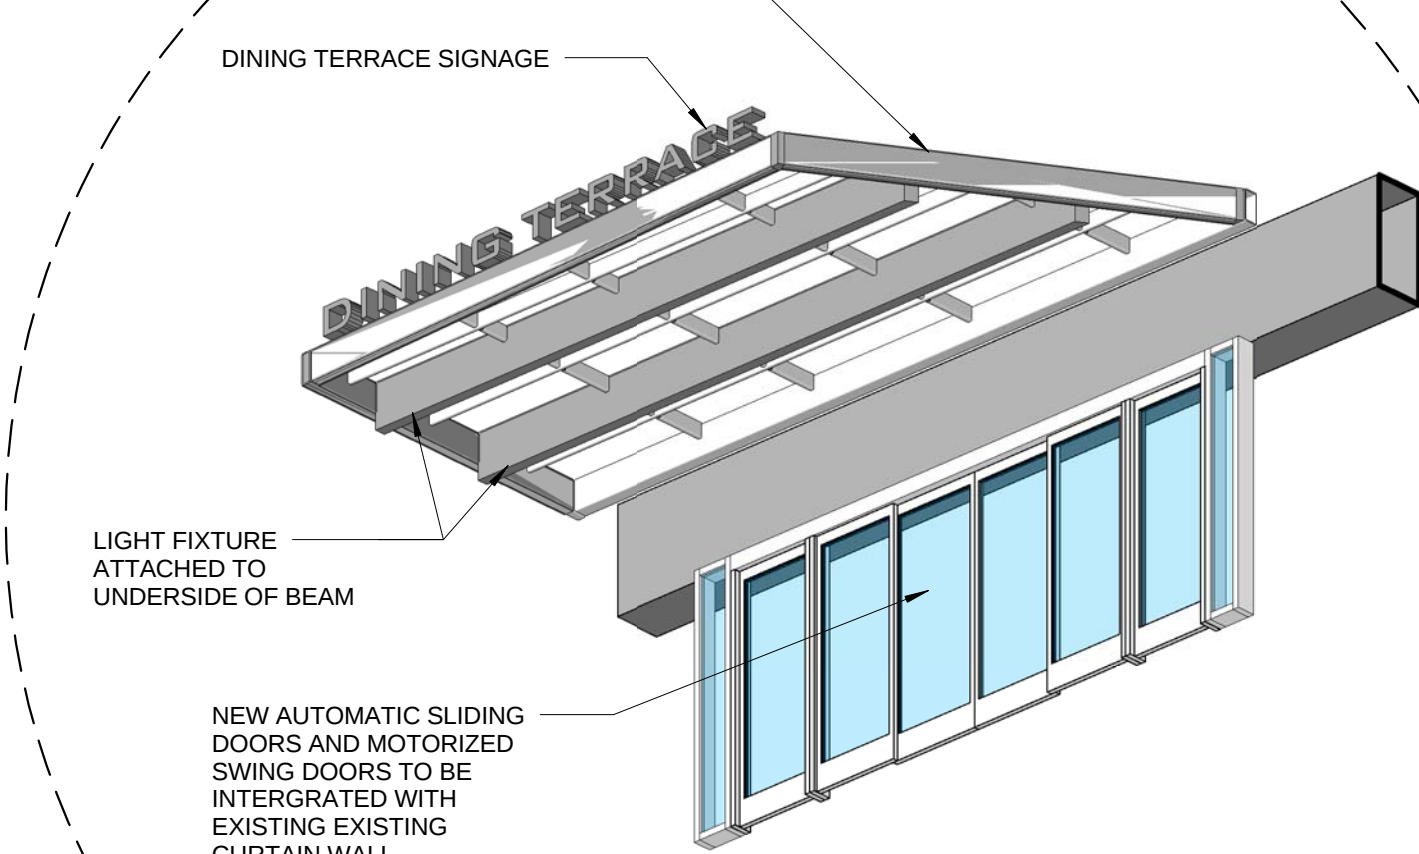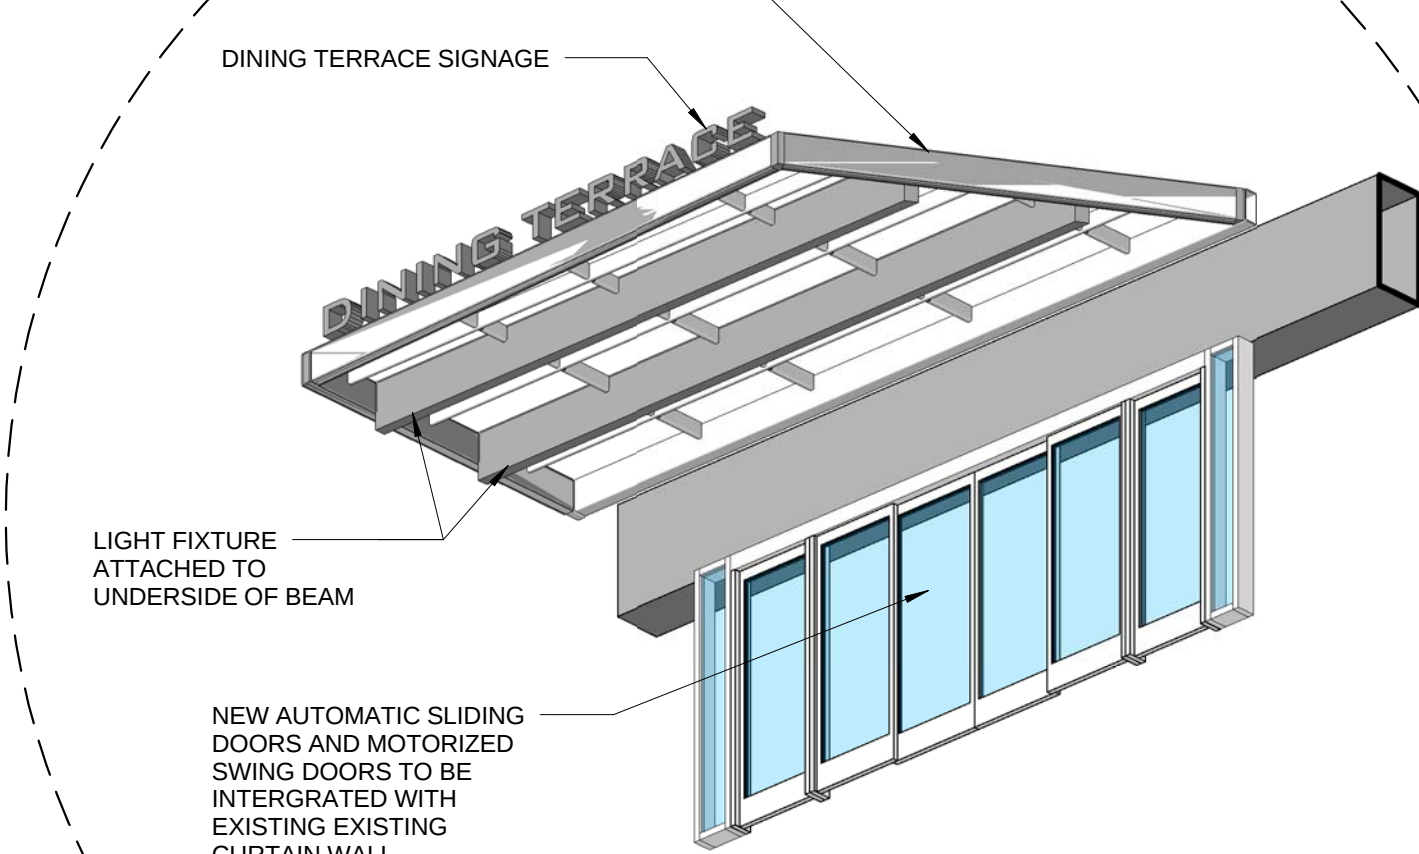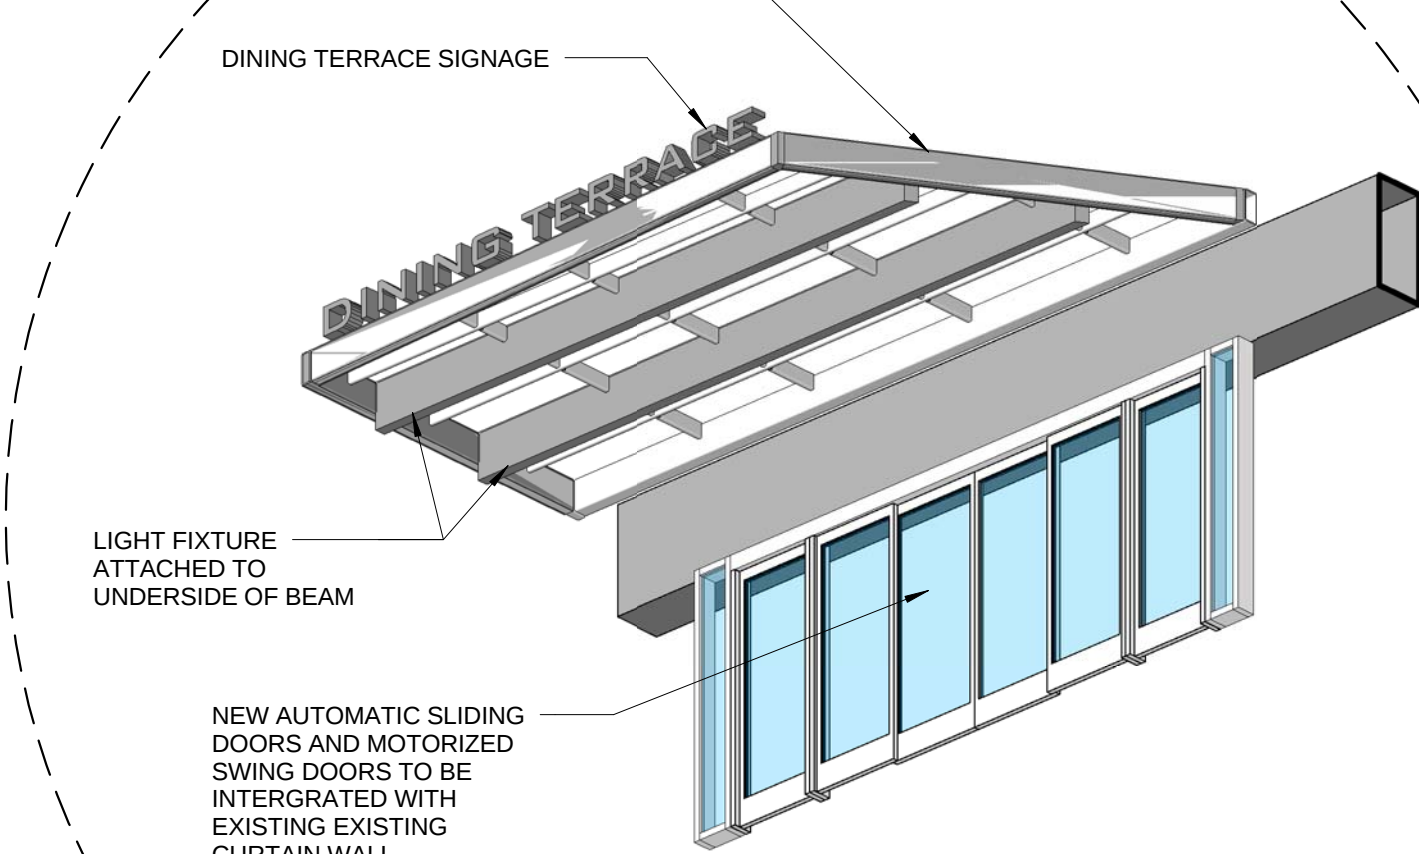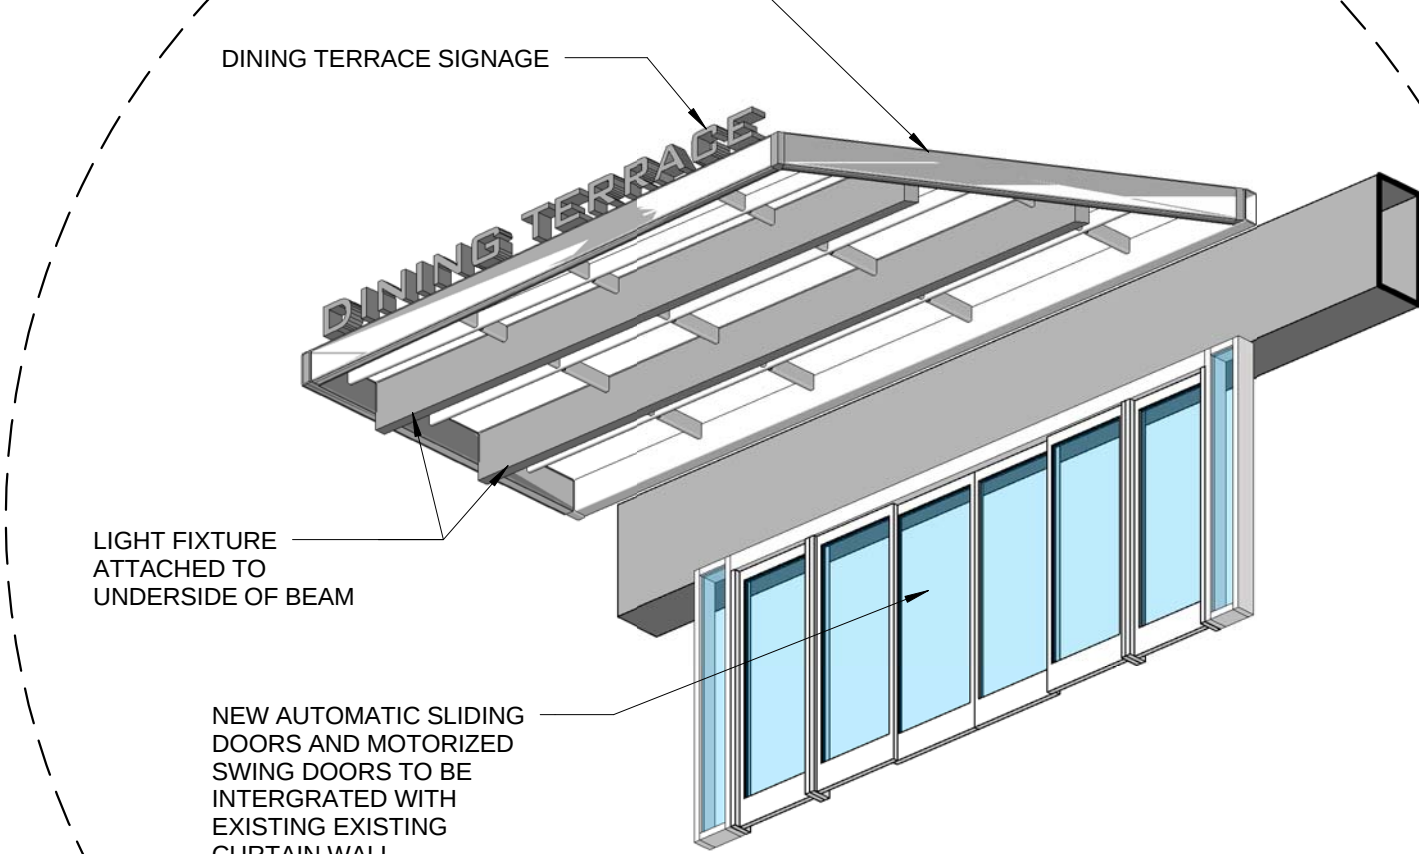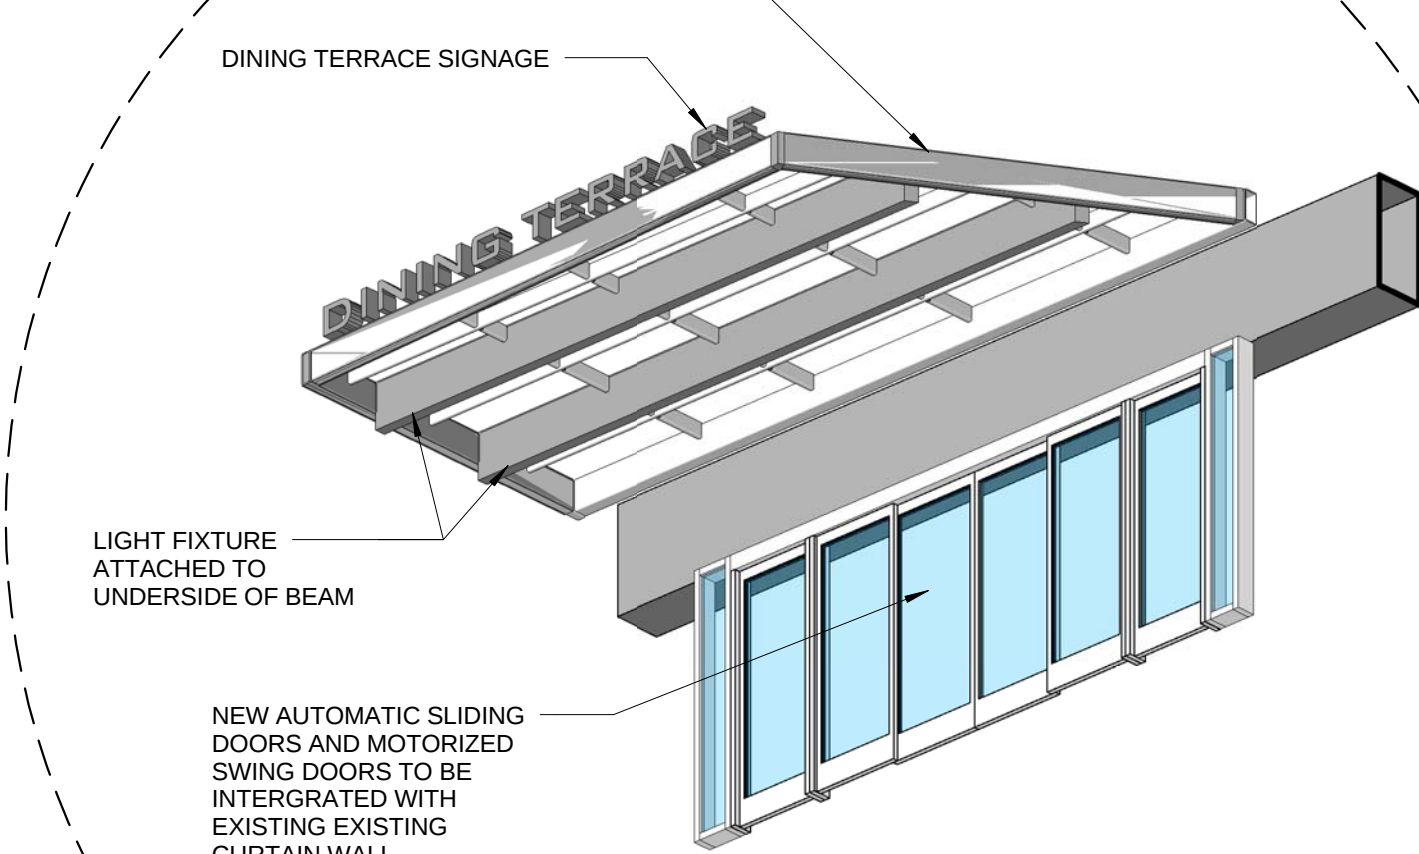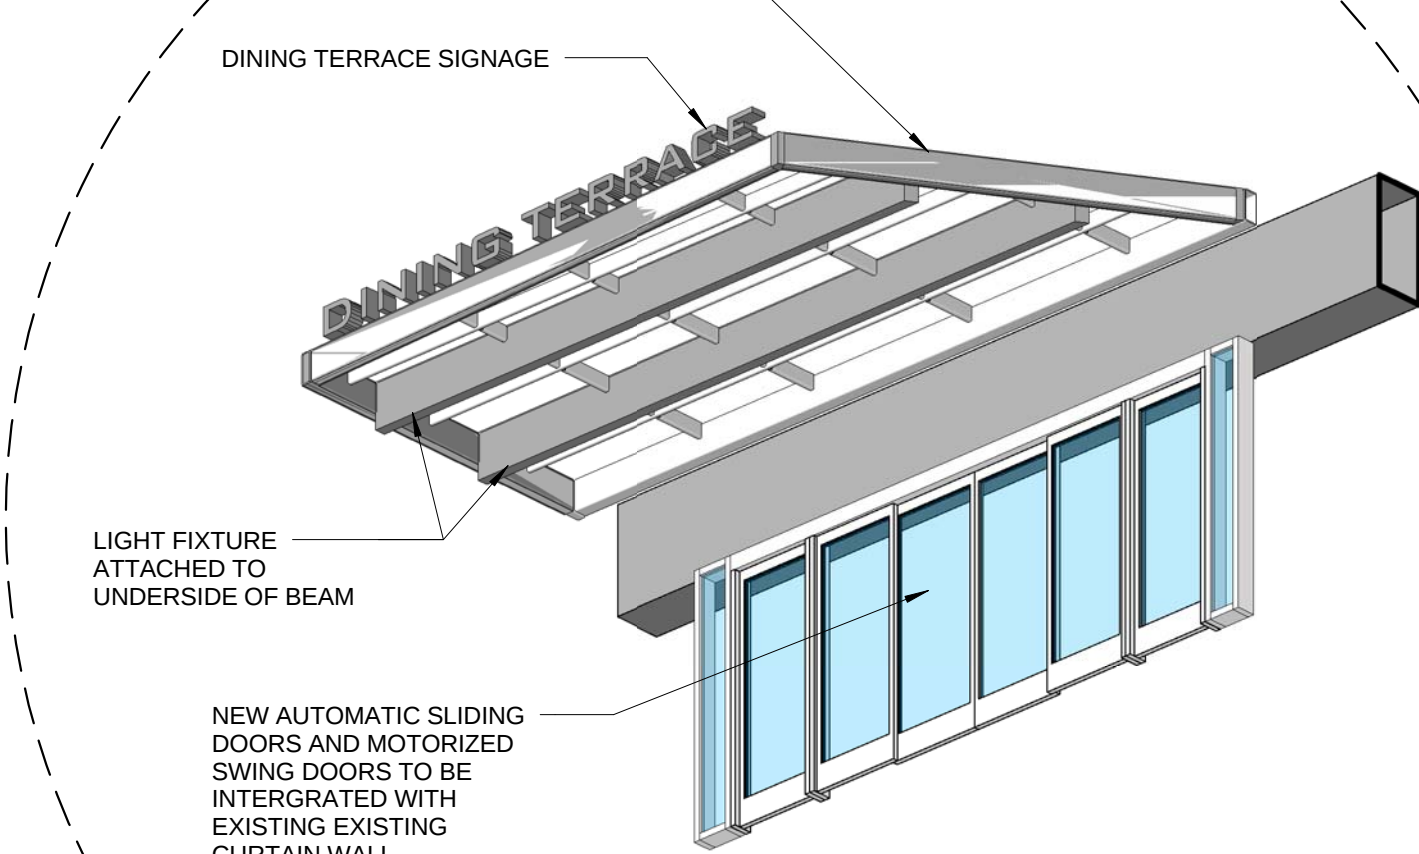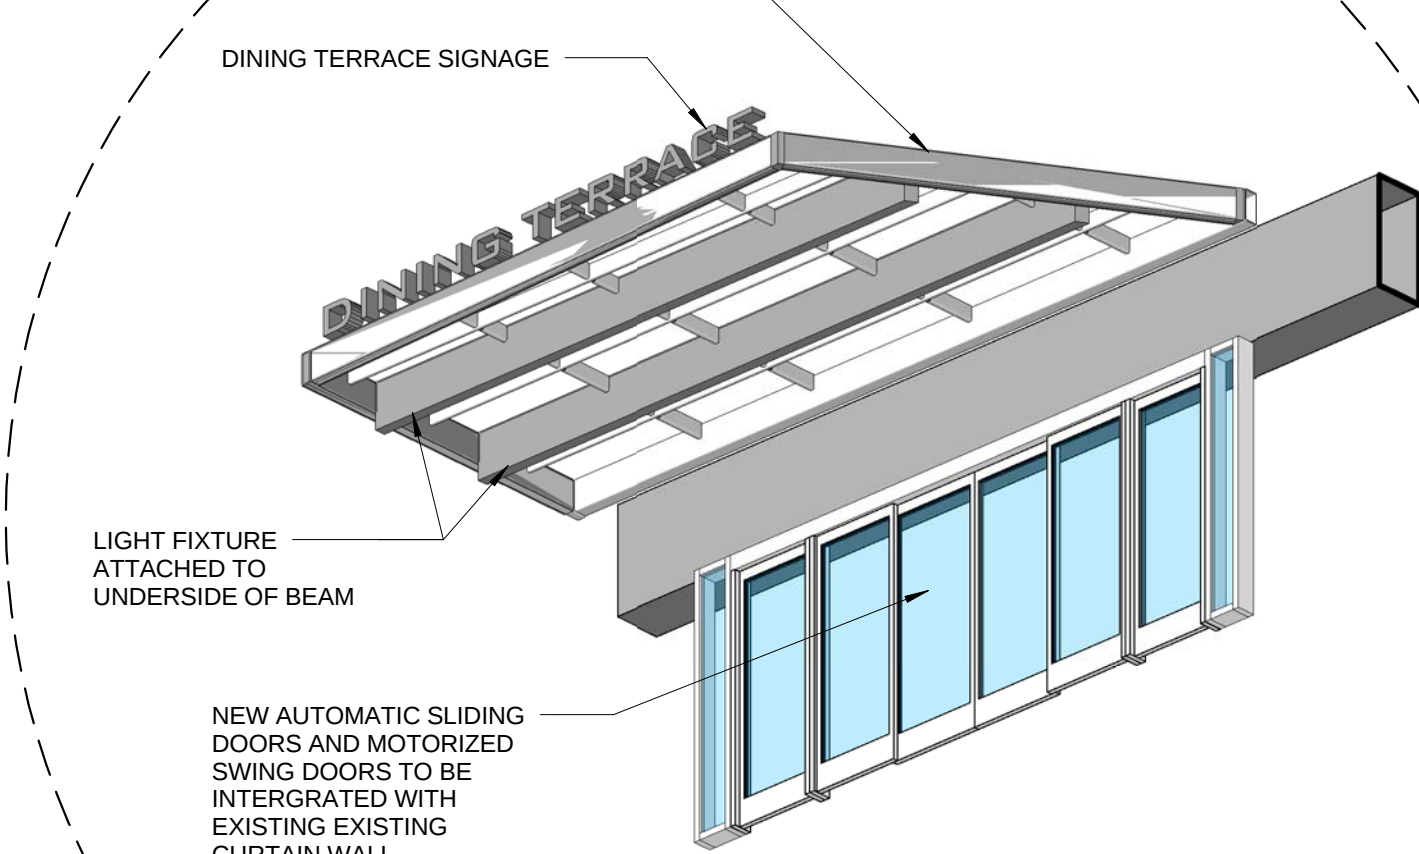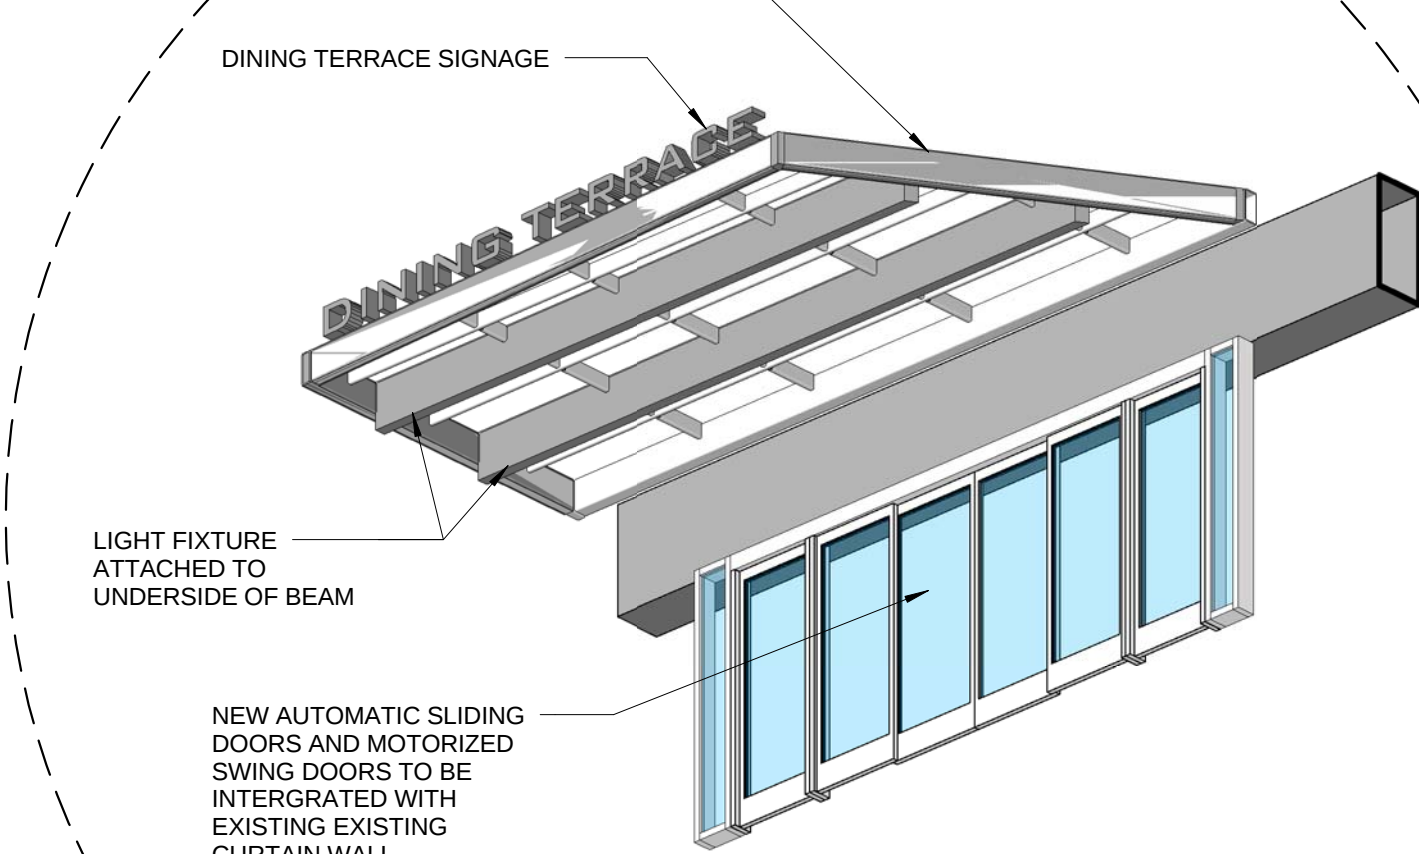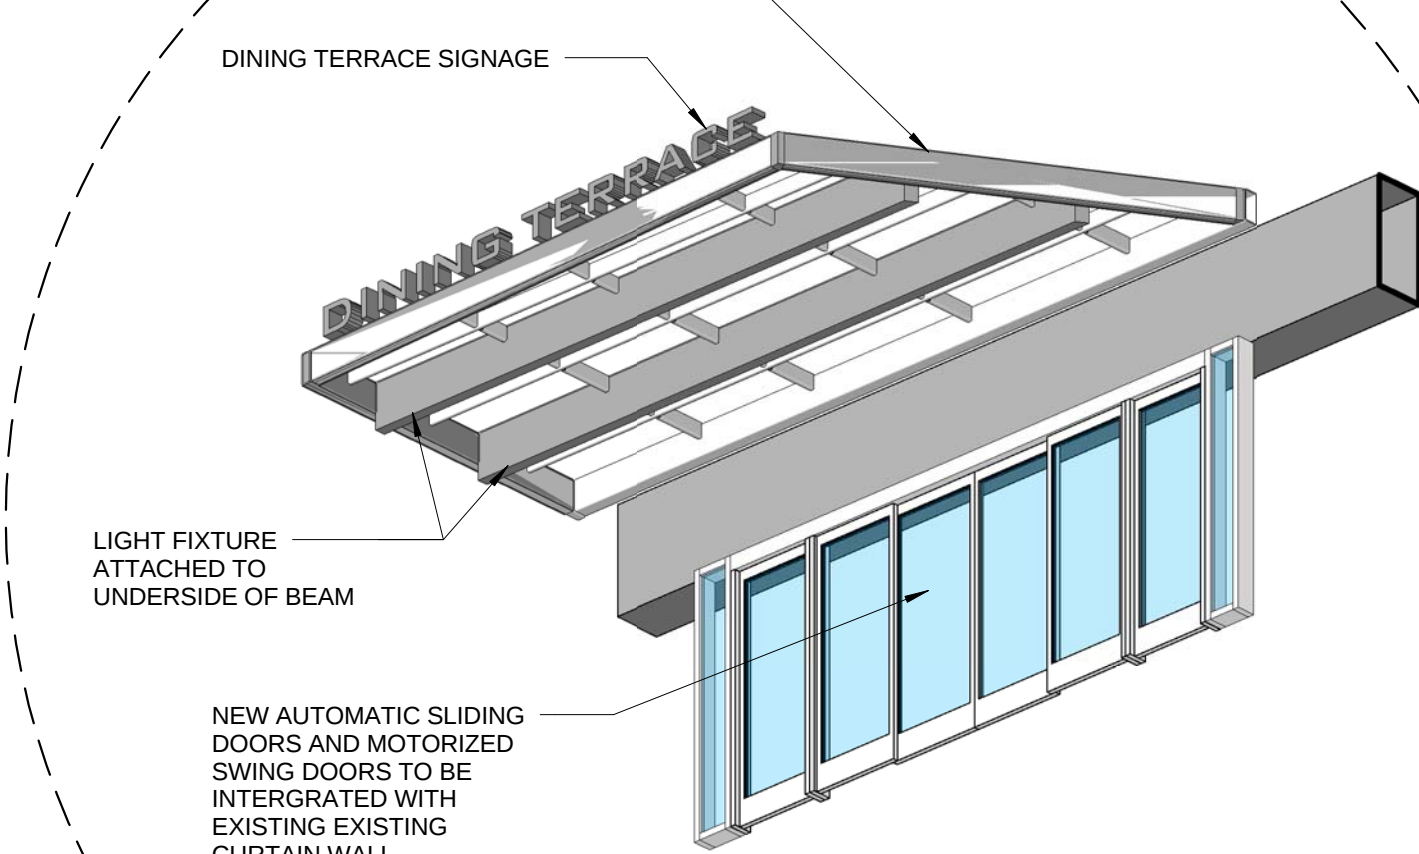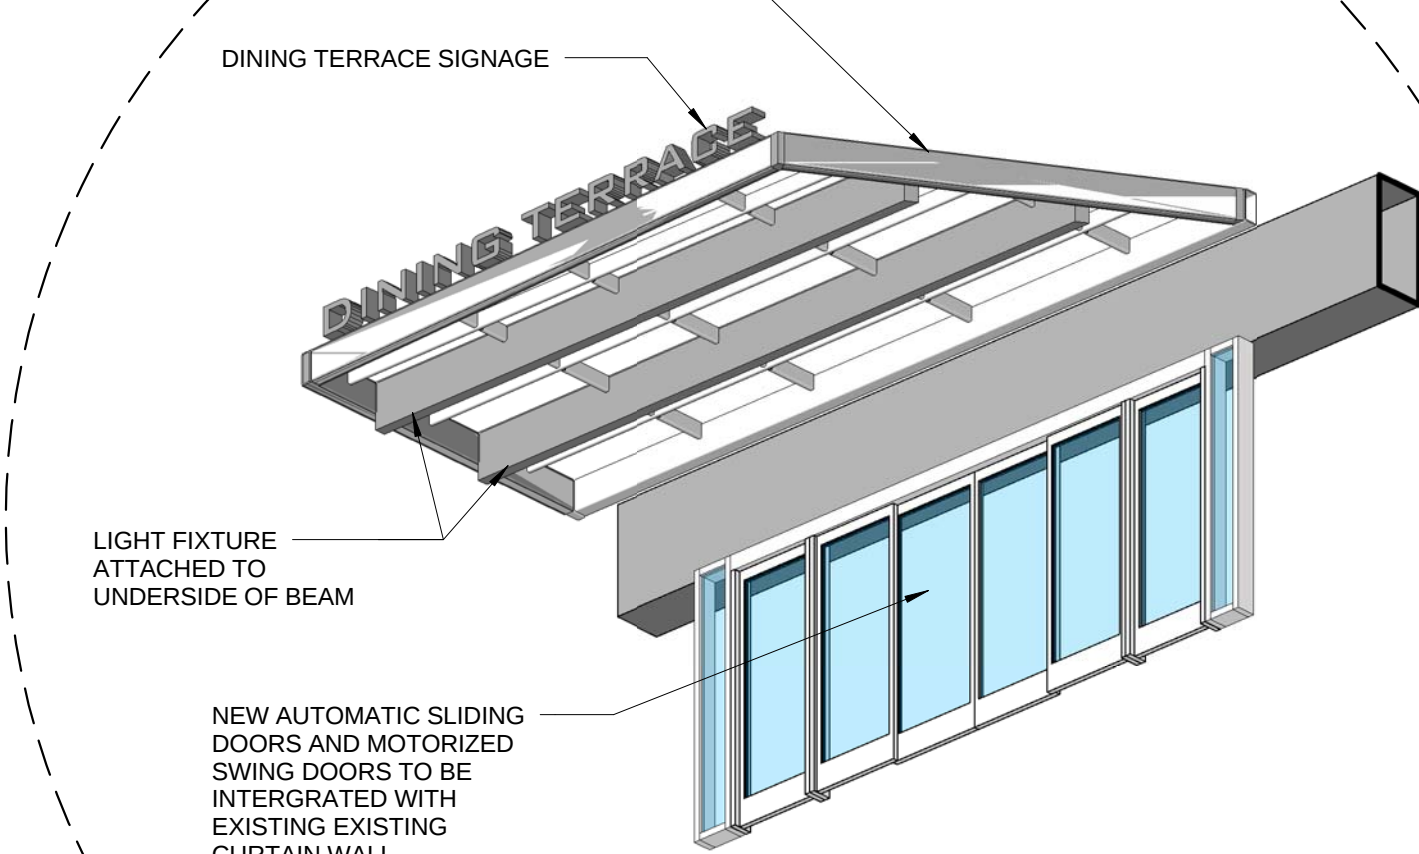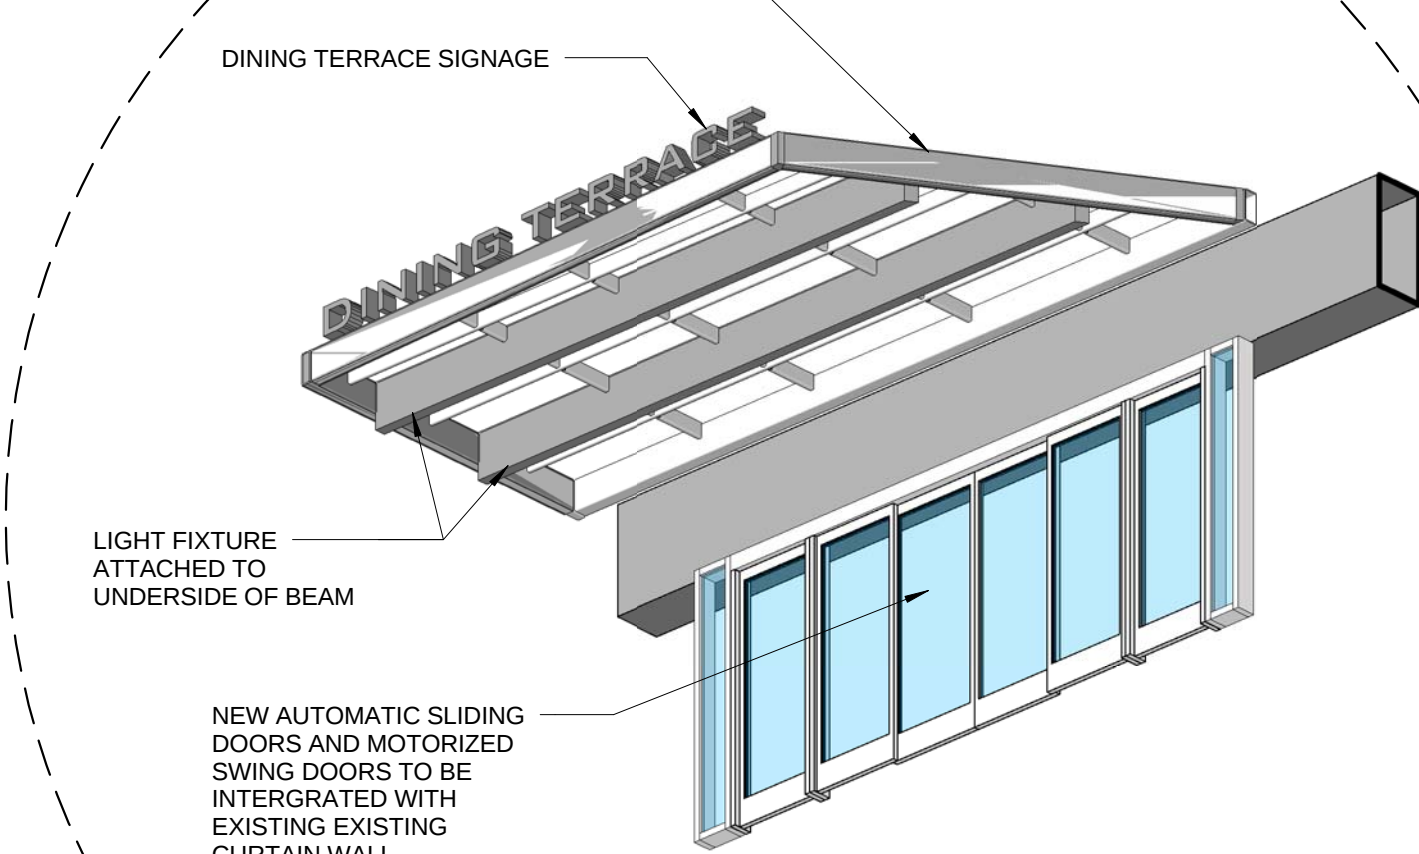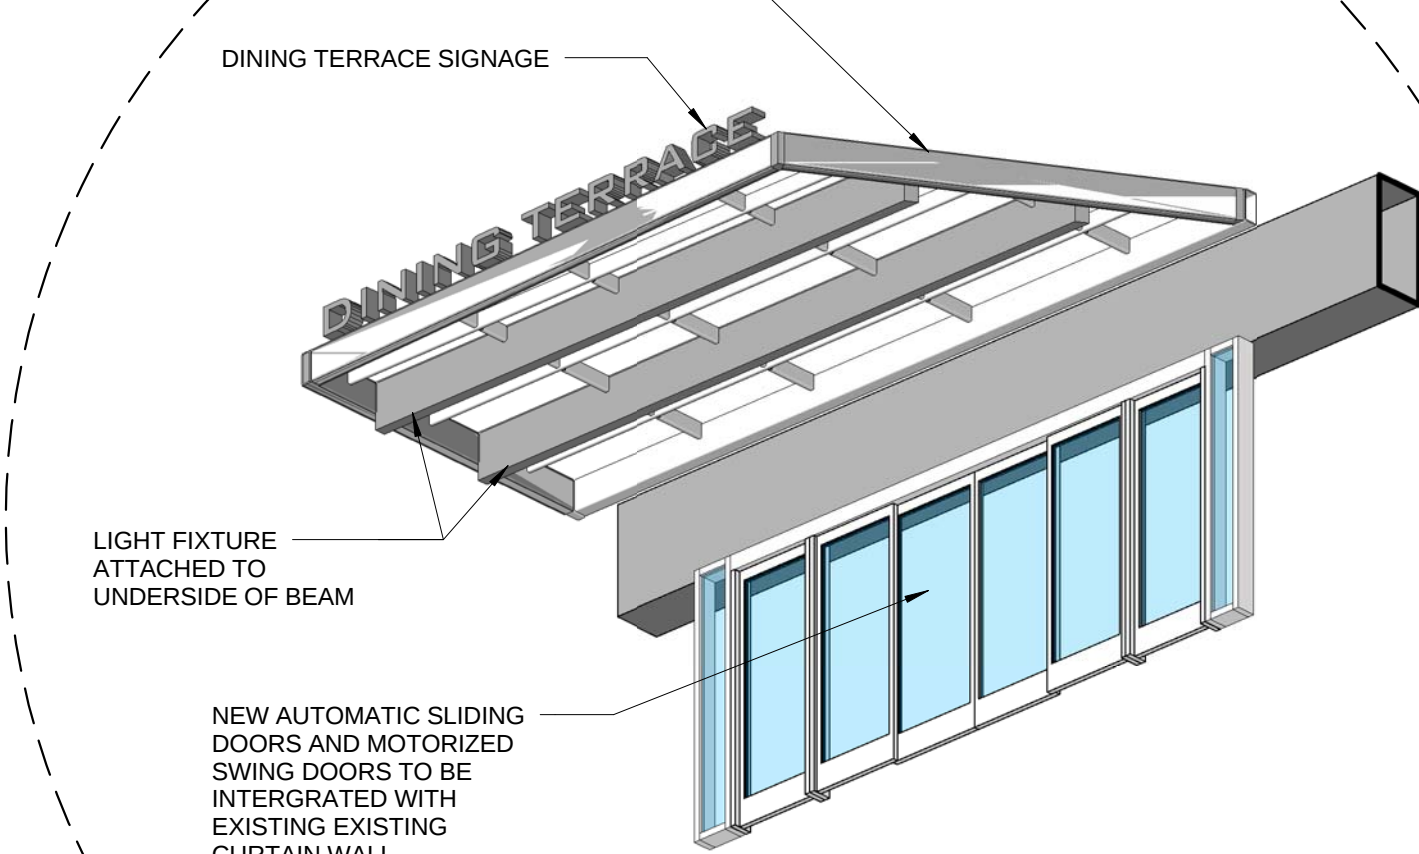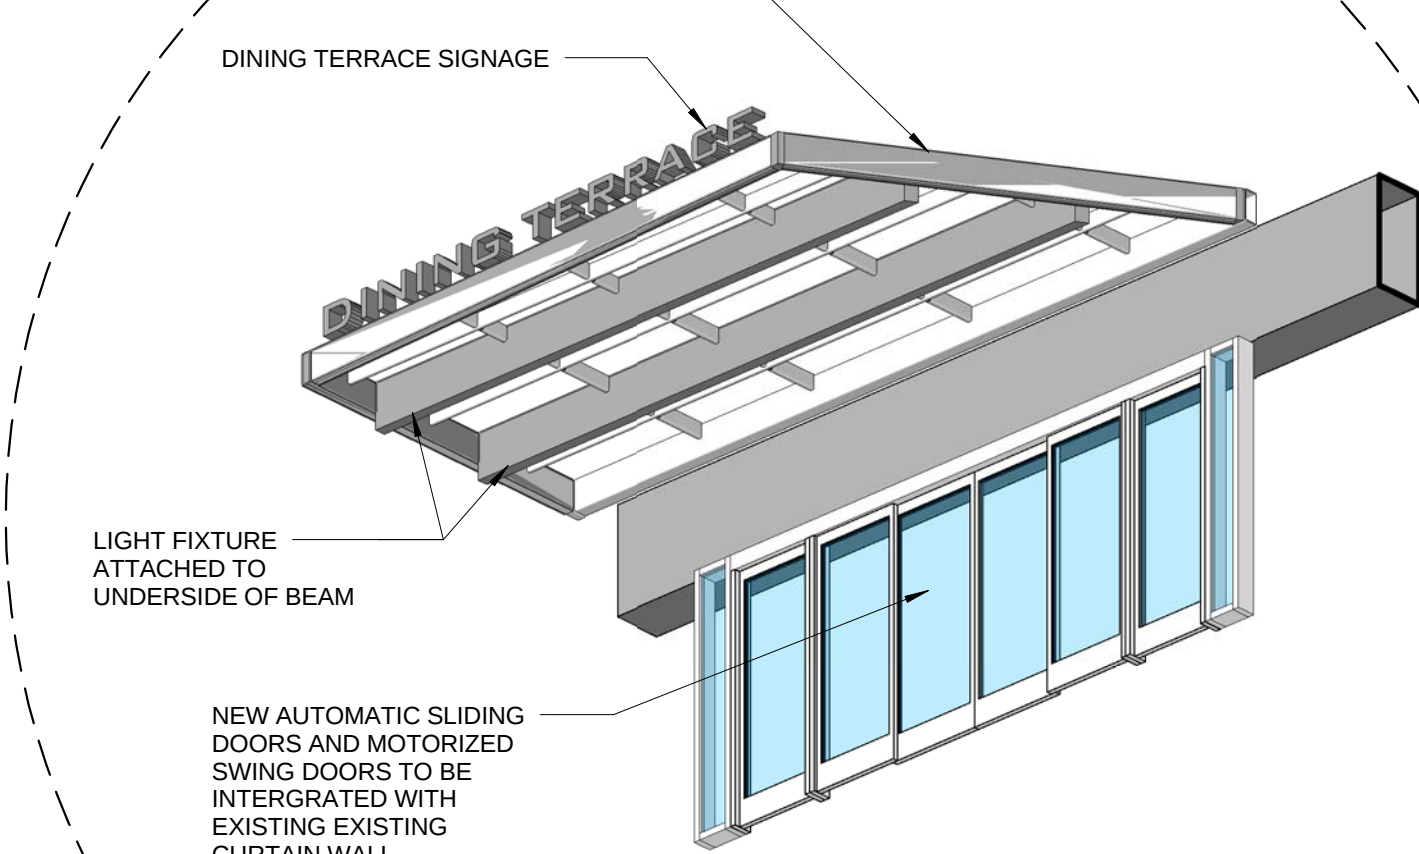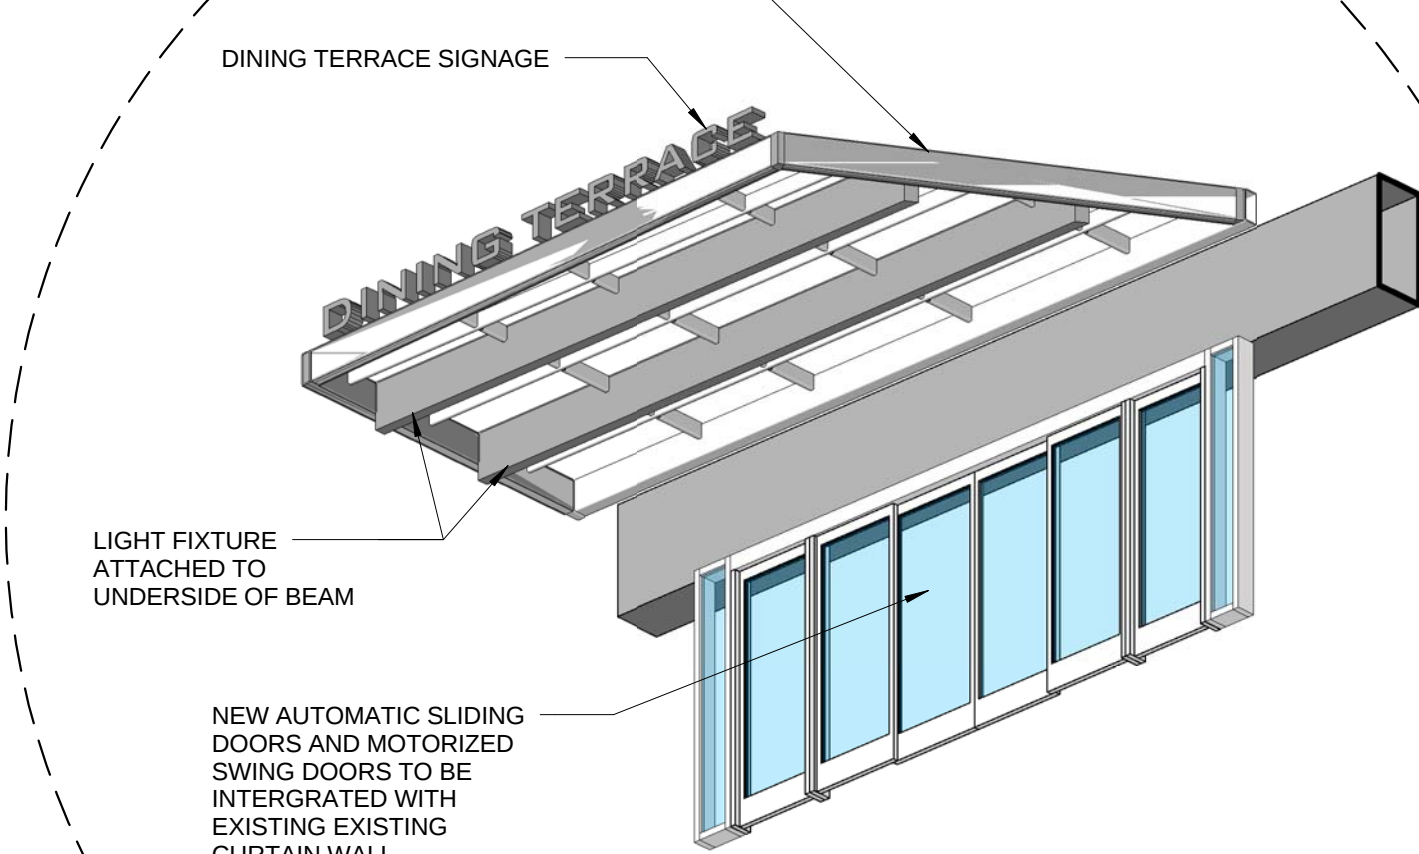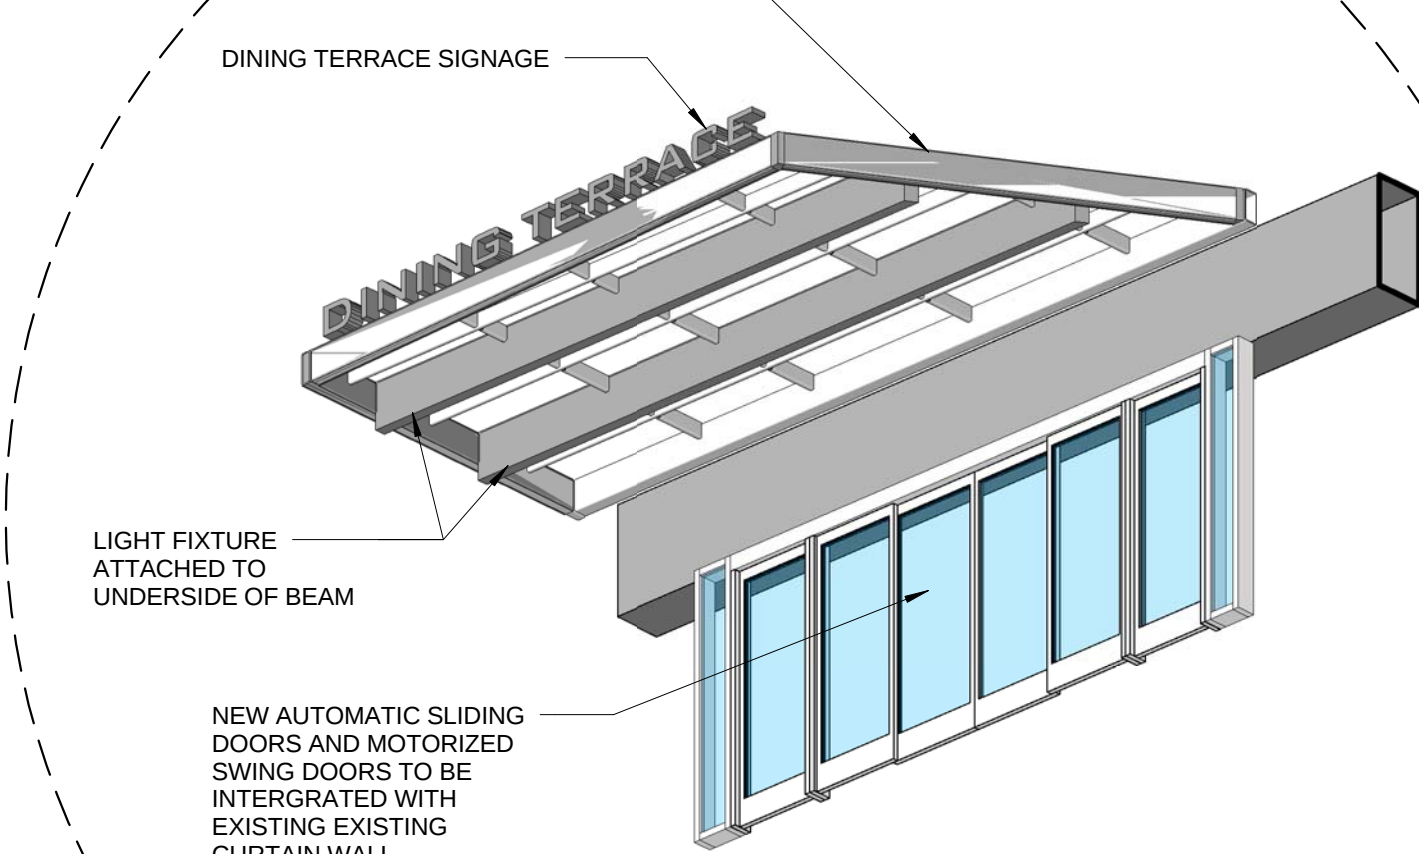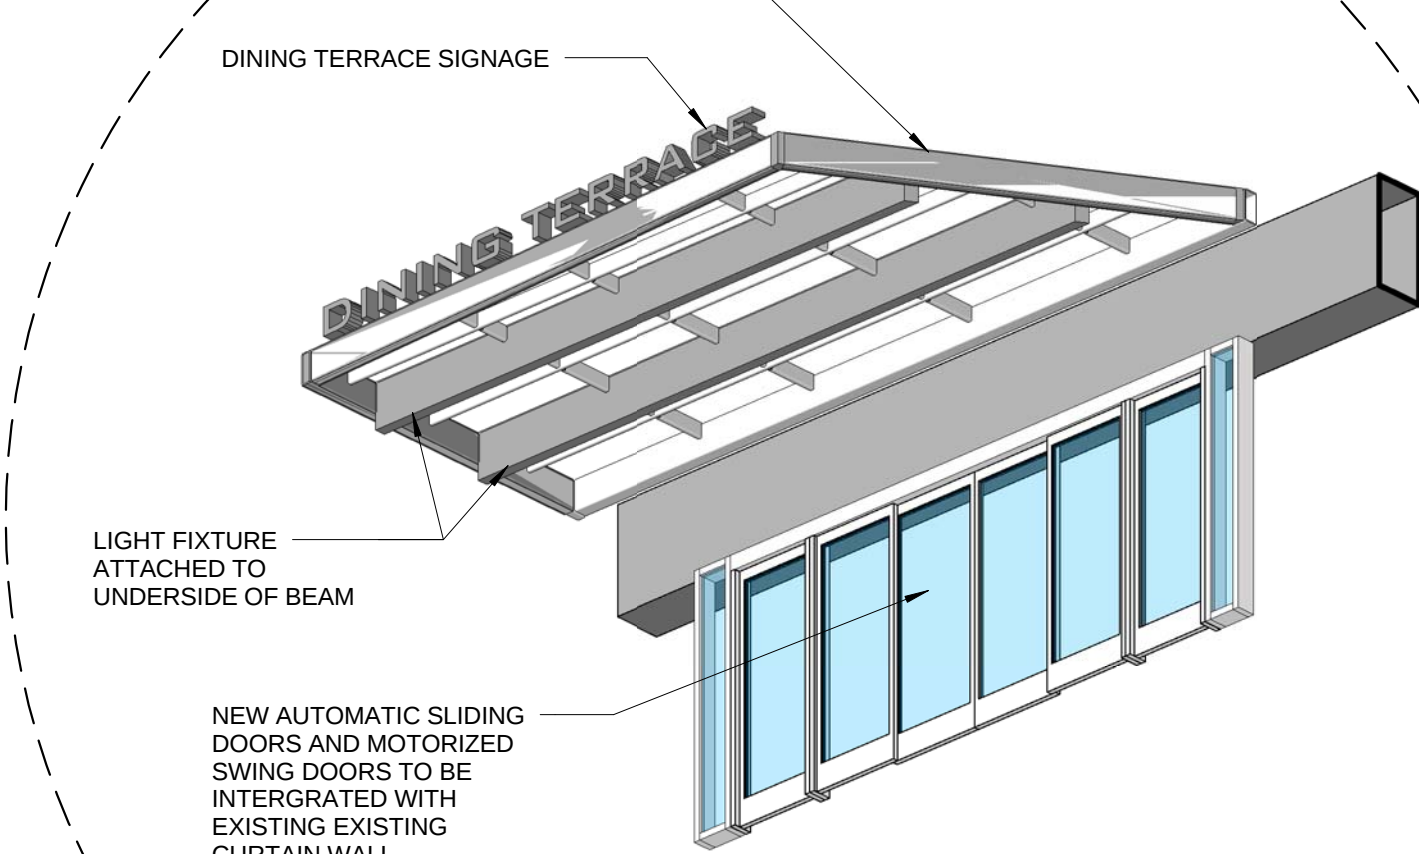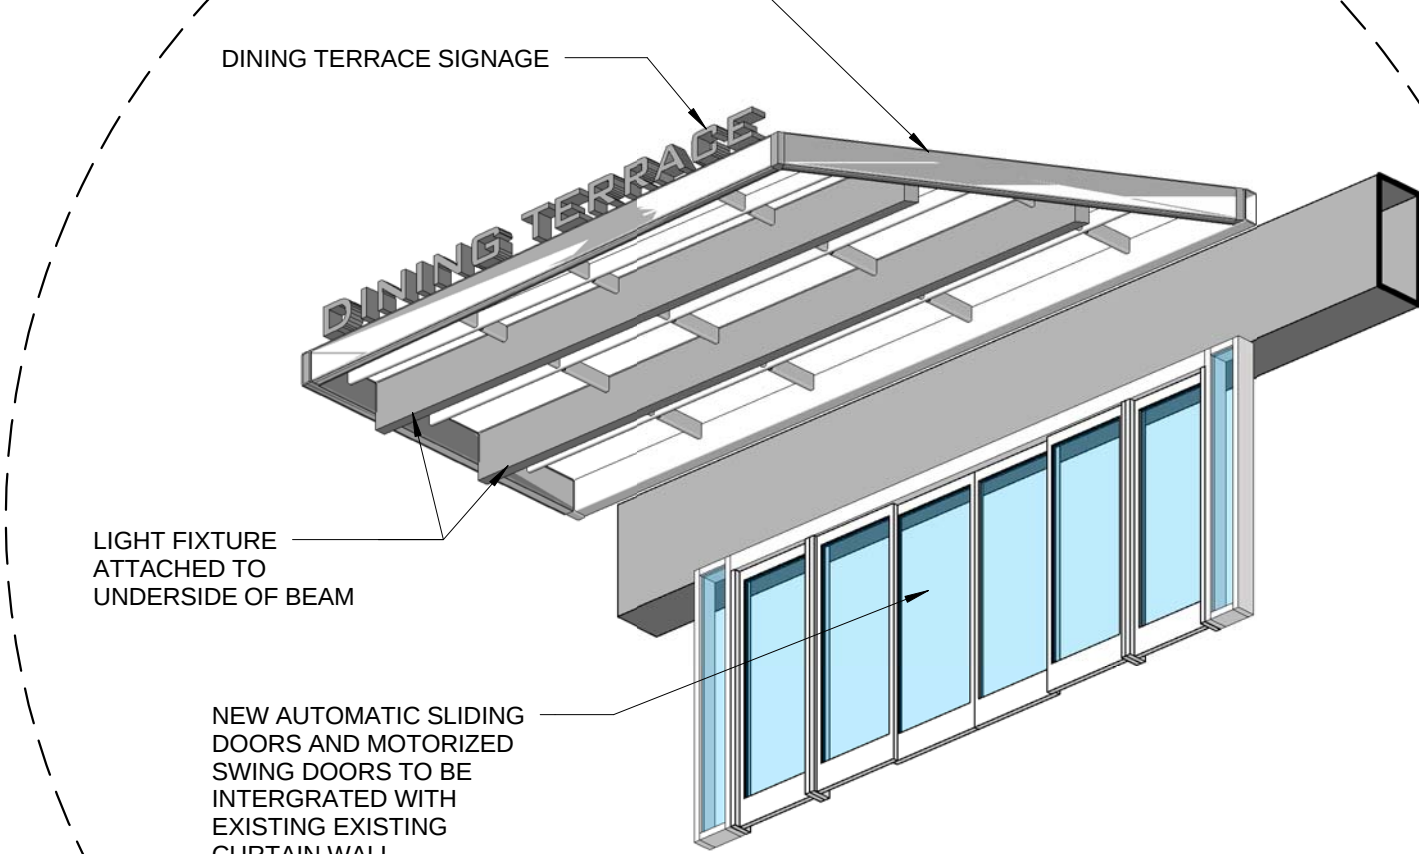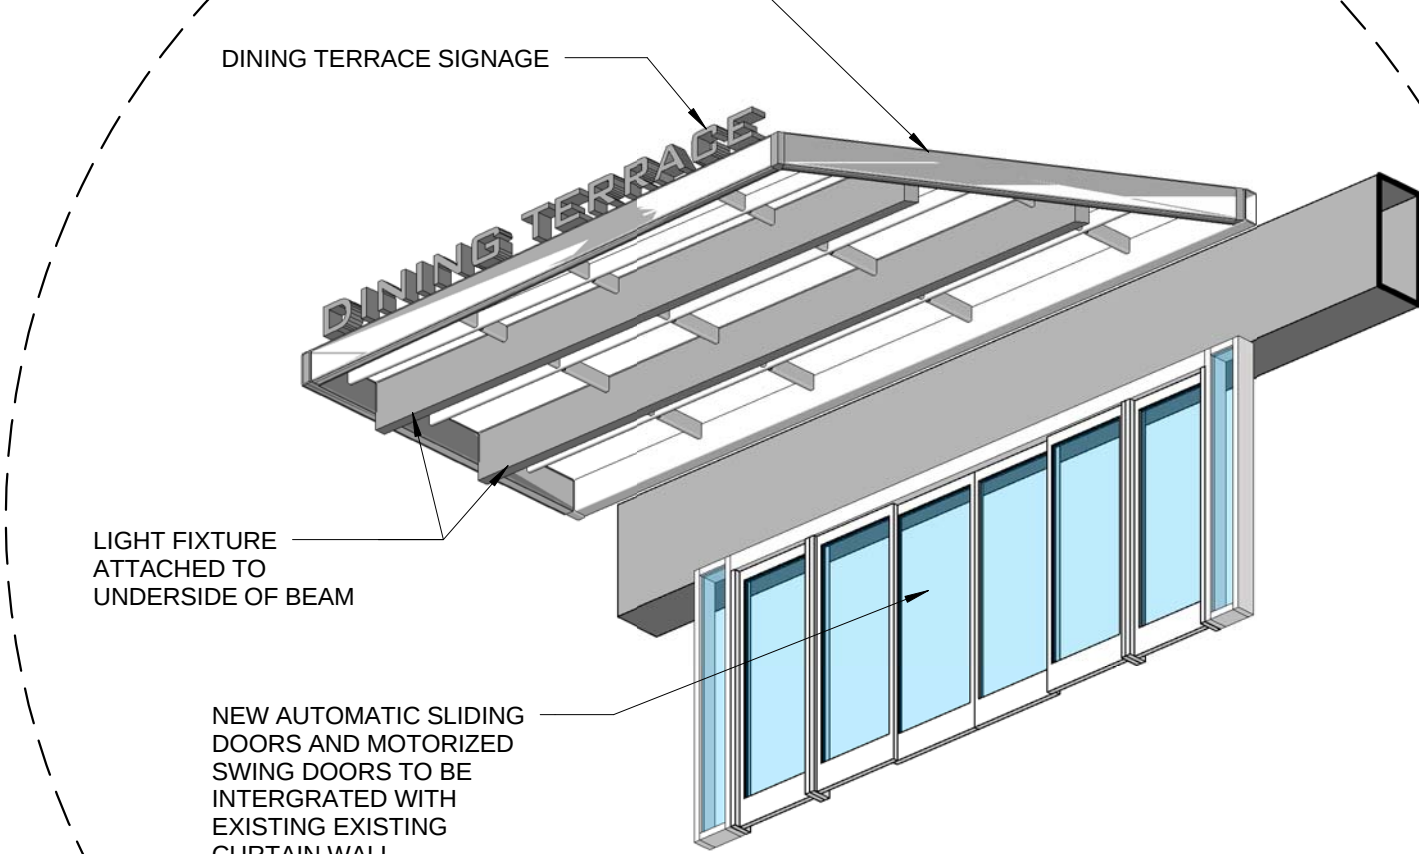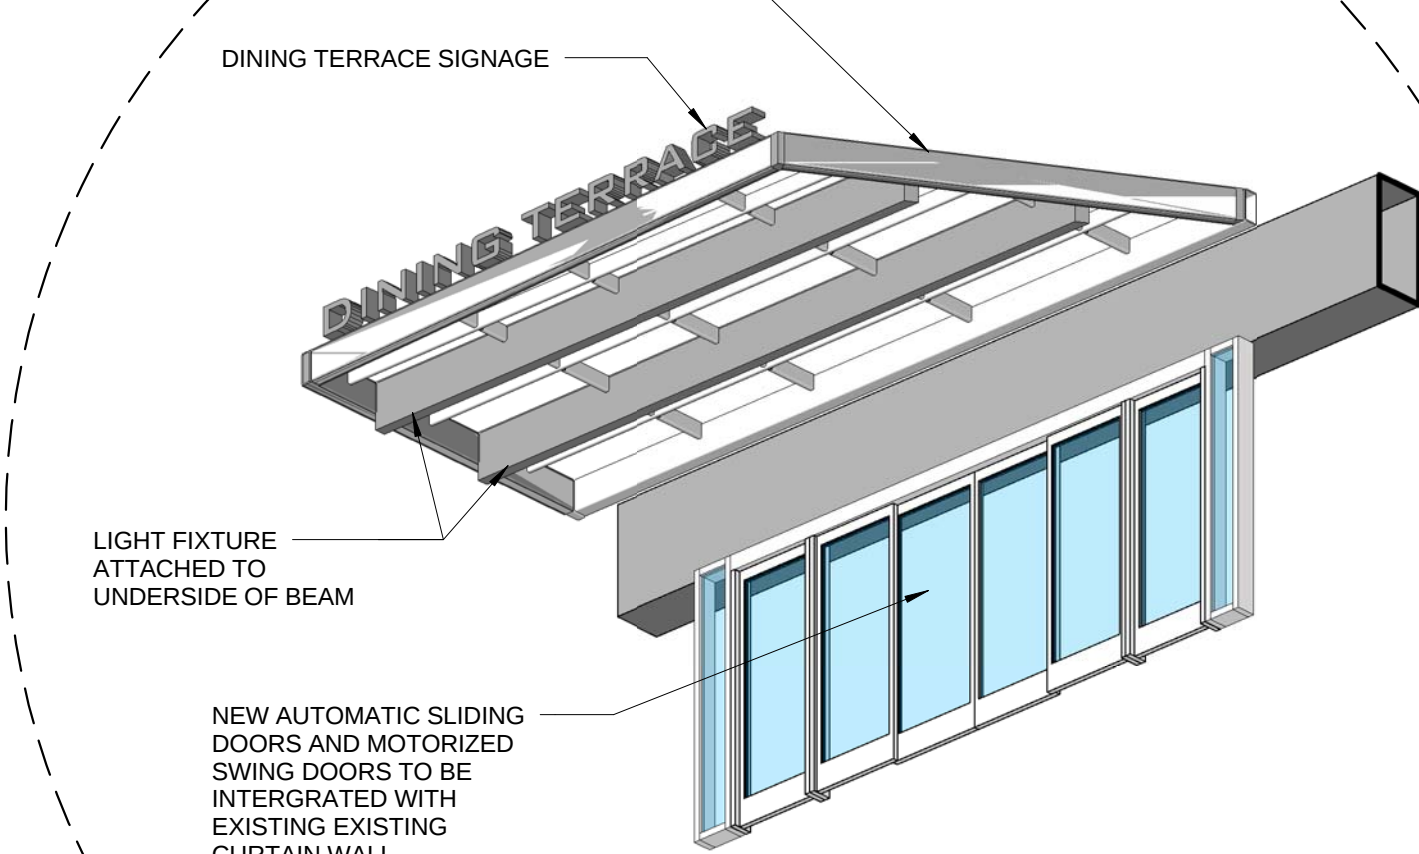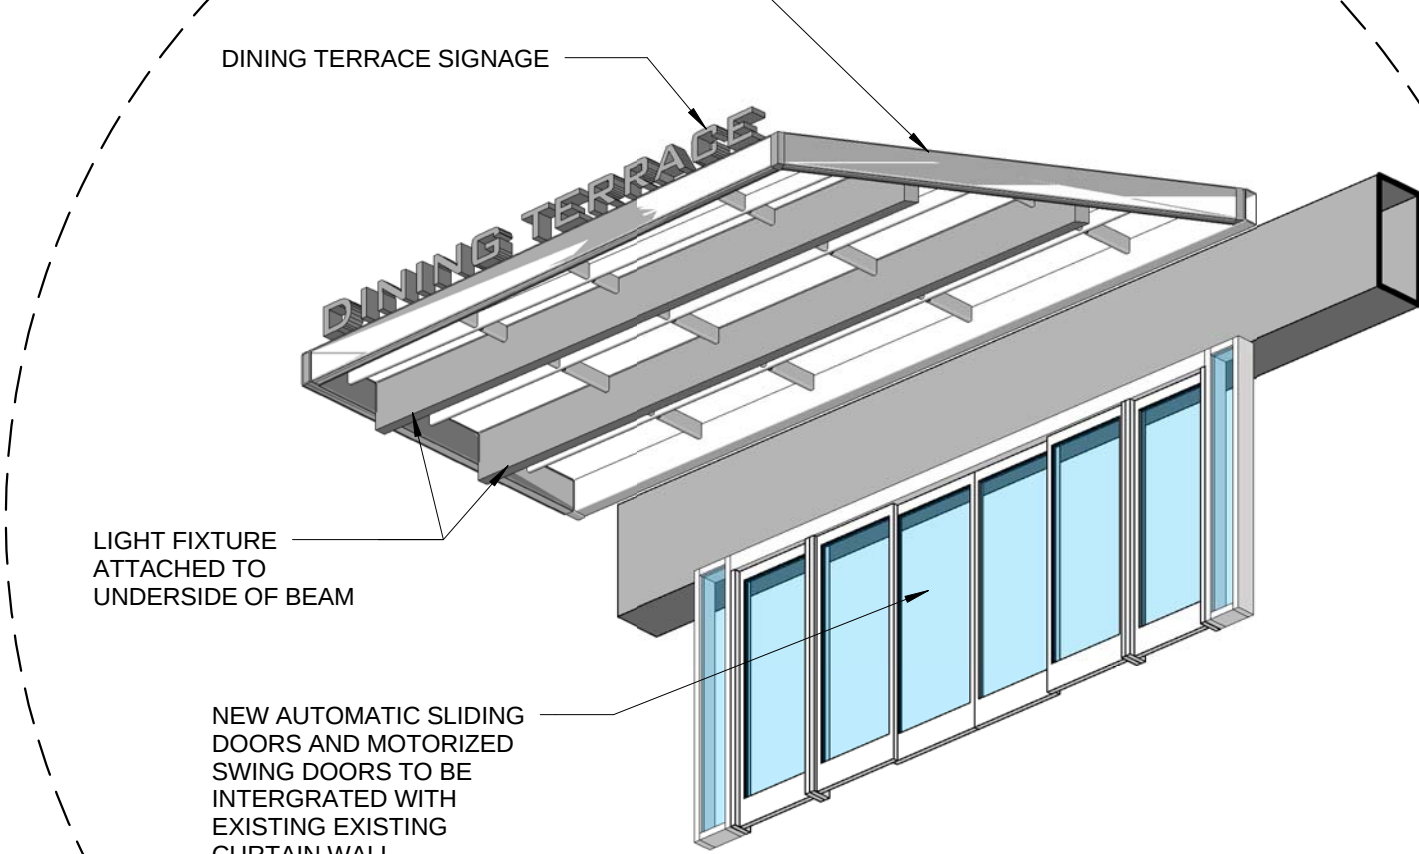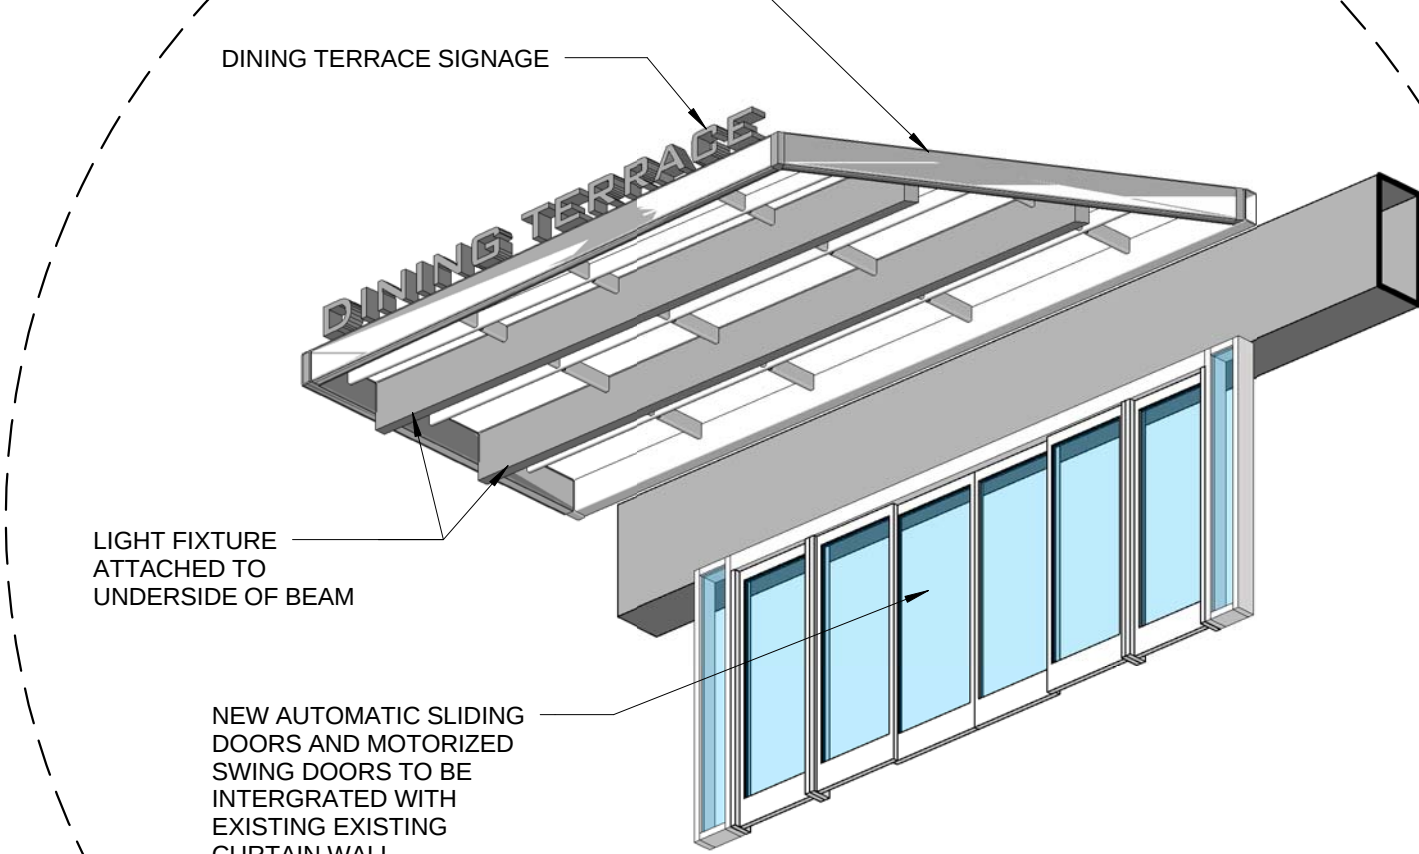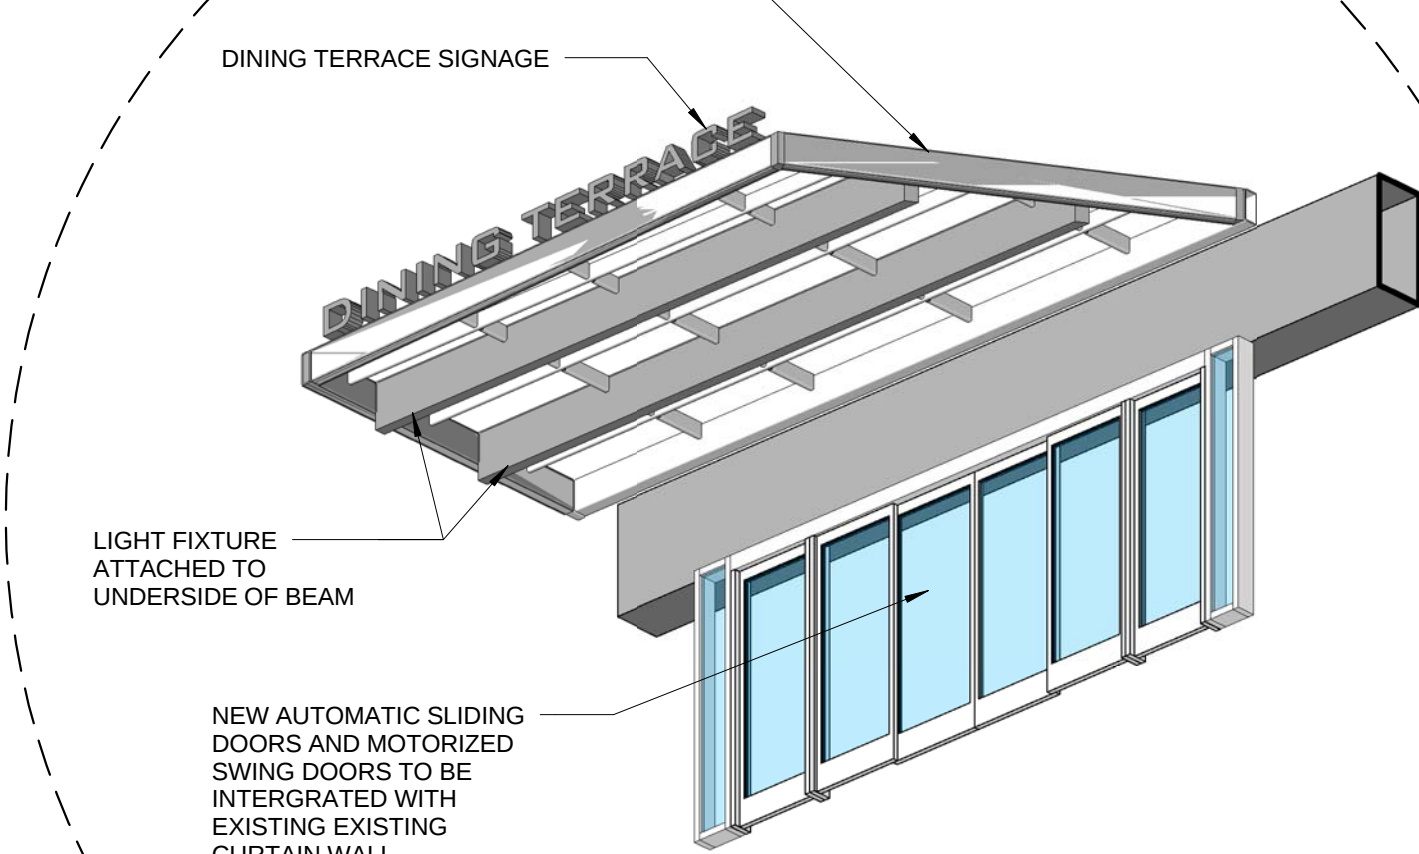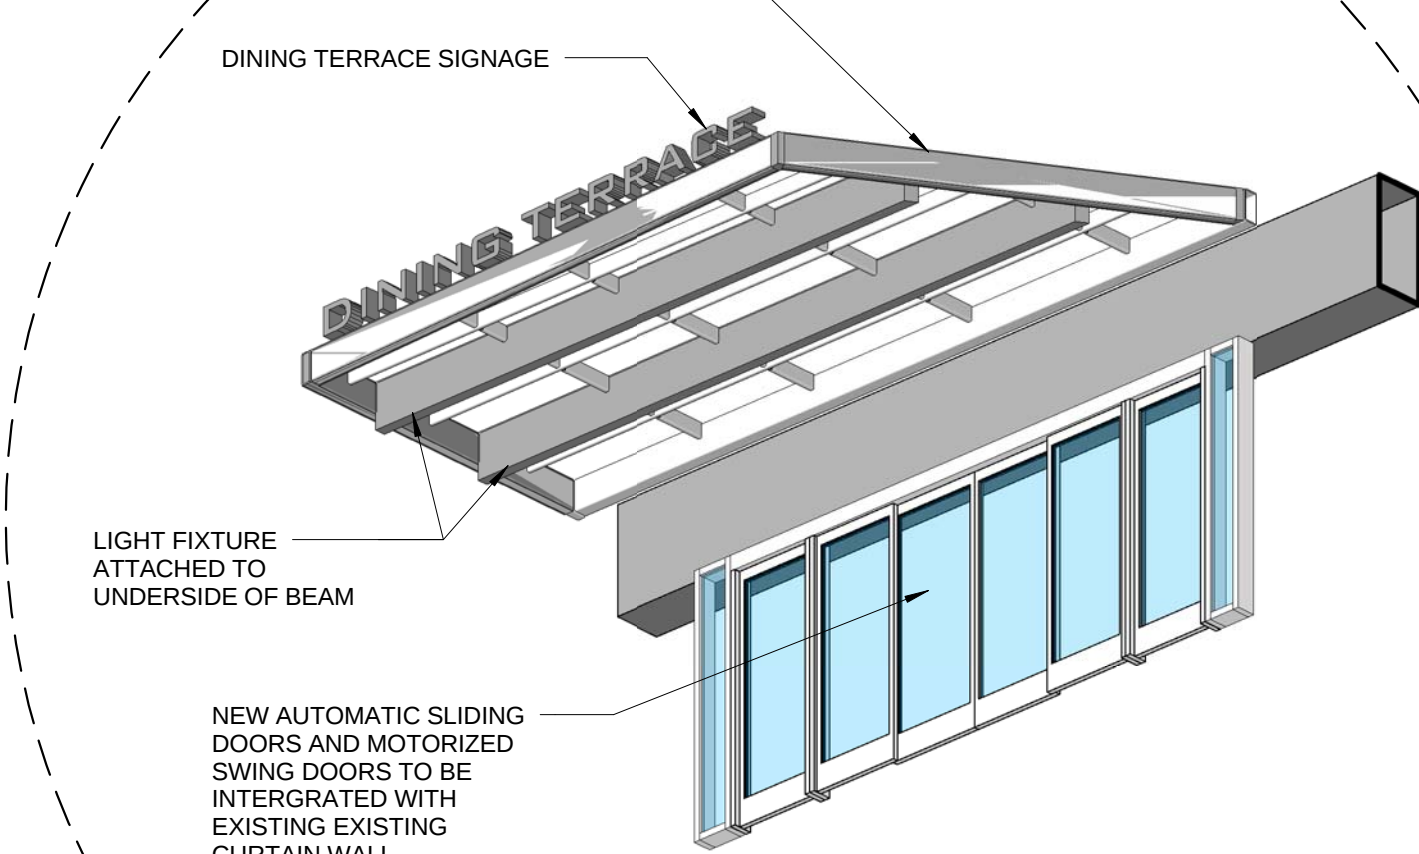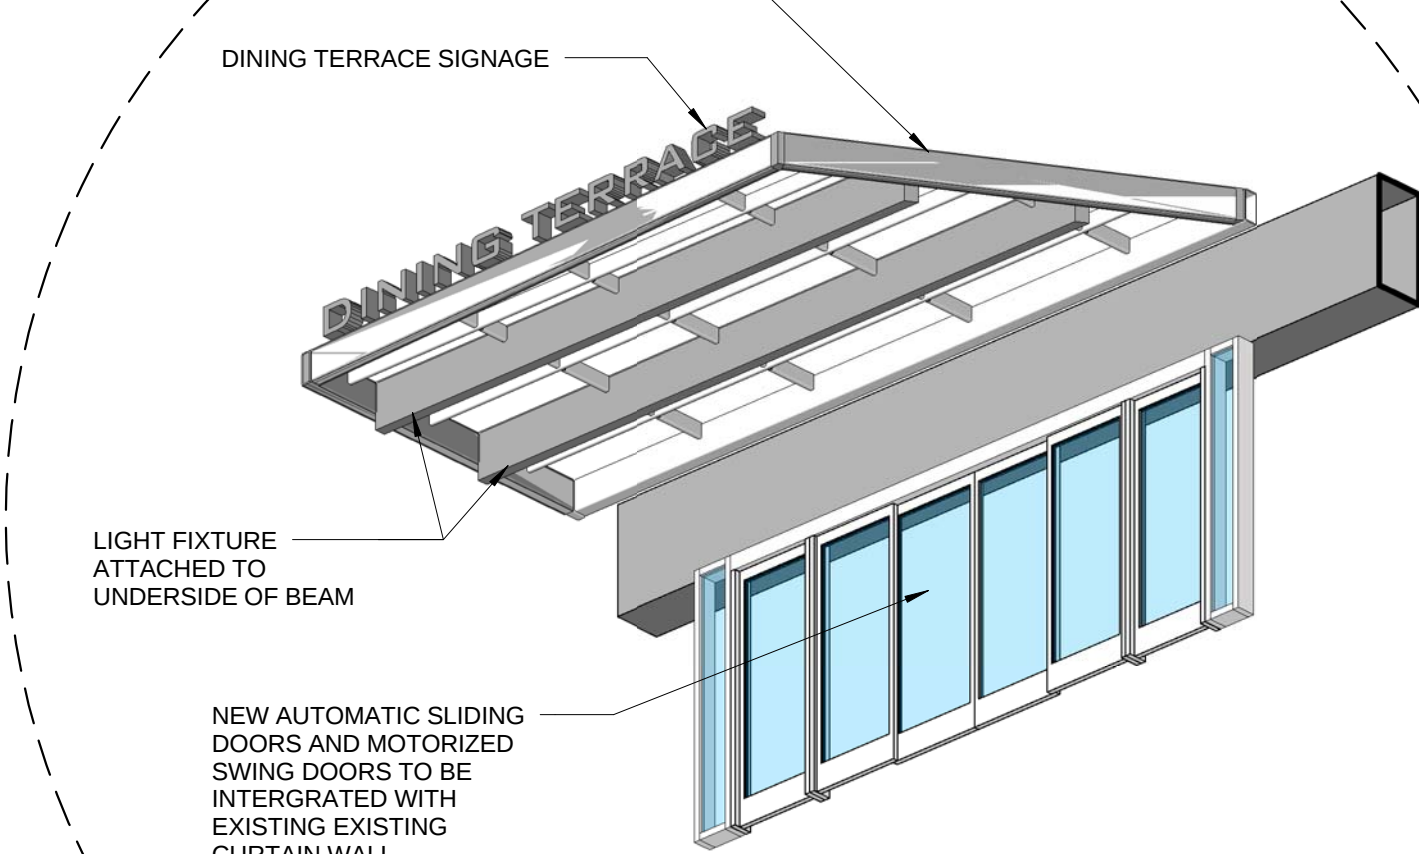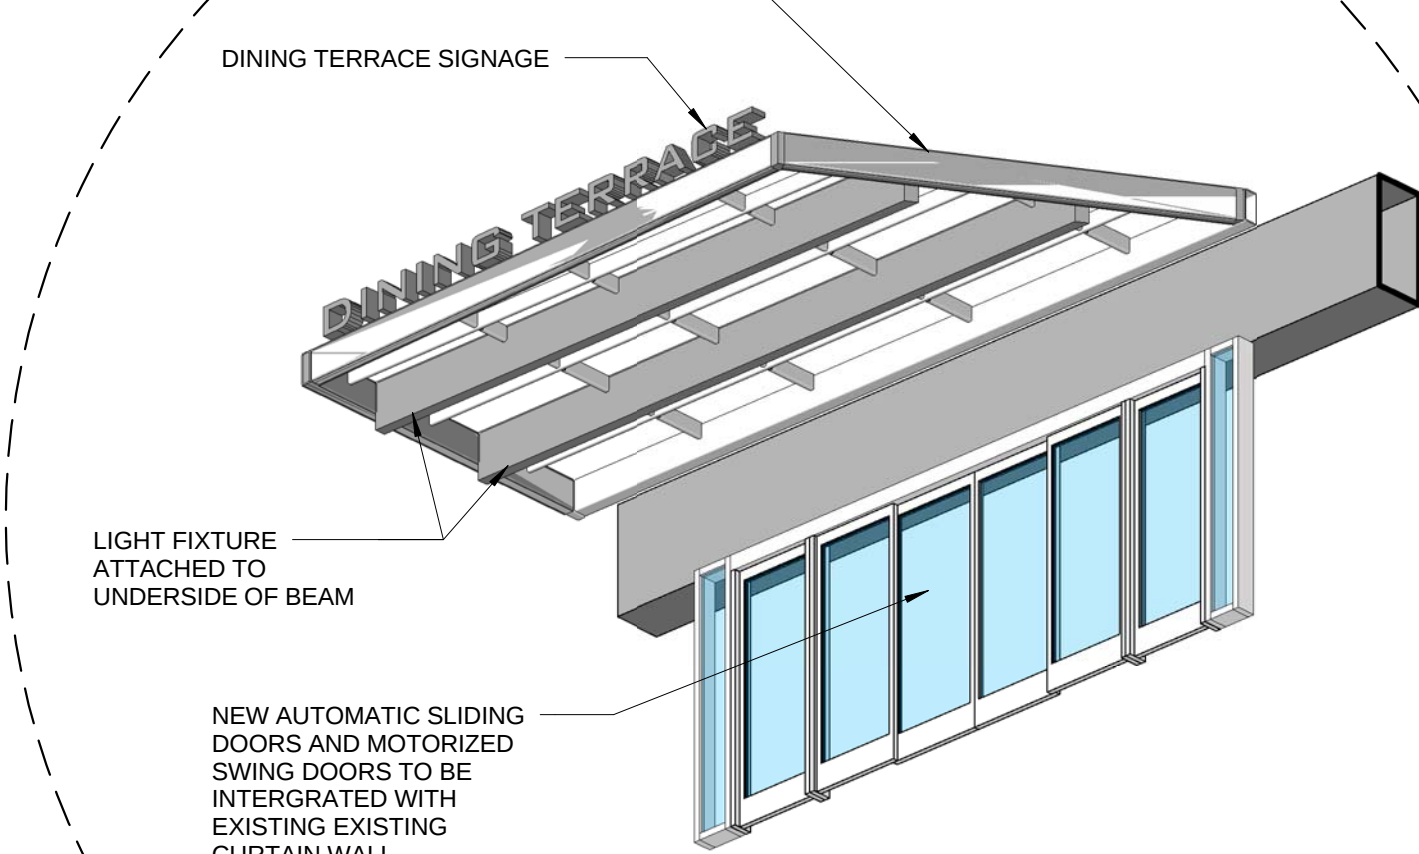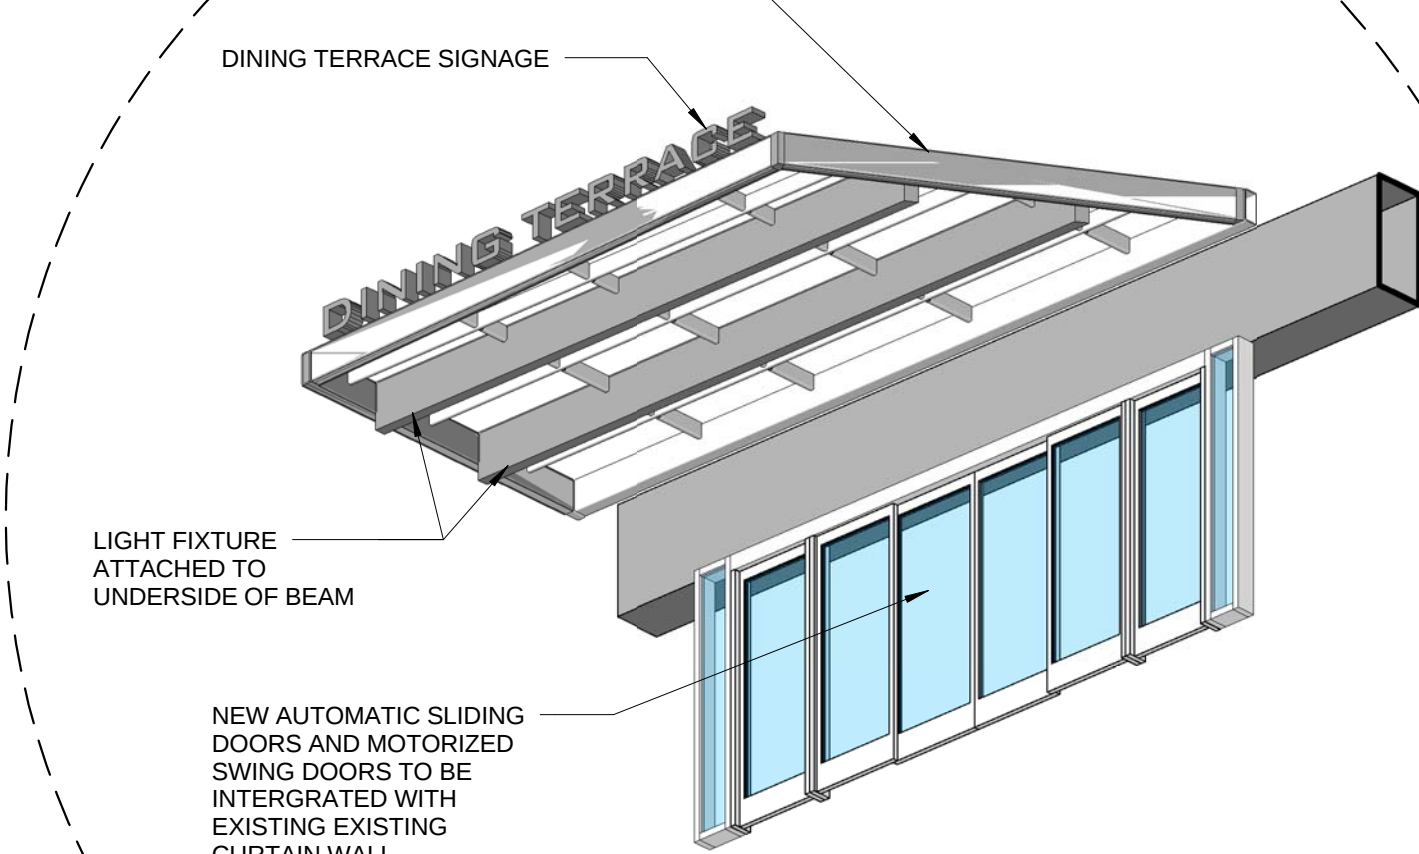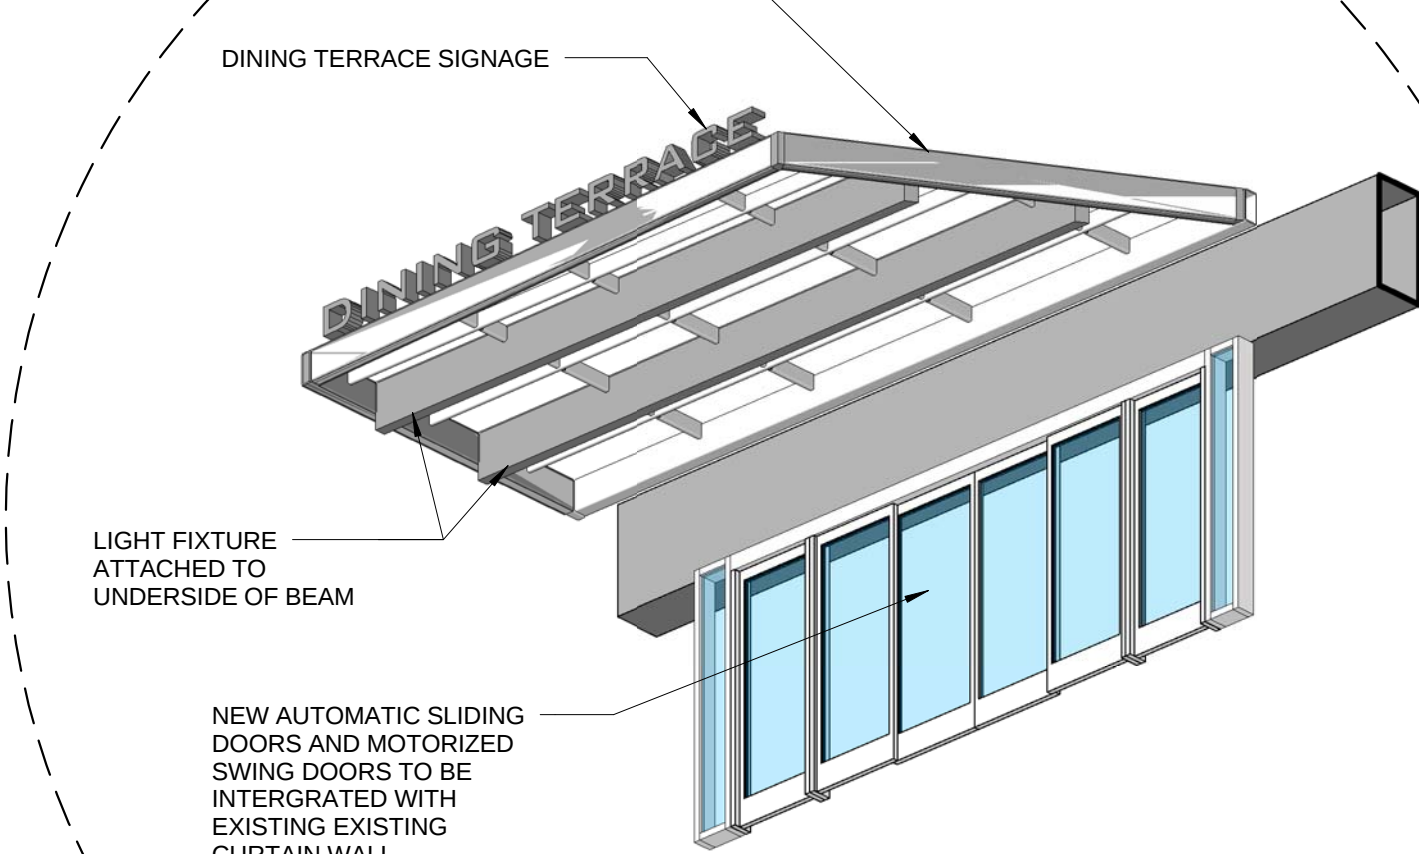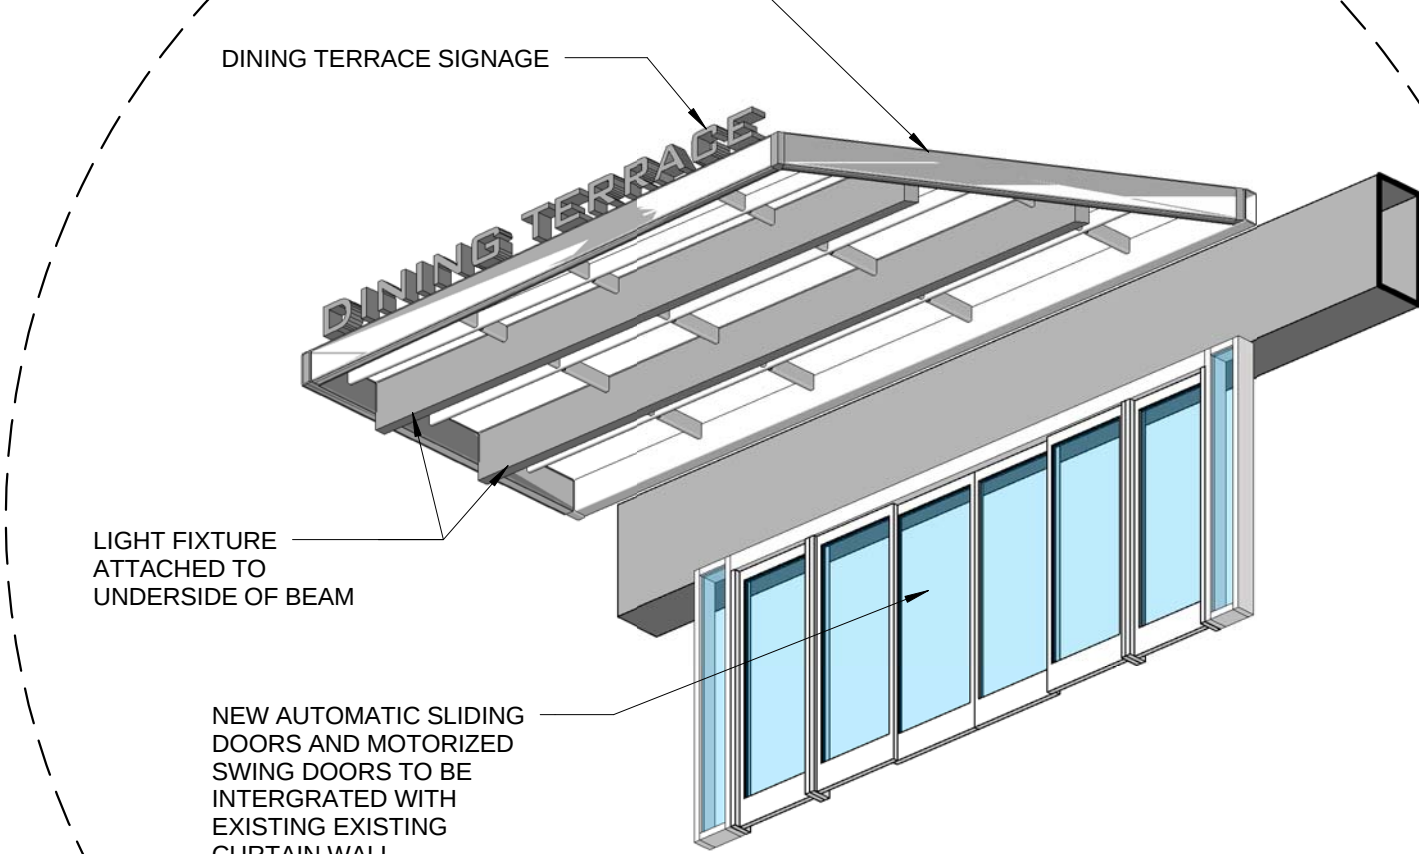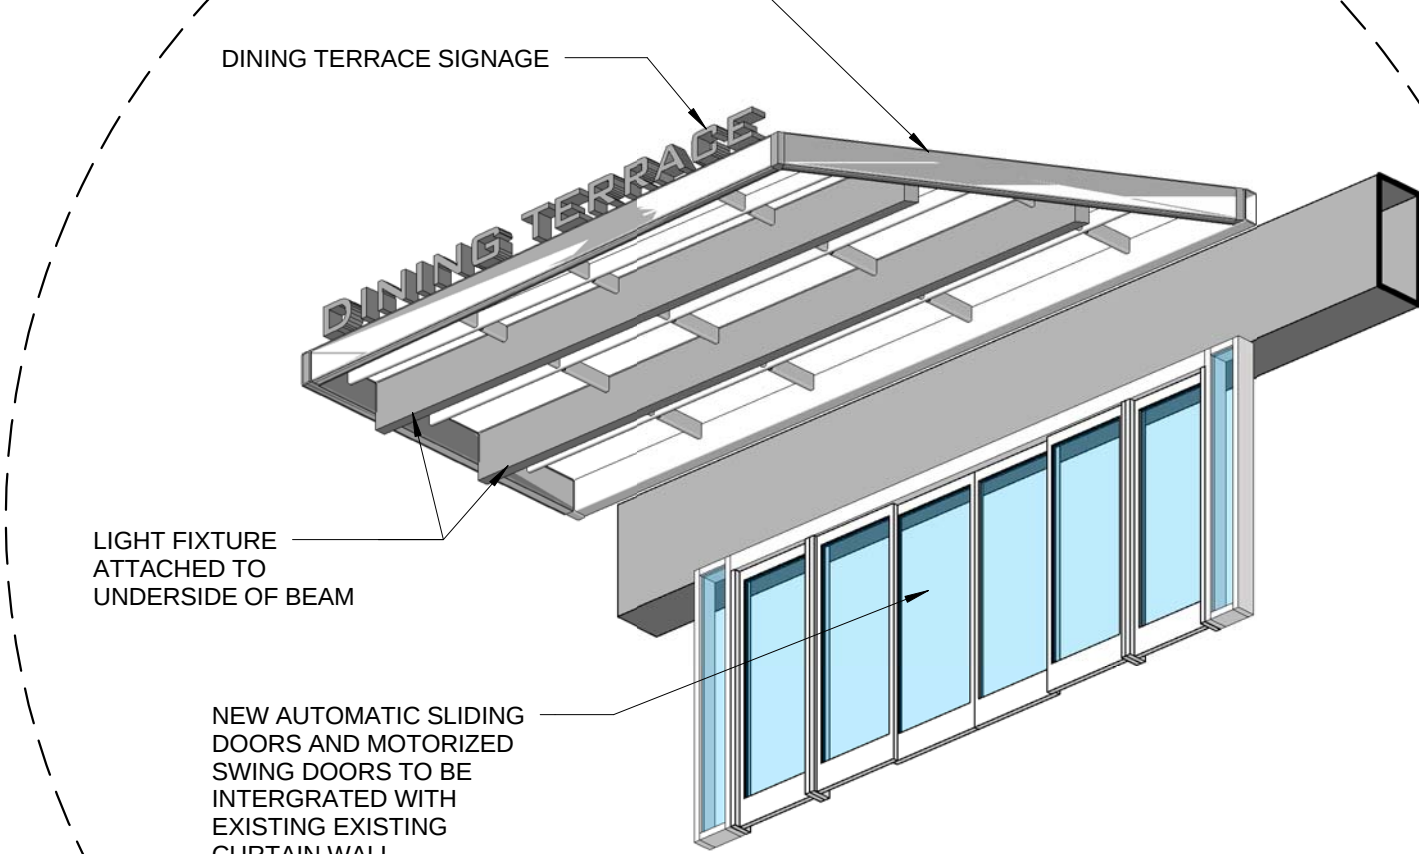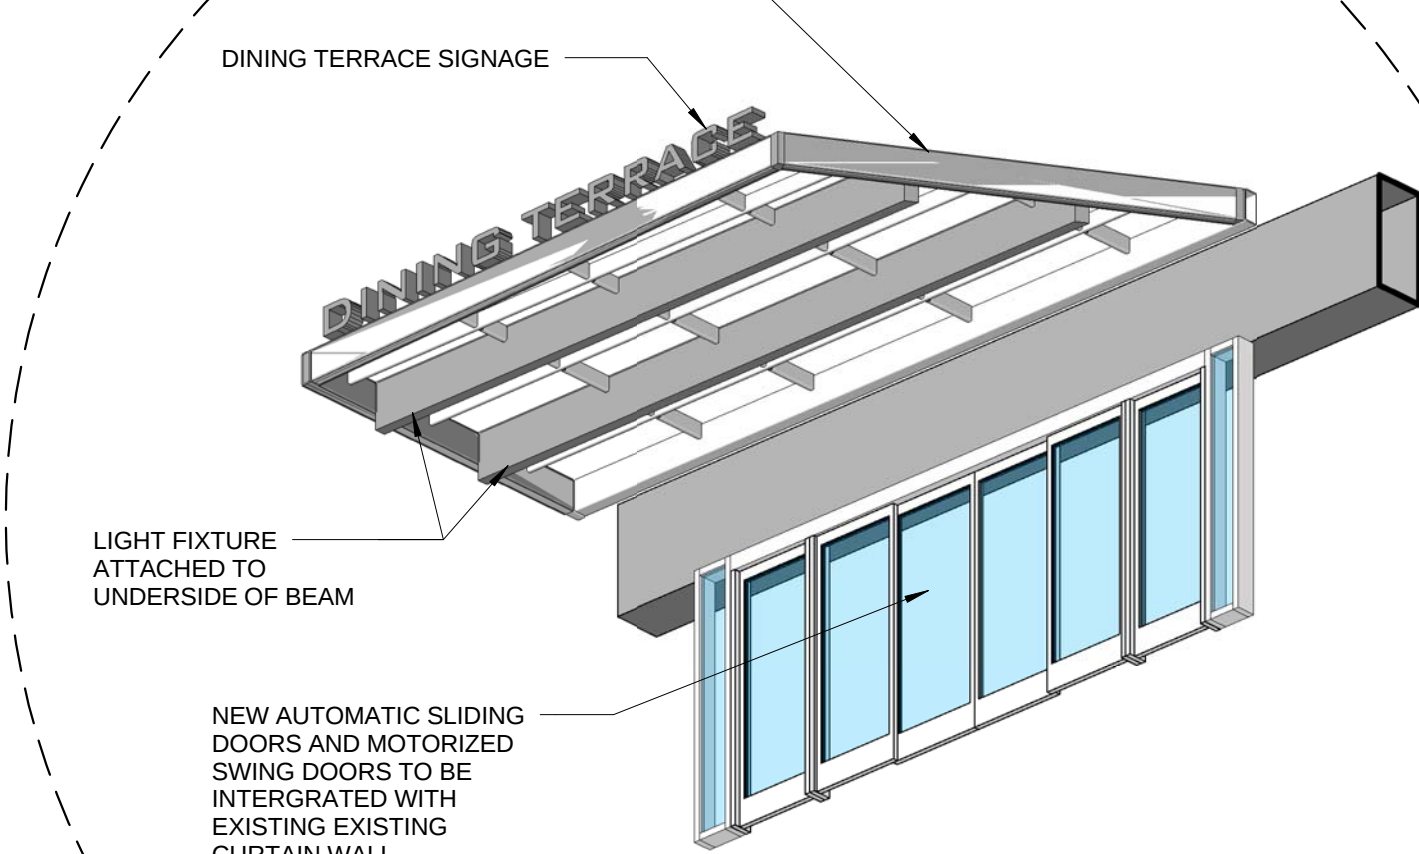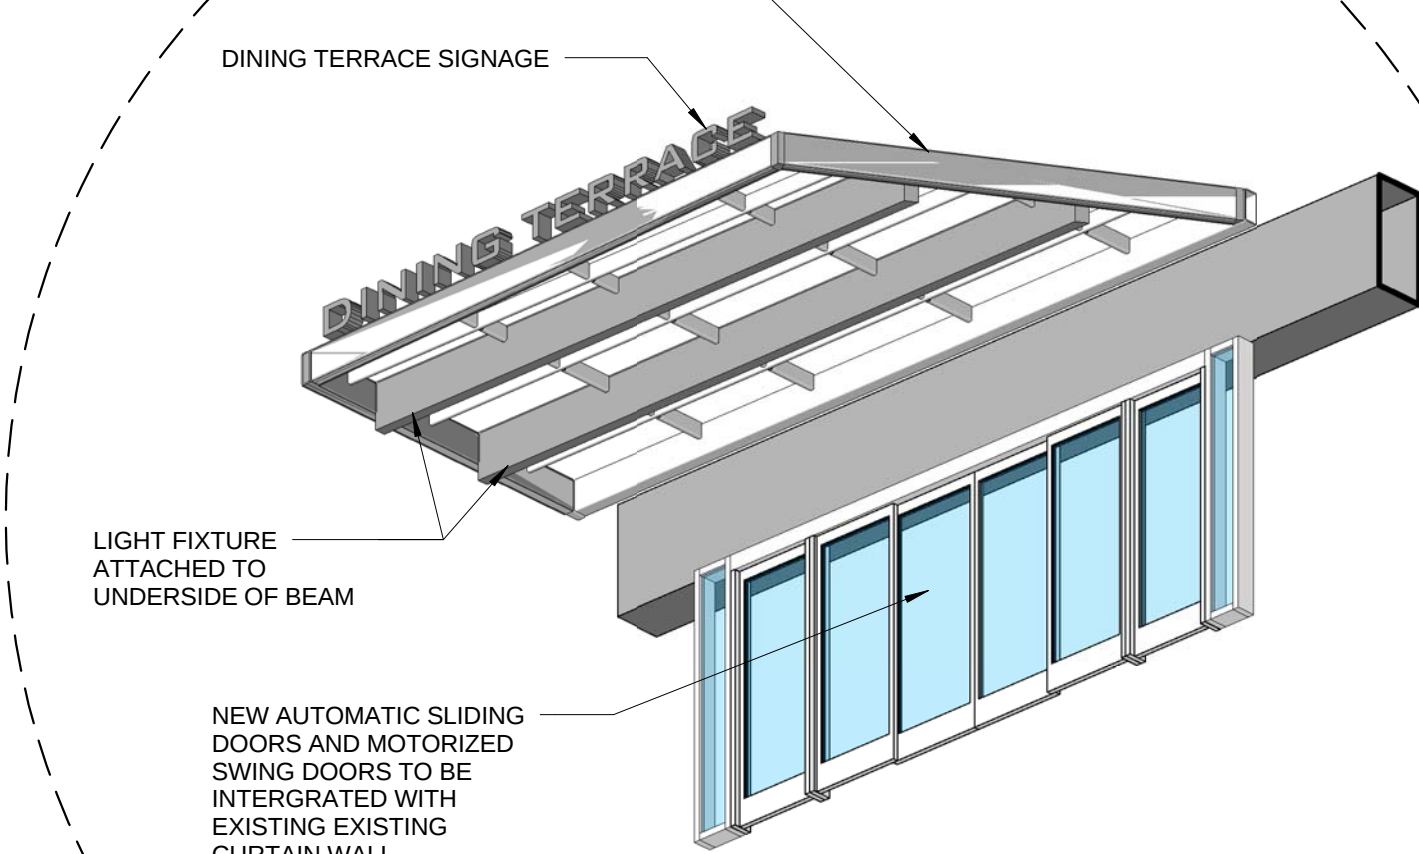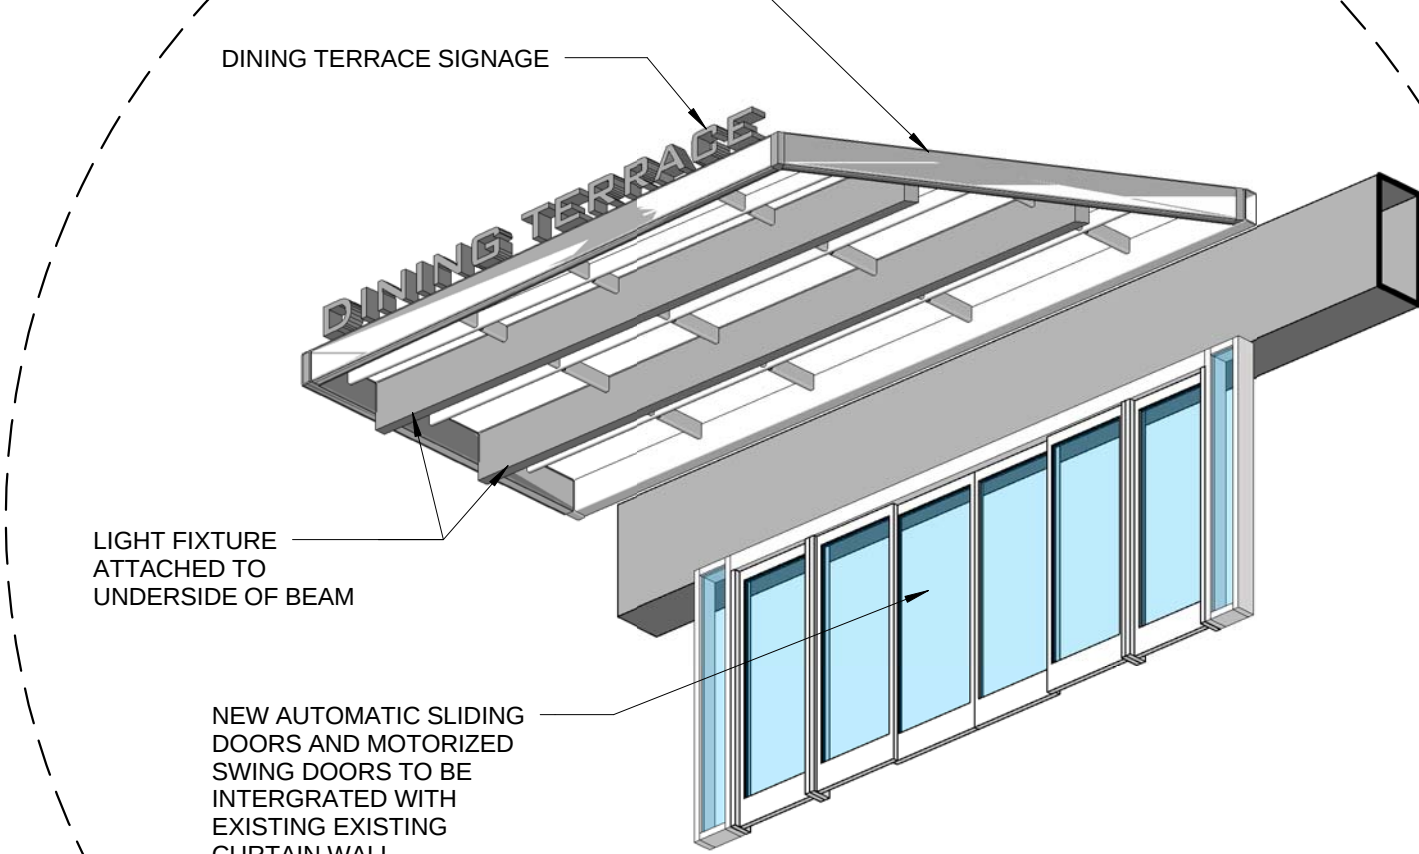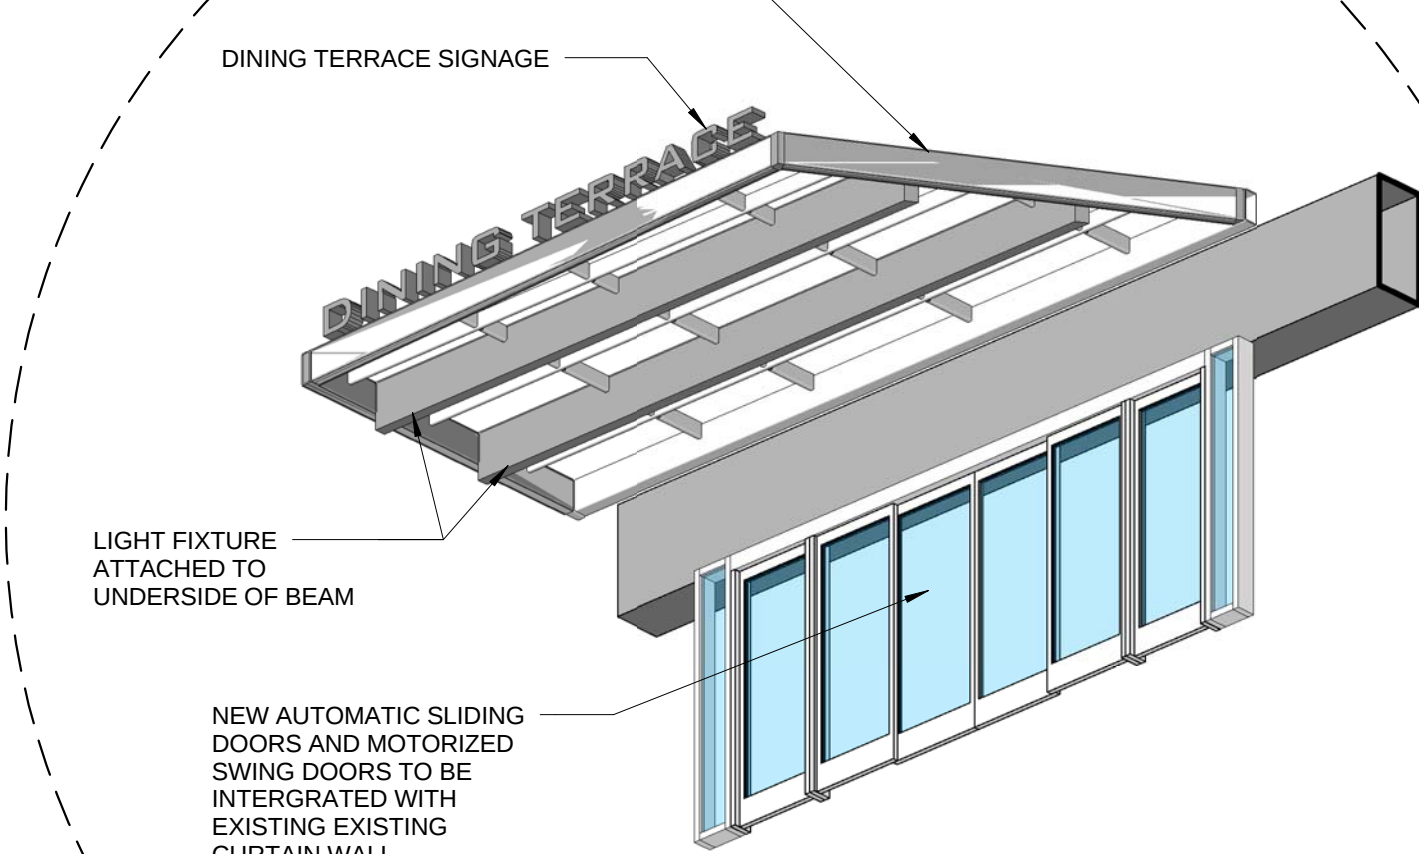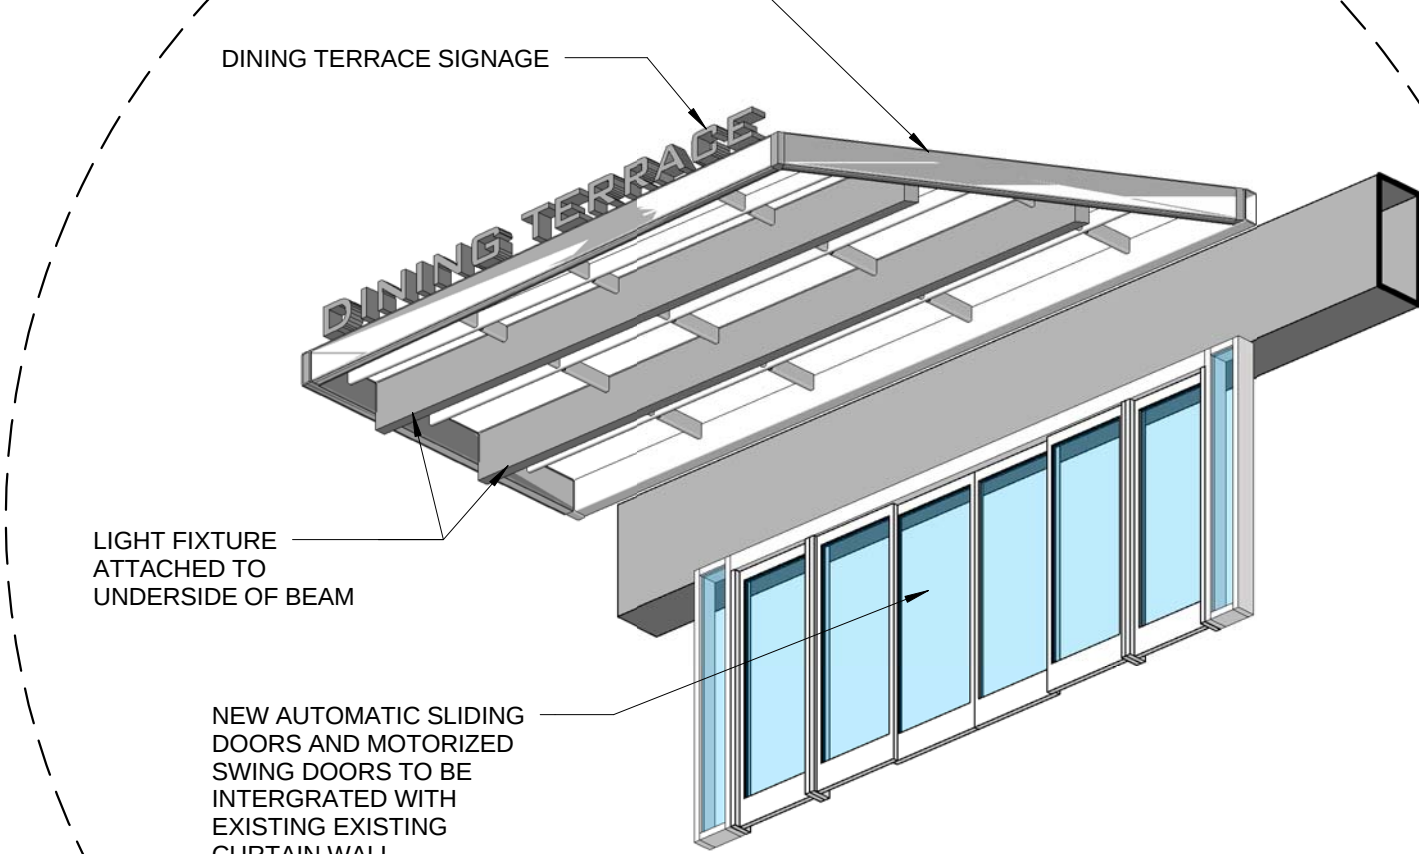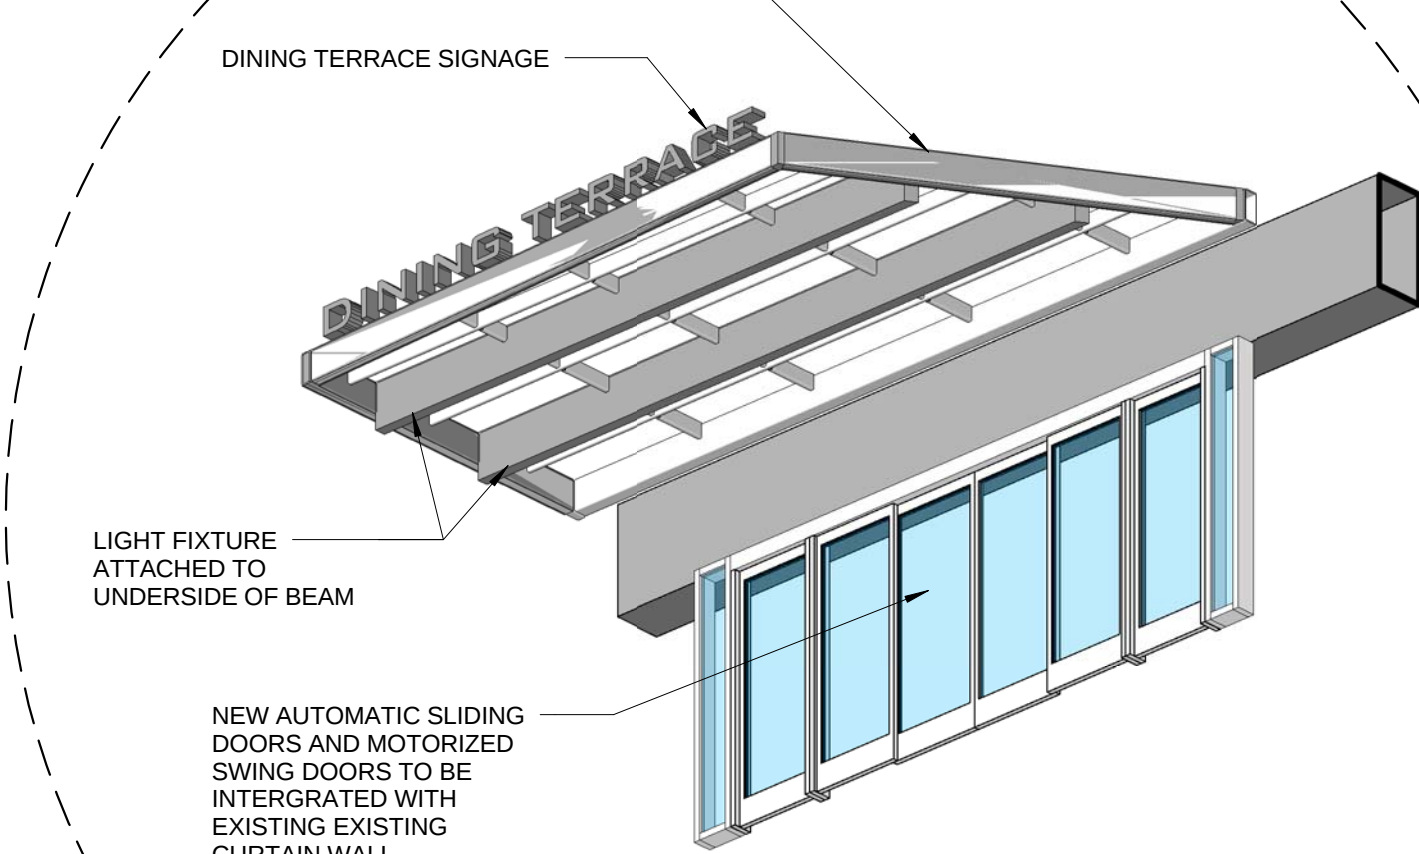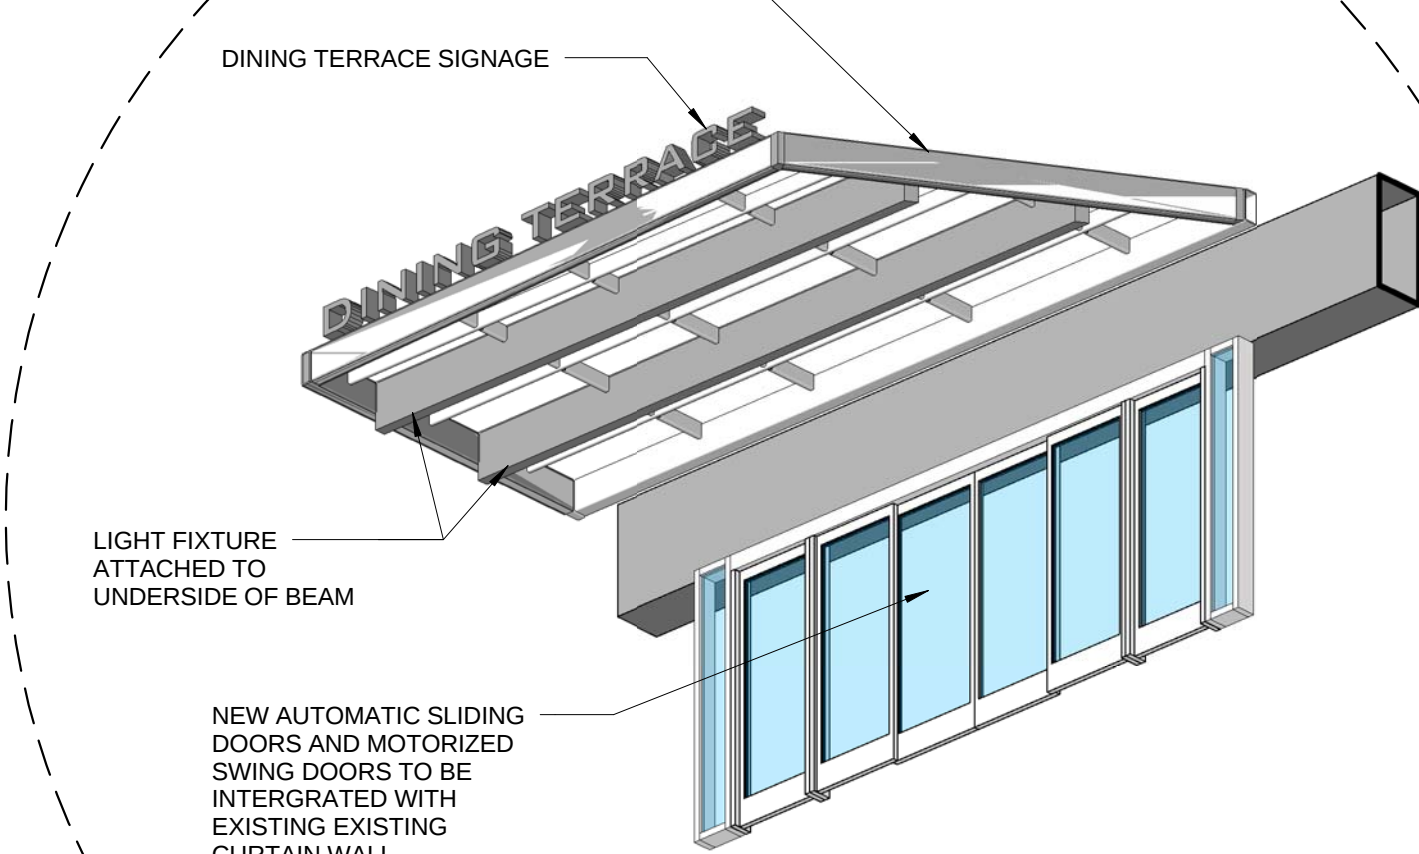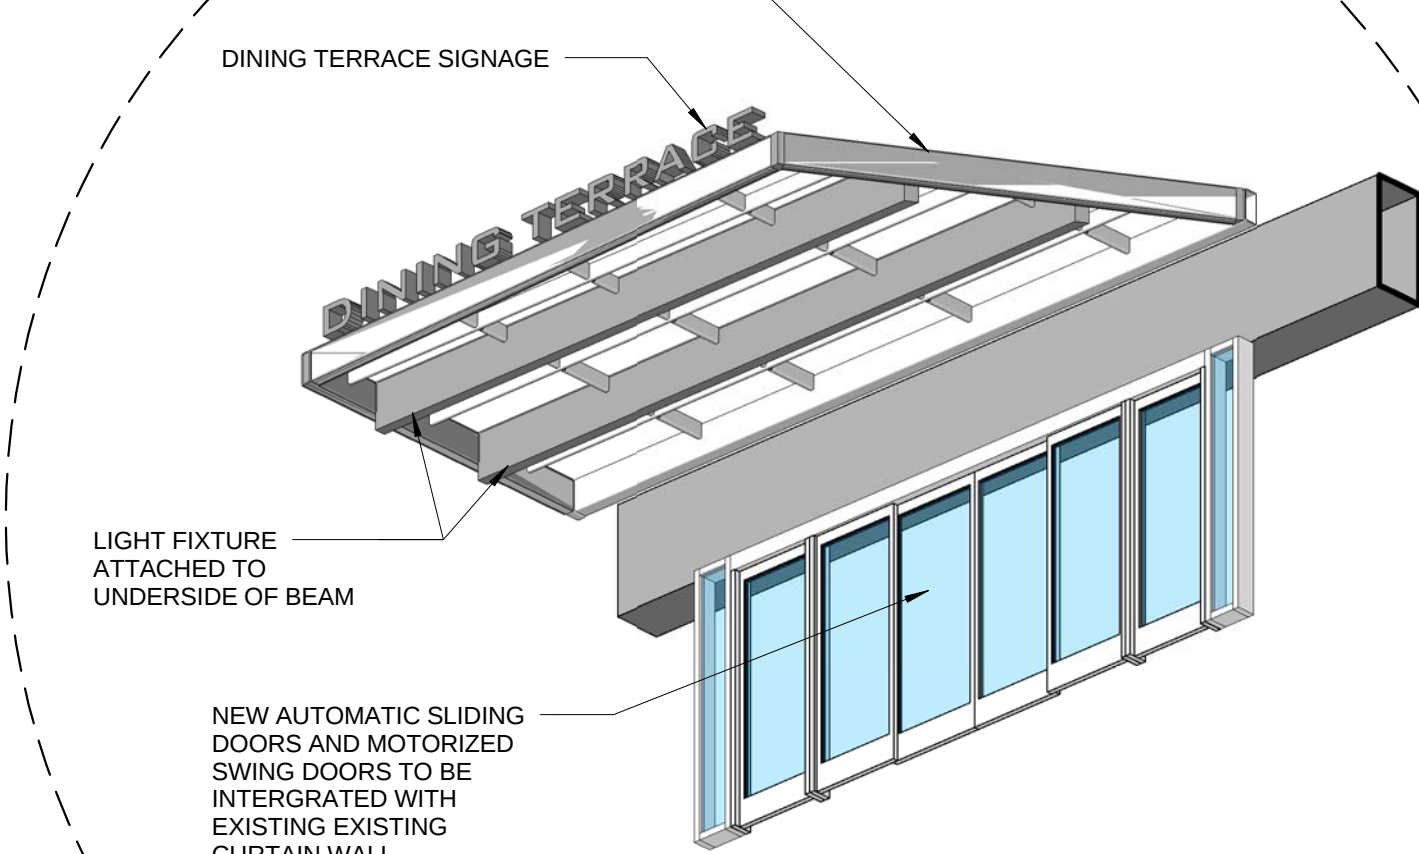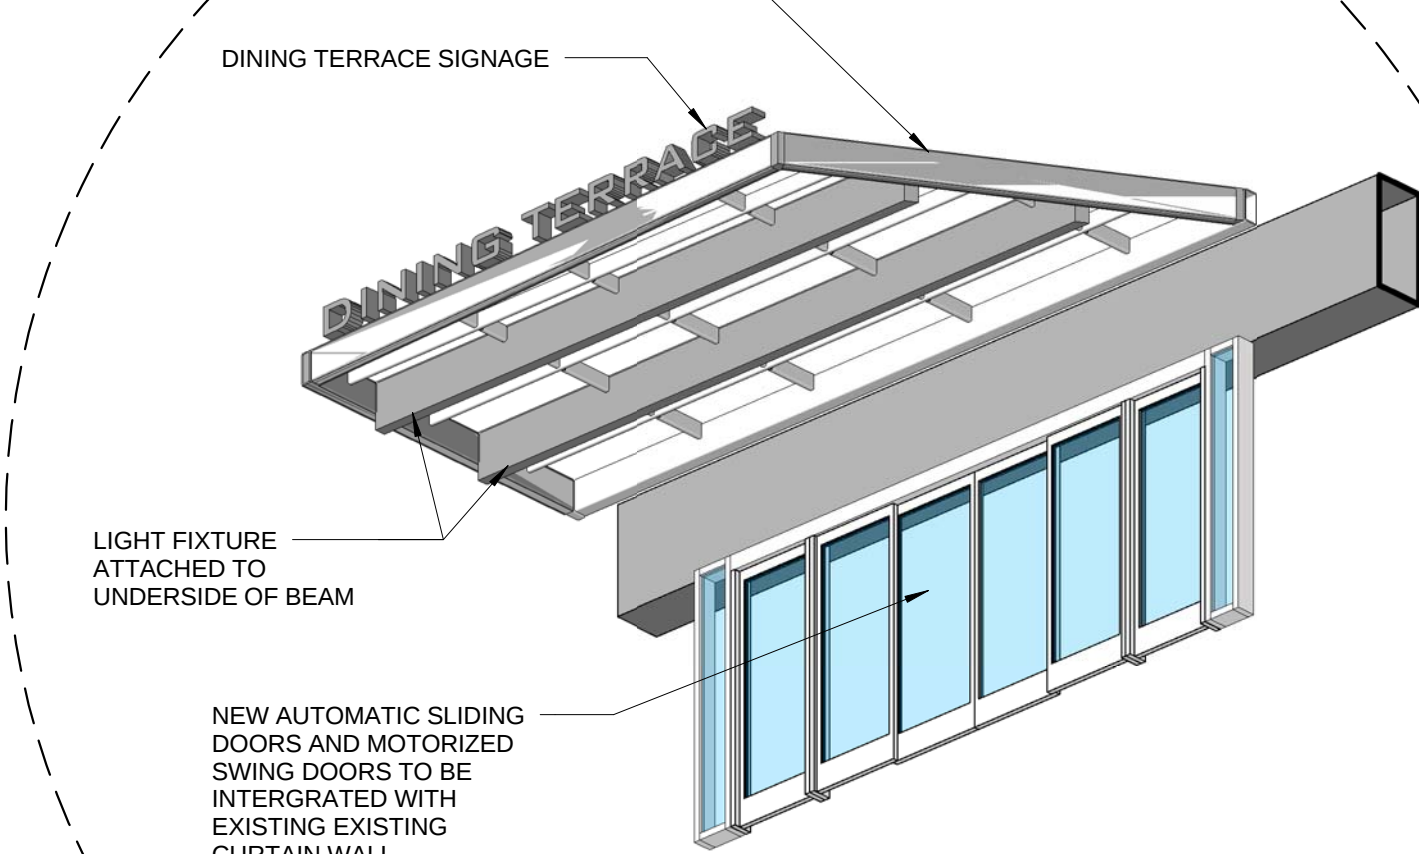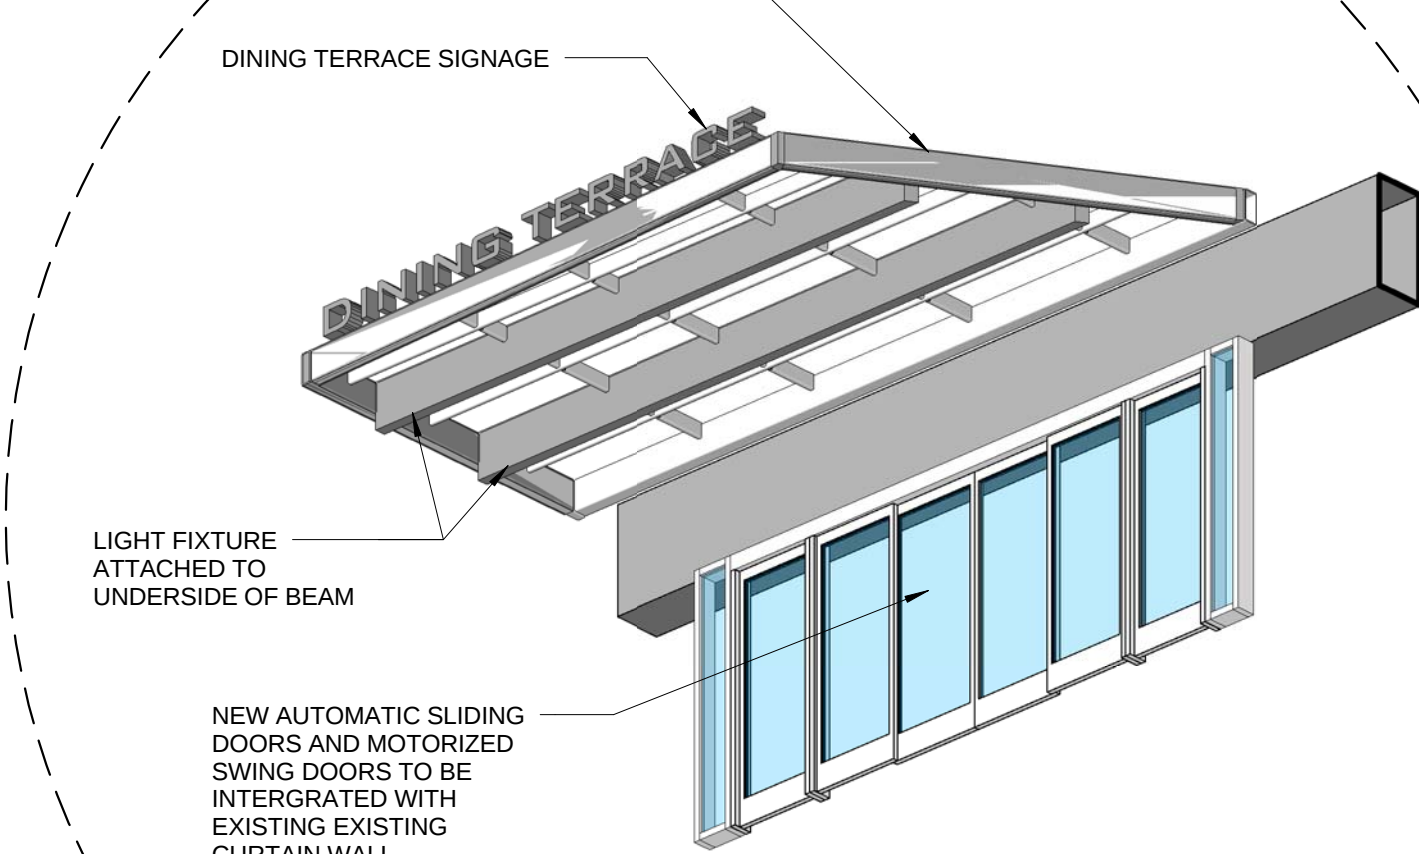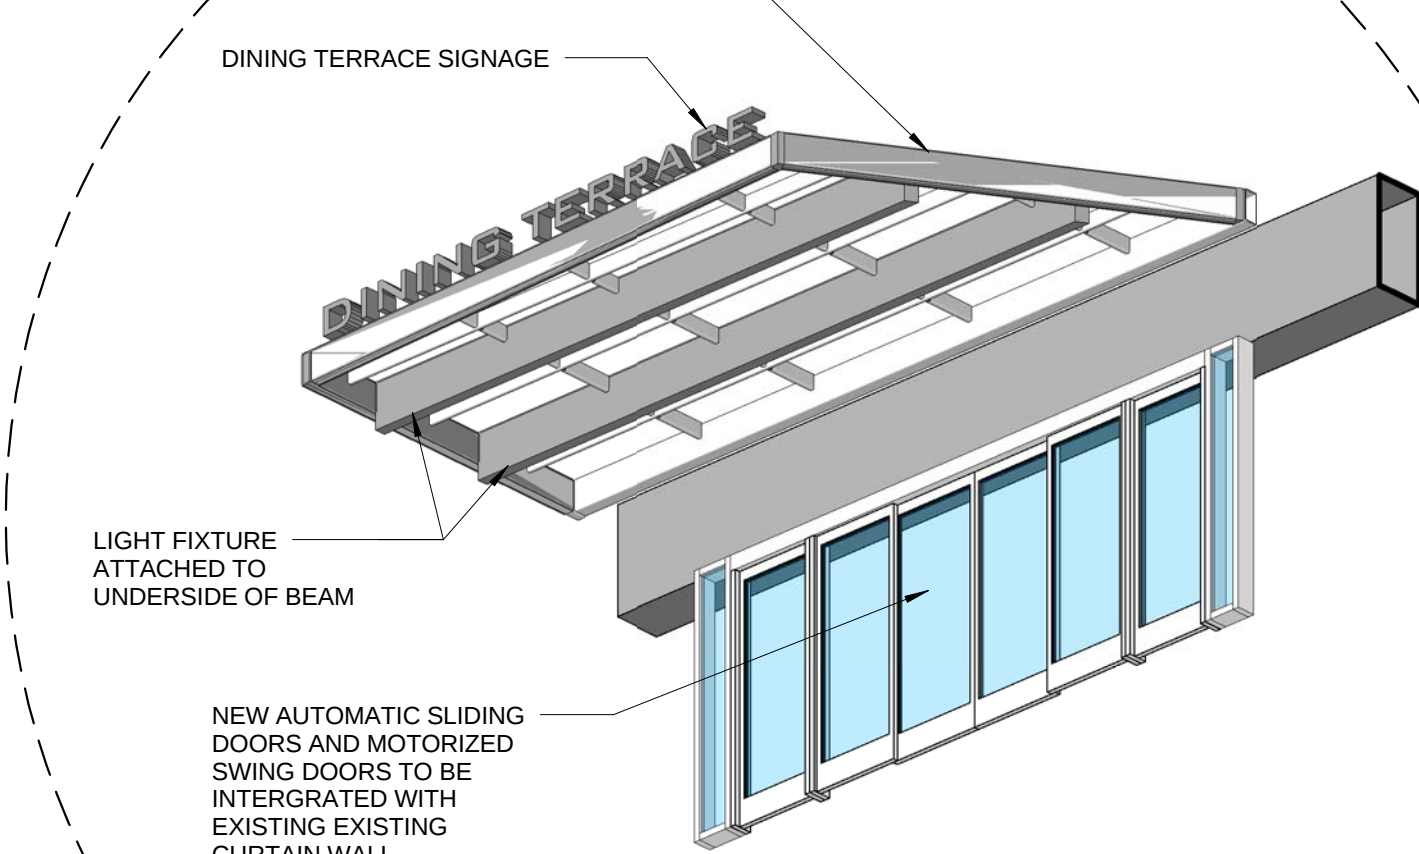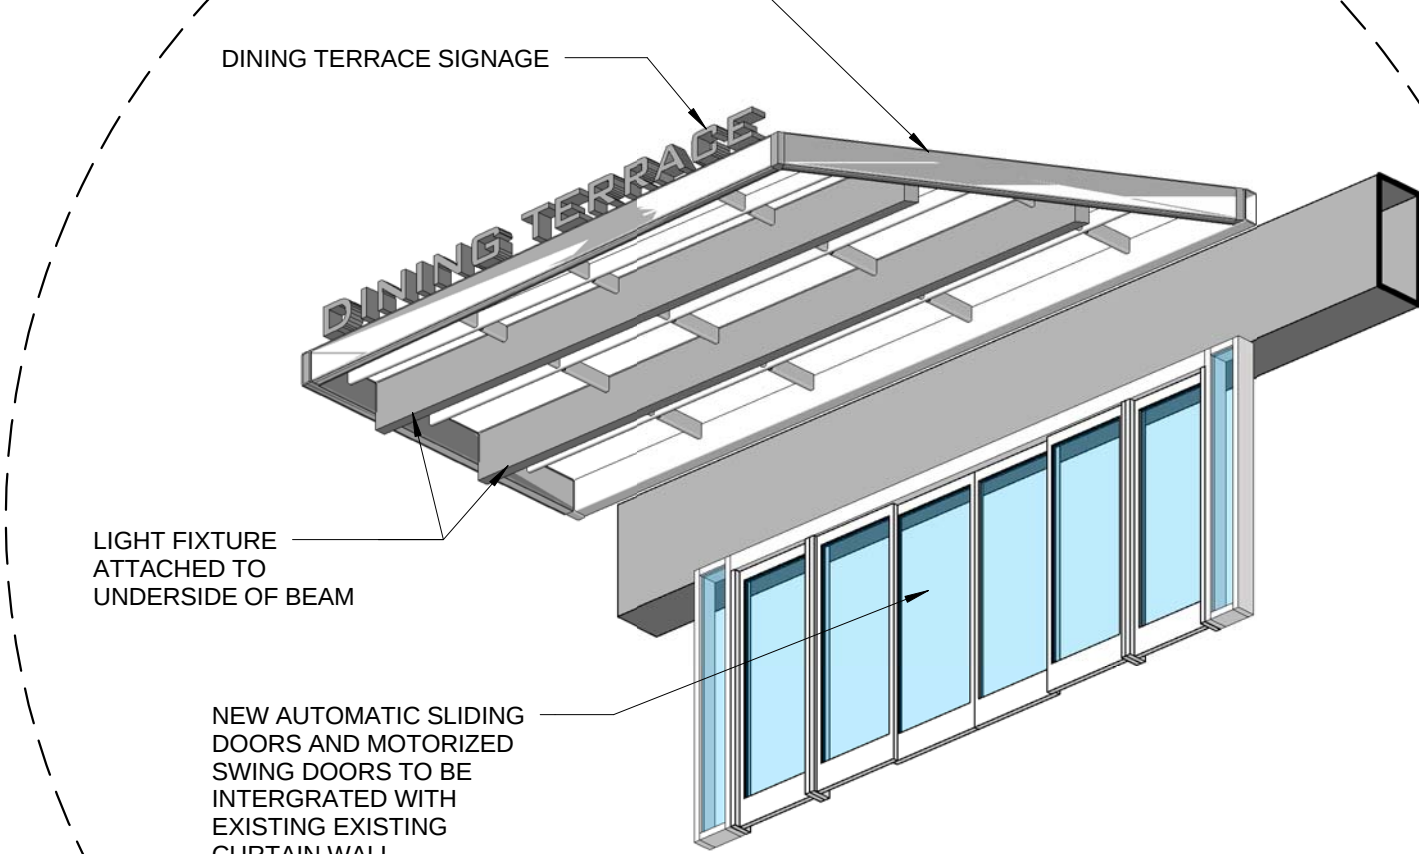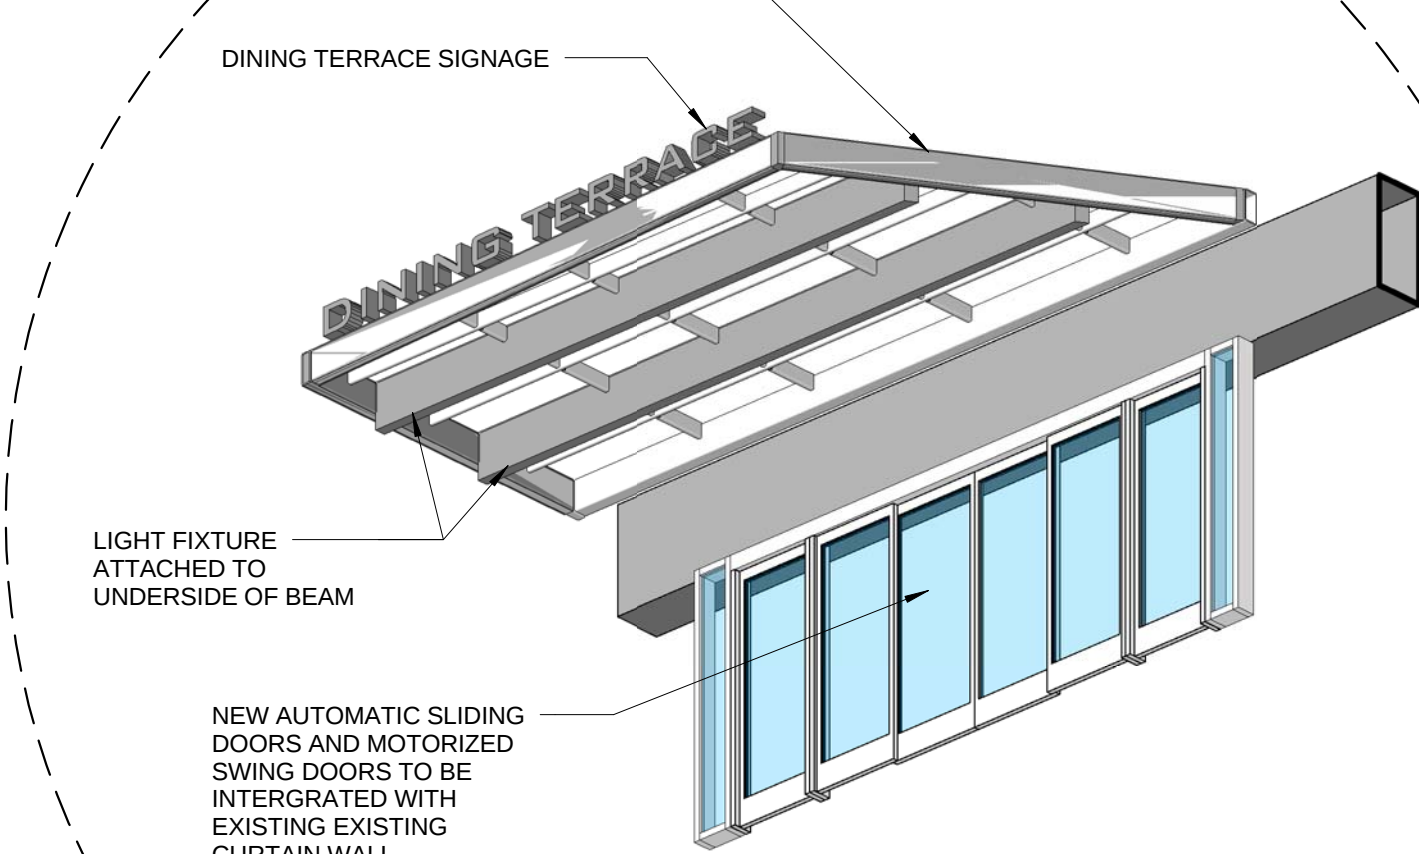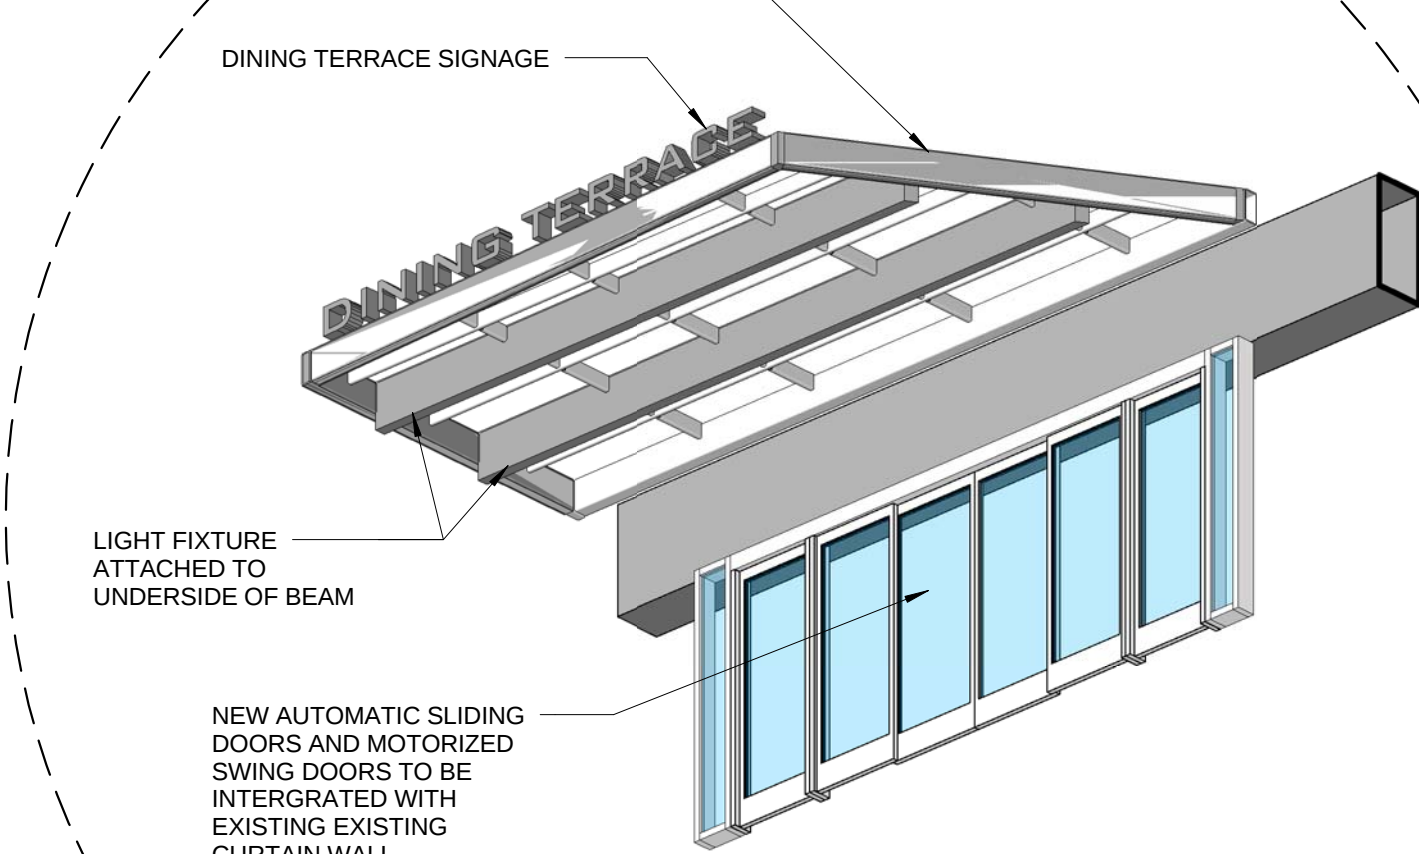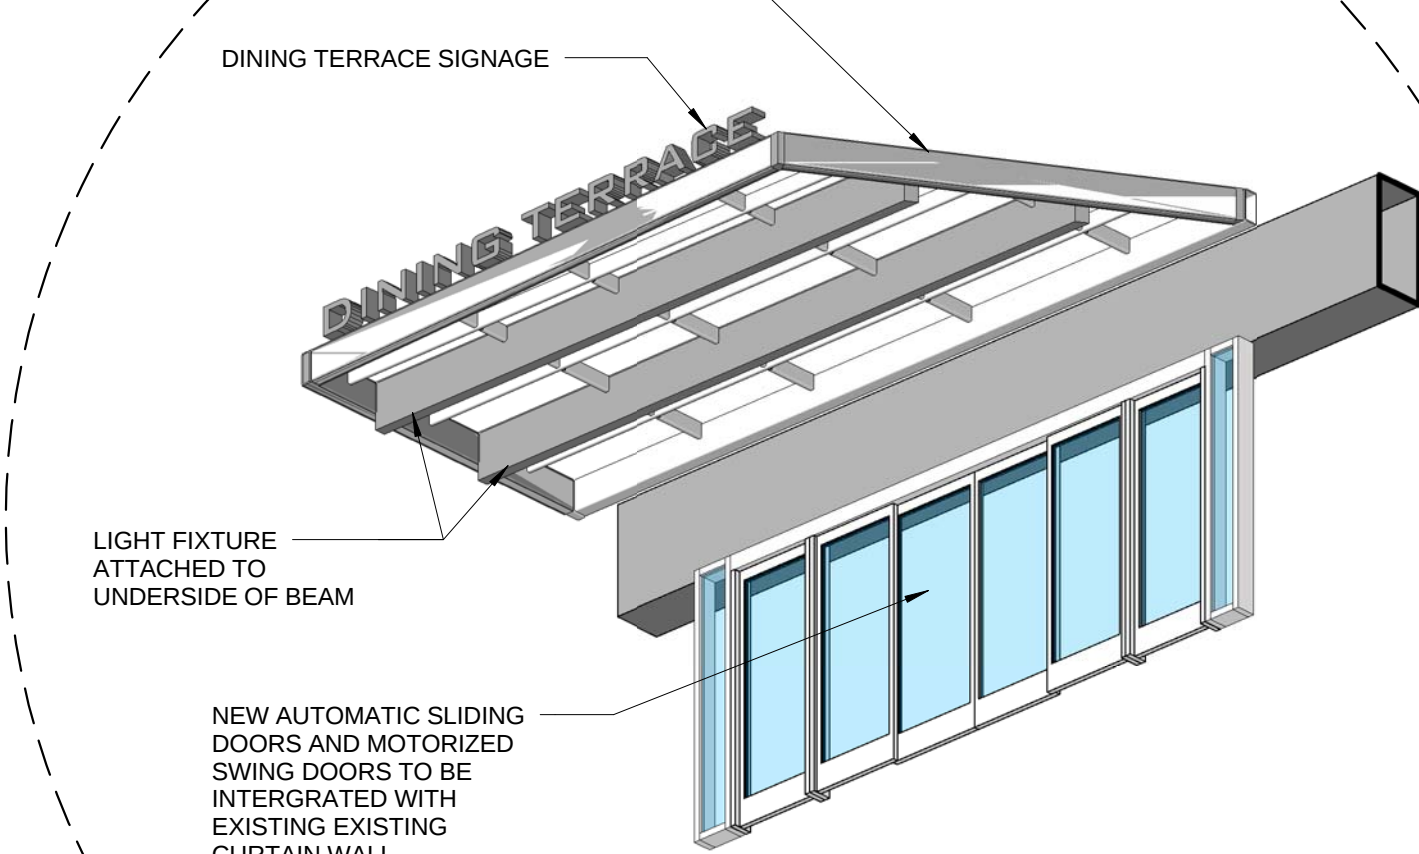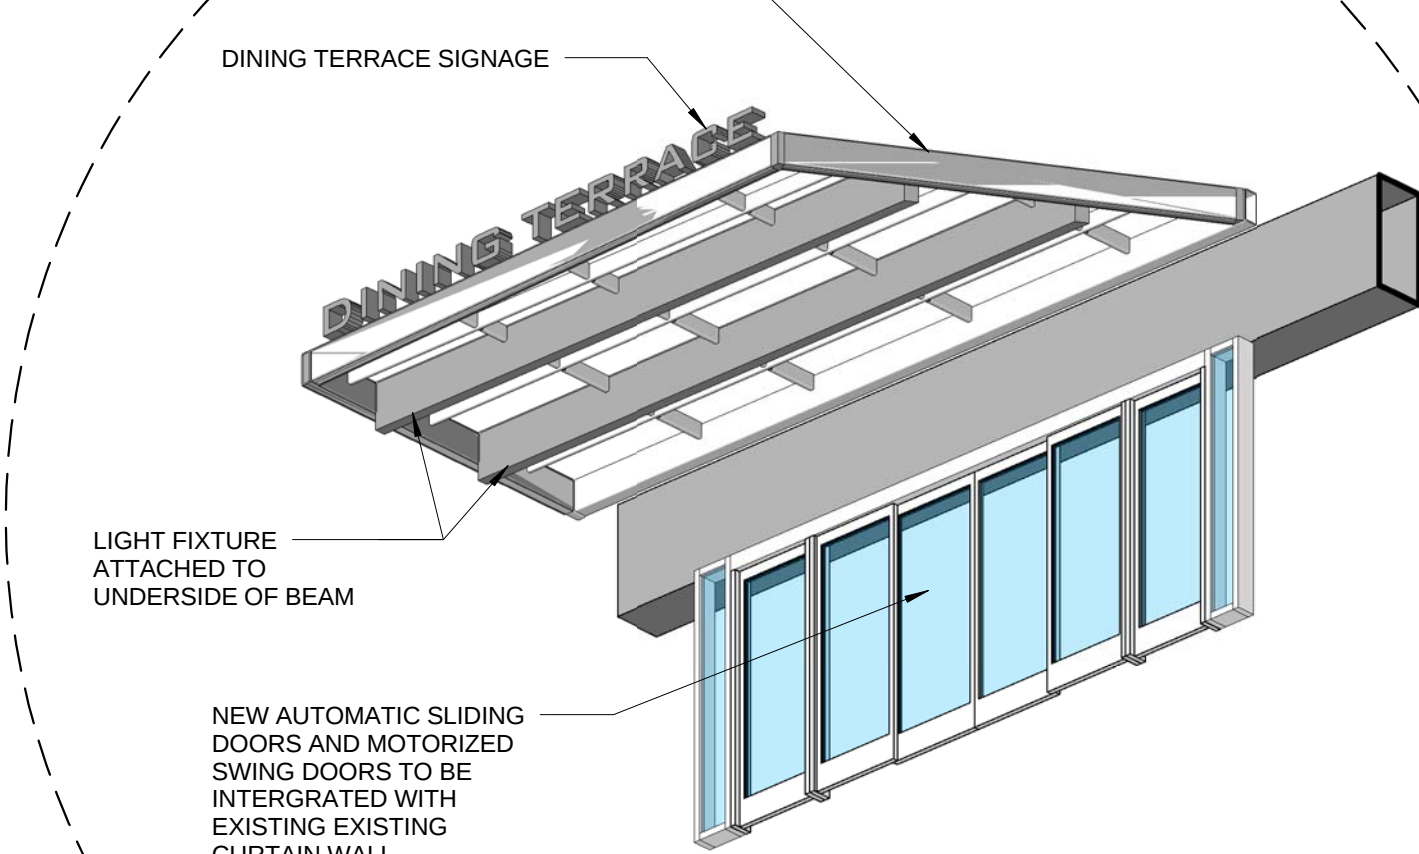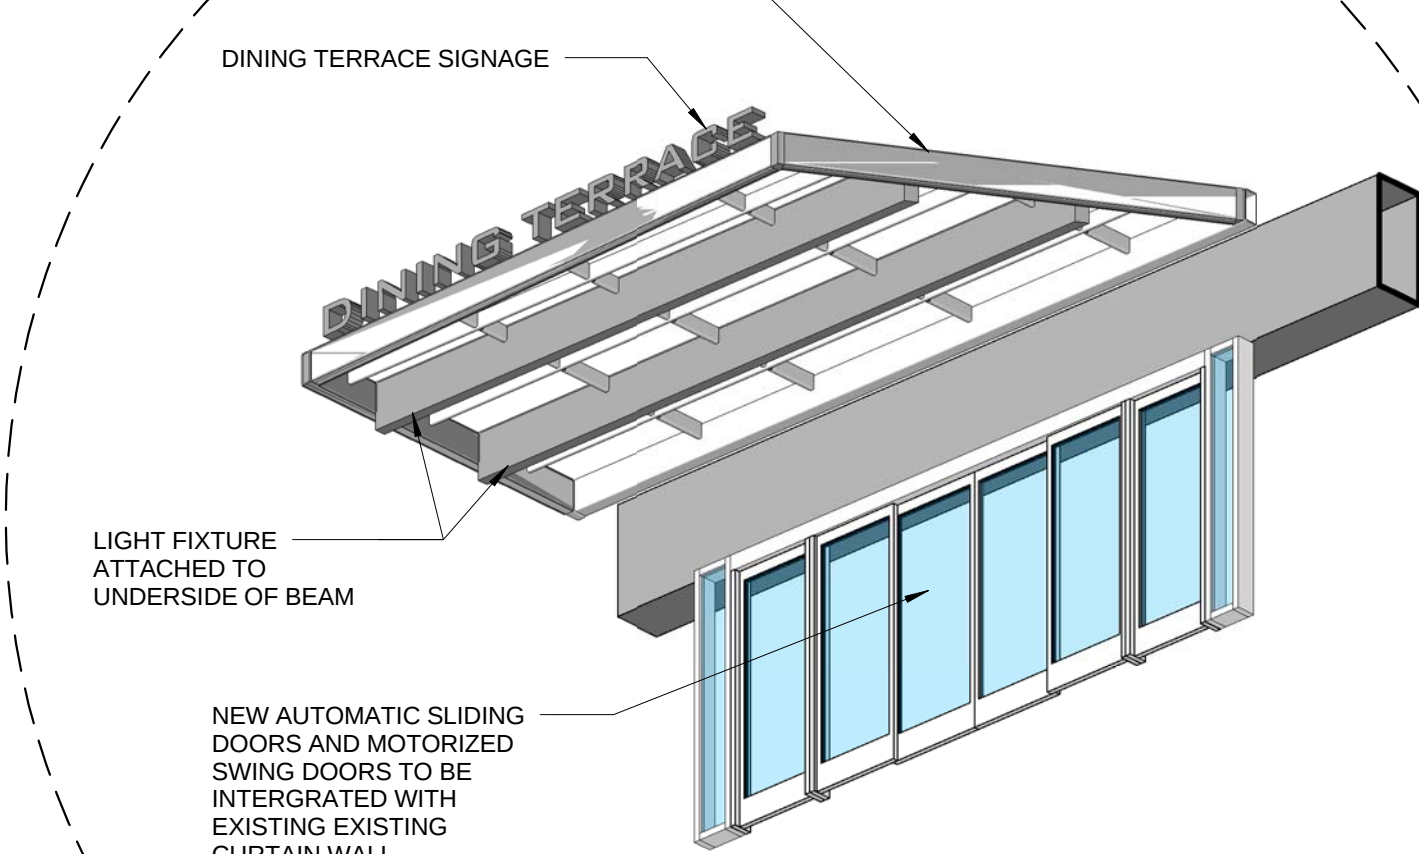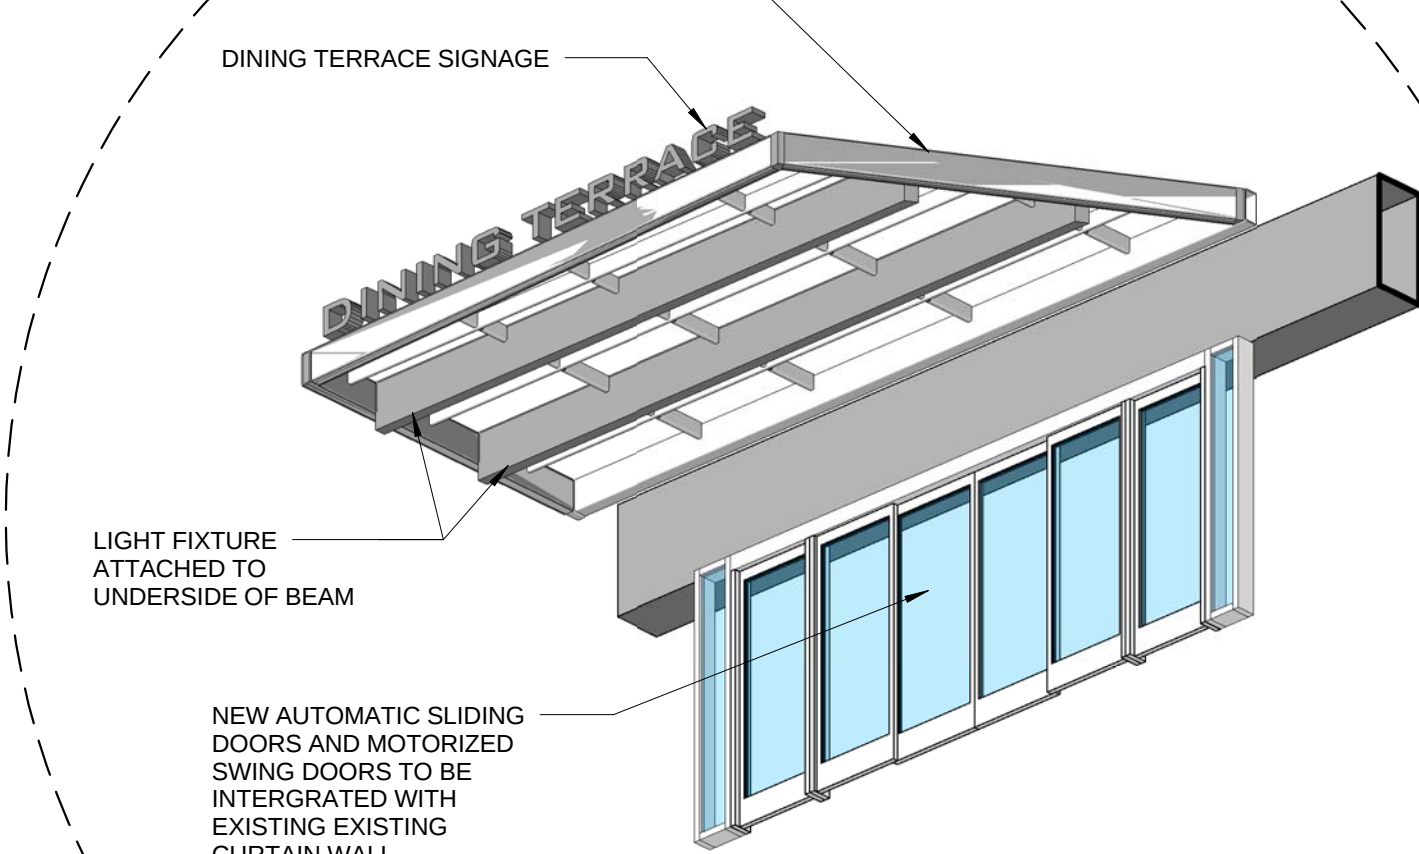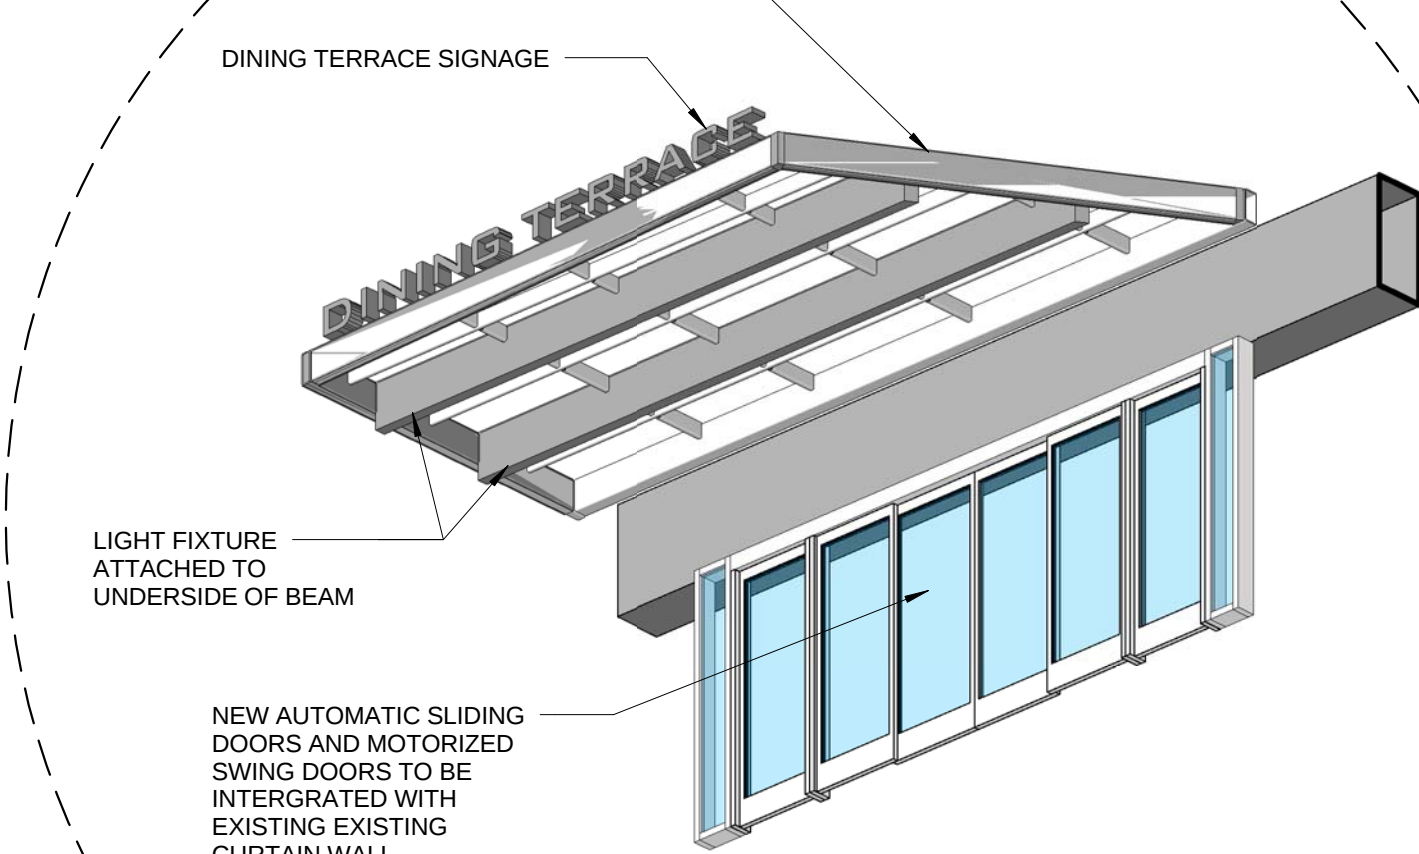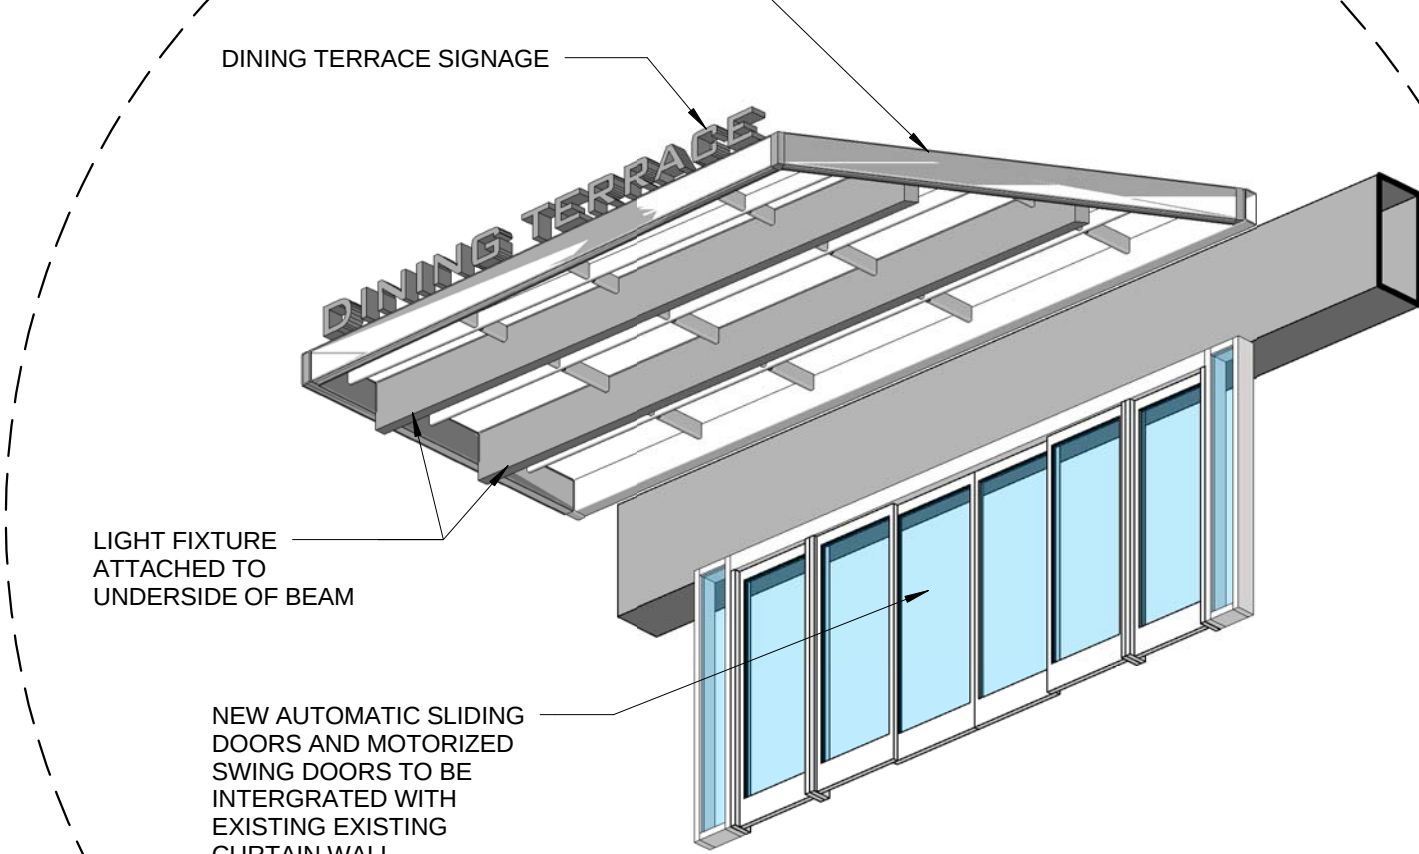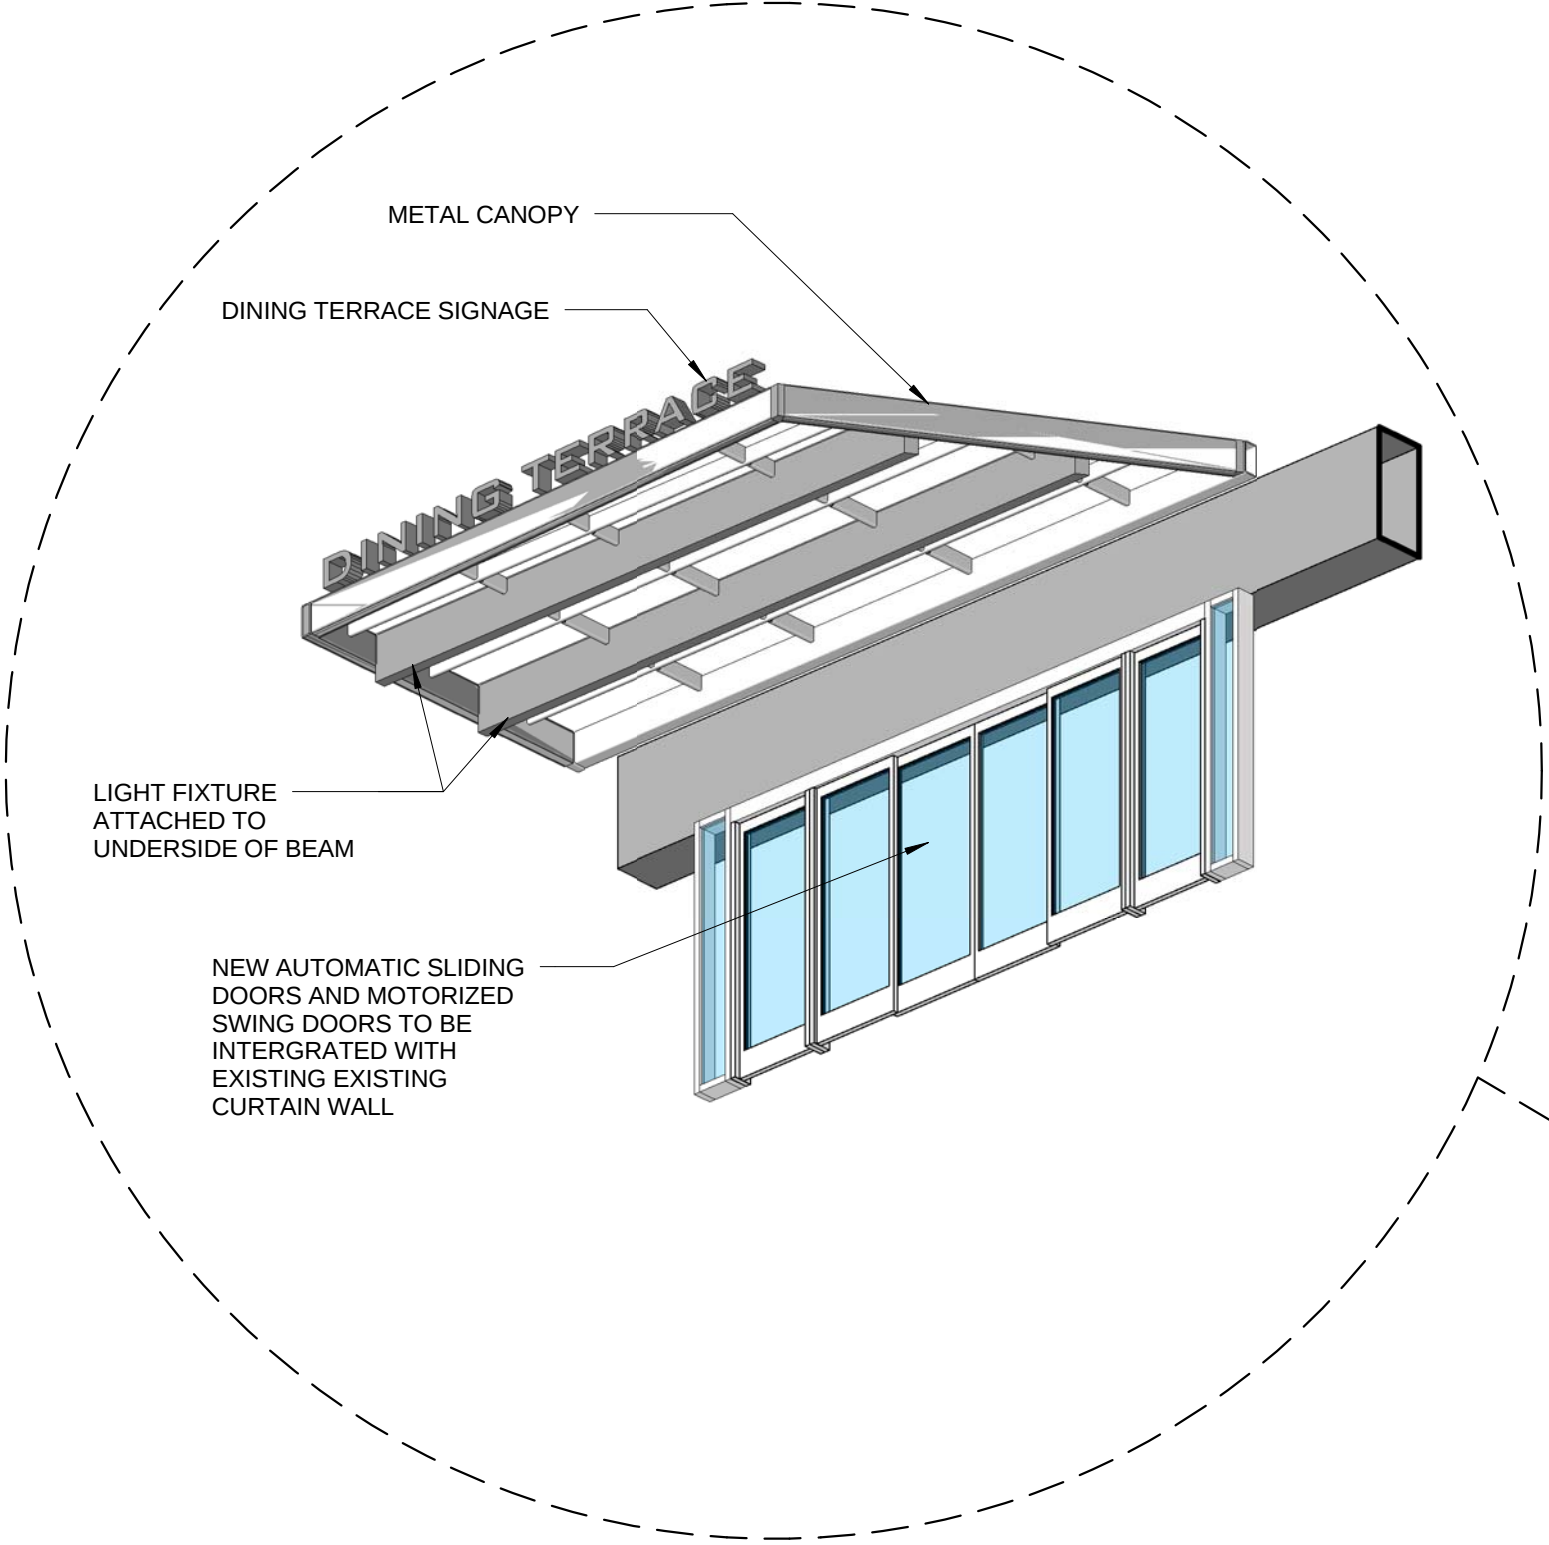

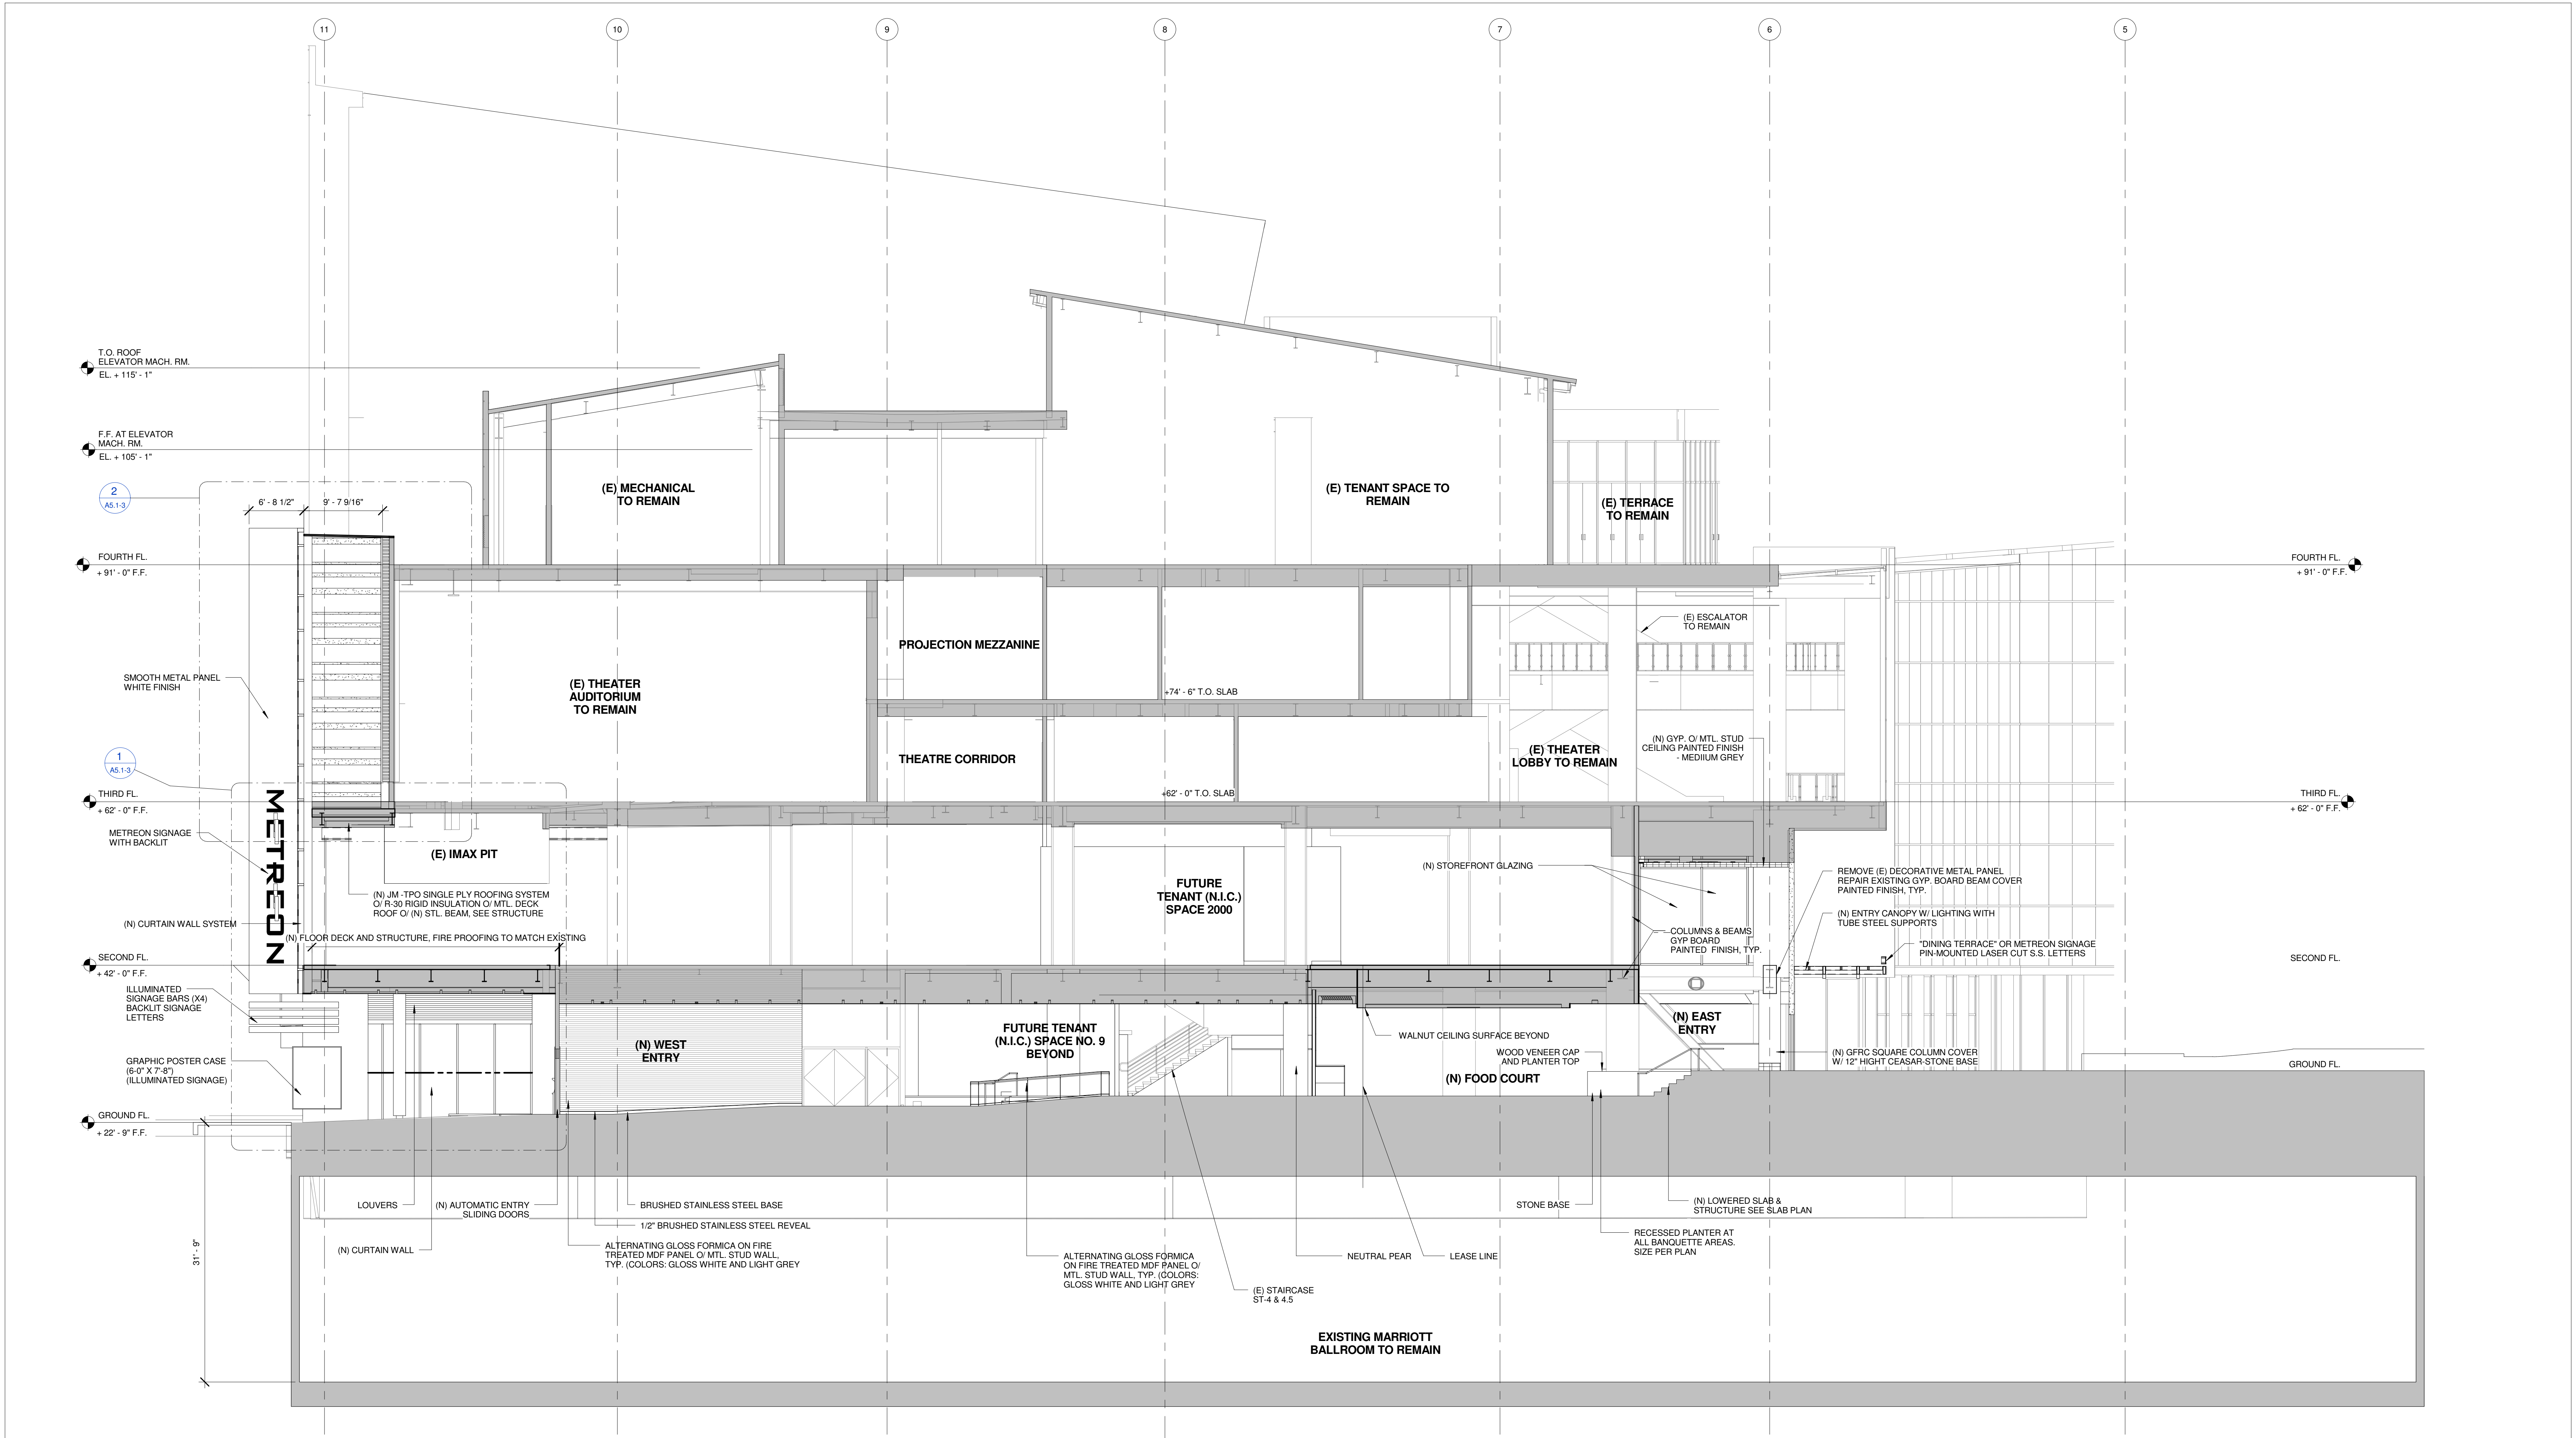

1. DRAFT STOPS TO EXTEND DOWNWARDS AT LEAST 12" BELOW THE CEILING. FIRE SPRINKLERS SHALL BE INSTALLED IN THE CEILING WITHIN 2' OF THE DRAFT CURTAIN AND NOT MORE THAN 6' ON CENTER AS PER CBC 707.2

EAST-WEST SECTION (LOOKING NORTH)


SCALE
1/8" = 1'-0"

1

Consultants:

Registration No.

Key Plan


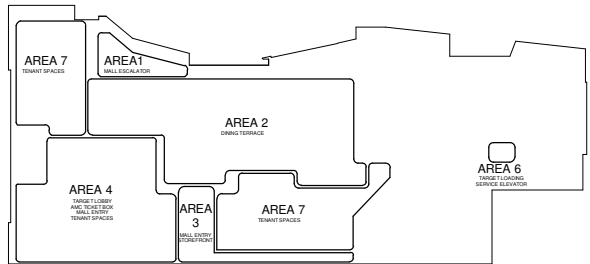


Sheet Title

BUILDING SECTION


Job No. Date Scale
1295 SEPT 01, 2010. 1/8" = 1'-0"

A4.1

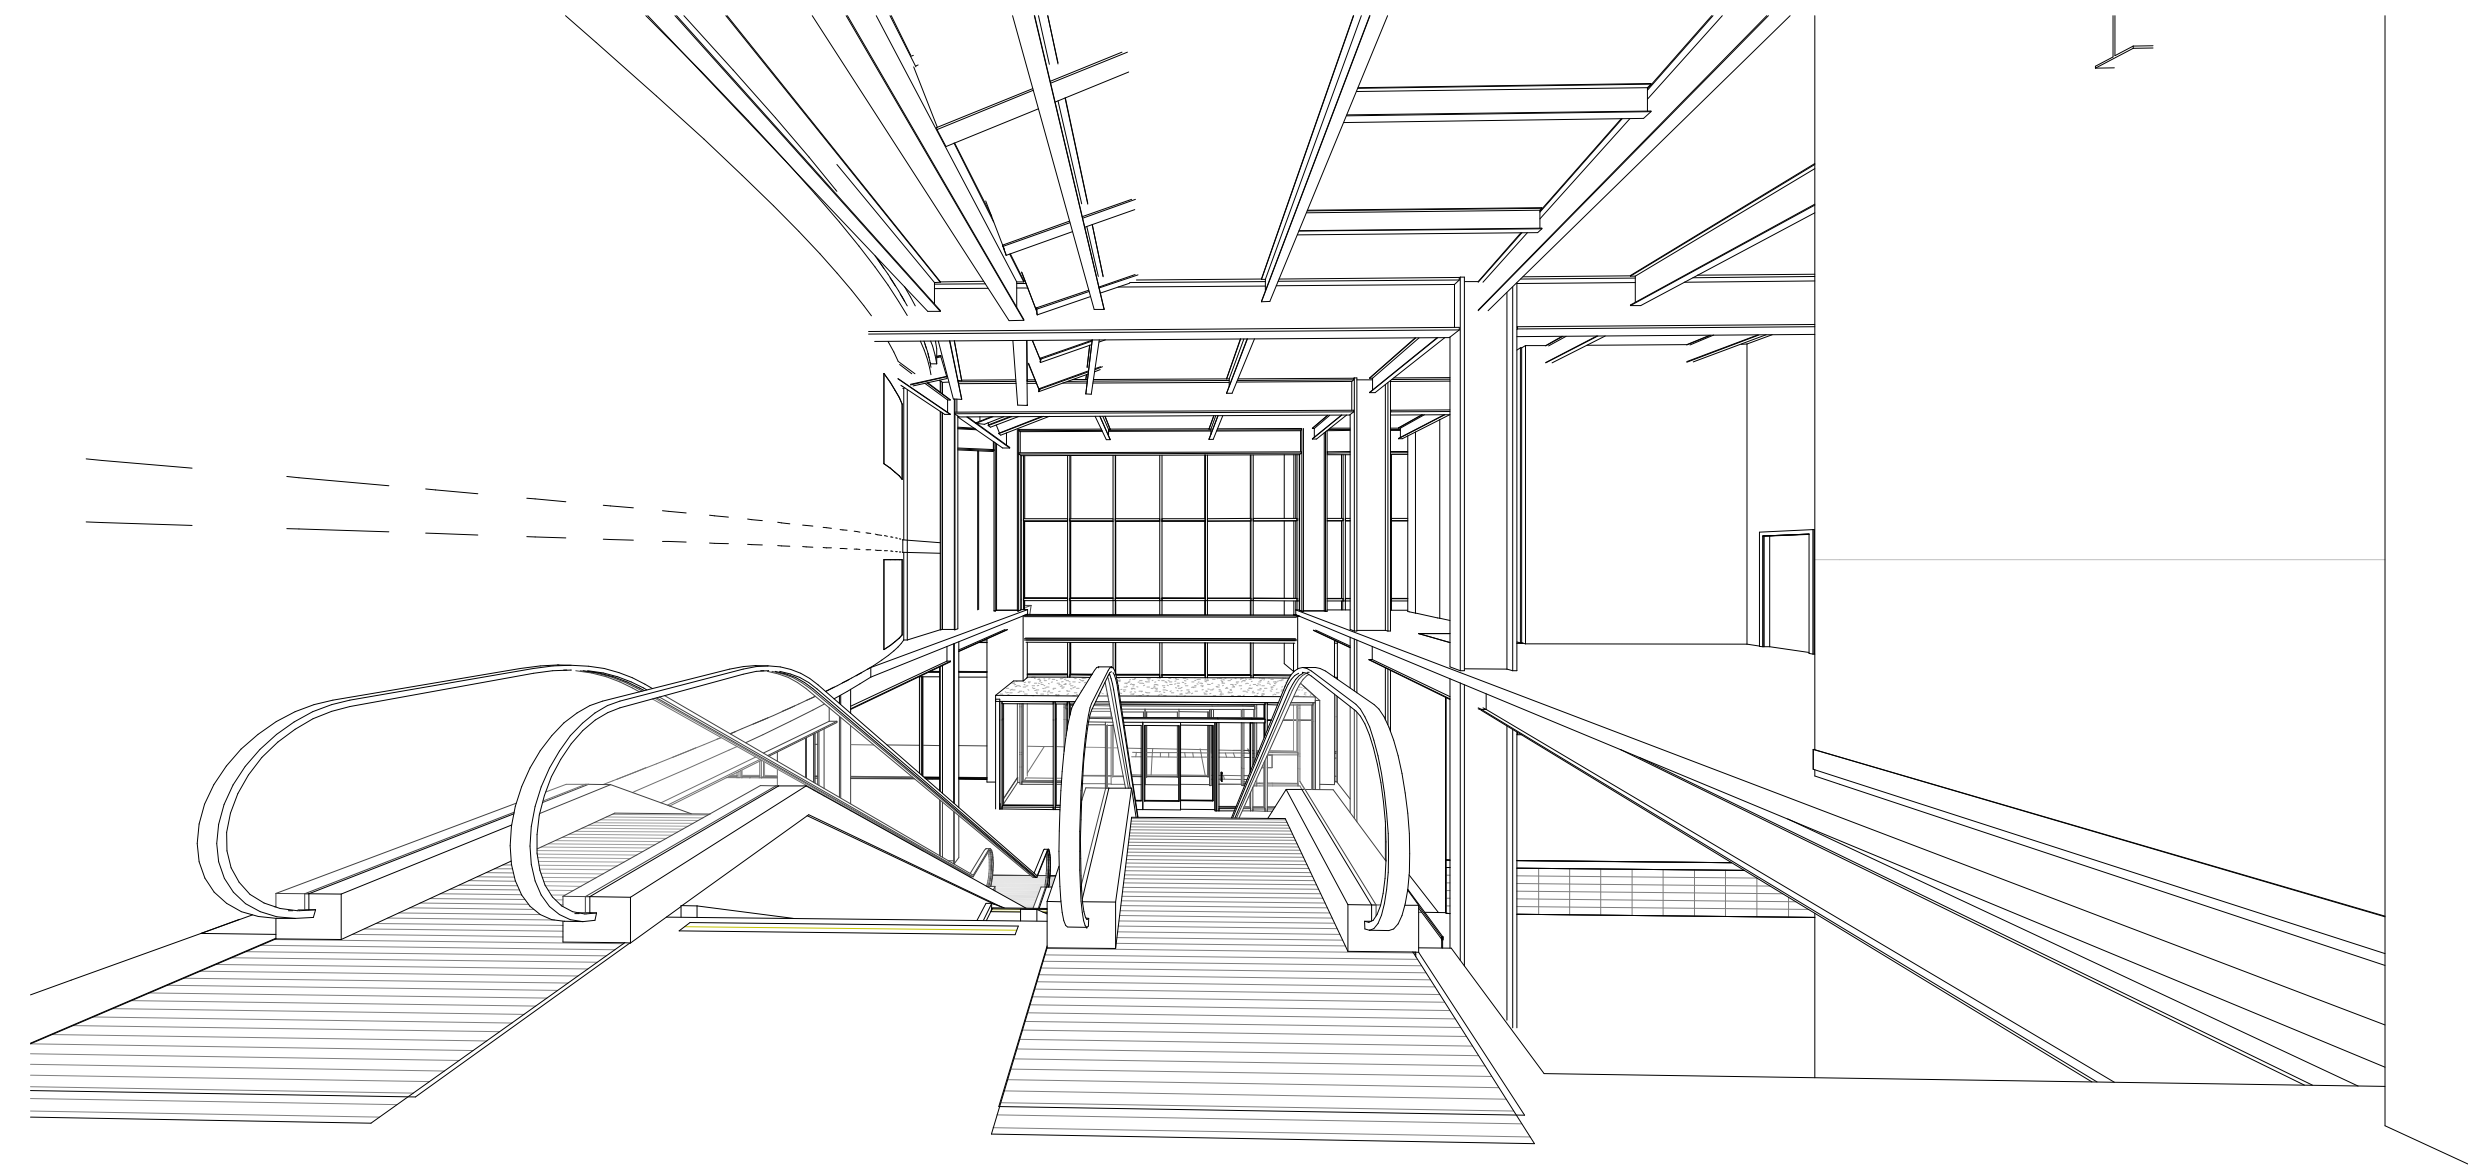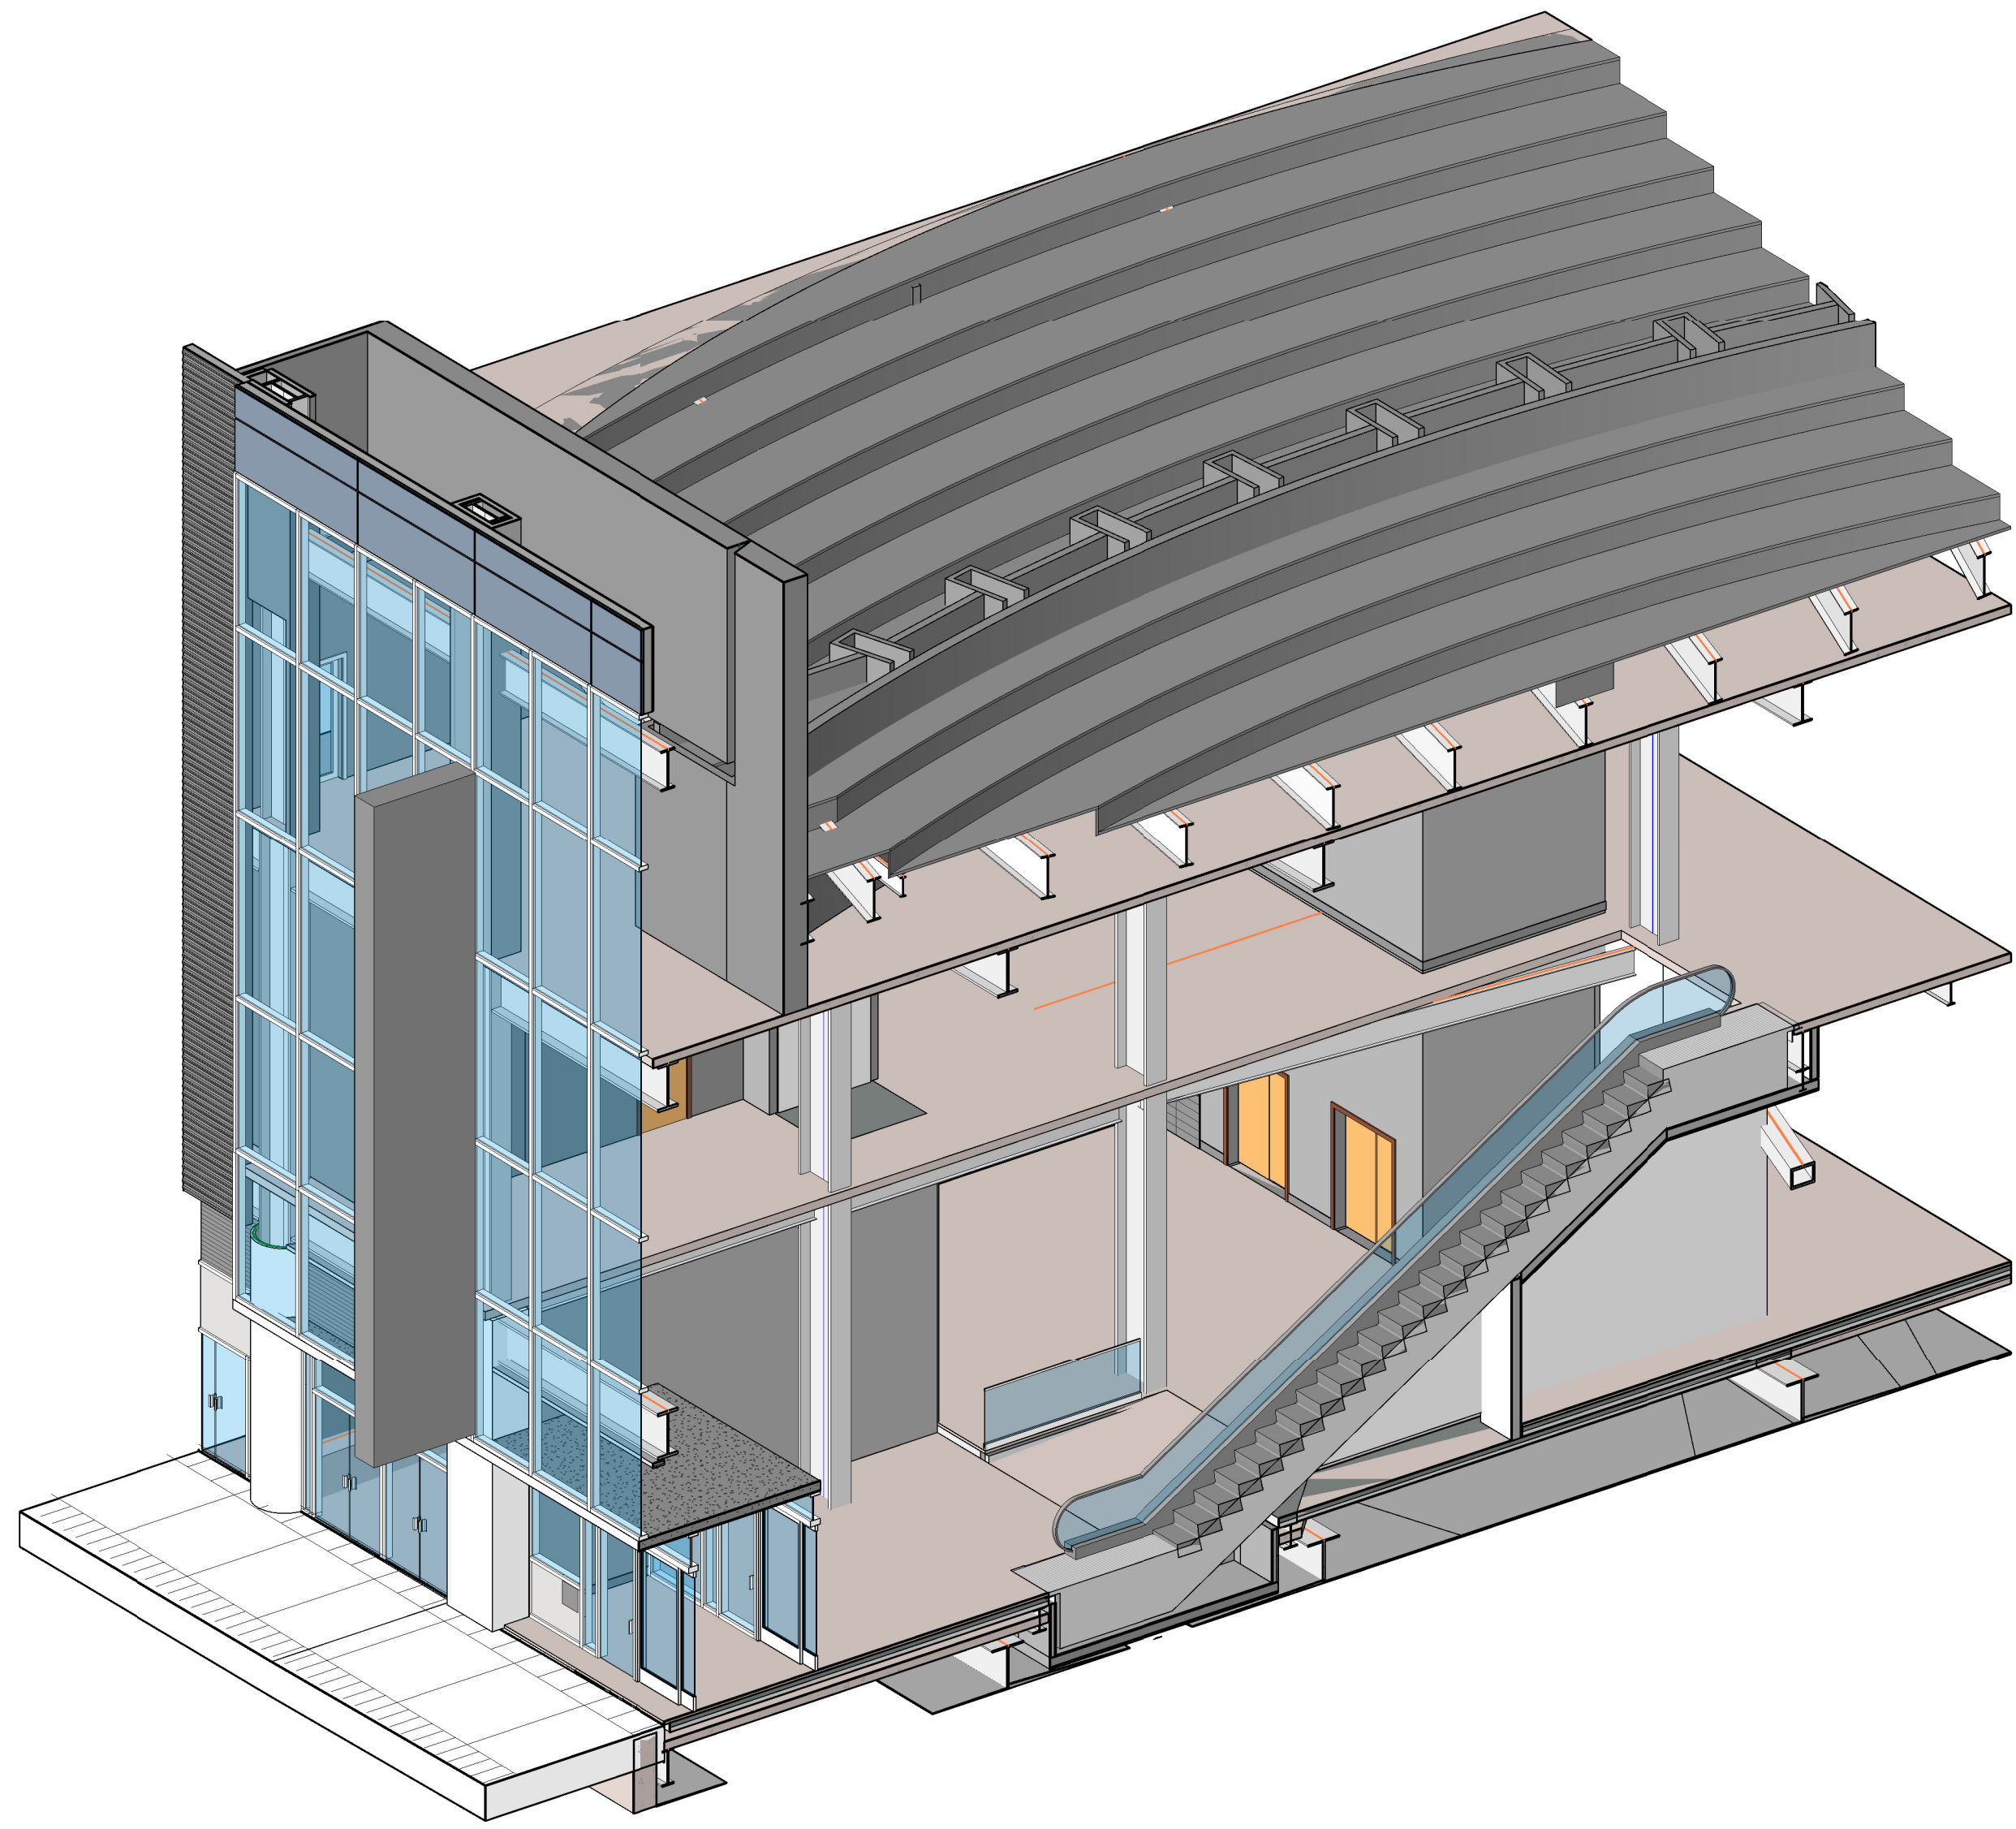

VIEW FROM SECOND FLOOR LOBBY DOWN TO LEVEL 1

SCALE 2

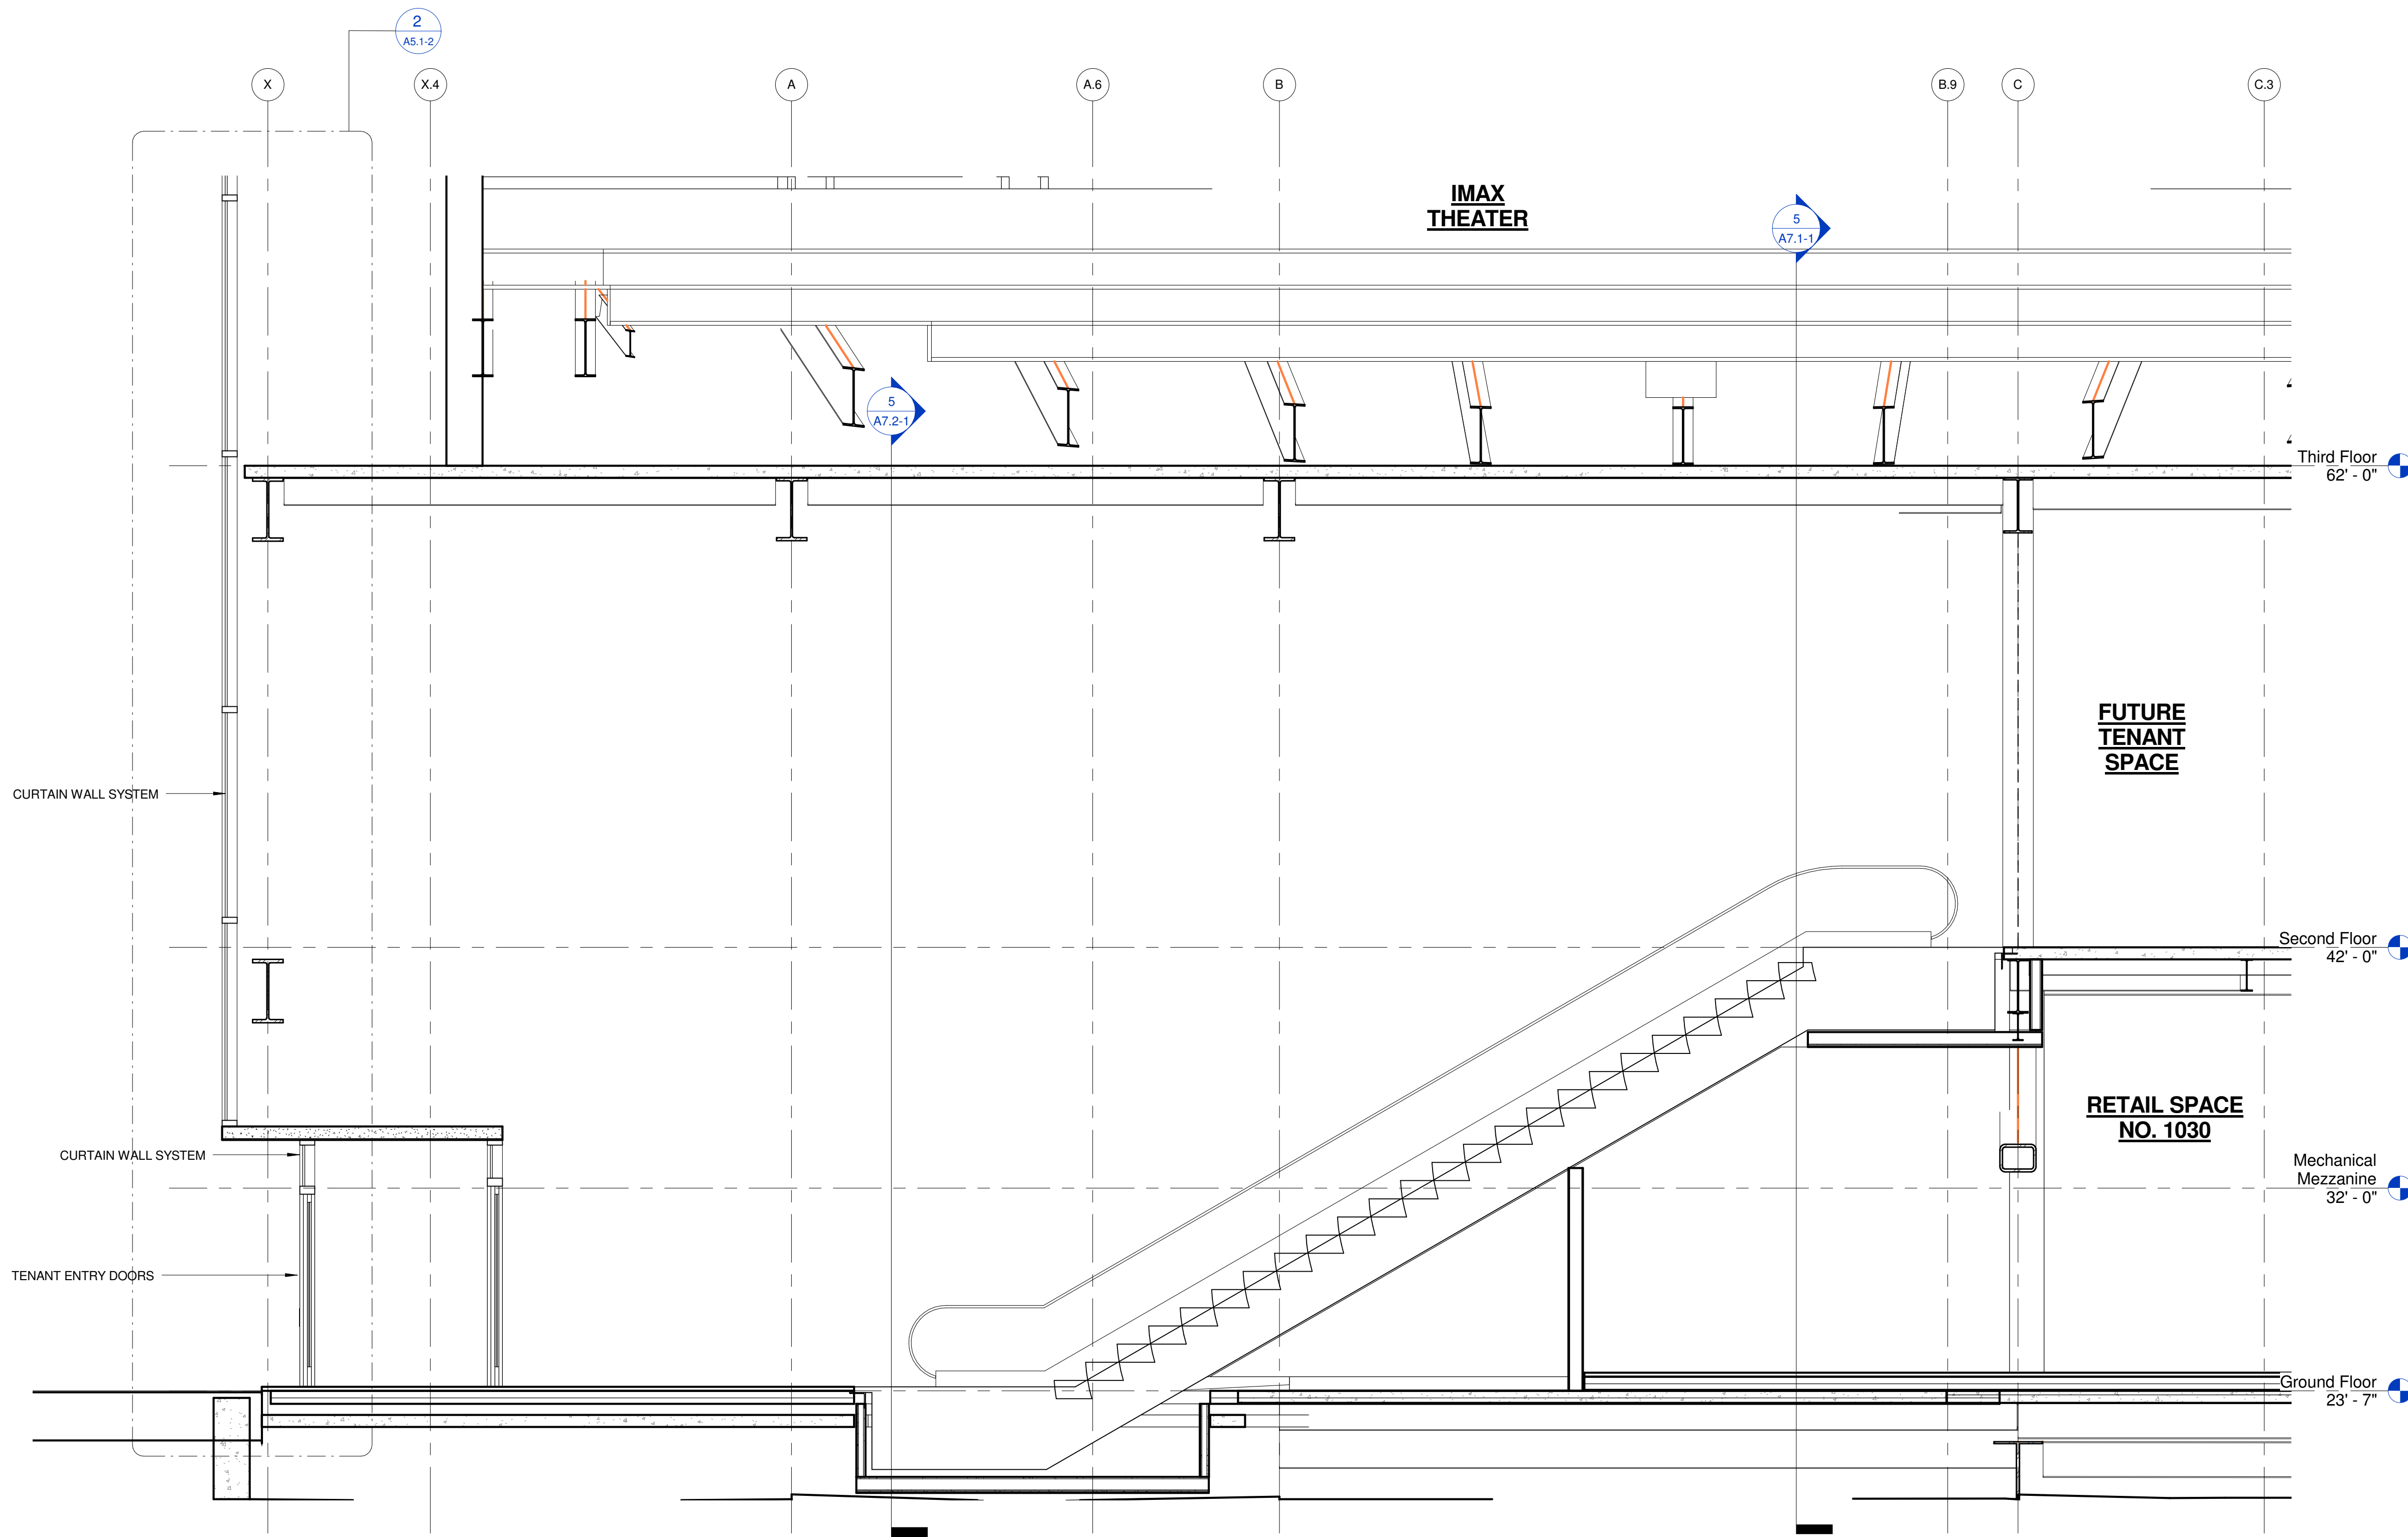



VIEW FROM LEVEL 1 LOBBY UPTO SECOND LEVEL

SCALE 3

ANCHOR TENANT ENTRY SECTION

SCALE 1
1/4" = 1'-0"

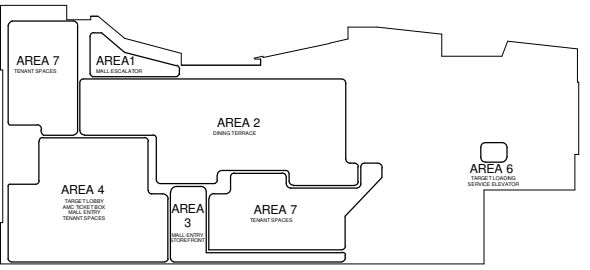
Consultants:	Registration No.	Key Plan 	Sheet Title TENANT ENTRY SECTION
			Job No. 1295 Date SEPT 01, 2010 Scale 1/4" = 1'-0"
			A4.6

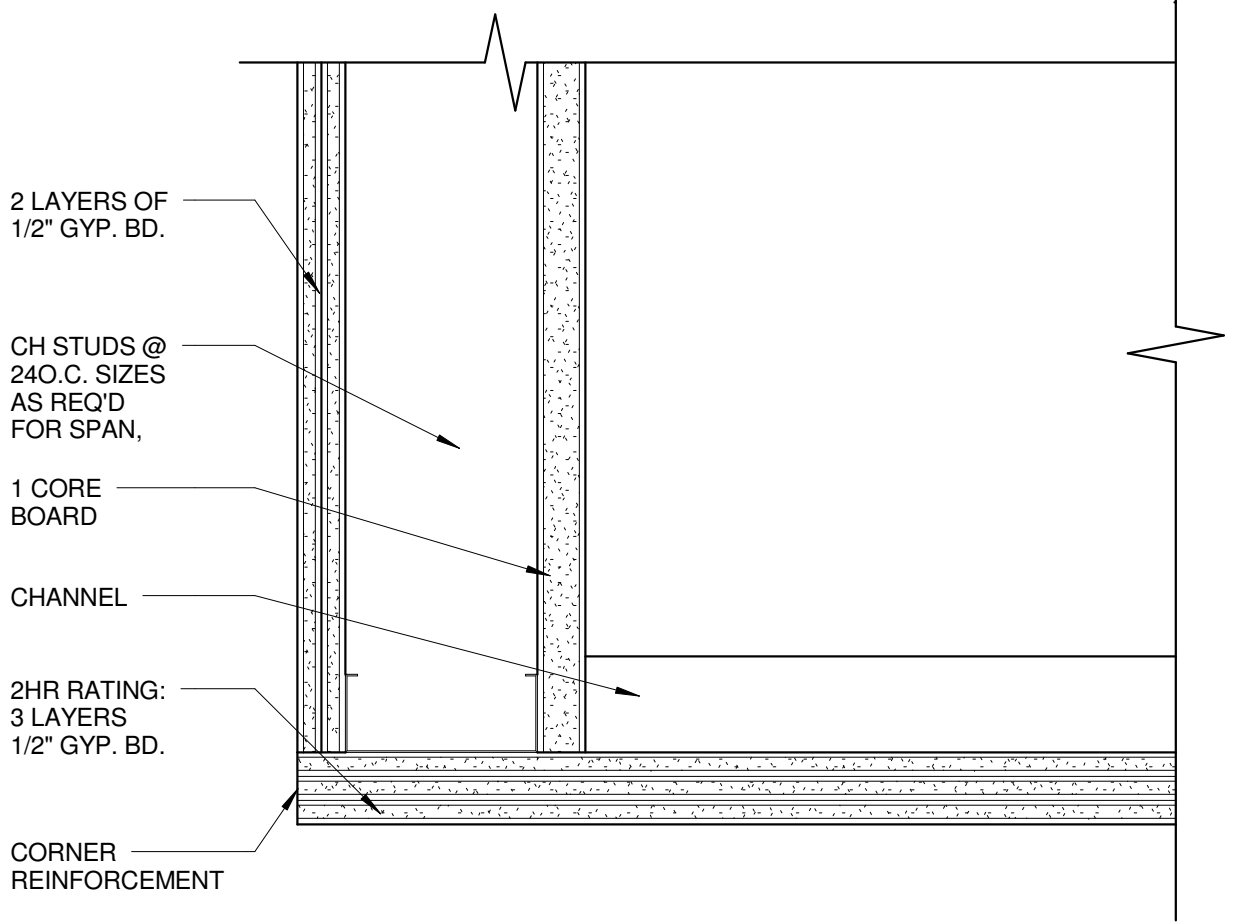

2HR RATED HORIZONTAL ENCLOSURES

SCALE
3" = 1'-0"


2

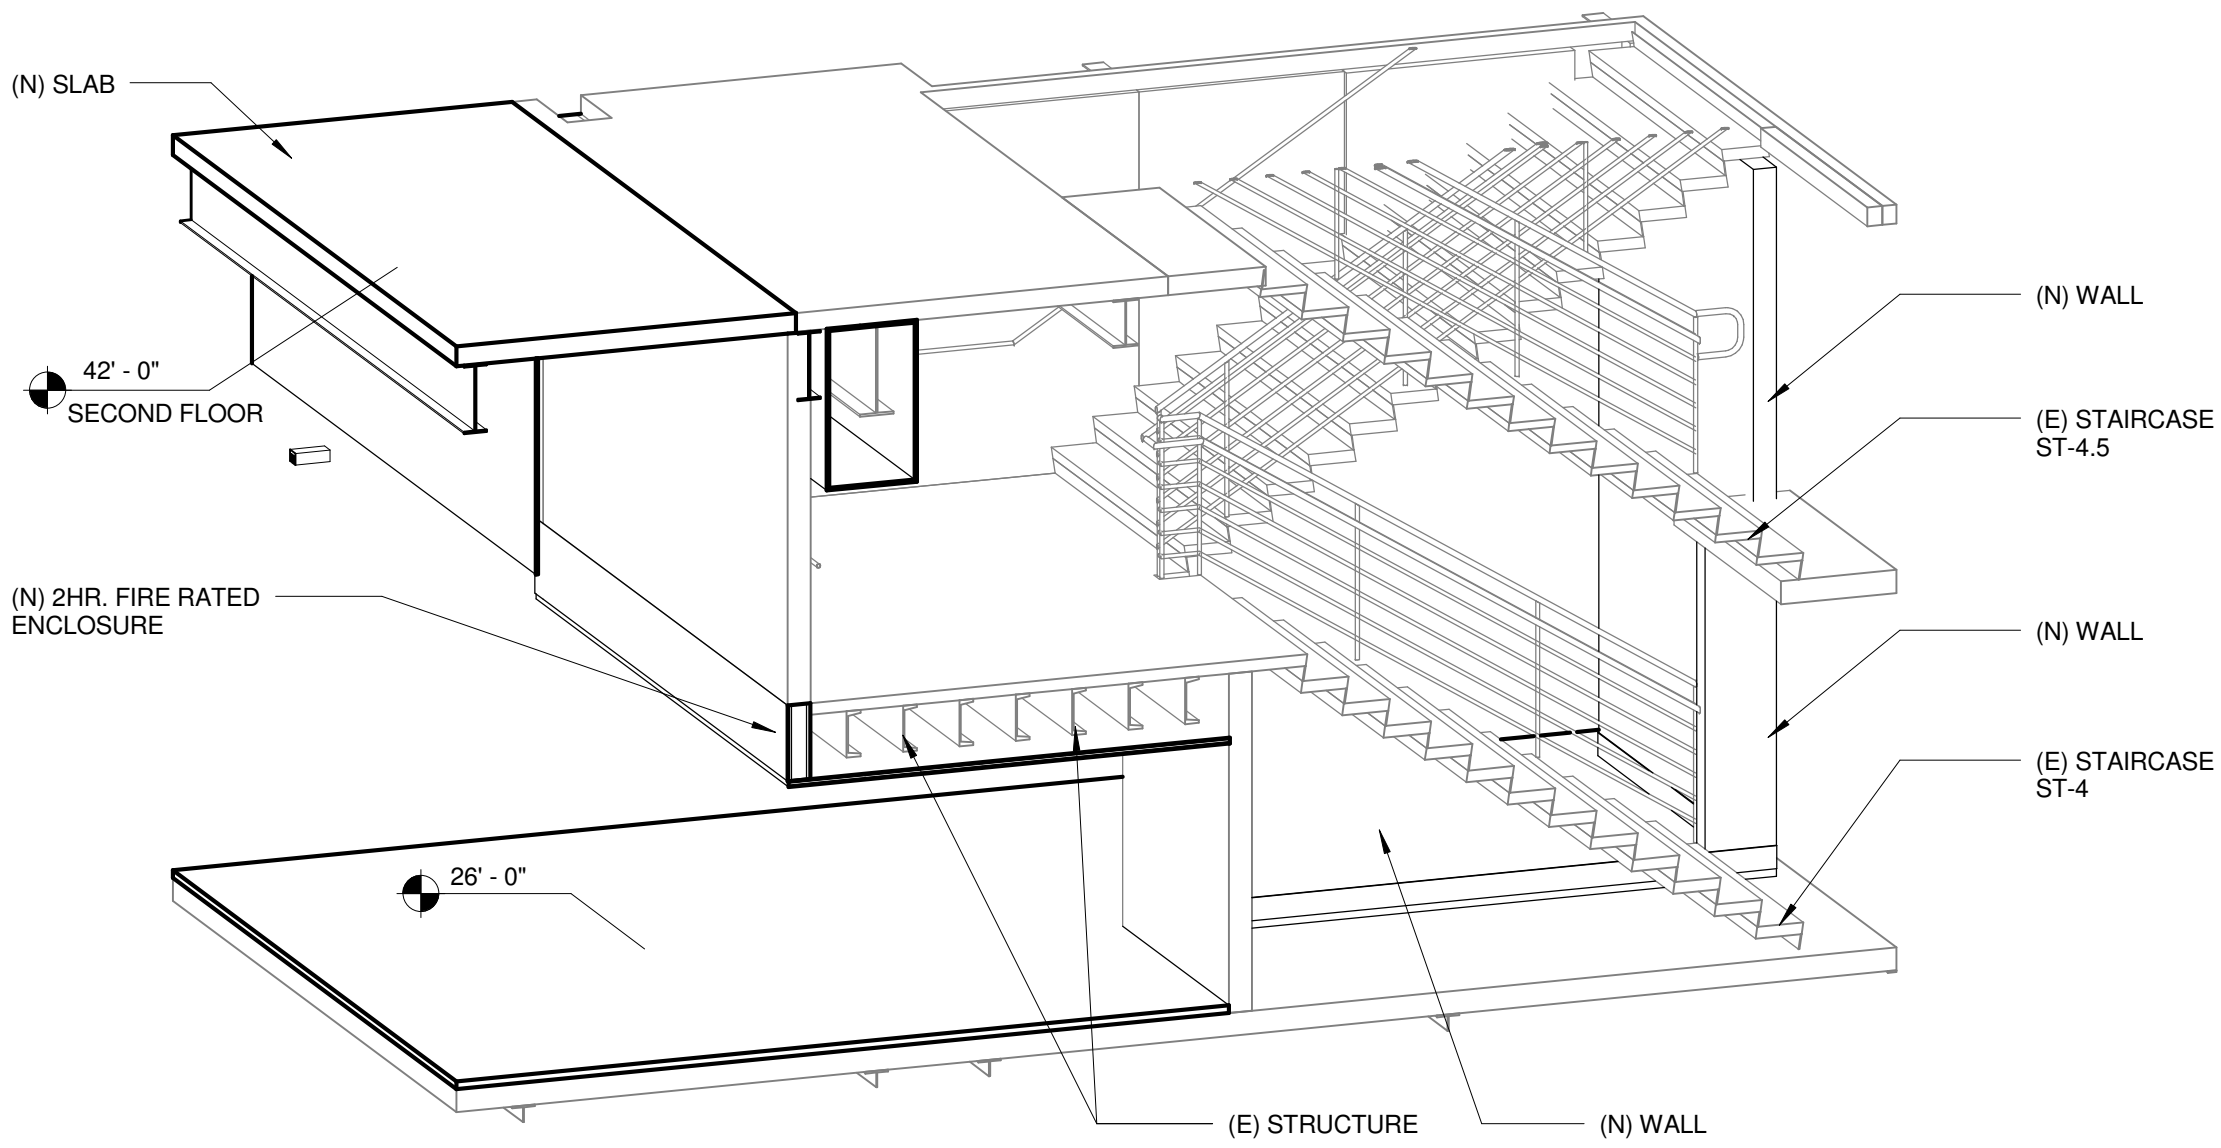

STAIR-4 3D VIEW

SCALE


4

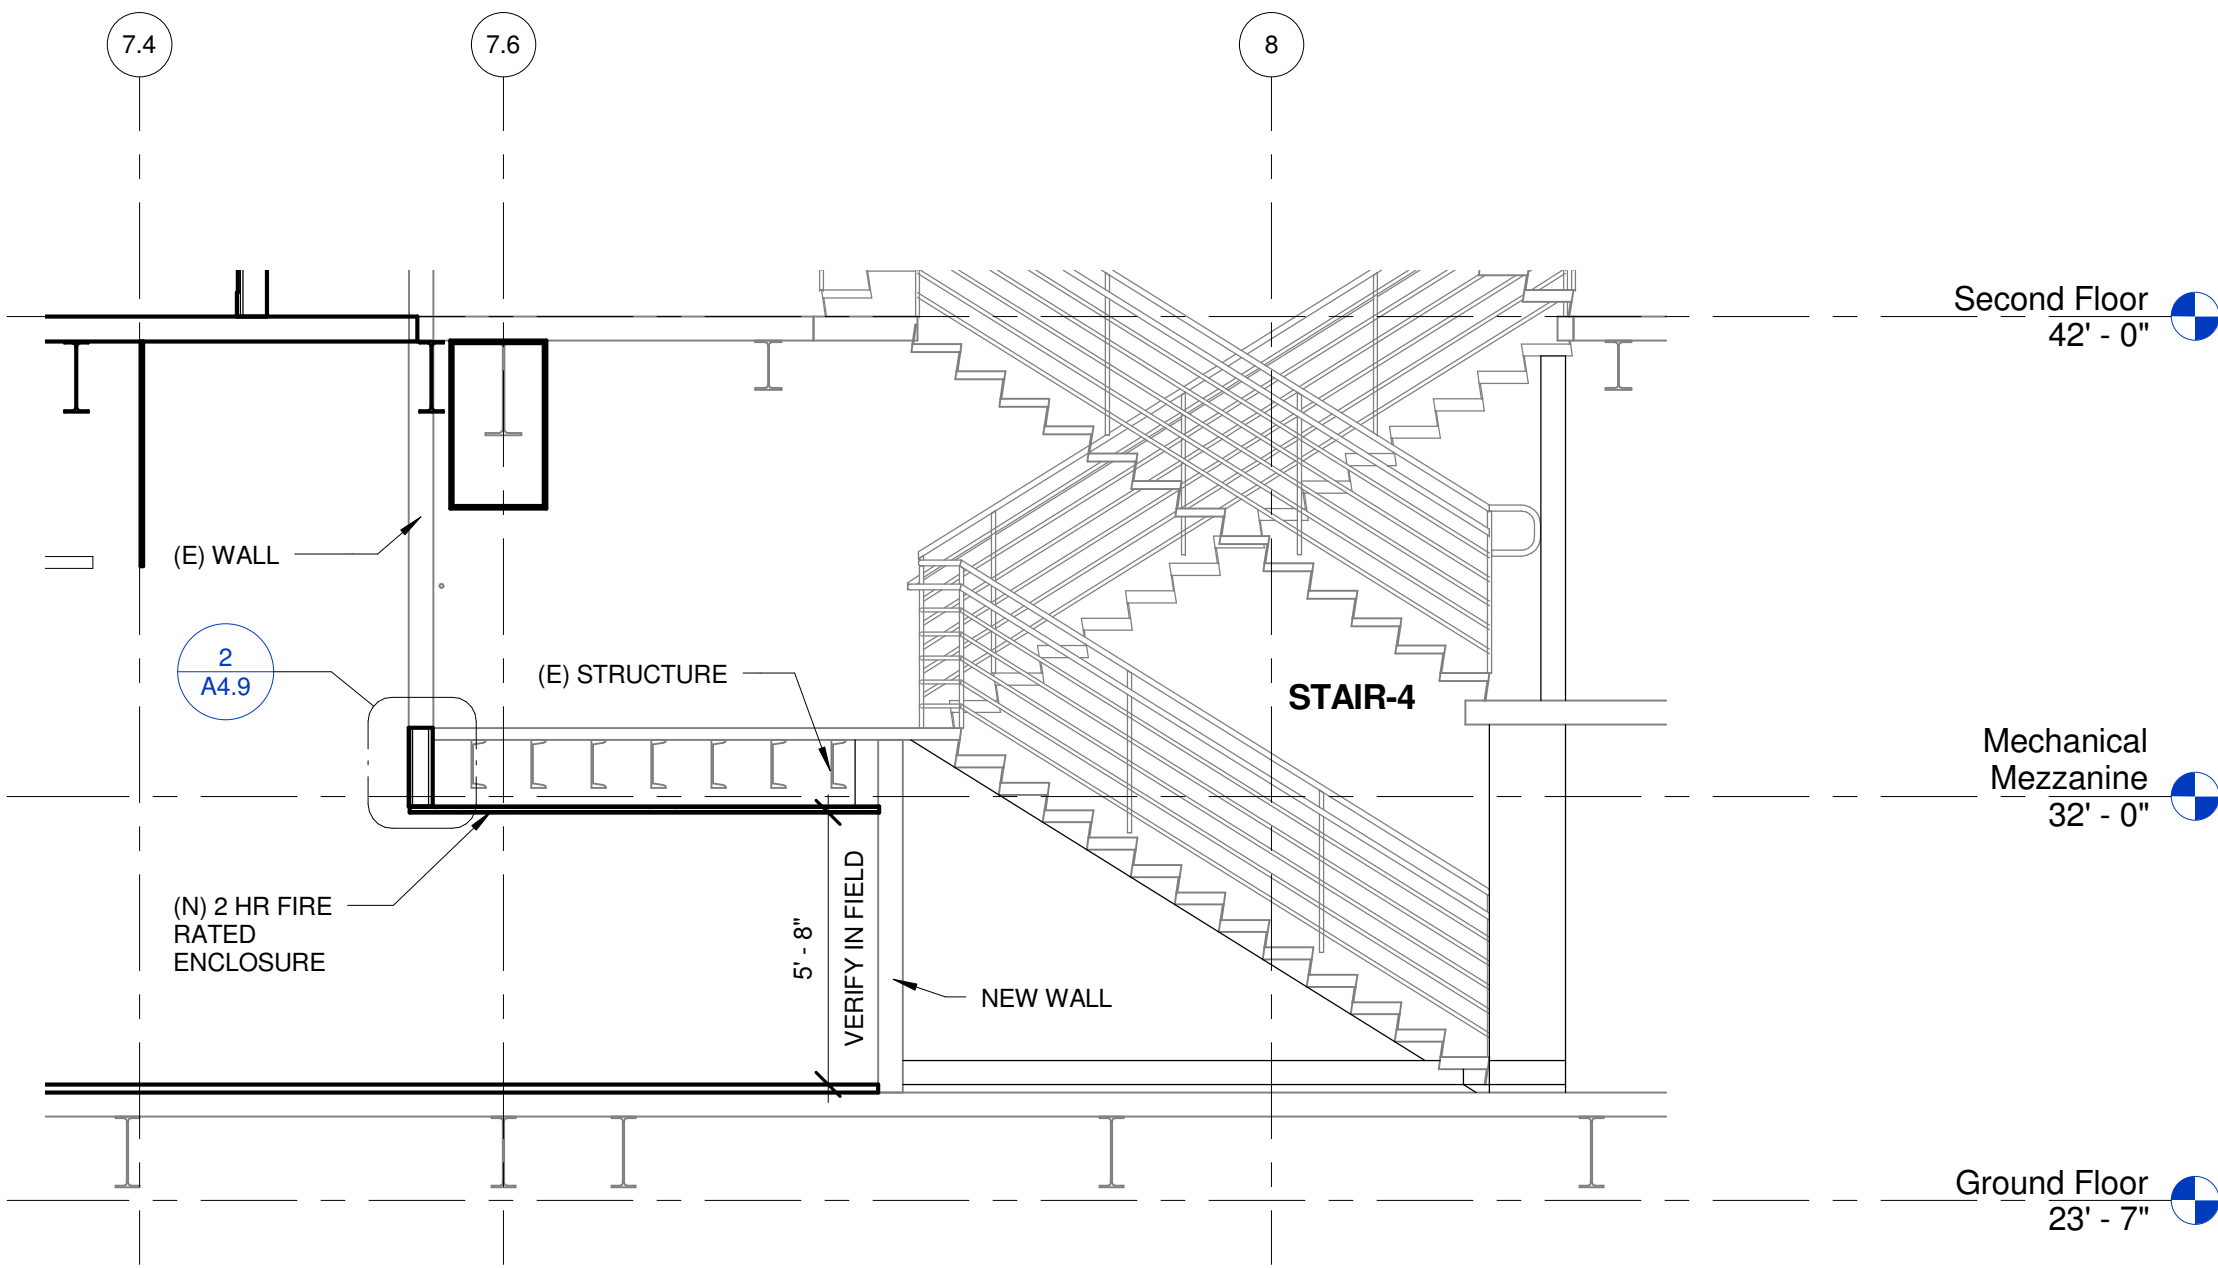

SECTION OF STAIRCASE 4 & 4.5

SCALE
1/4" = 1'-0"

3

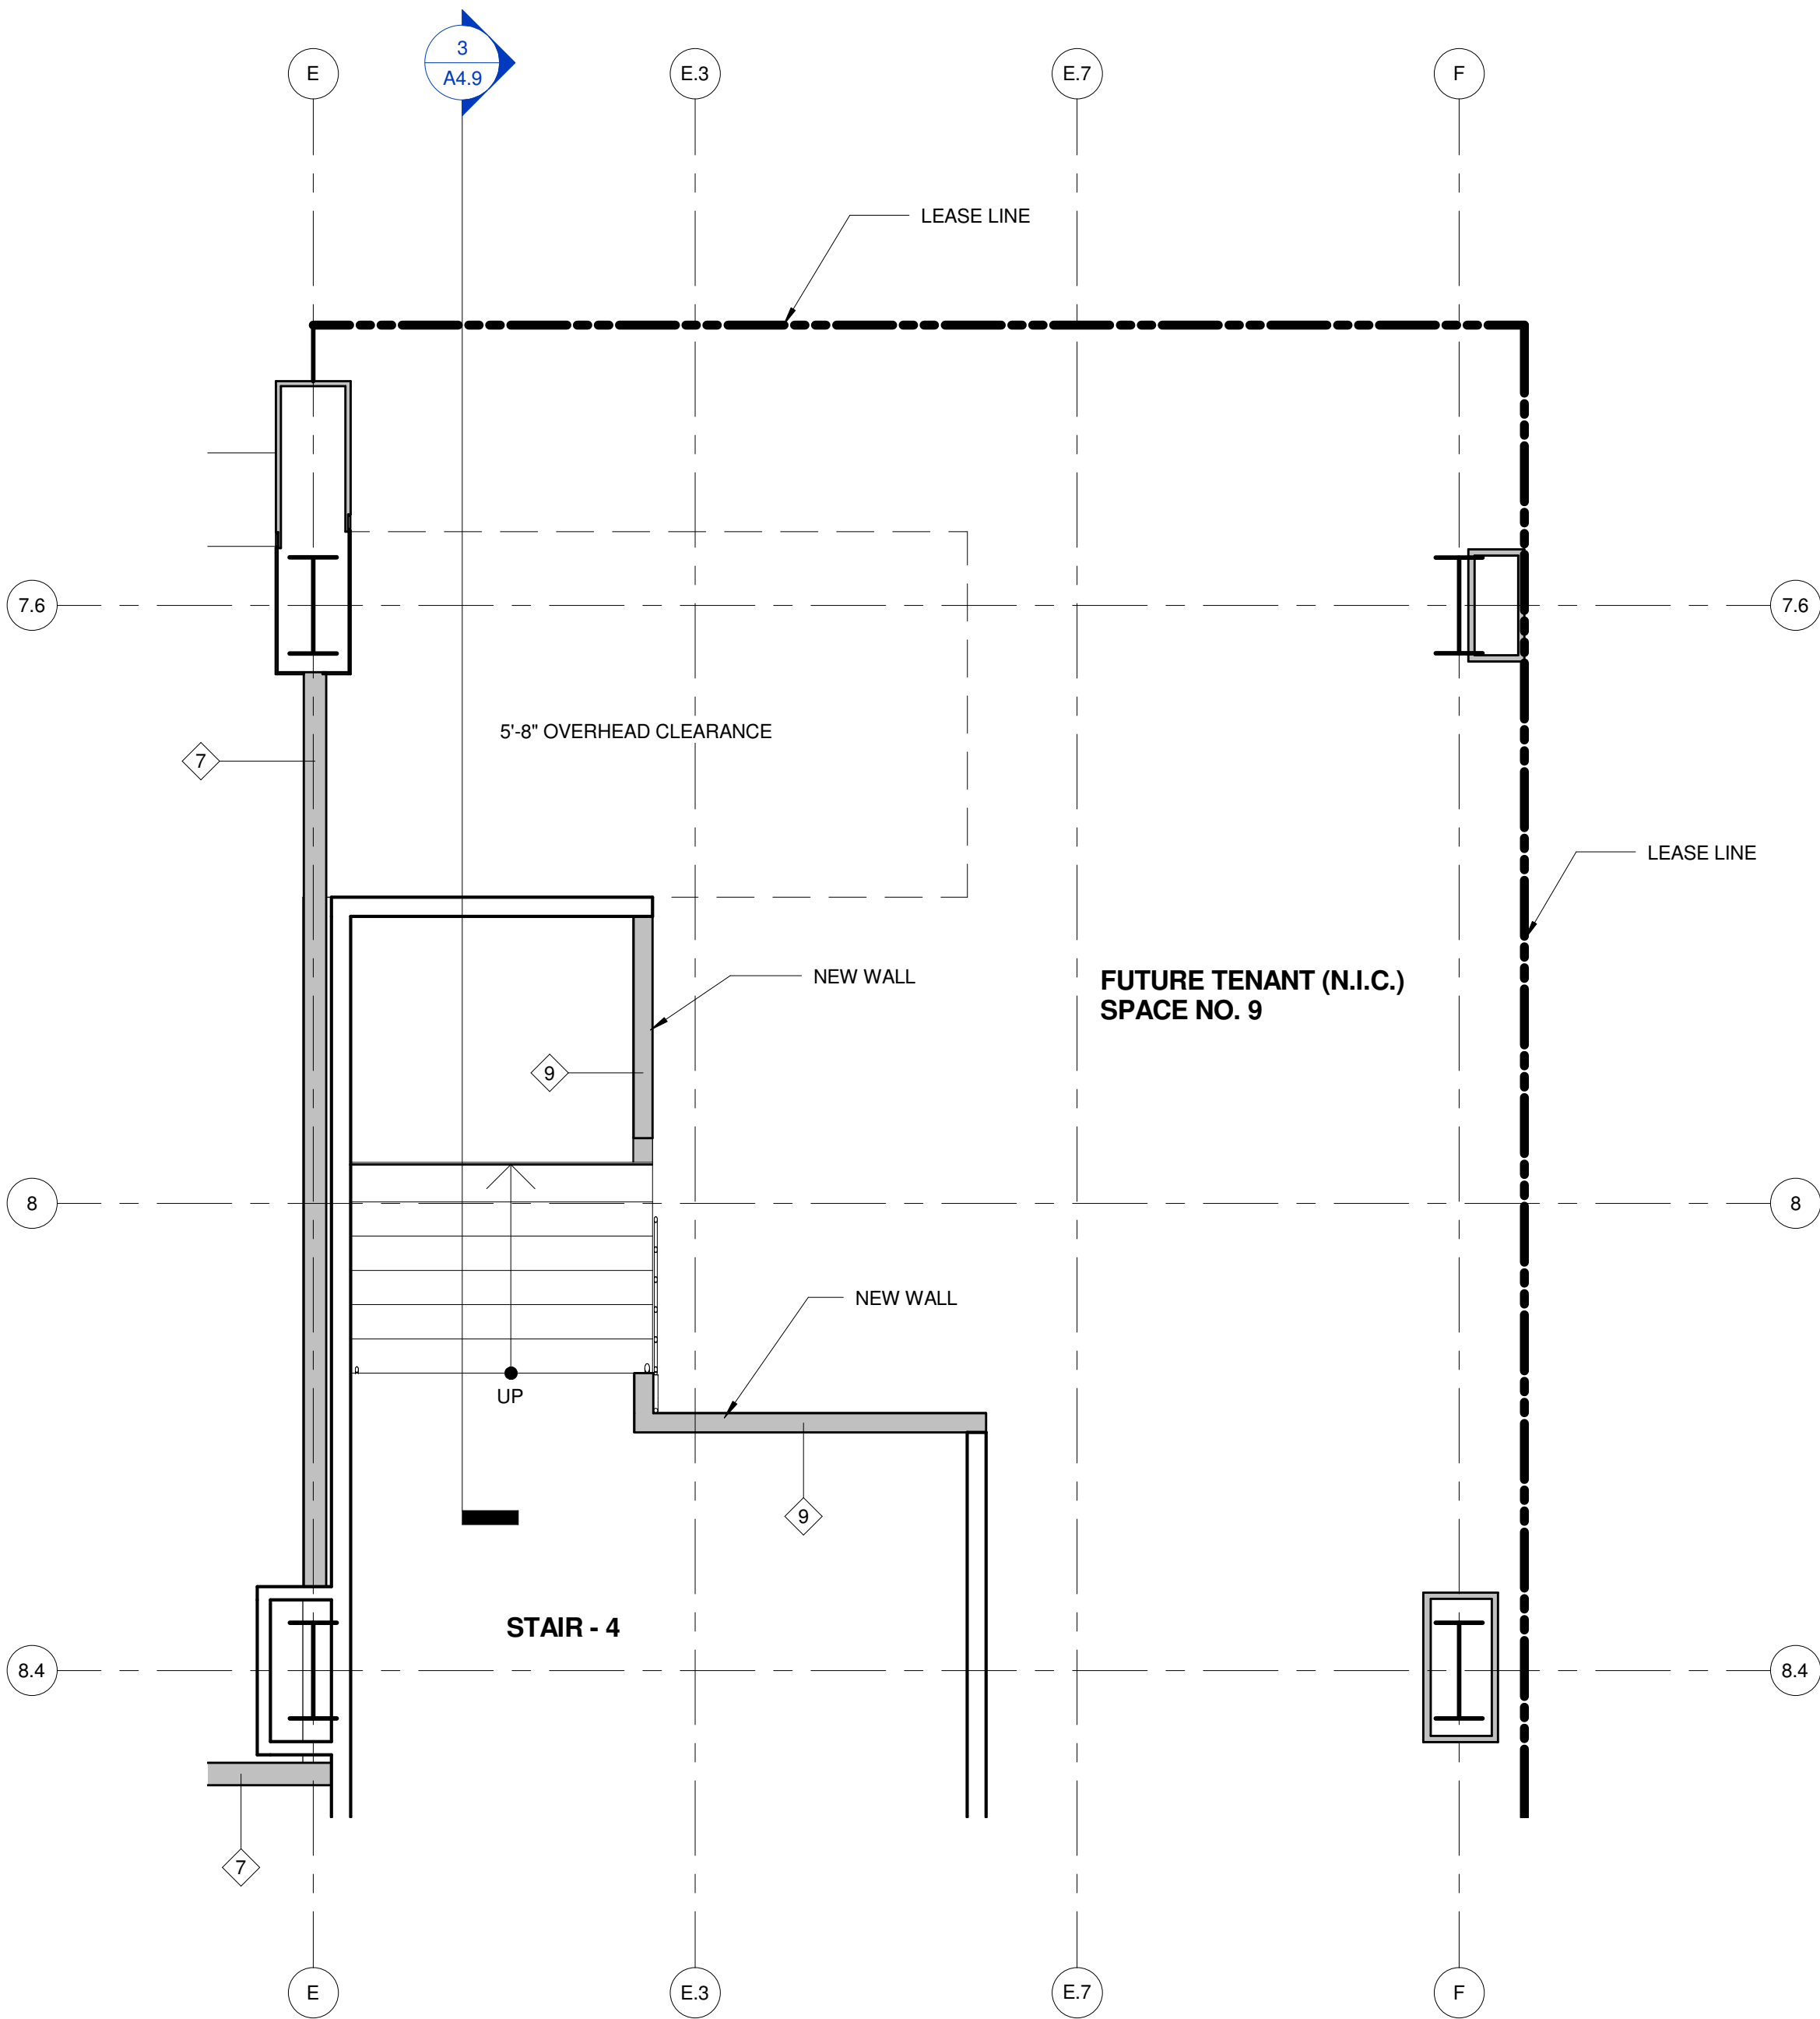

- NOTES:
- PLEASE REFER SHEET NO. A8.1-1 & A8.1-2 FOR WALL TYPES
 - PLEASE REFER SHEET NO. A2.1A FOR LOCATION OF (N) WALLS & LEASE LINES

STAIRCASE PLAN OF 4 & 4.5


SCALE
1/4" = 1'-0"

1

Consultants:

Registration No.

Key Plan












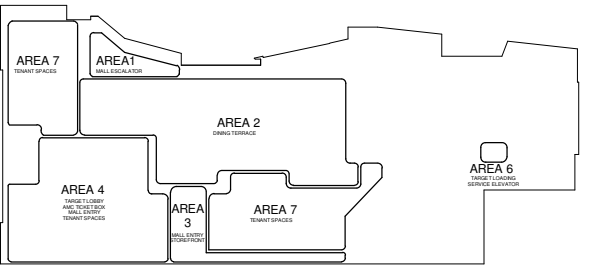


Sheet Title

STAIR NO.4 & 4.5
PLANS,SECTIONS &
PERSPECTIVE

Job No. Date Scale
1295 SEPT 01, 2010. As indicated

A4.9

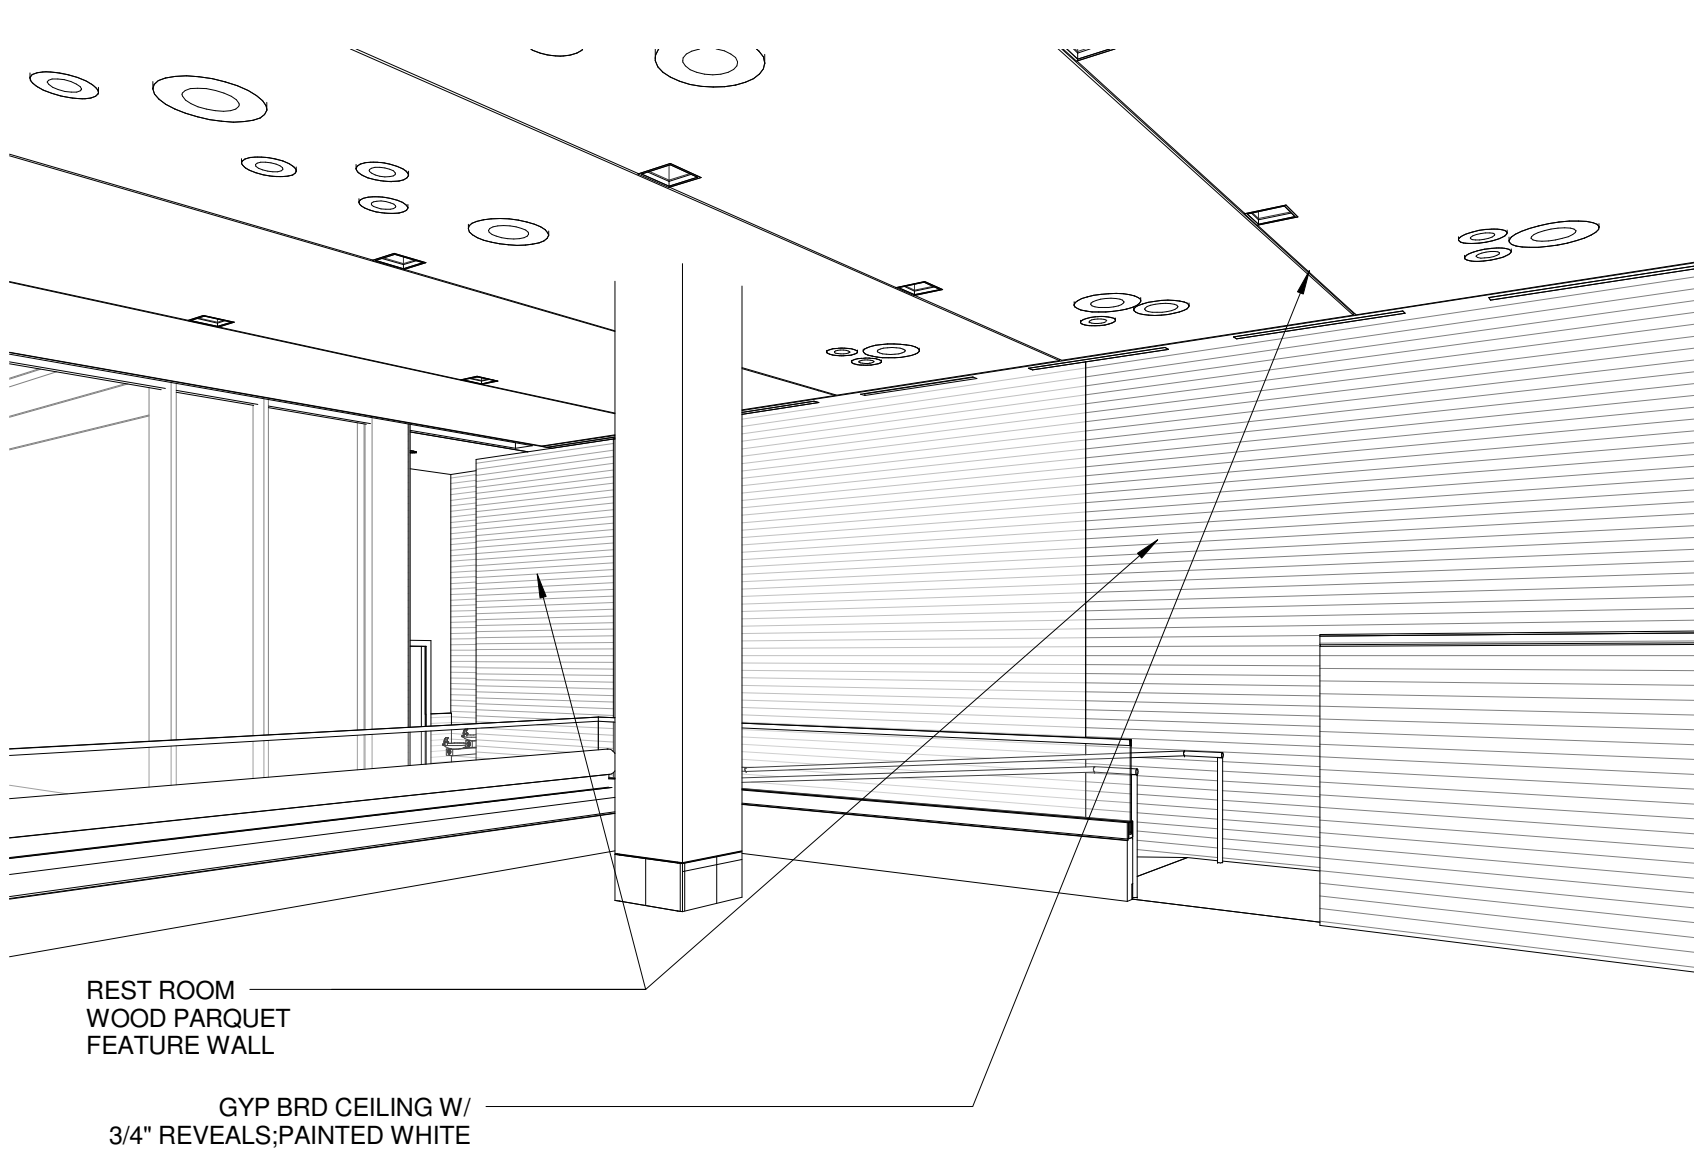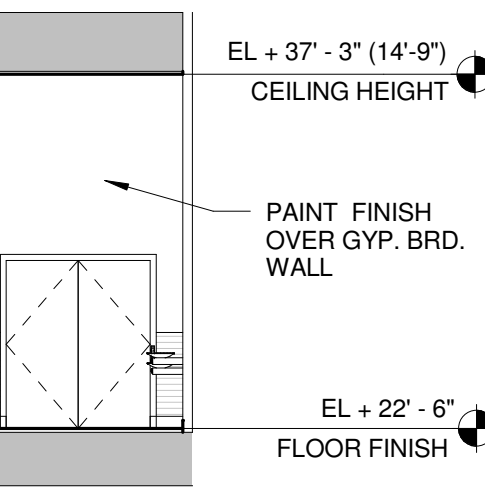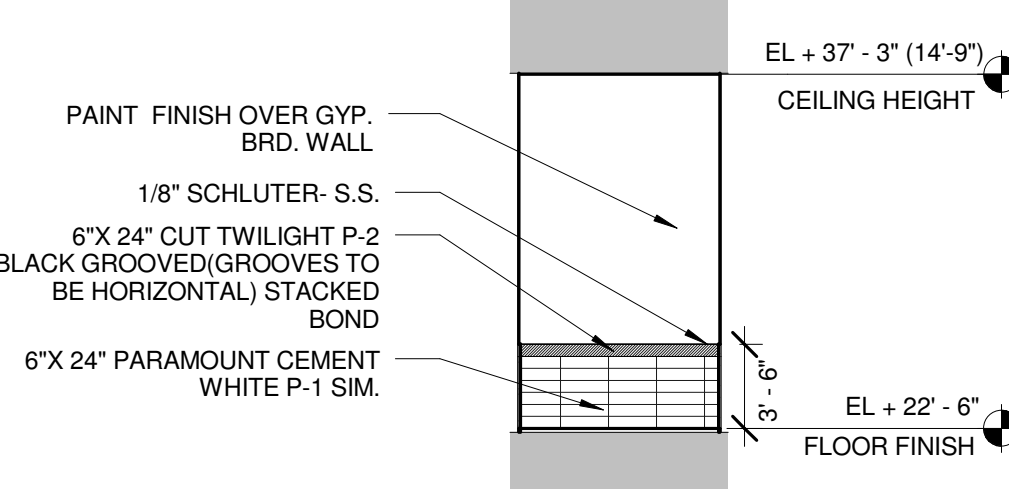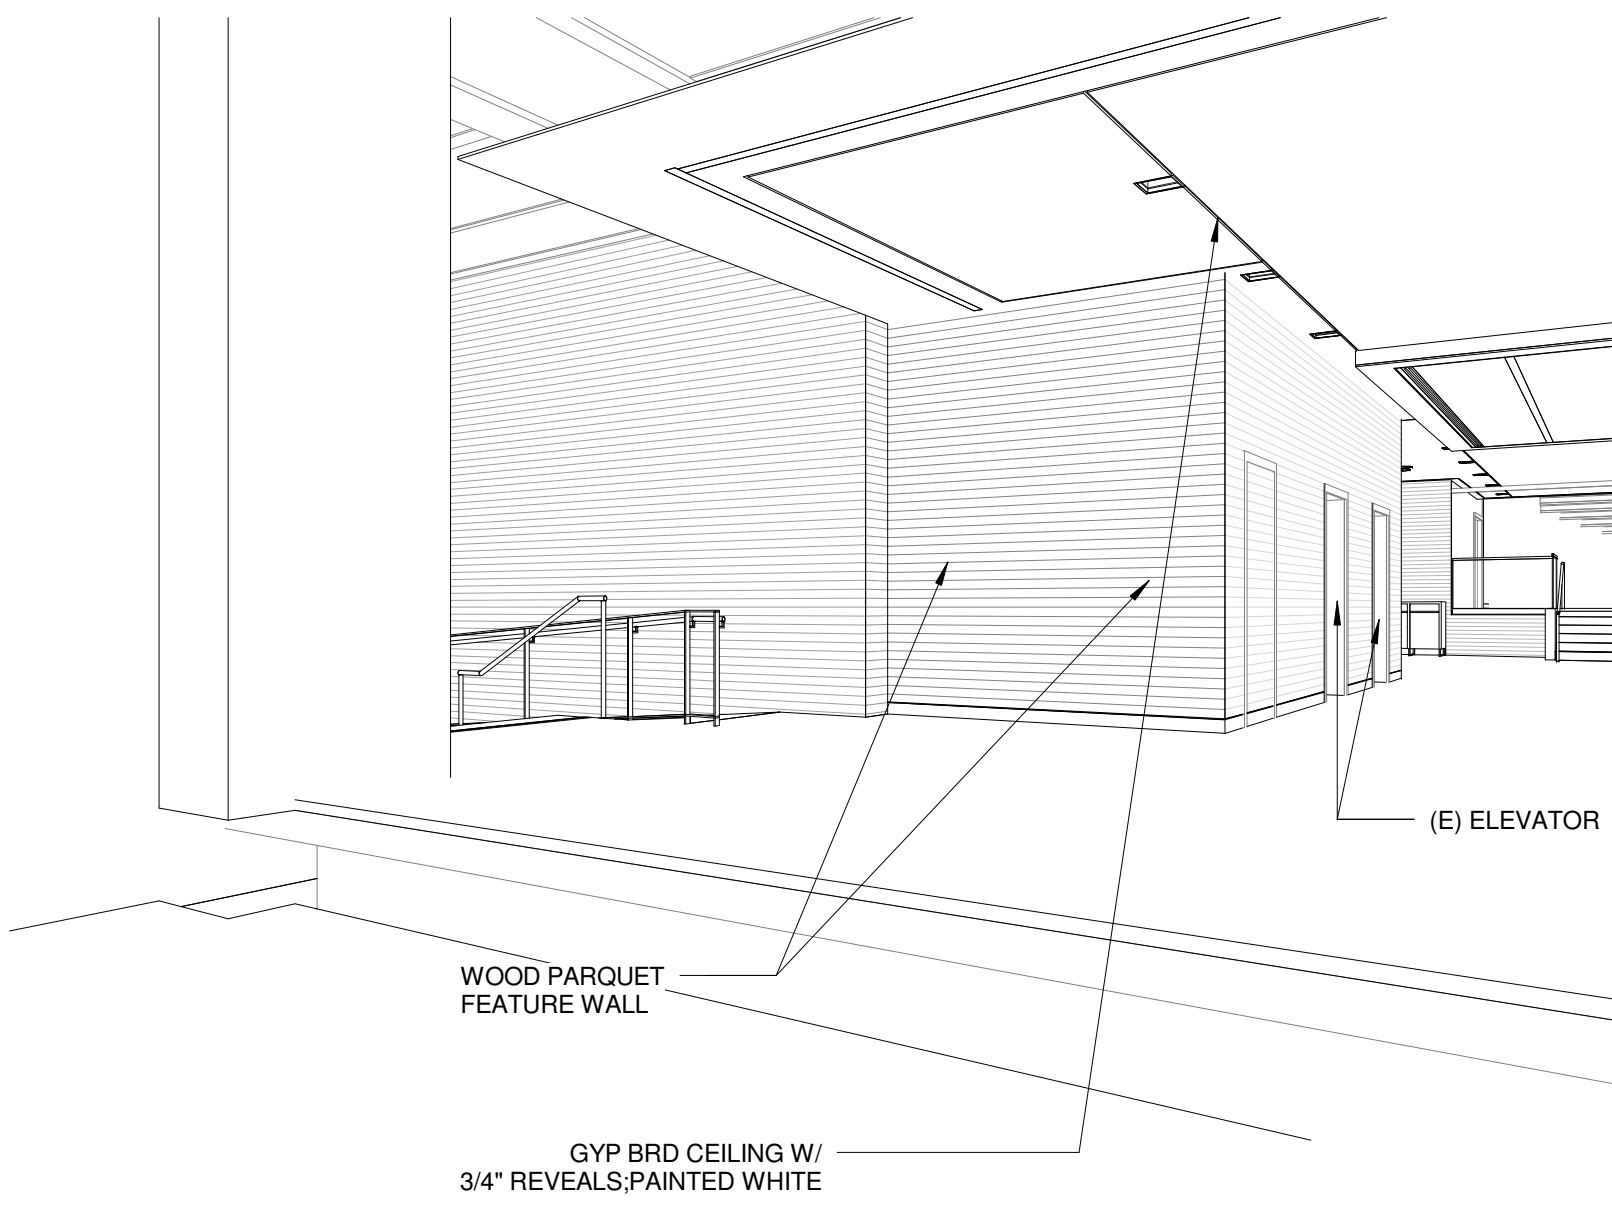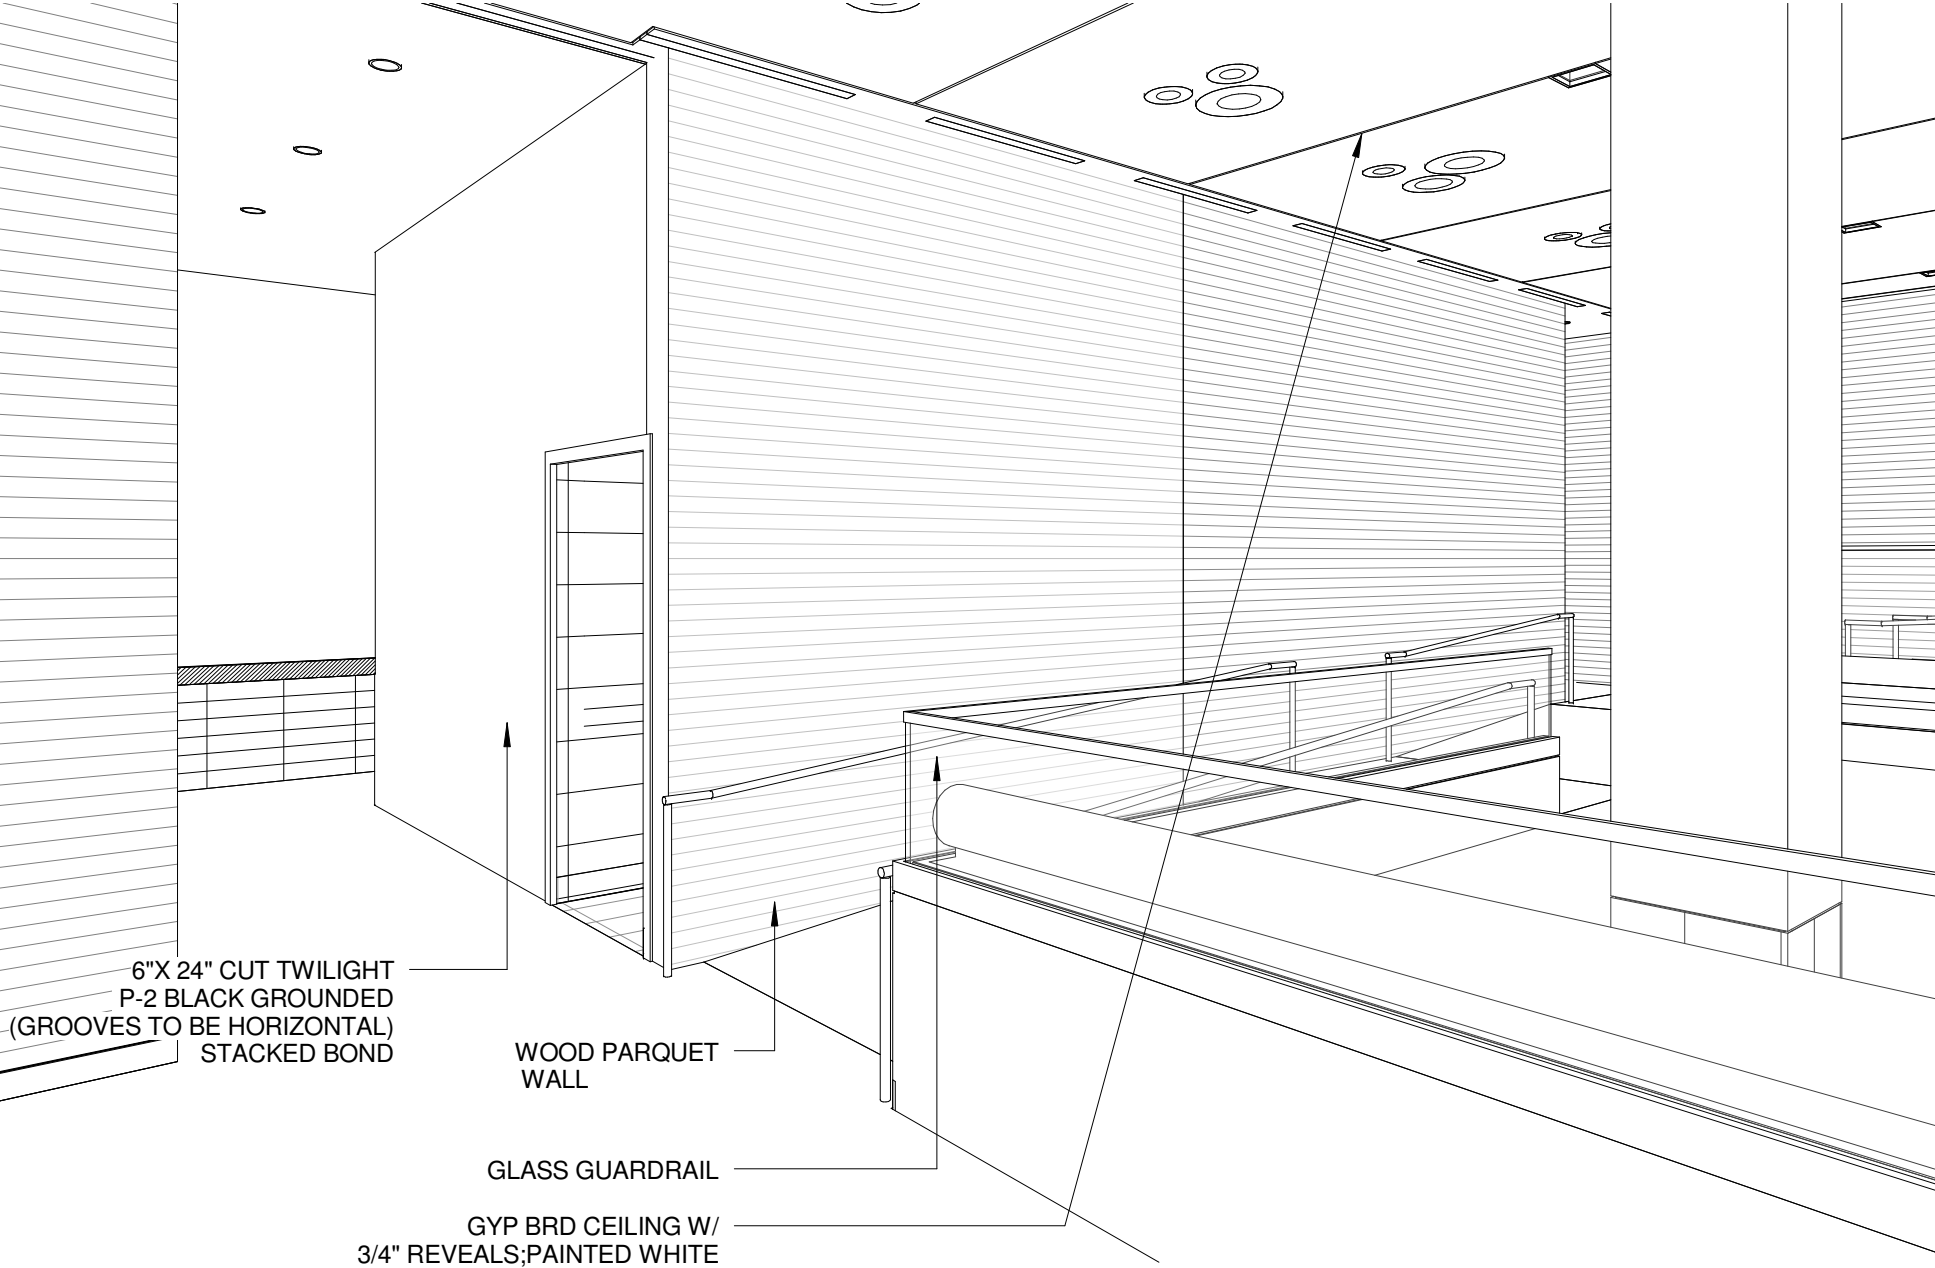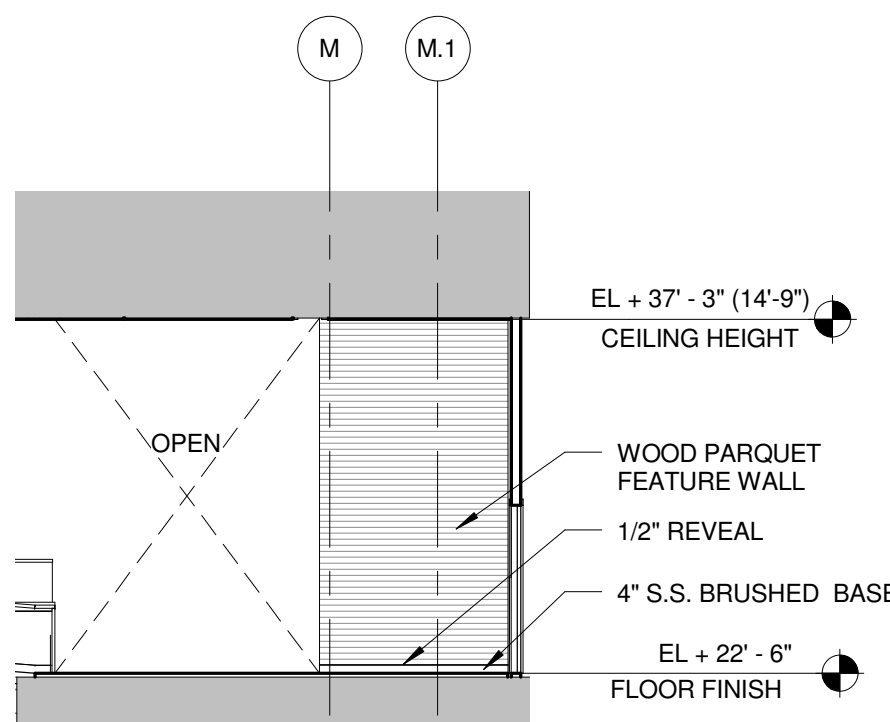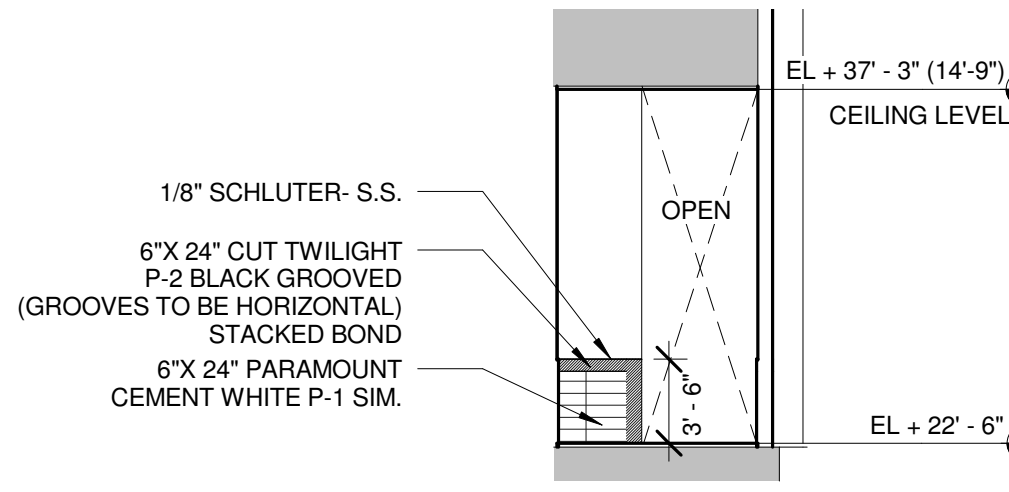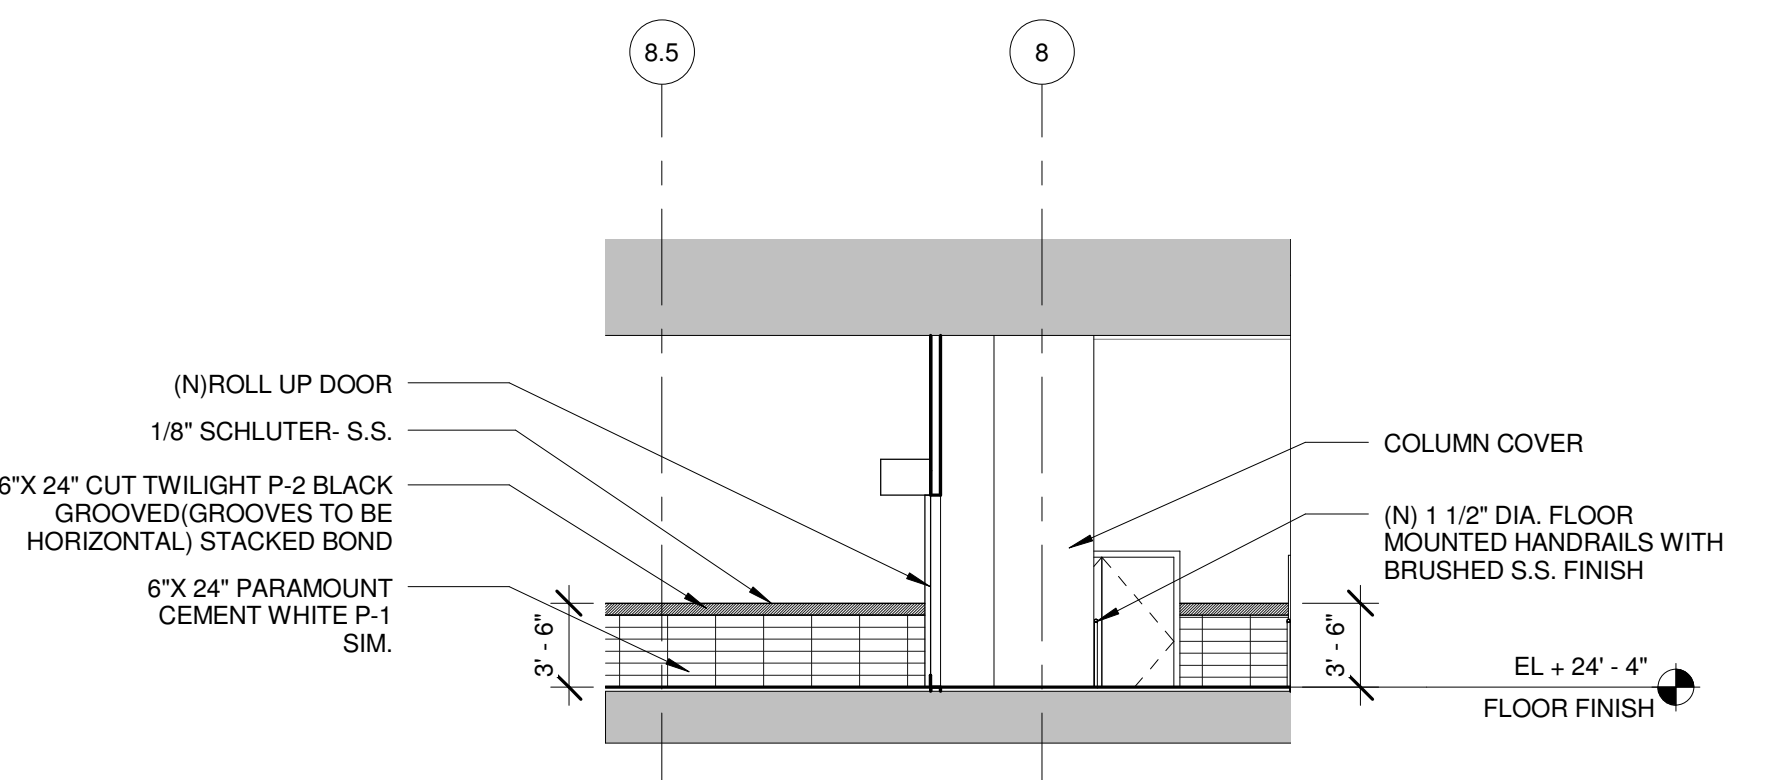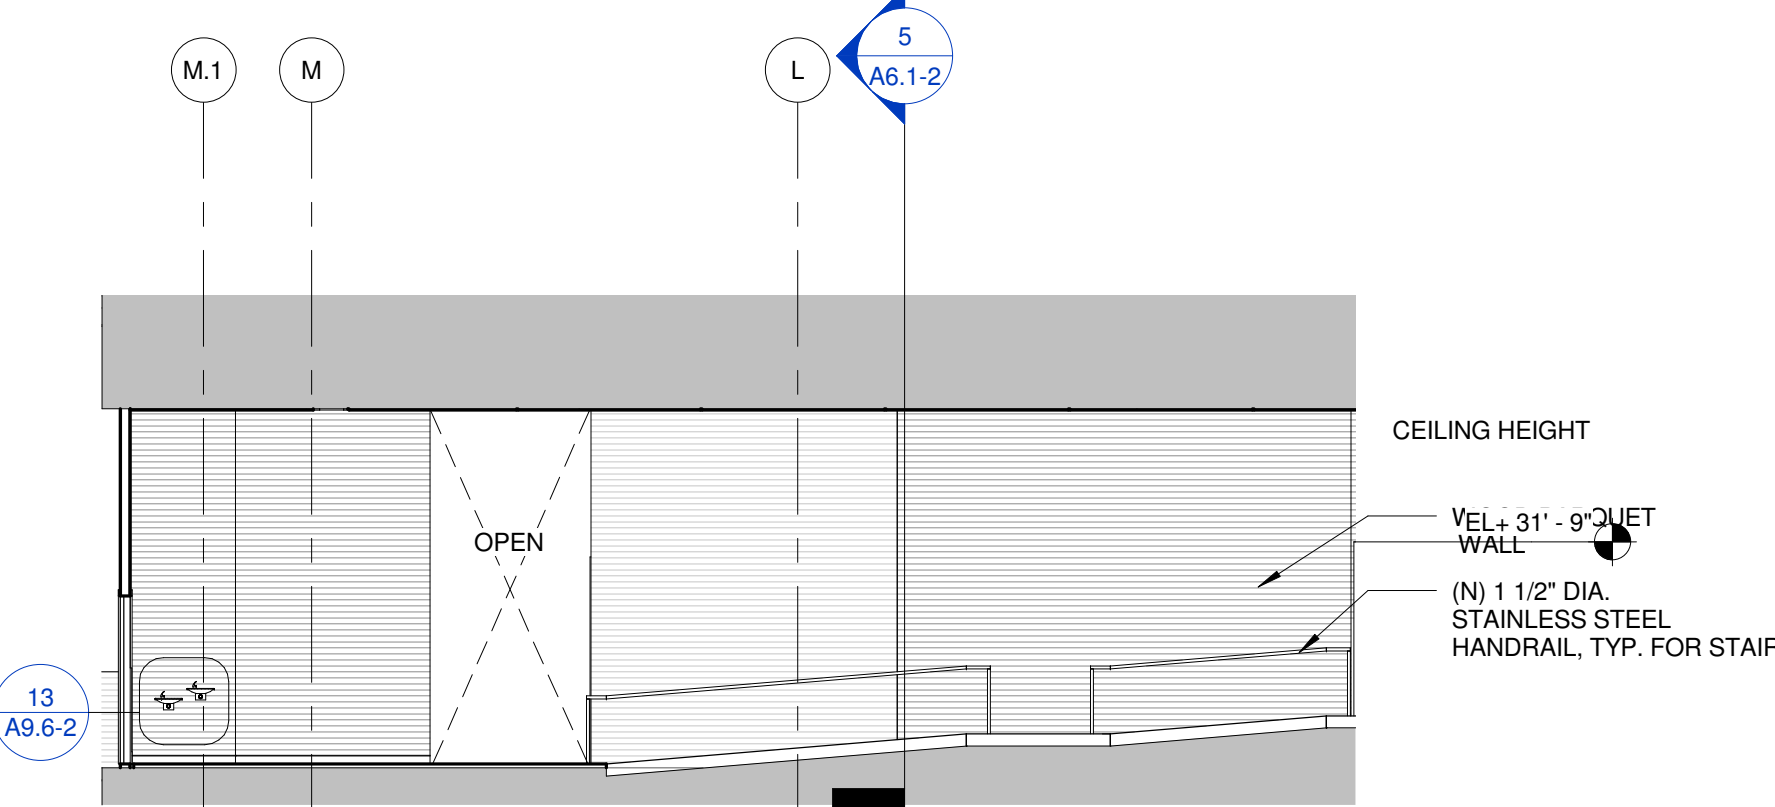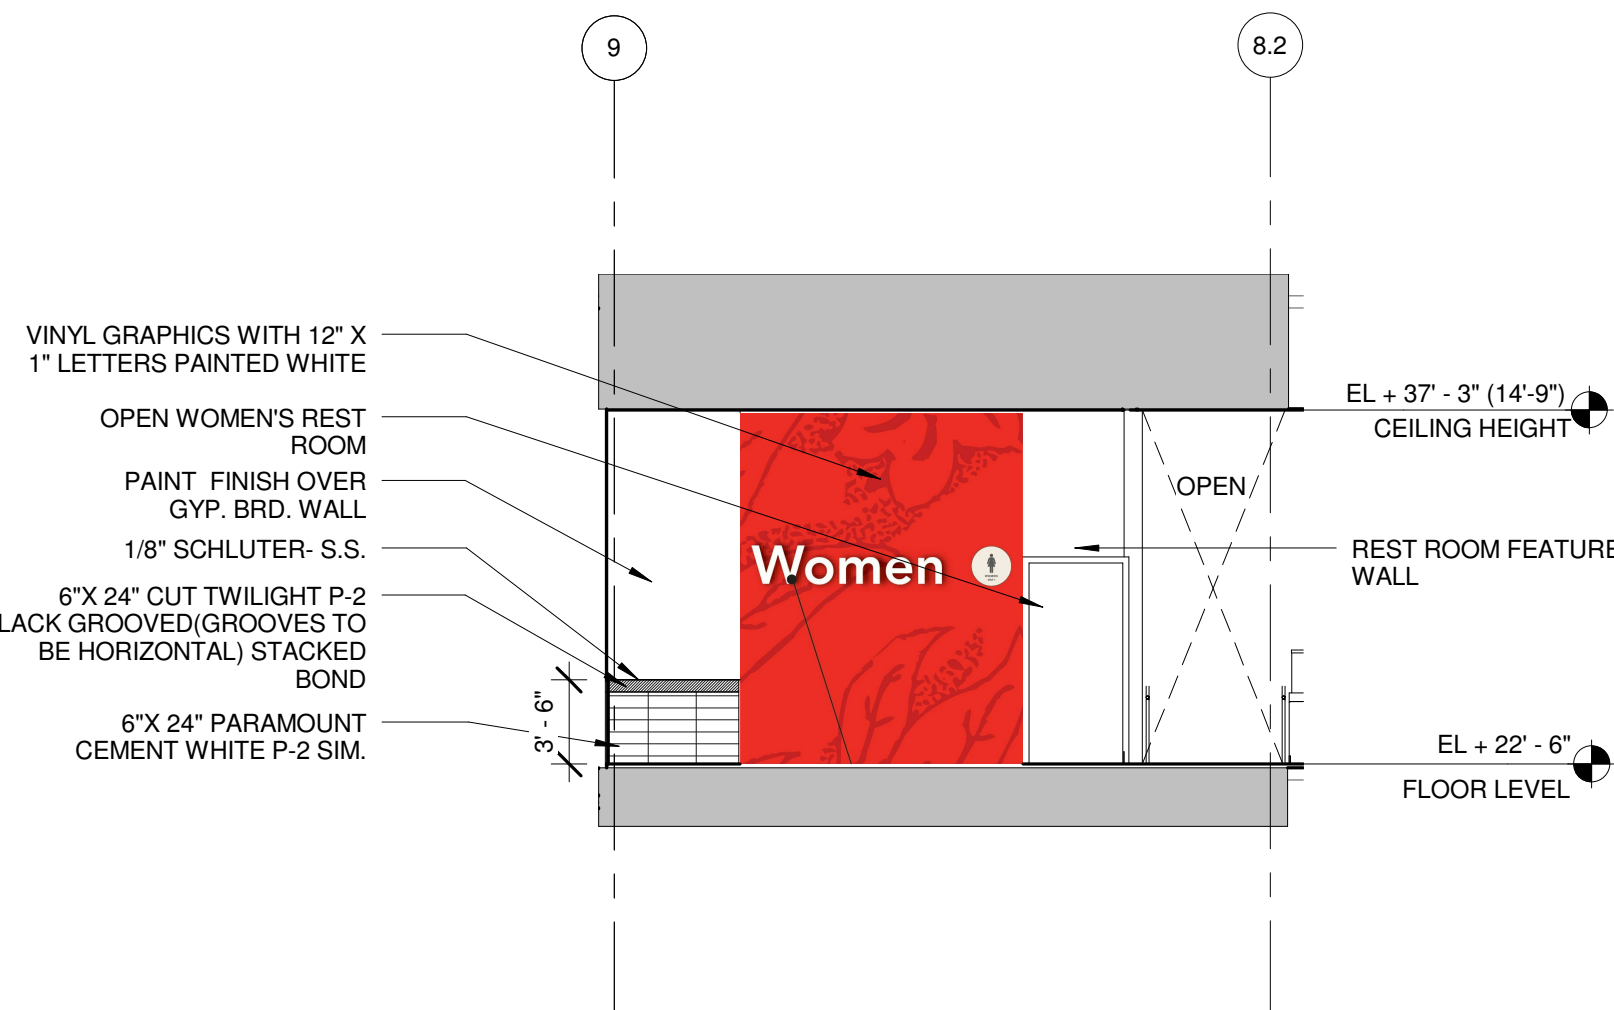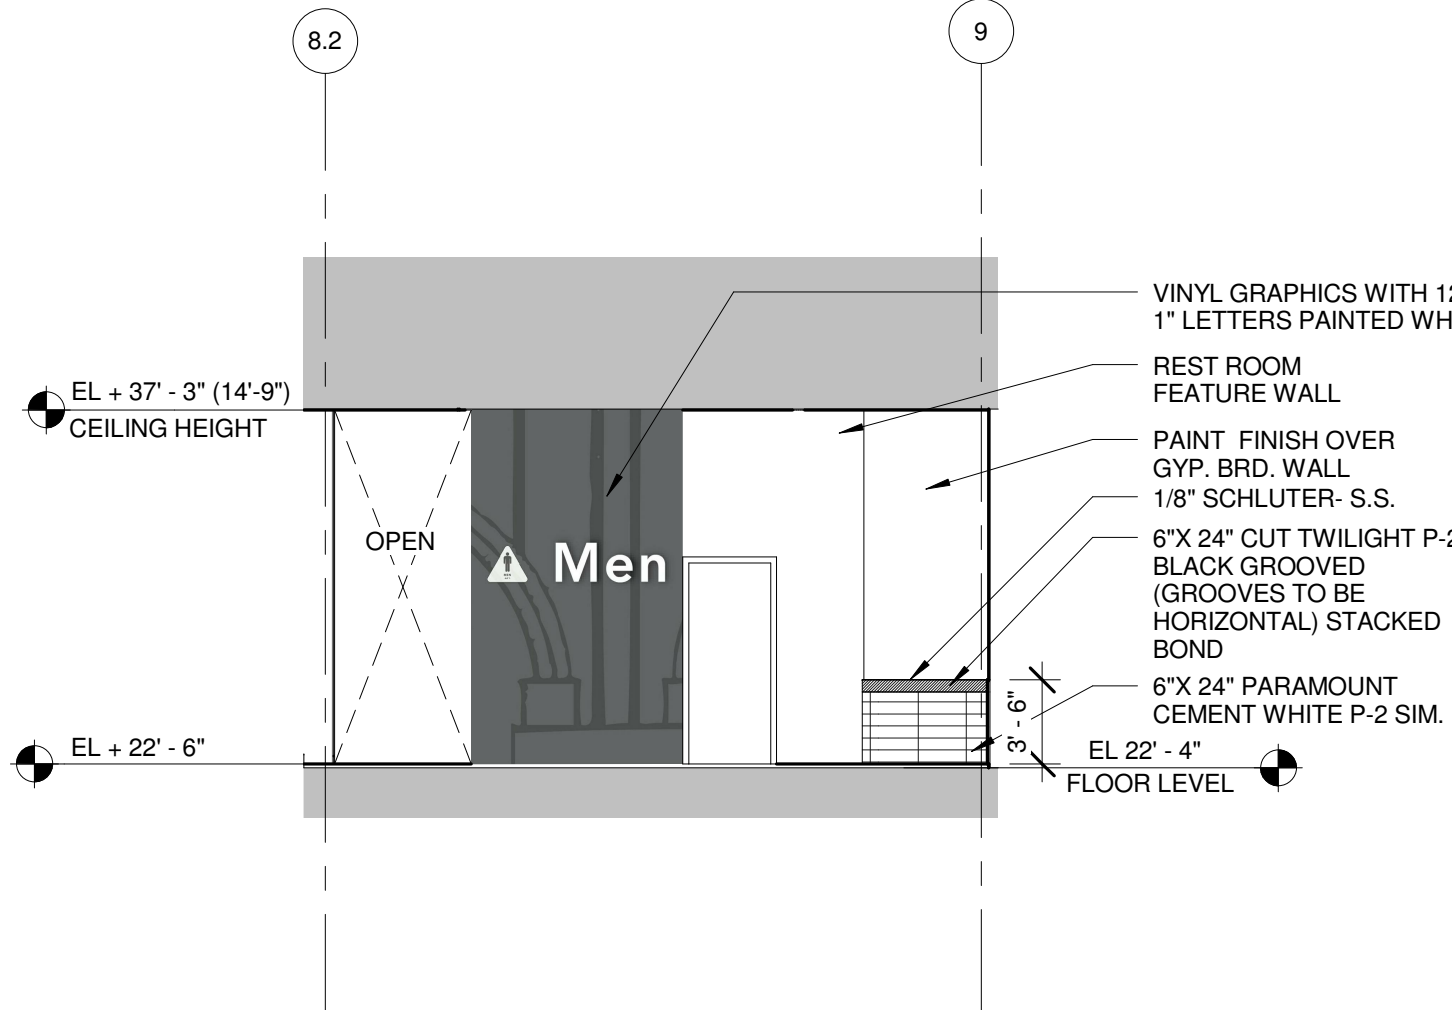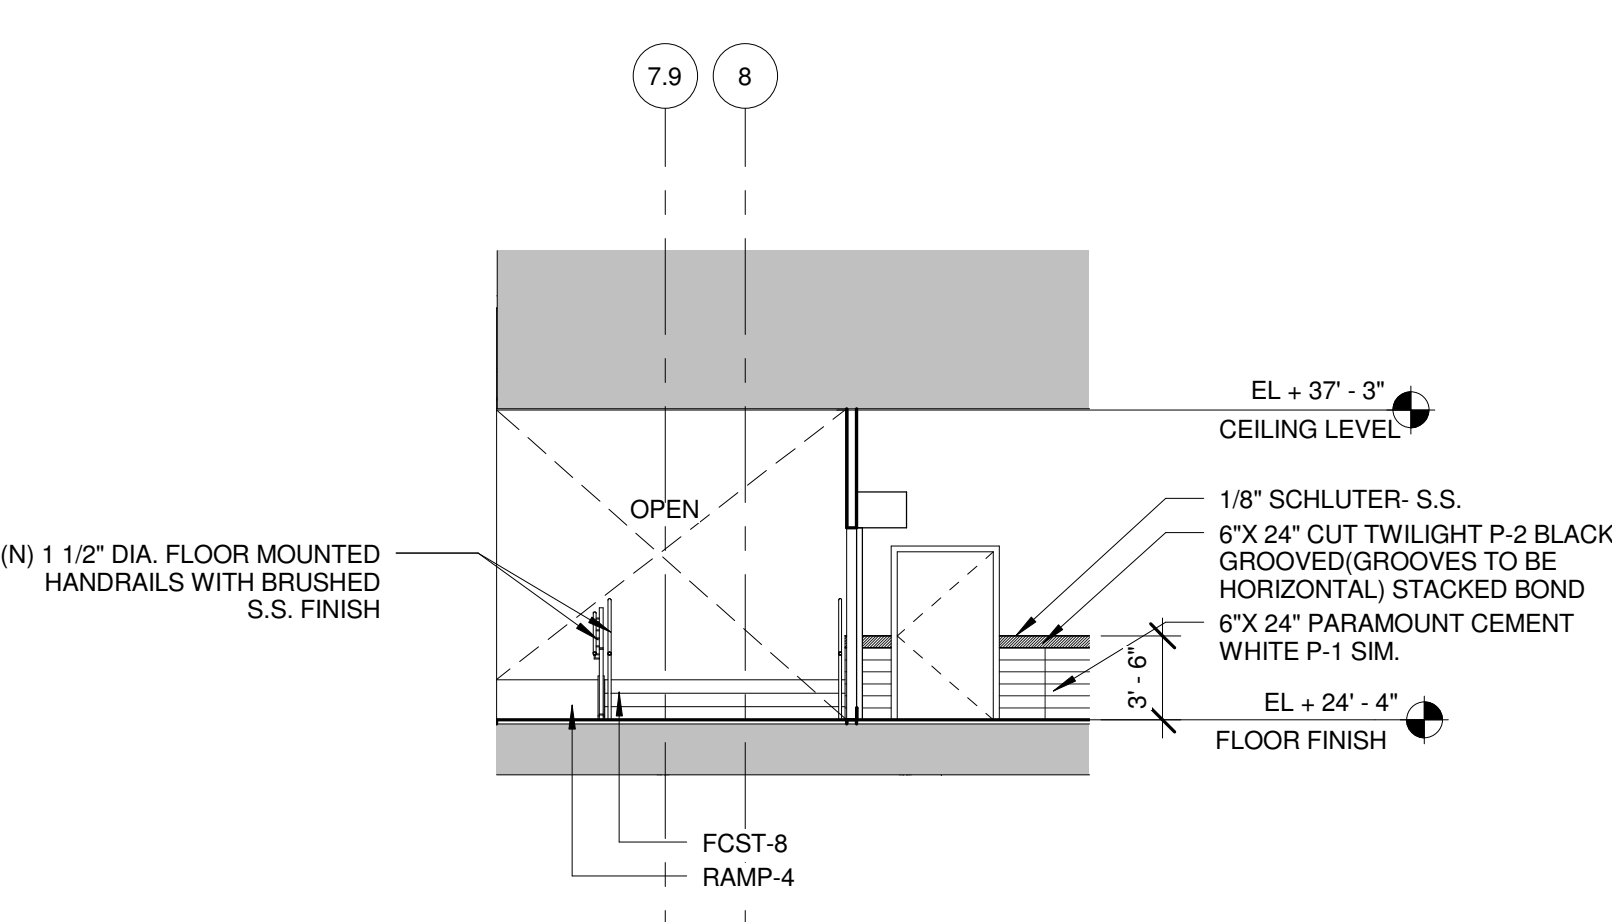
 REST ROOM WOOD PARQUET FEATURE WALL GYP BRD CEILING W/ 3/4" REVEALS,PAINTED WHITE FOOD COURT	 EL + 37' - 3" (14'-9") CEILING HEIGHT PAINT FINISH OVER GYP. BRD. WALL EL + 22' - 6" FLOOR FINISH	 PAINT FINISH OVER GYP. BRD. WALL 1/8" SCHLUTER- S.S. 6"X 24" CUT TWILIGHT P-2 BLACK GROOVED(GROOVES TO BE HORIZONTAL) STACKED BOND 6"X 24" PARAMOUNT CEMENT WHITE P-1 SIM. EL + 37' - 3" (14'-9") CEILING HEIGHT EL + 22' - 6" FLOOR FINISH	 WOOD PARQUET FEATURE WALL GYP BRD CEILING W/ 3/4" REVEALS,PAINTED WHITE (E) ELEVATOR
FOOD COURT- Elevation View 2 SCALE 12	FOOD COURT- Elevation SCALE 1/8" = 1'-0" 9	FOOD COURT- Elevation-13 SCALE 1/8" = 1'-0" 6	FOOD COURT- 3D VIEW SCALE 3
 6"X 24" CUT TWILIGHT P-2 BLACK GROOVED (GROOVES TO BE HORIZONTAL) STACKED BOND WOOD PARQUET WALL GLASS GUARDRAIL GYP BRD CEILING W/ 3/4" REVEALS,PAINTED WHITE	 EL + 37' - 3" (14'-9") CEILING HEIGHT WOOD PARQUET FEATURE WALL 1/2" REVEAL 4" S.S. BRUSHED BASE EL + 22' - 6" FLOOR FINISH	 1/8" SCHLUTER- S.S. 6"X 24" CUT TWILIGHT P-2 BLACK GROOVED (GROOVES TO BE HORIZONTAL) STACKED BOND 6"X 24" PARAMOUNT CEMENT WHITE P-1 SIM. EL + 37' - 3" (14'-9") CEILING LEVEL EL + 22' - 6" FLOOR FINISH	 (N)ROLL UP DOOR 1/8" SCHLUTER- S.S. 6"X 24" CUT TWILIGHT P-2 BLACK GROOVED(GROOVES TO BE HORIZONTAL) STACKED BOND COLUMN COVER (N) 1 1/2" DIA. FLOOR MOUNTED HANDRAILS WITH BRUSHED S.S. FINISH EL + 24' - 4" FLOOR FINISH
3D View 34 SCALE 11	FOOD COURT- Elevation-15 SCALE 1/8" = 1'-0" 8	FOOD COURT- Elevation-12 SCALE 1/8" = 1'-0" 5	FOOD COURT- Elevation-10 SCALE 1/8" = 1'-0" 2
 CEILING HEIGHT EL + 37' - 3" (14'-9") 1/8" SCHLUTER- S.S. (N) 1 1/2" DIA. STAINLESS STEEL HANDRAIL, TYP. FOR STAIR EL + 22' - 6" FLOOR FINISH	 VINYL GRAPHICS WITH 12" X 1" LETTERS PAINTED WHITE OPEN WOMEN'S REST ROOM PAINT FINISH OVER GYP. BRD. WALL 1/8" SCHLUTER- S.S. 6"X 24" CUT TWILIGHT P-2 BLACK GROOVED(GROOVES TO BE HORIZONTAL) STACKED BOND 6"X 24" PARAMOUNT CEMENT WHITE P-2 SIM. EL + 37' - 3" (14'-9") CEILING HEIGHT EL + 22' - 6" FLOOR LEVEL	 EL + 37' - 3" (14'-9") CEILING HEIGHT REST ROOM FEATURE WALL PAINT FINISH OVER GYP. BRD. WALL 1/8" SCHLUTER- S.S. 6"X 24" CUT TWILIGHT P-2 BLACK GROOVED (GROOVES TO BE HORIZONTAL) STACKED BOND 6"X 24" PARAMOUNT CEMENT WHITE P-2 SIM. EL + 22' - 6" FLOOR LEVEL	 EL + 37' - 3" CEILING LEVEL 1/8" SCHLUTER- S.S. (N) 1 1/2" DIA. FLOOR MOUNTED HANDRAILS WITH BRUSHED S.S. FINISH EL + 24' - 4" FLOOR FINISH
FOOD COURT- Elevation-17 SCALE 1/8" = 1'-0" 10	FOOD COURT- Elevation-14 SCALE 1/8" = 1'-0" 7	FOOD COURT- Elevation-11 SCALE 1/8" = 1'-0" 4	FOOD COURT- Elevation-8 SCALE 1/8" = 1'-0" 1

1. DRAFT STOPS TO EXTEND DOWNWARDS AT LEAST 12" BELOW THE CEILING. FIRE SPRINKLERS SHALL BE INSTALLED IN THE CEILING WITHIN 2" OF THE DRAFT CURTAIN AND NOT MORE THAN 6" ON CENTER AS PER CBC 707.2

Consultants:

Registration No.


Key Plan

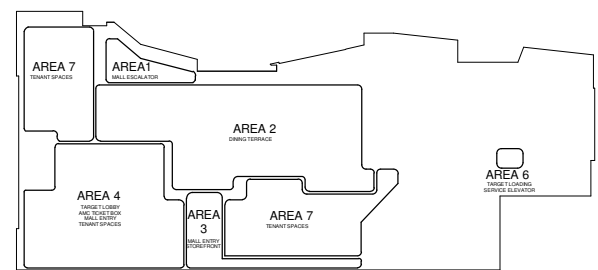

Sheet Title
**INTERIOR
ELEVATIONS,
SECTIONS, AND
PERSPECTIVES**

Job No. Date Scale
1295 SEPT 01, 2010. 1/8" = 1'-0"


A4.5-2

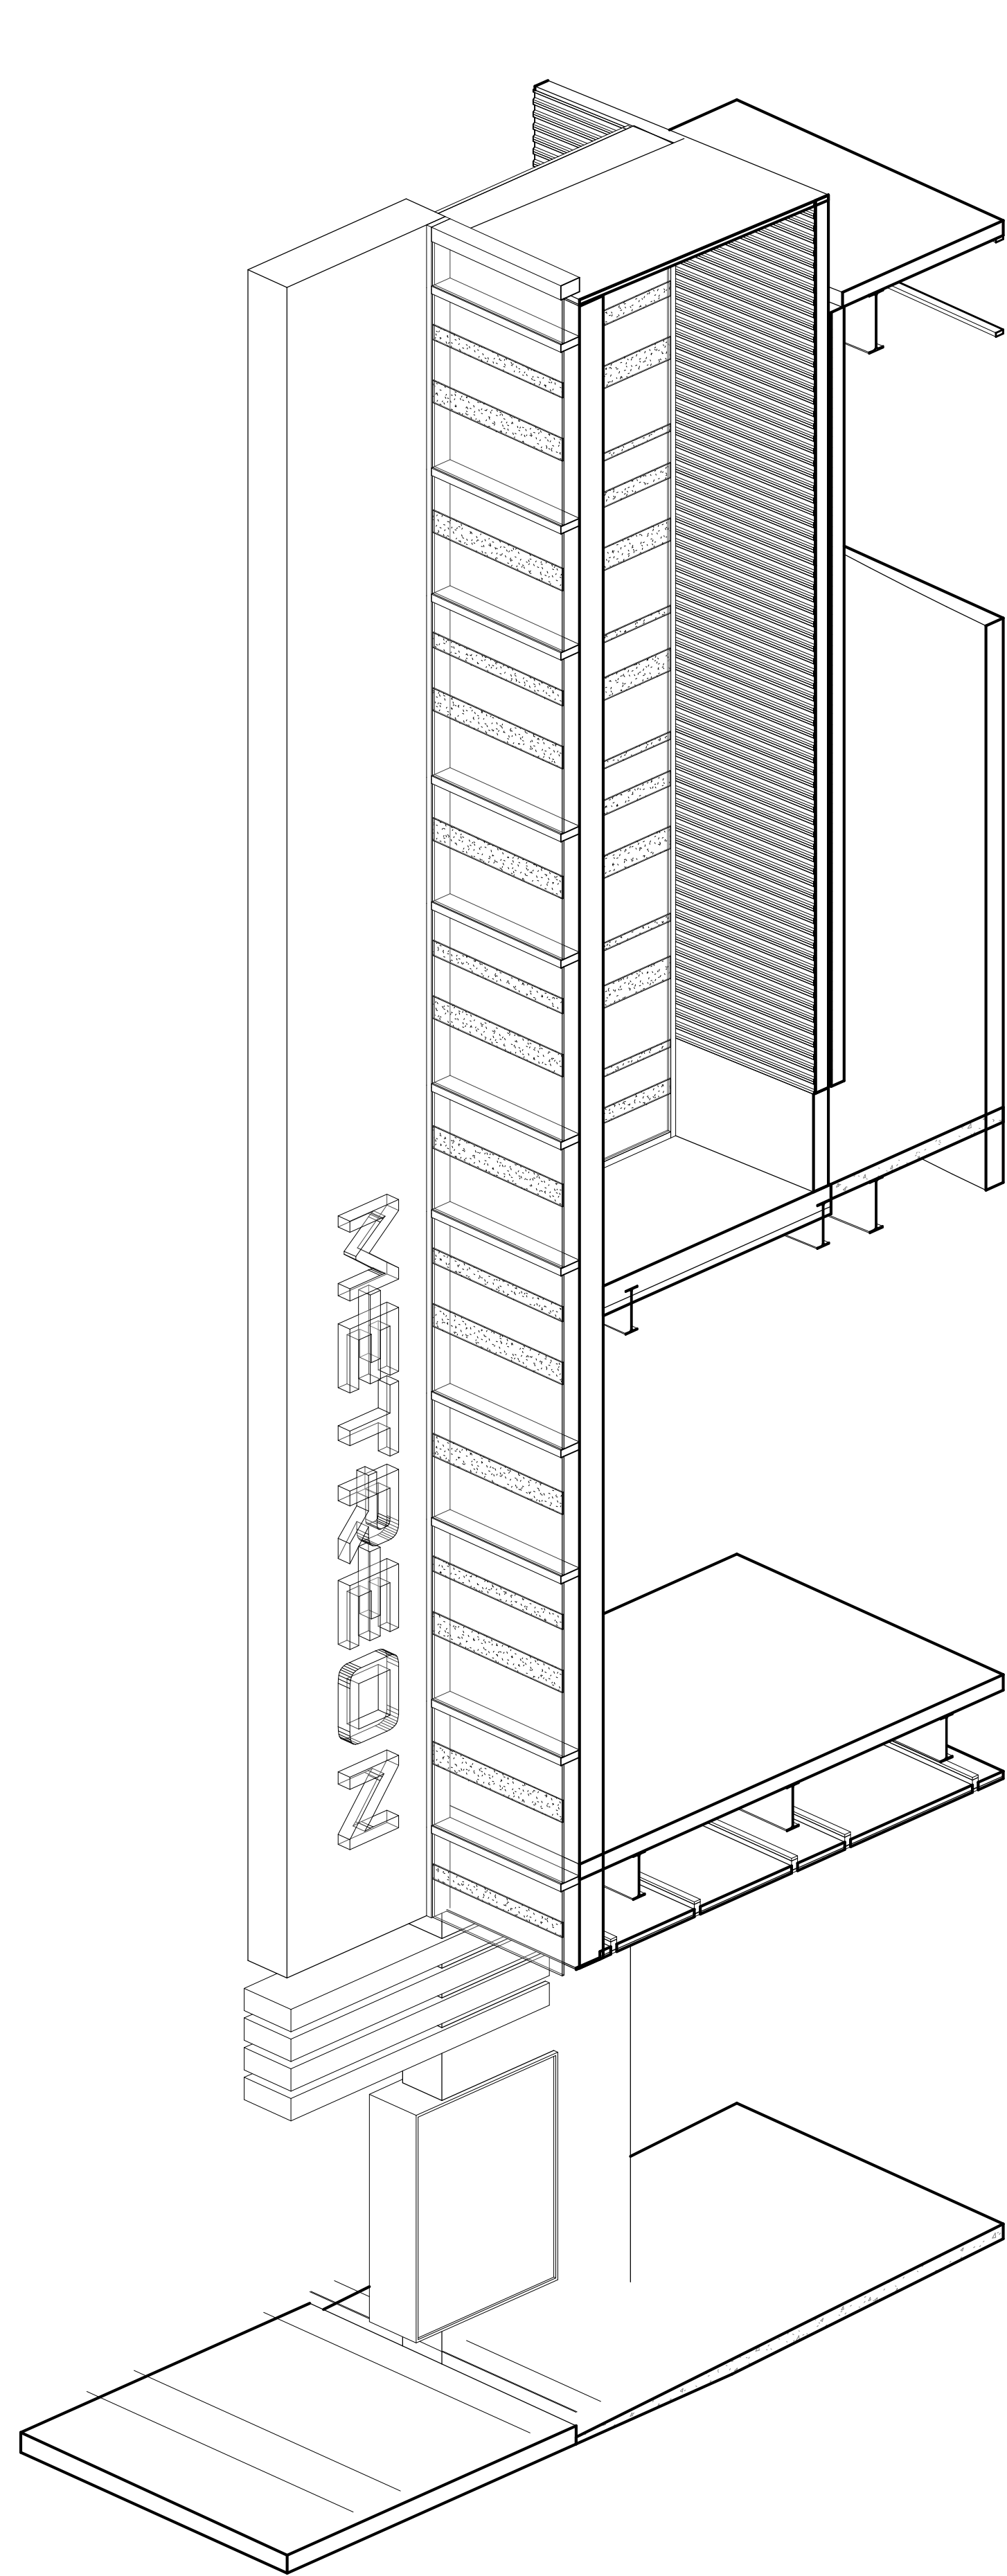

ENTRANCE BLADE - STRUCTURAL FRAMING

SCALE


7

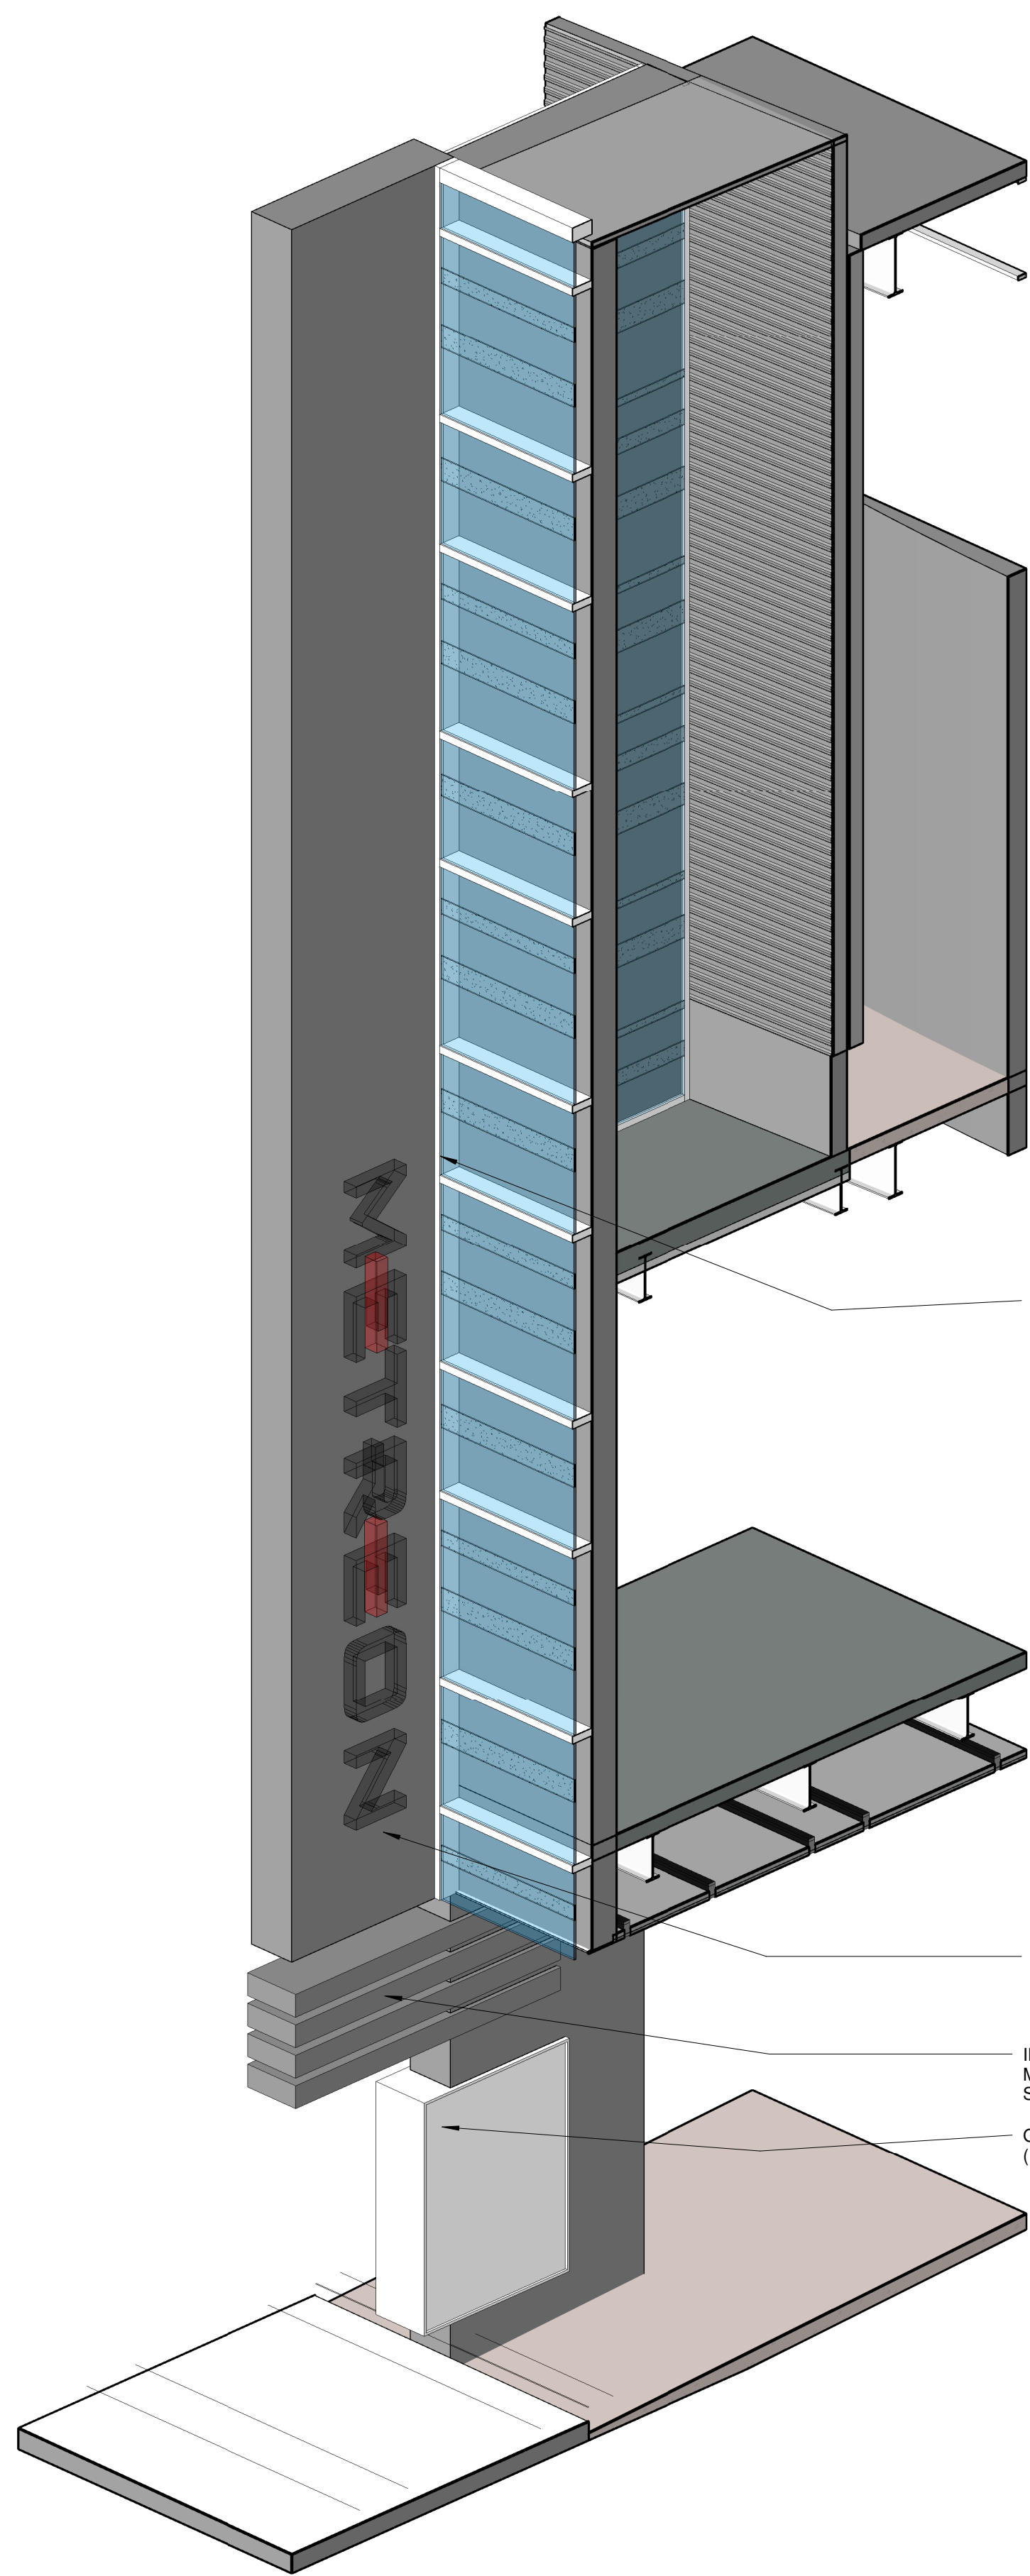

BLADE -3D VIEW

SCALE


6

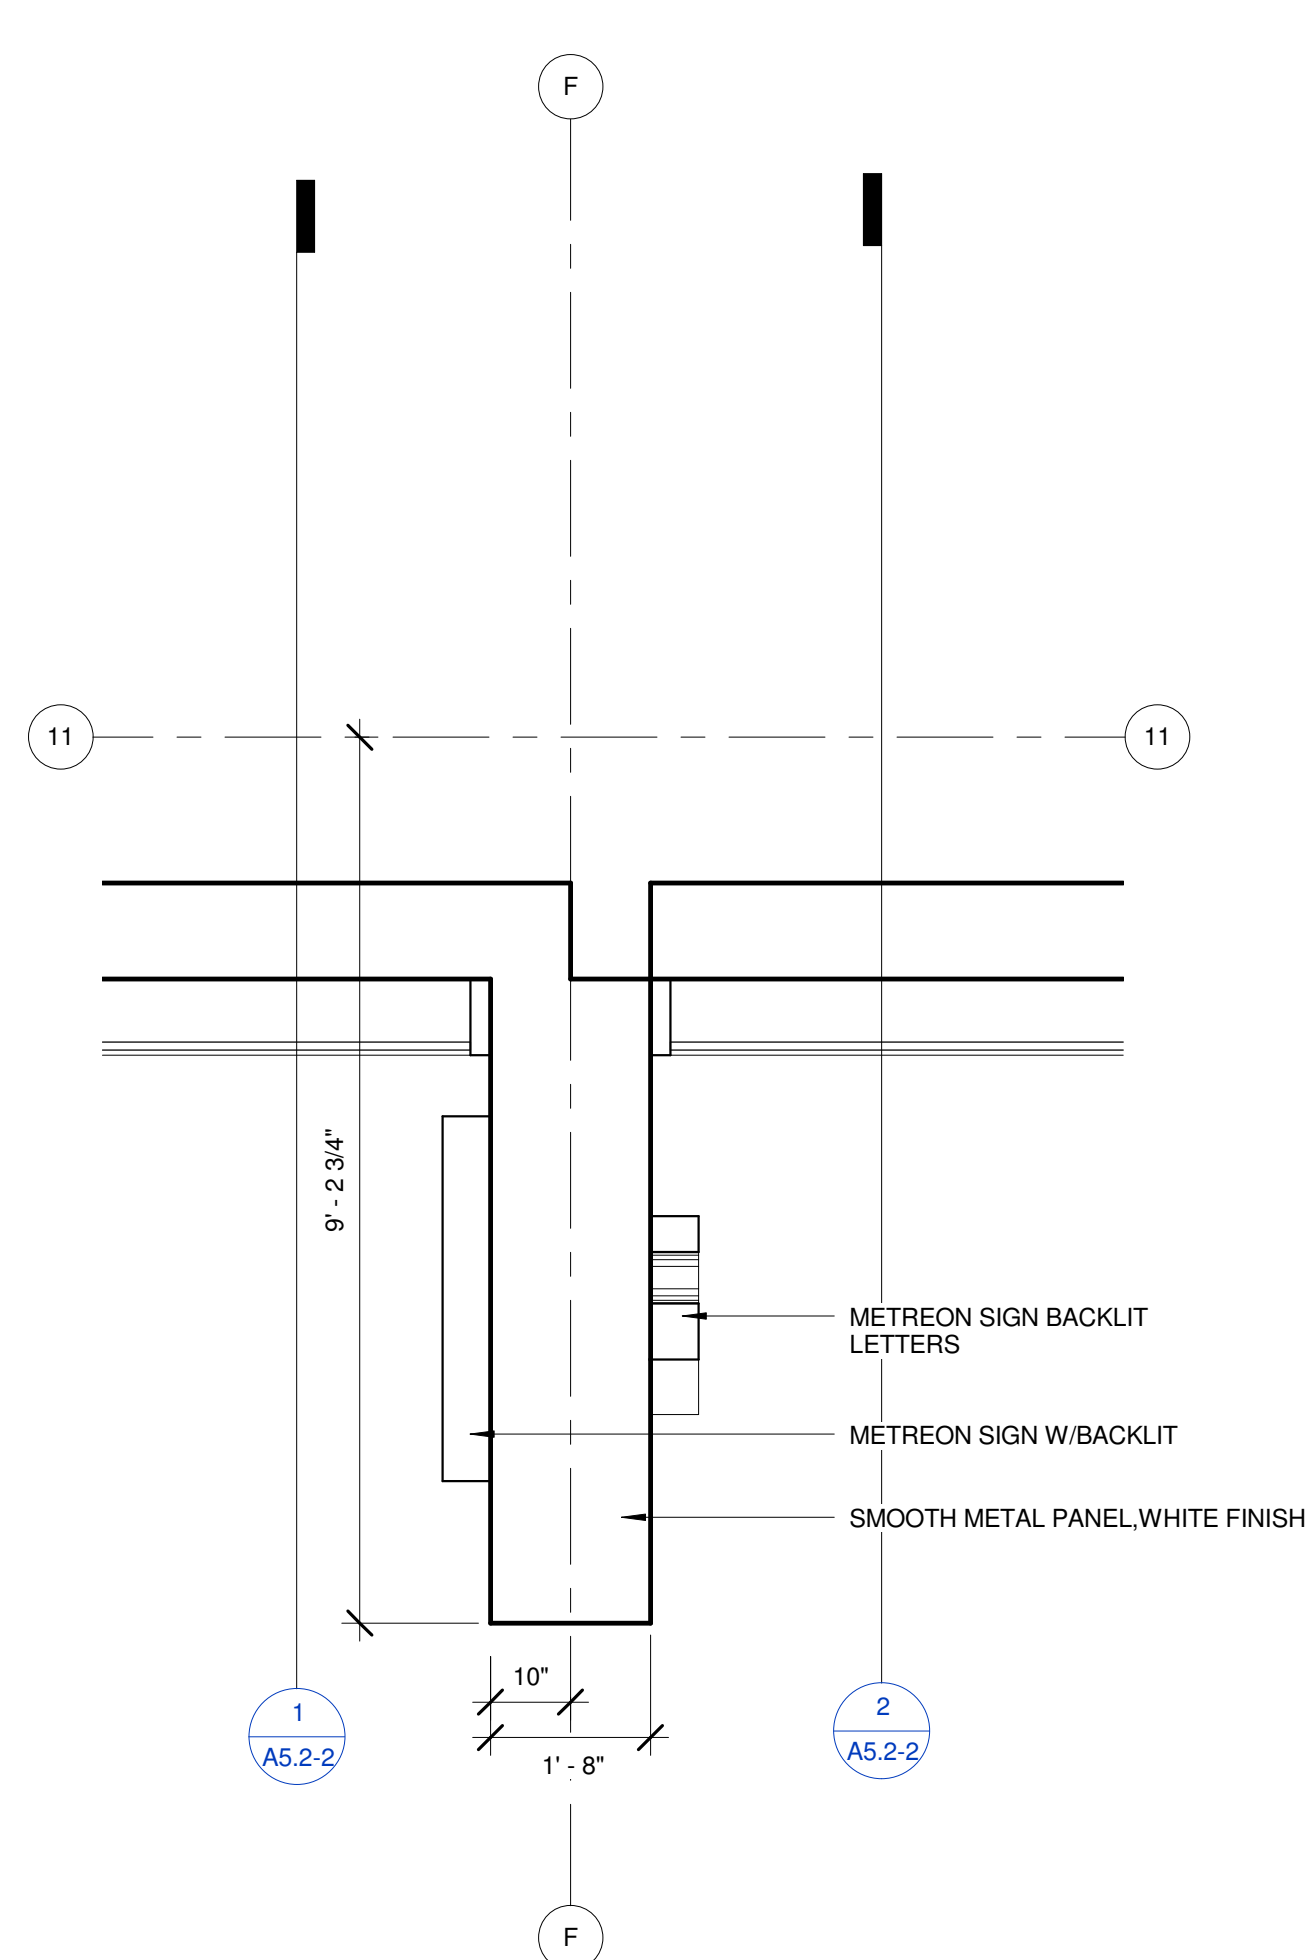

BLADE PLAN @ SECOND LEVEL

SCALE
1/2" = 1'-0"


5

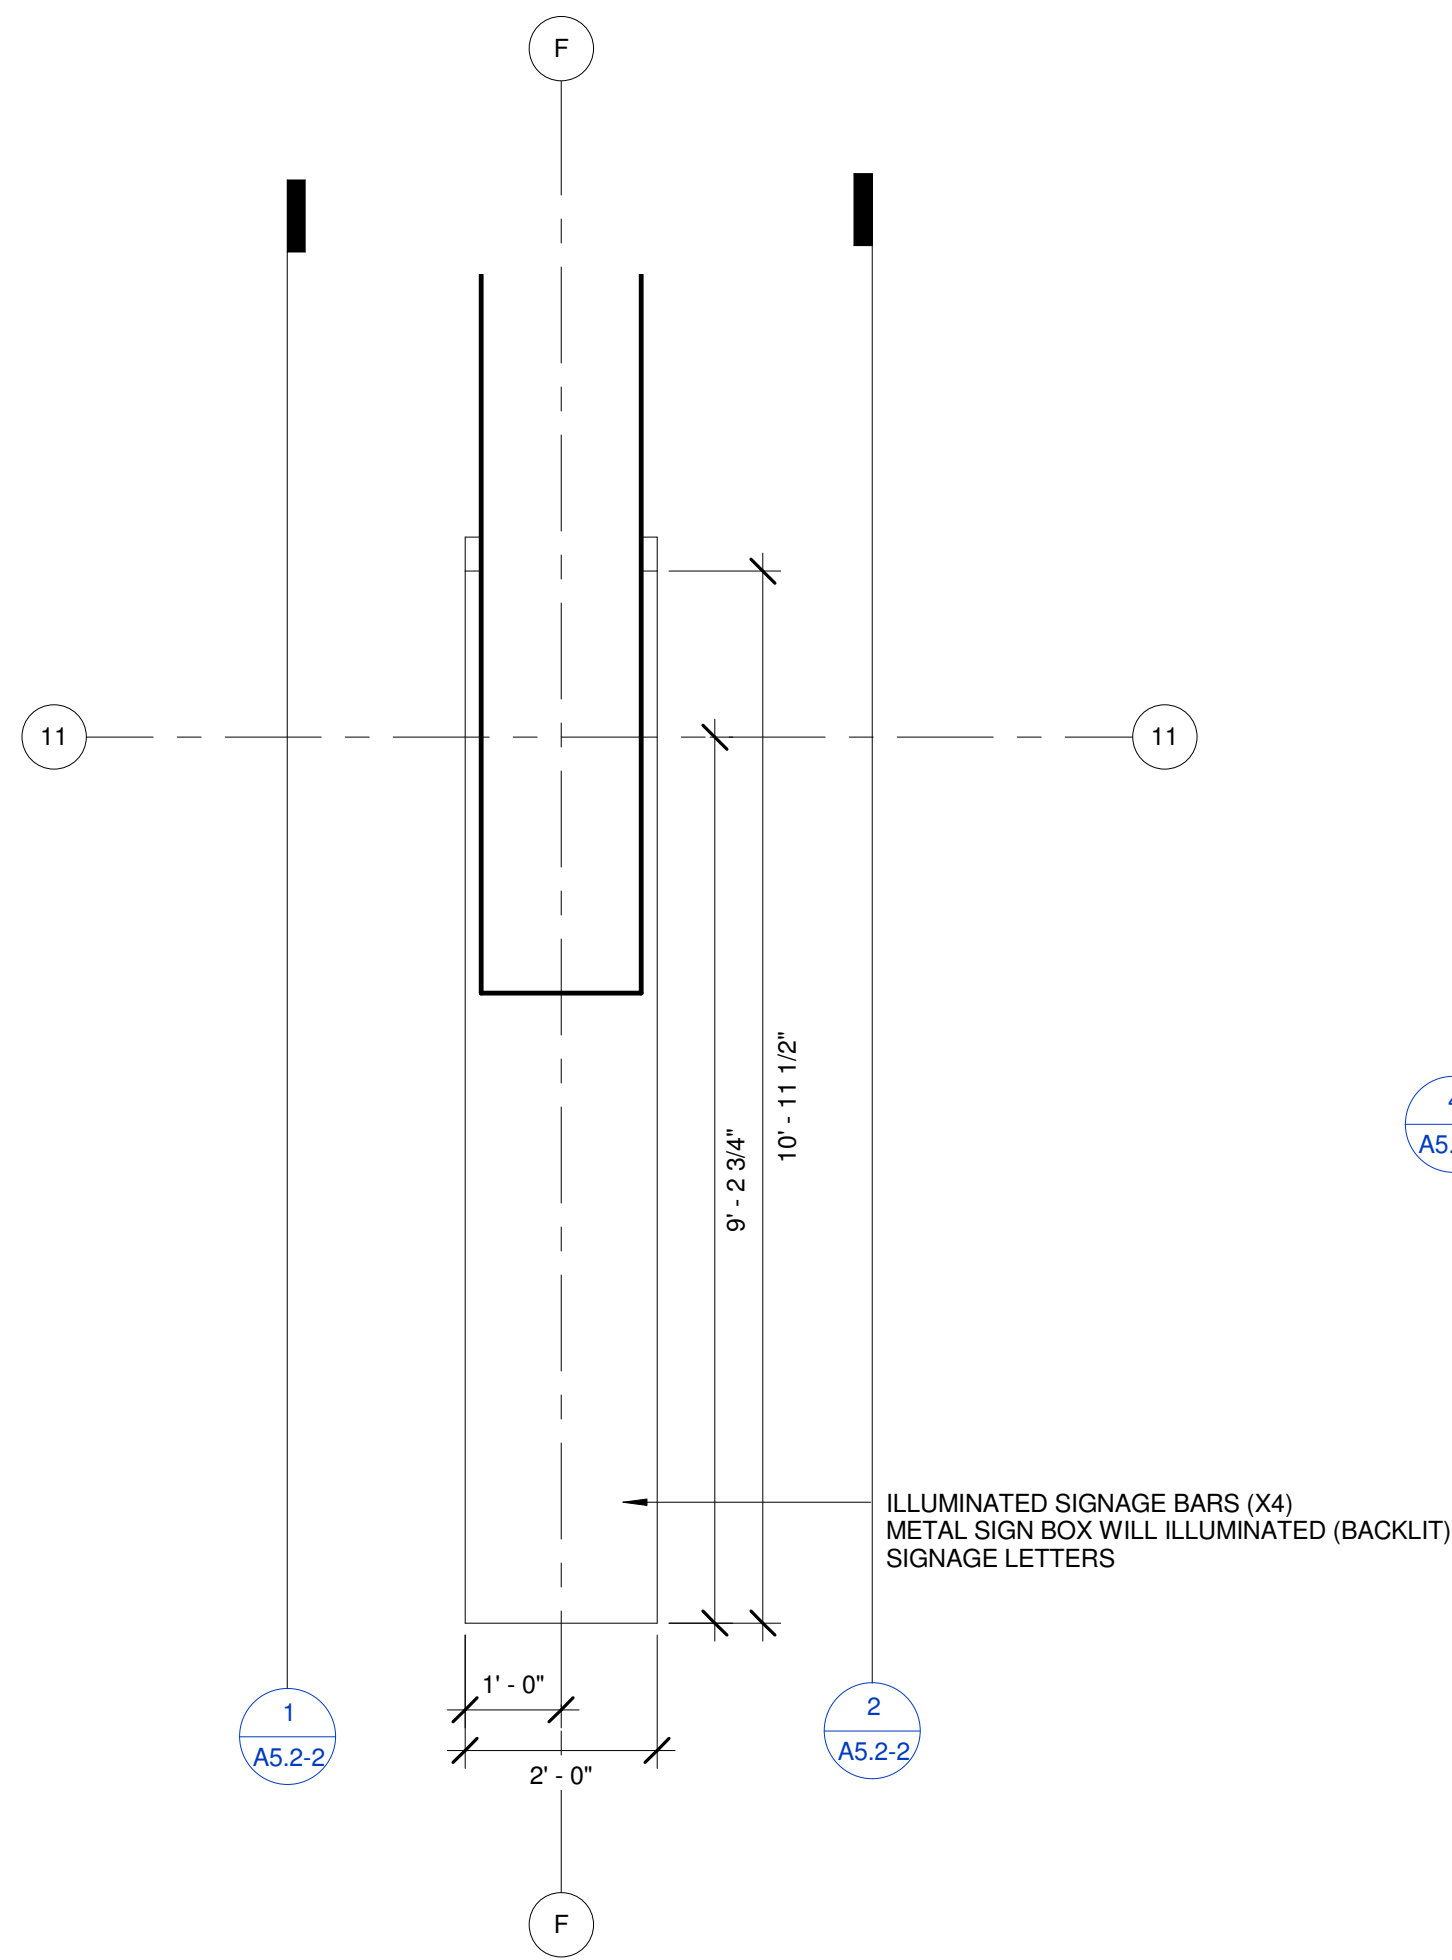

BLADE PLAN @ LIGHT BOX

SCALE
1/2" = 1'-0"


3

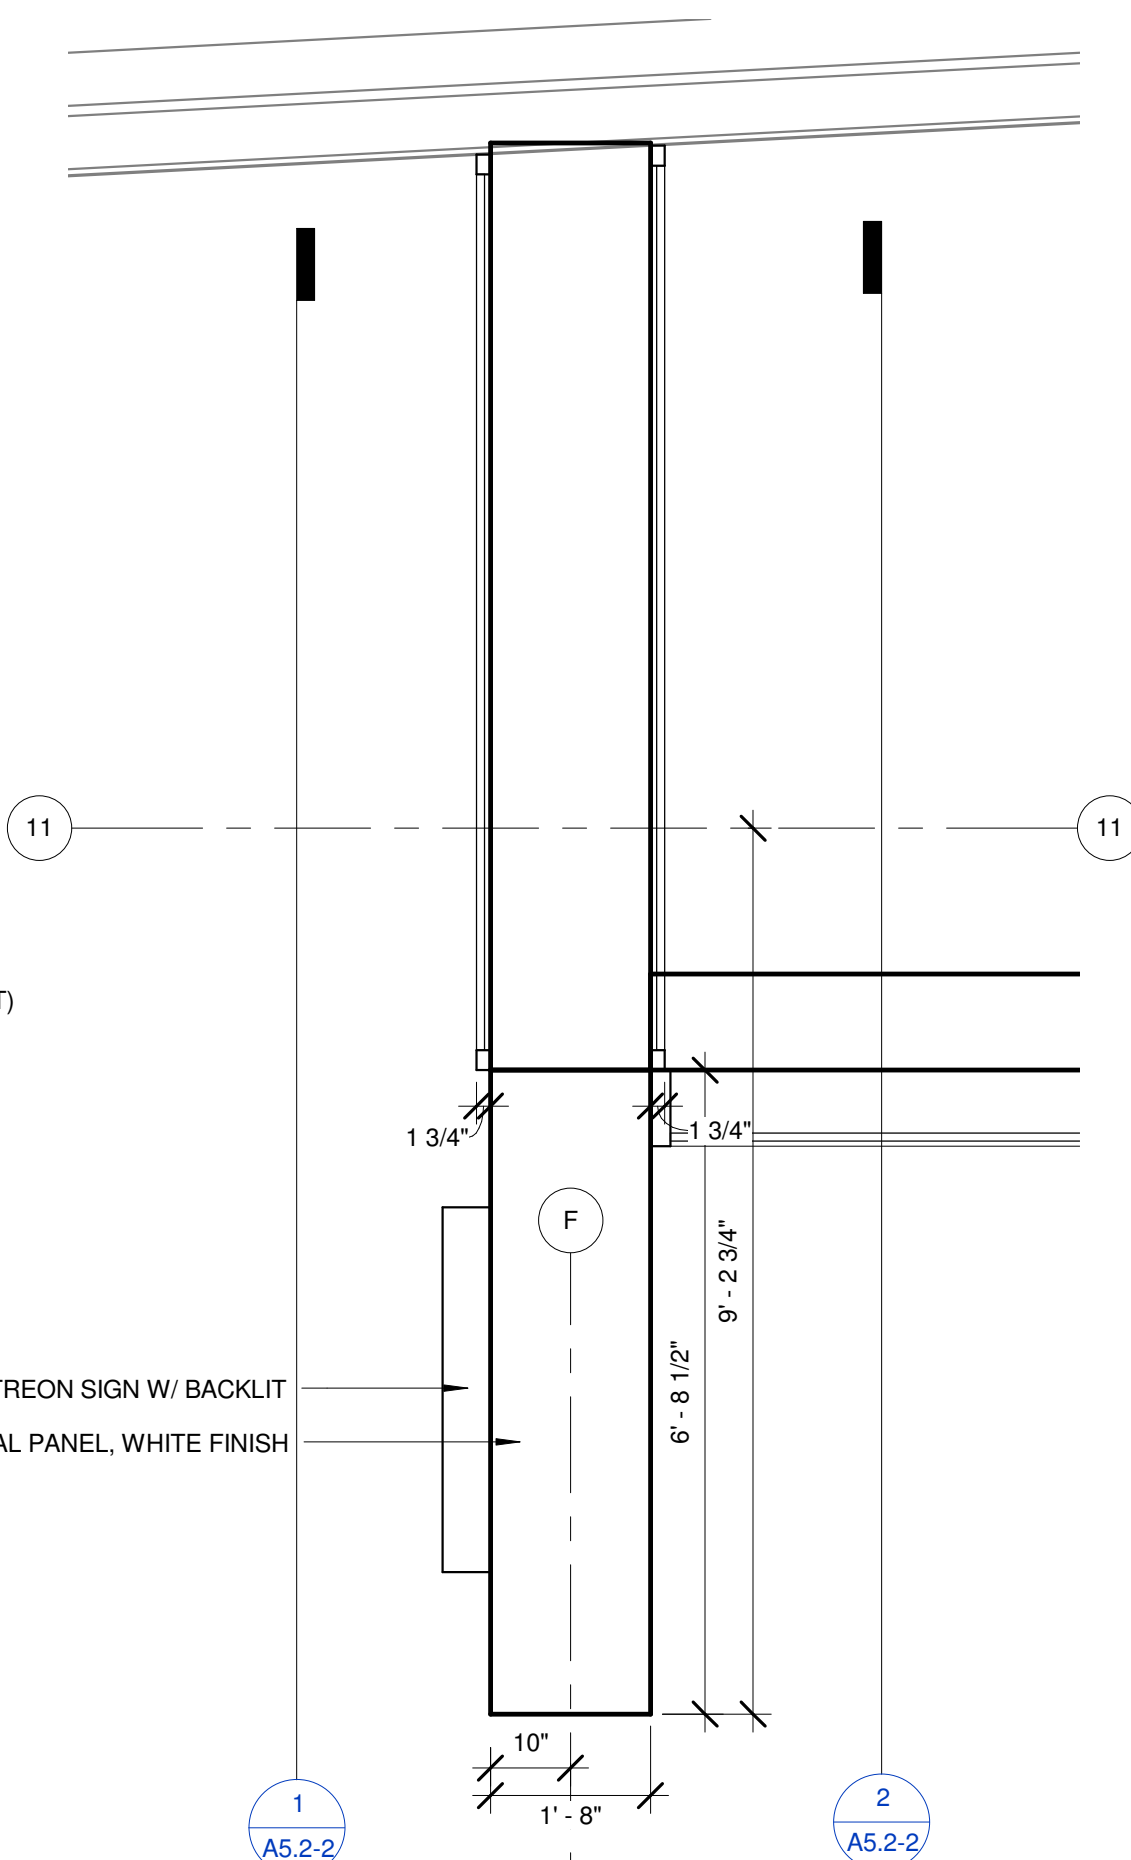

BLADE PLAN @ THIRD FLOOR

SCALE
1/2" = 1'-0"


4

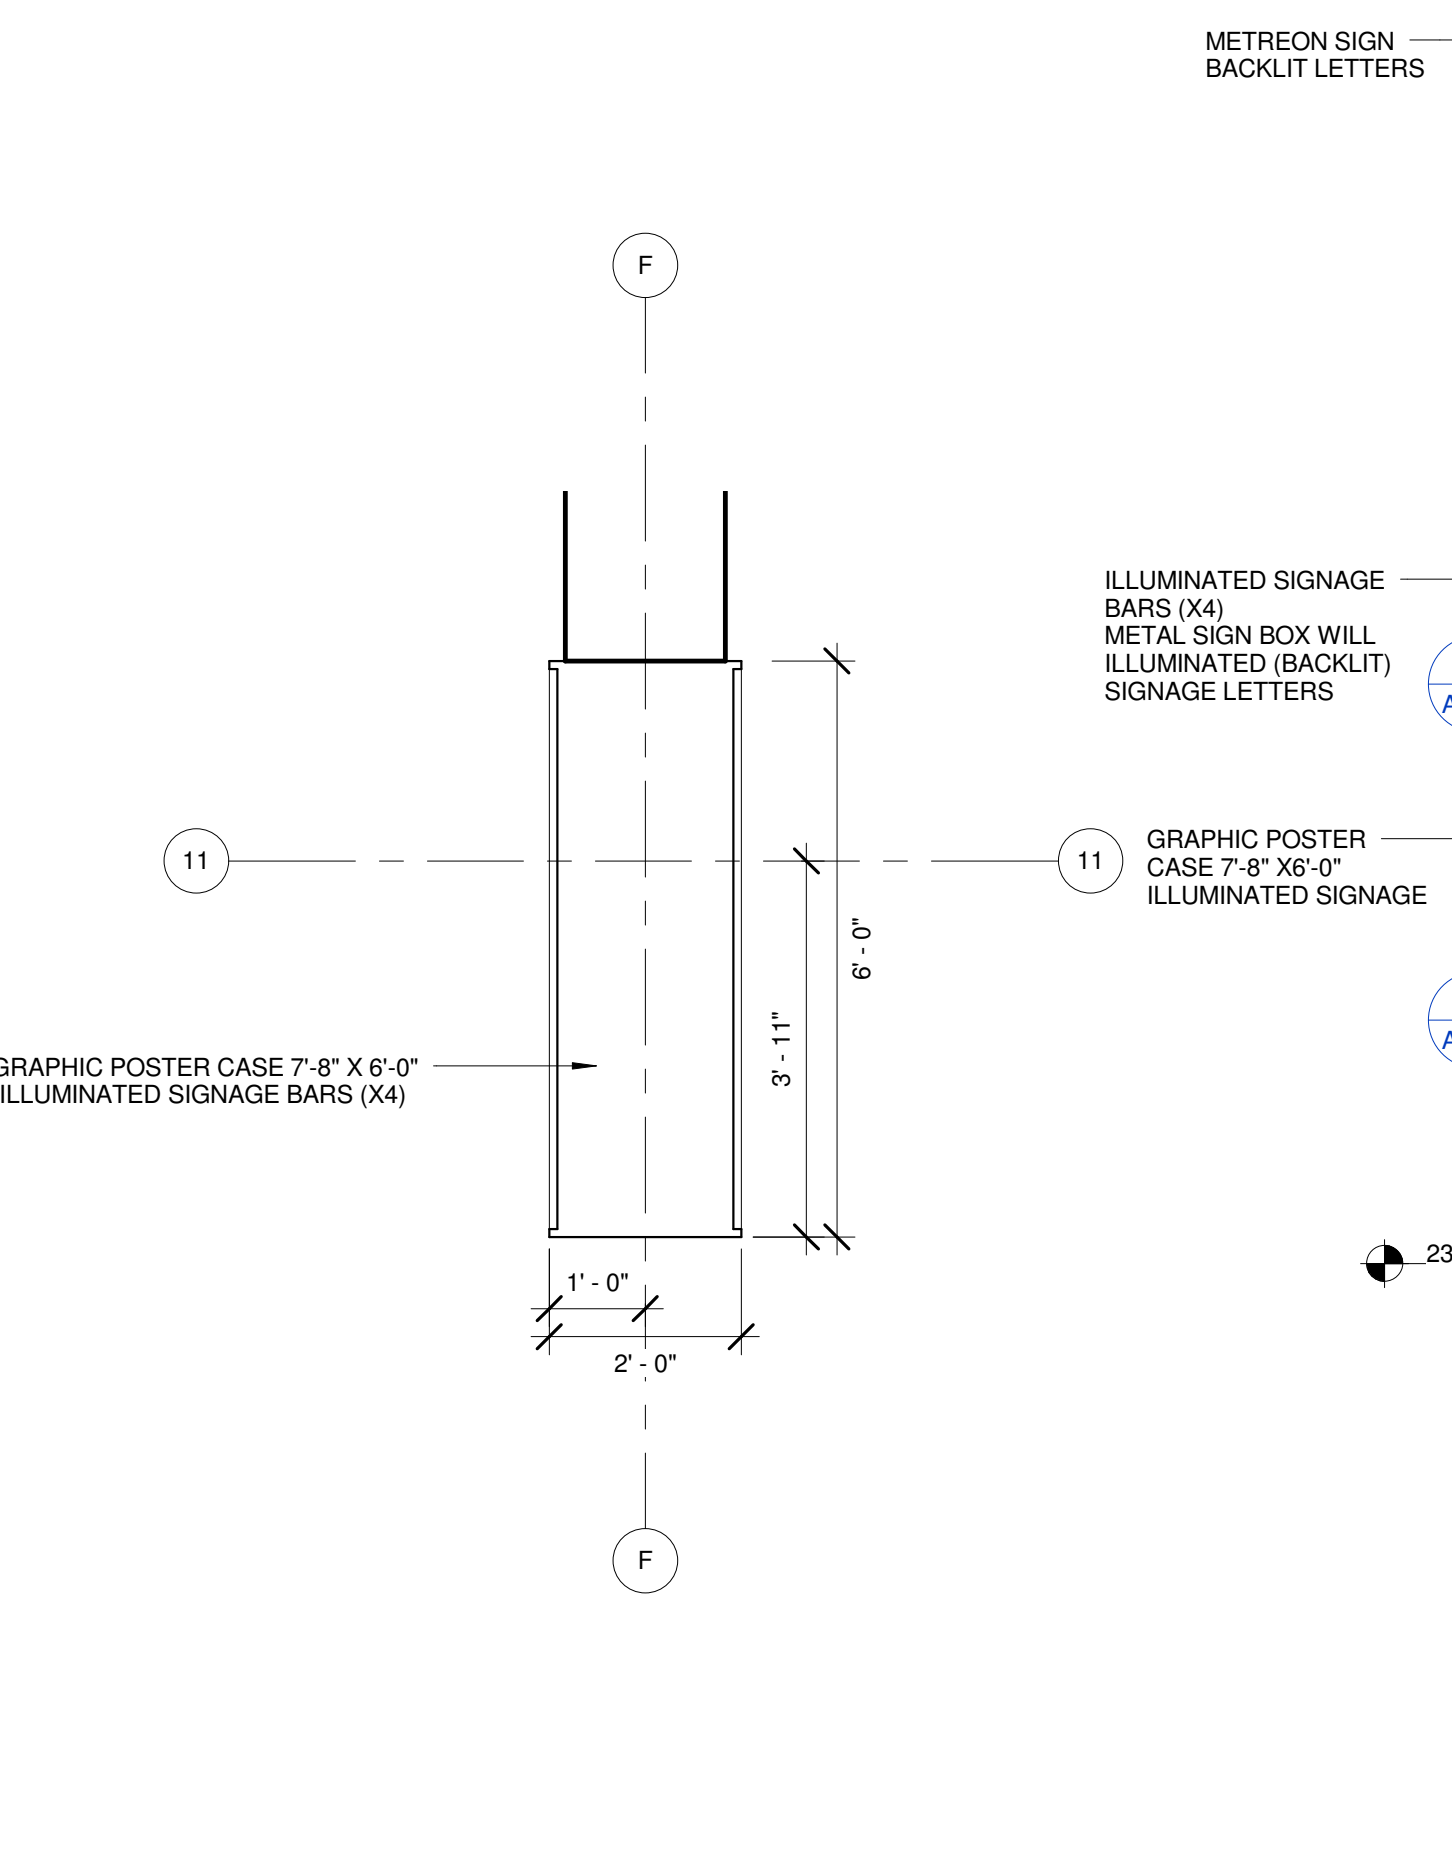

BLADE PLAN @ GROUND FLOOR

SCALE
1/2" = 1'-0"

2

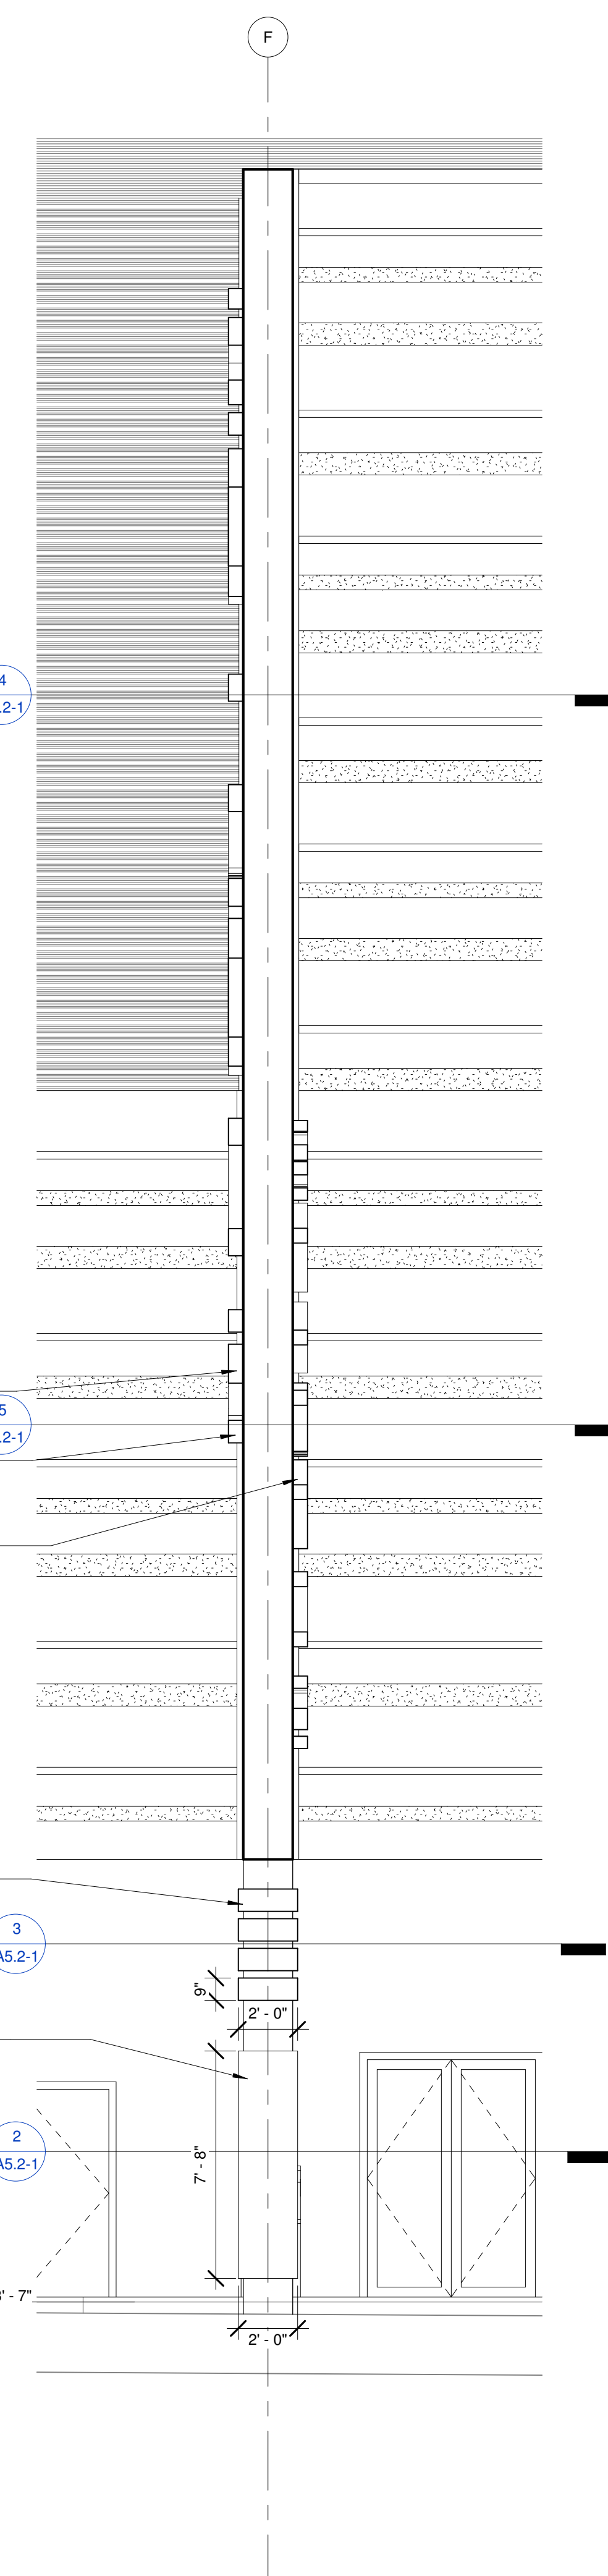

BLADE ELEVATION


SCALE
1/4" = 1'-0"

1

Consultants:

Registration No.







Key Plan

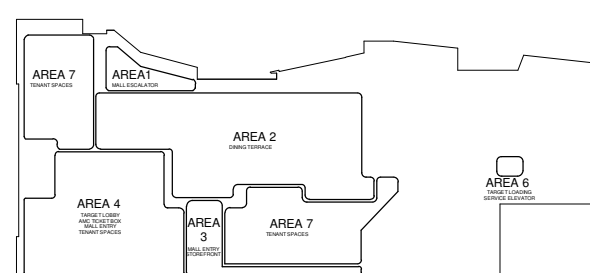


Sheet Title
**MAIN ENTRY BLADE
SIGN PLANS,
SECTIONS AND
PERSPECTIVE**

Job No. Date Scale
1295 SEPT 01, 2010. As indicated

A5.2-1

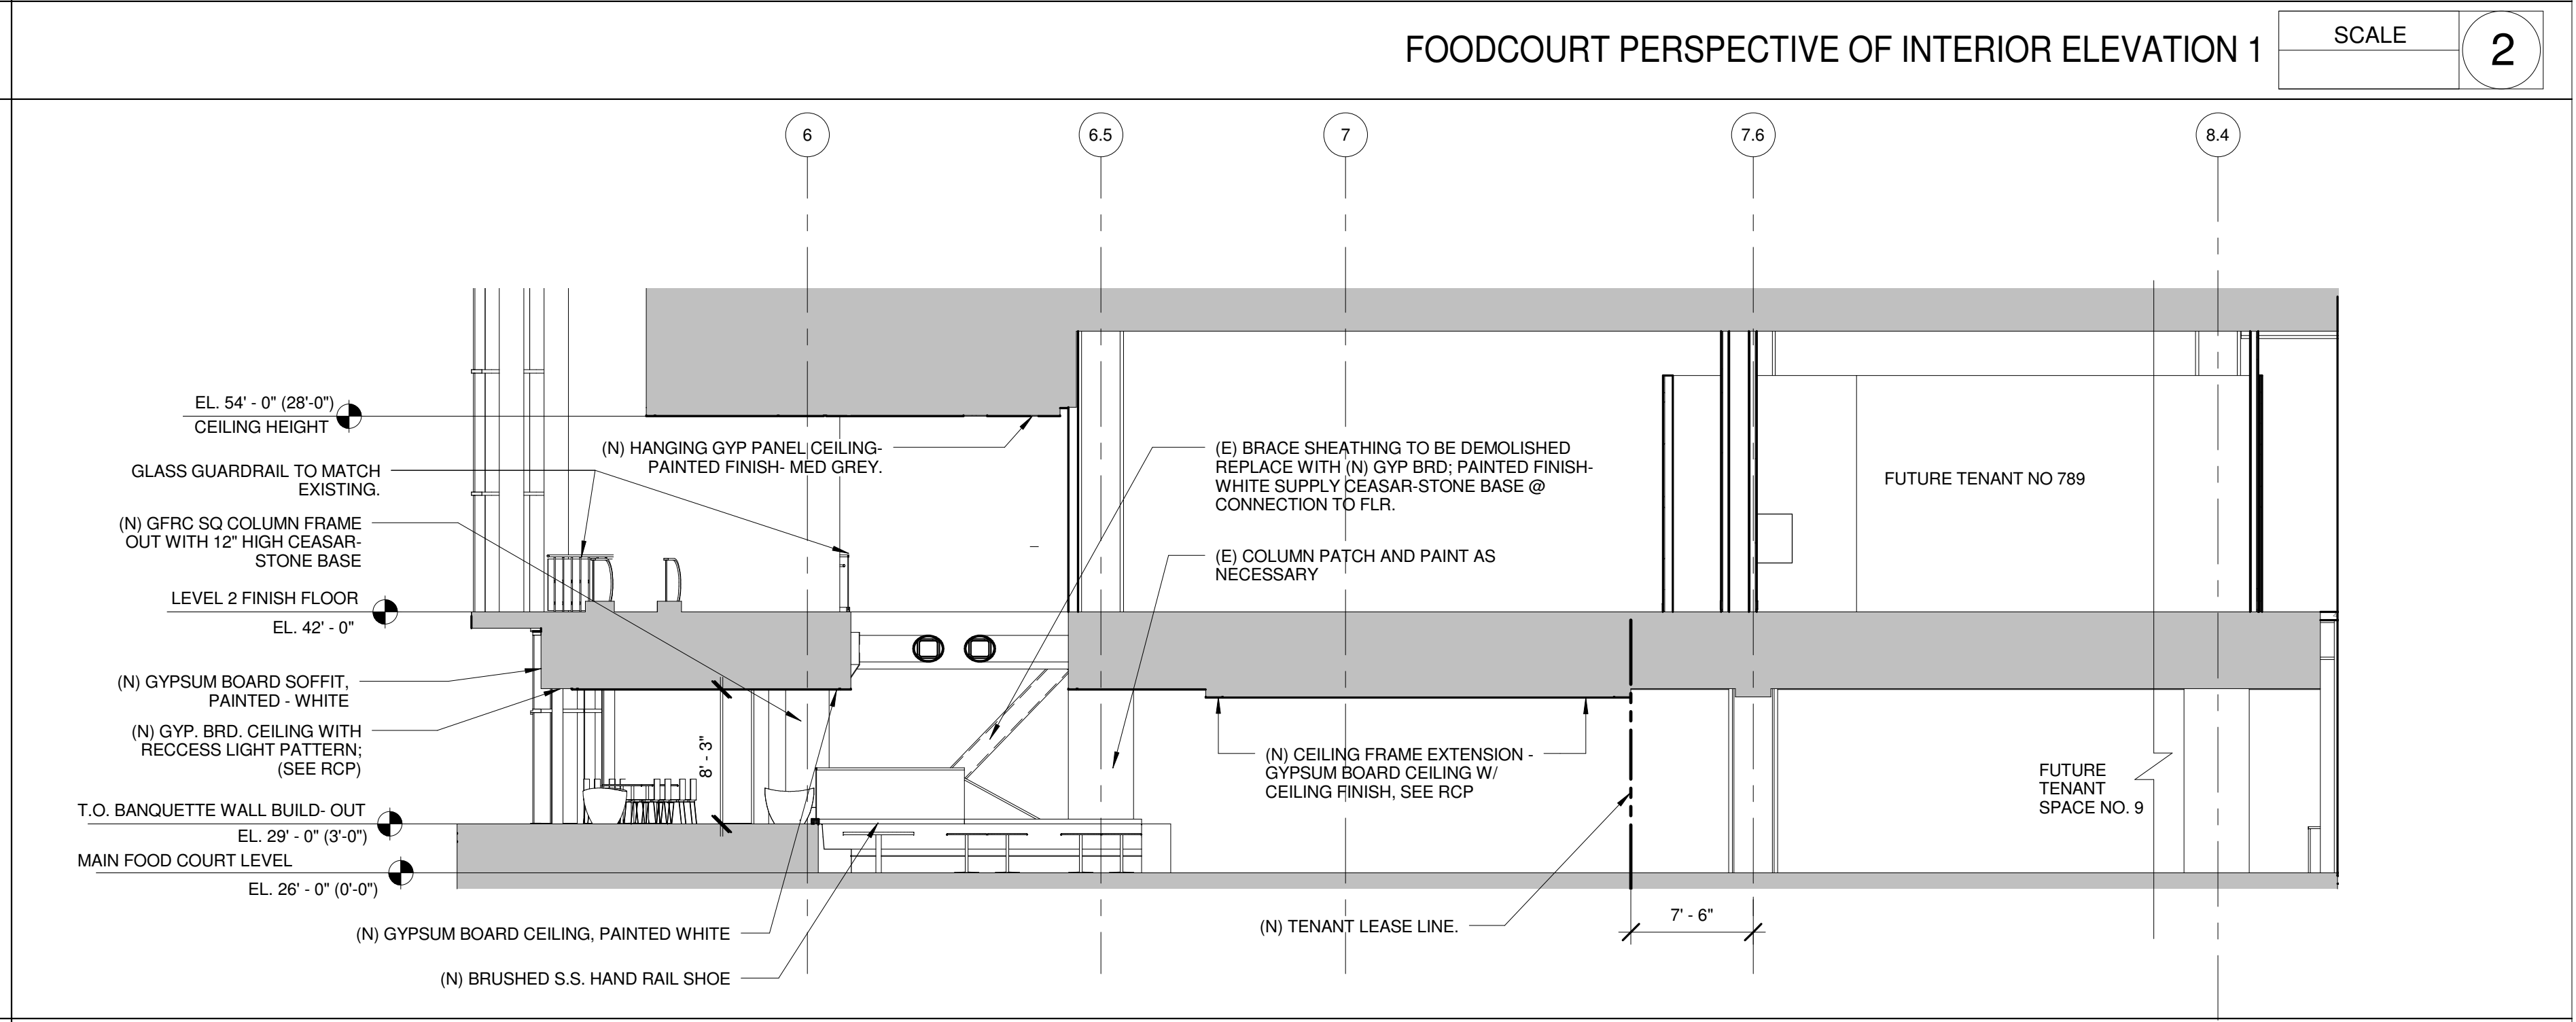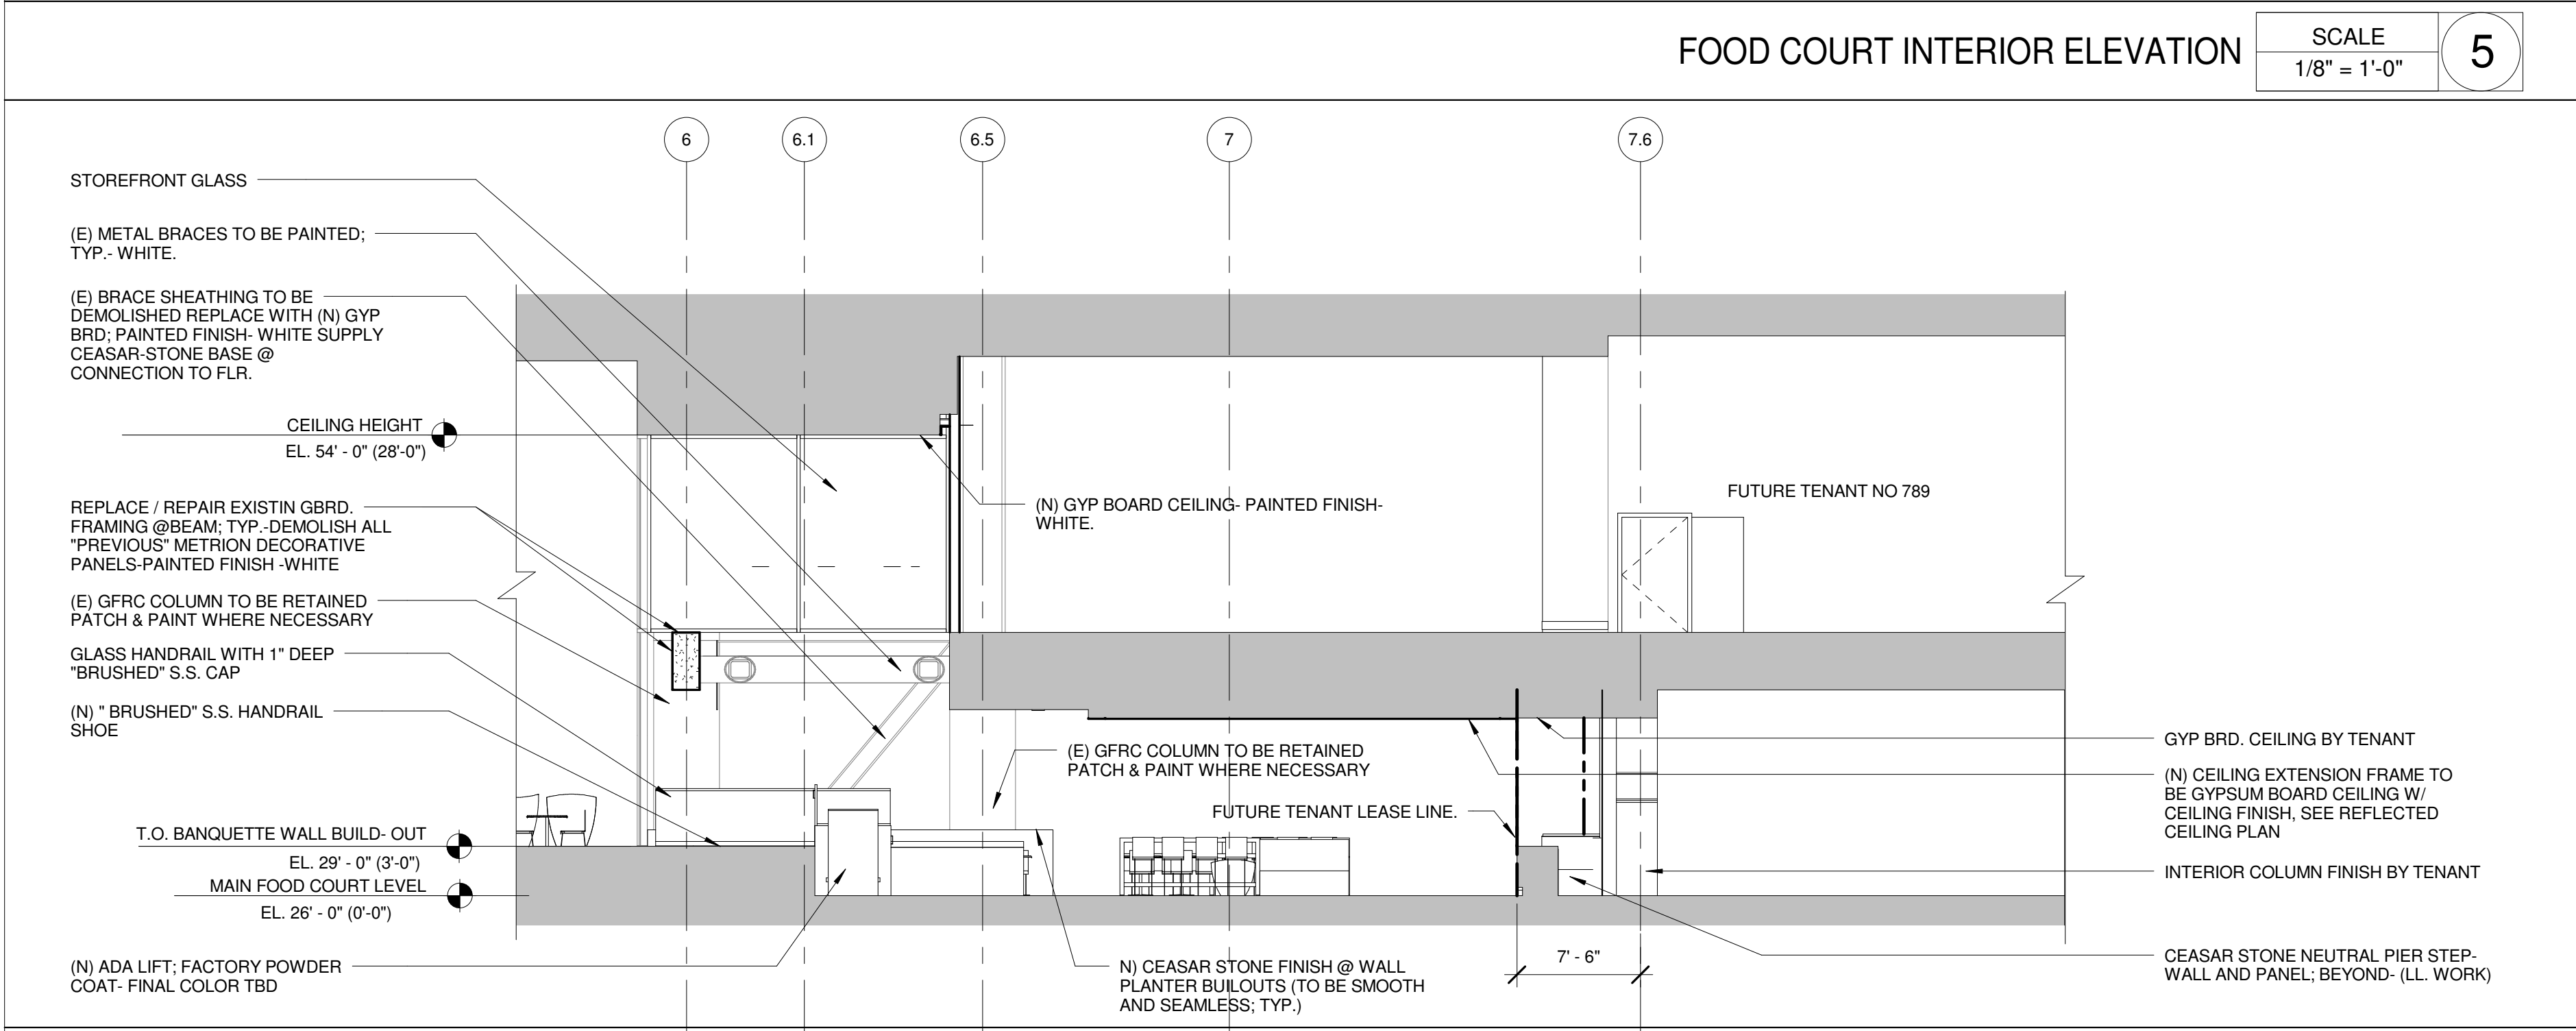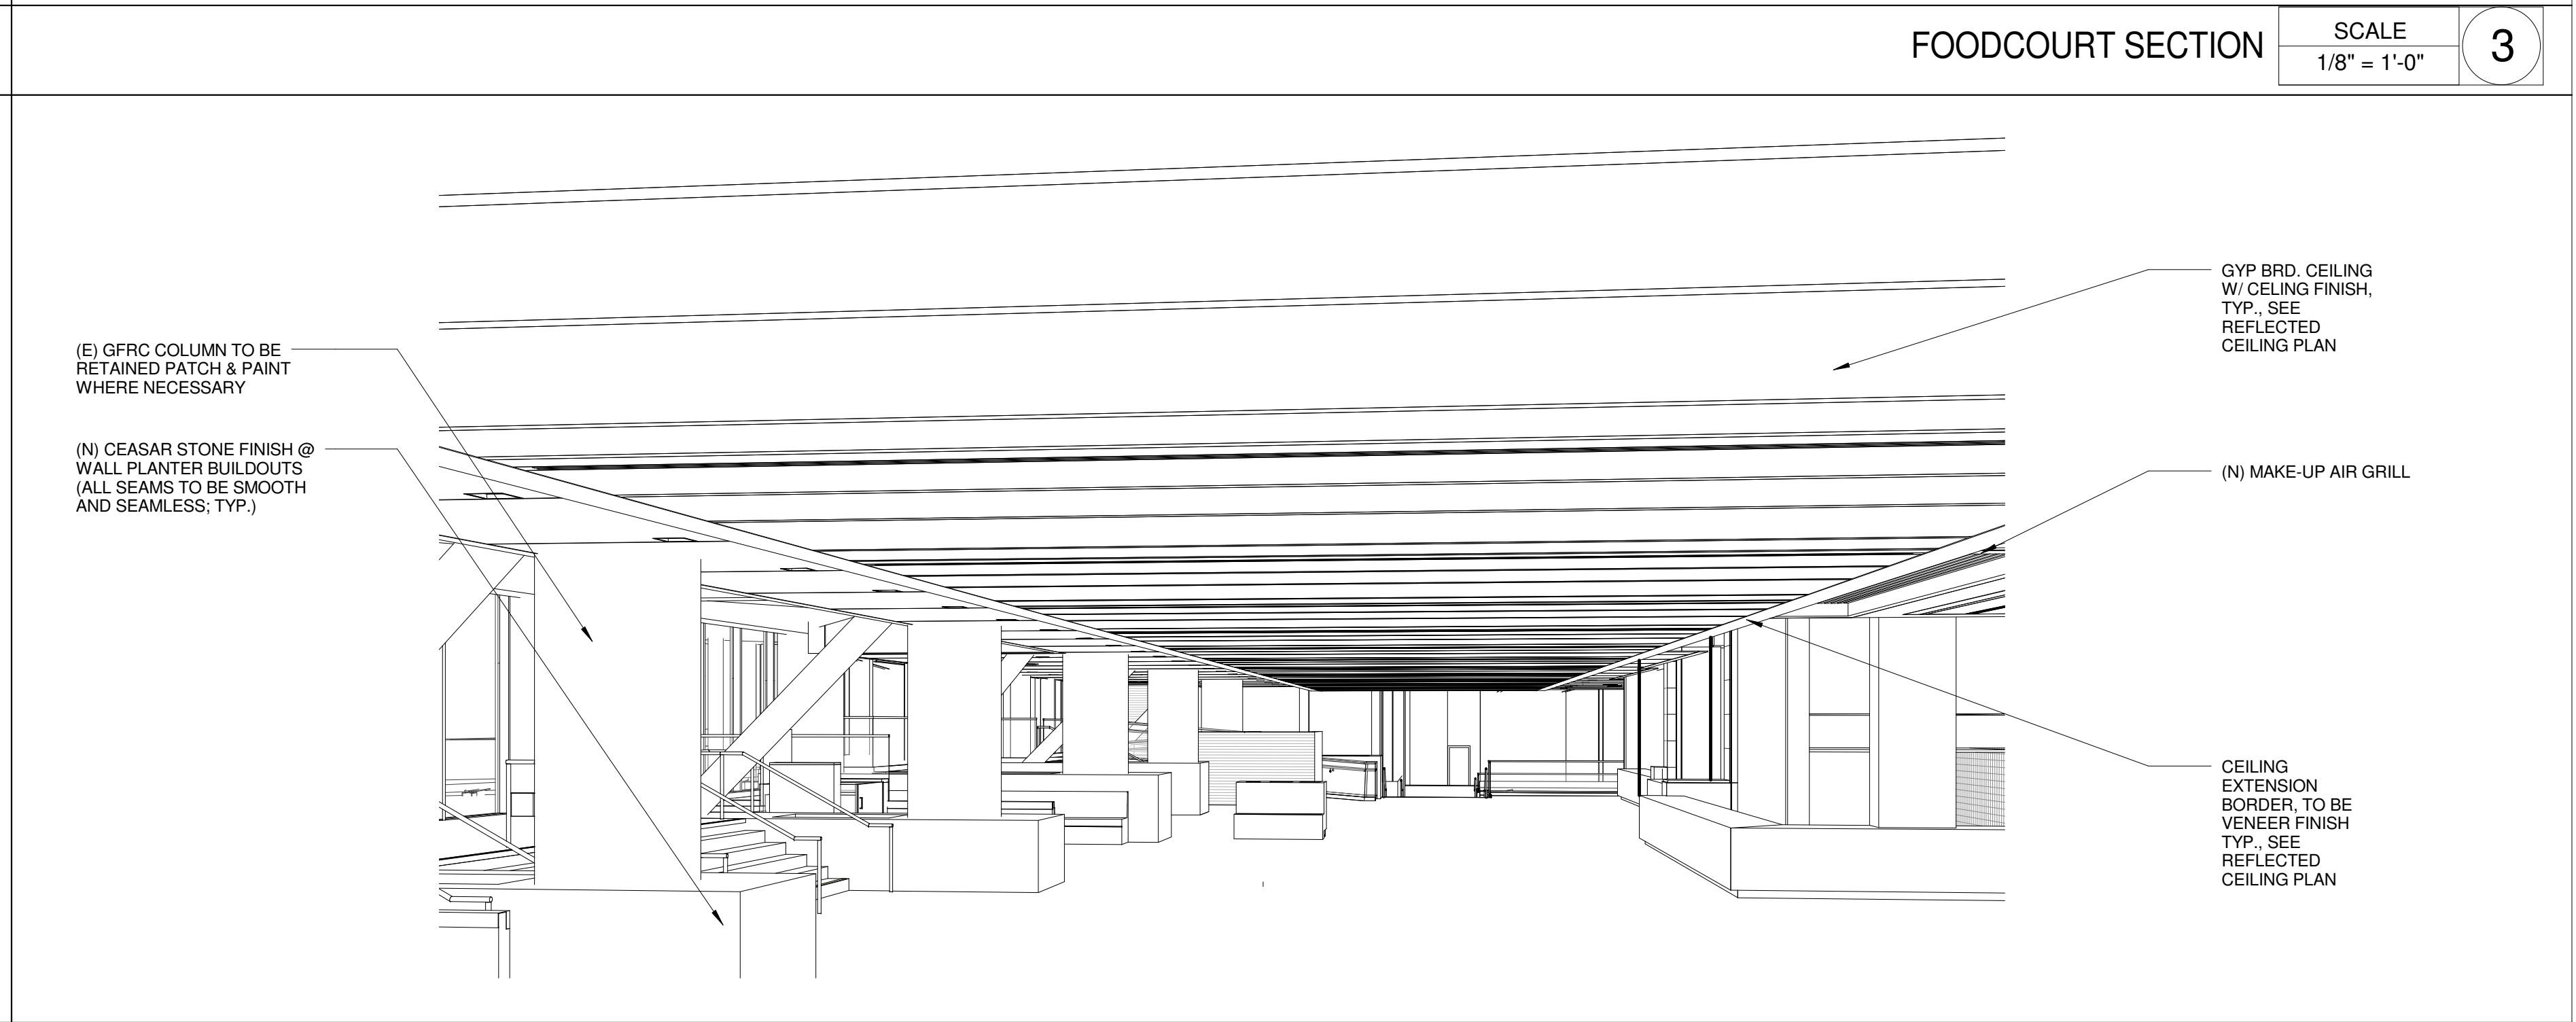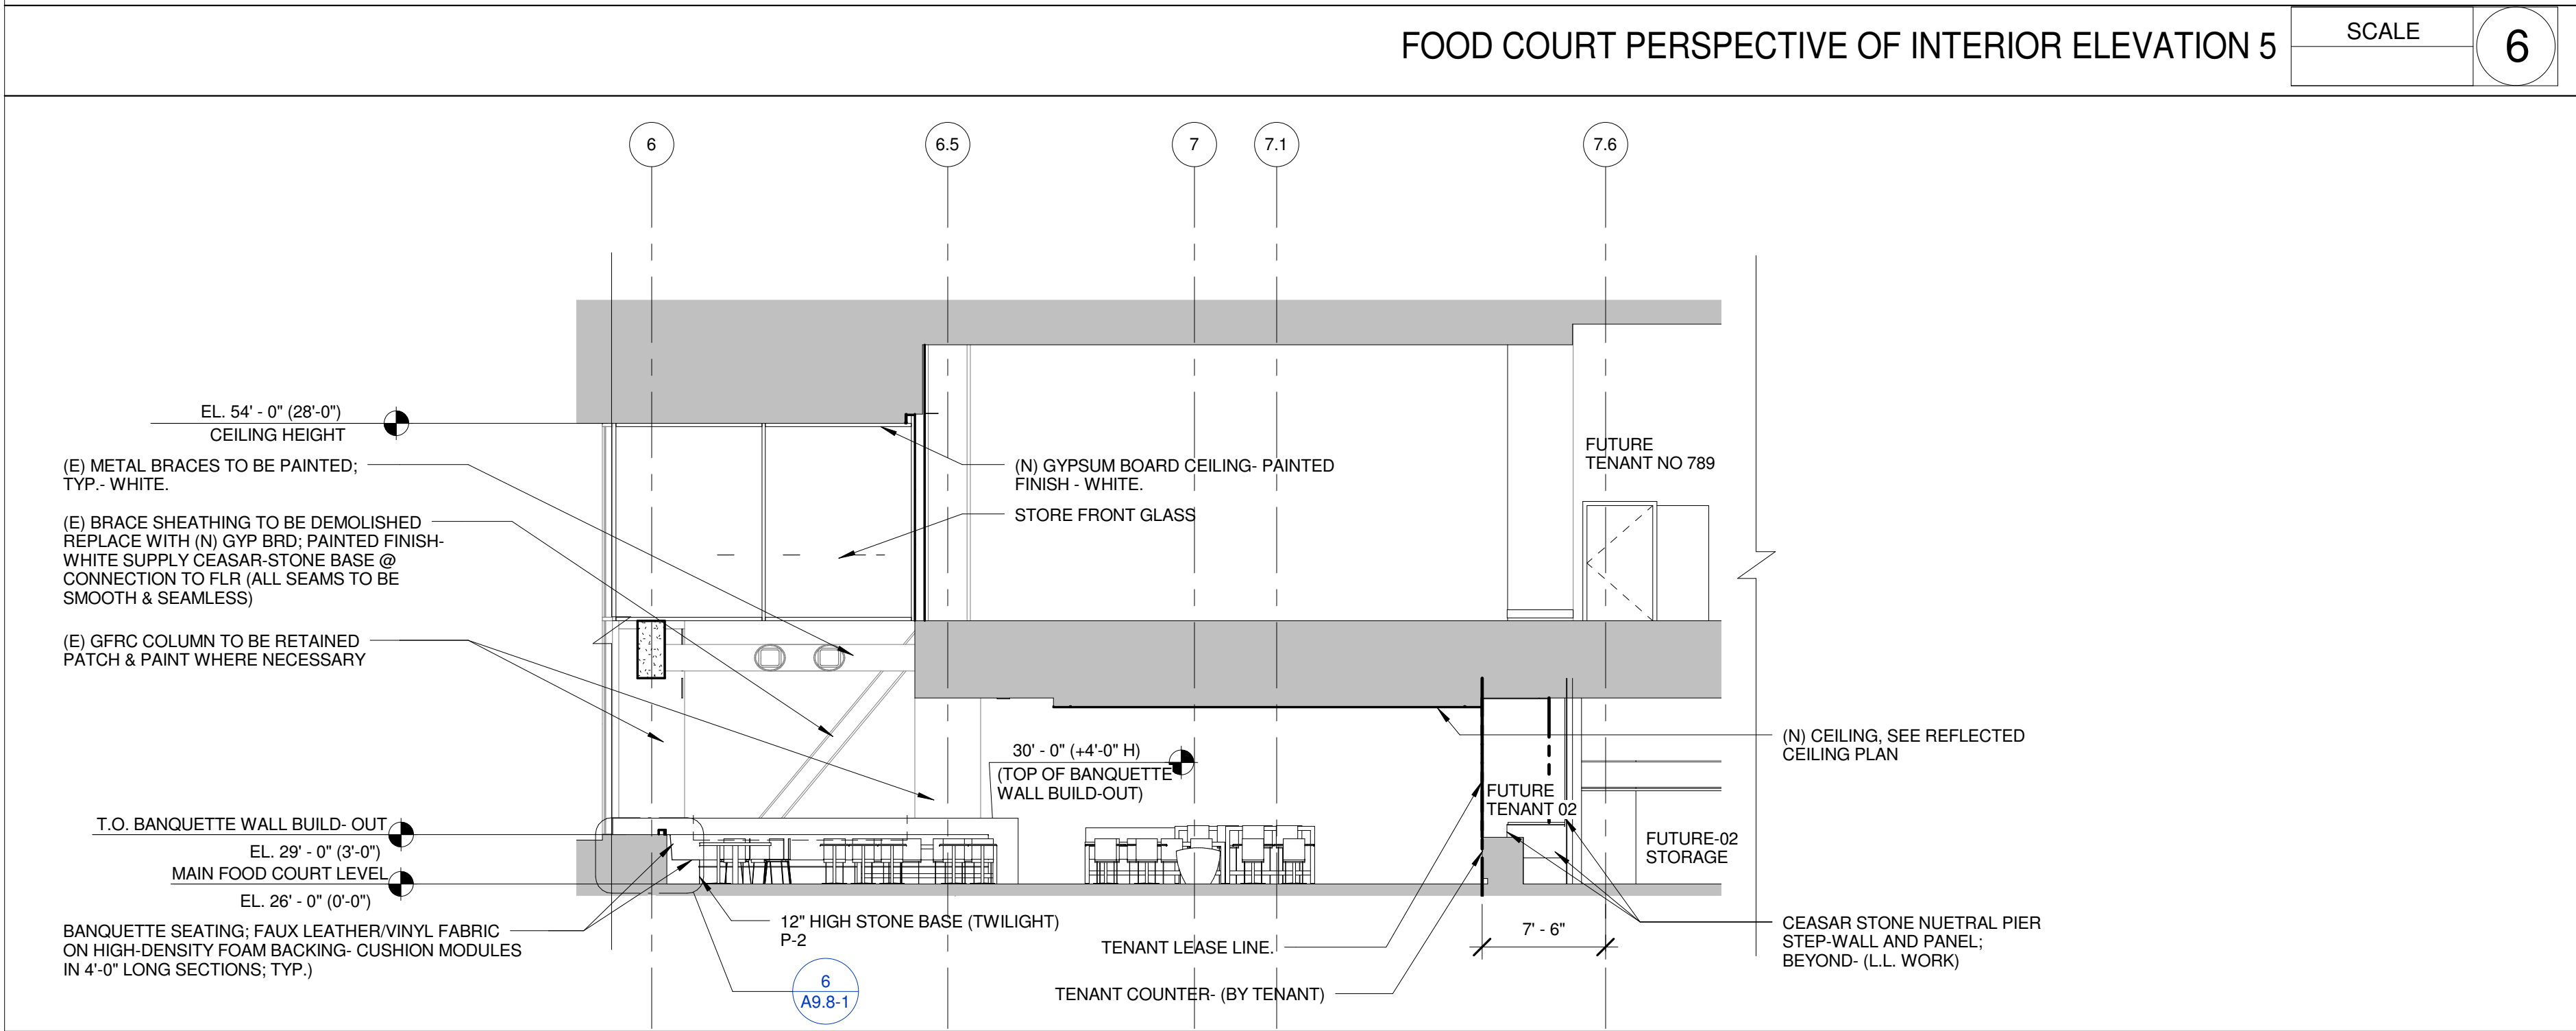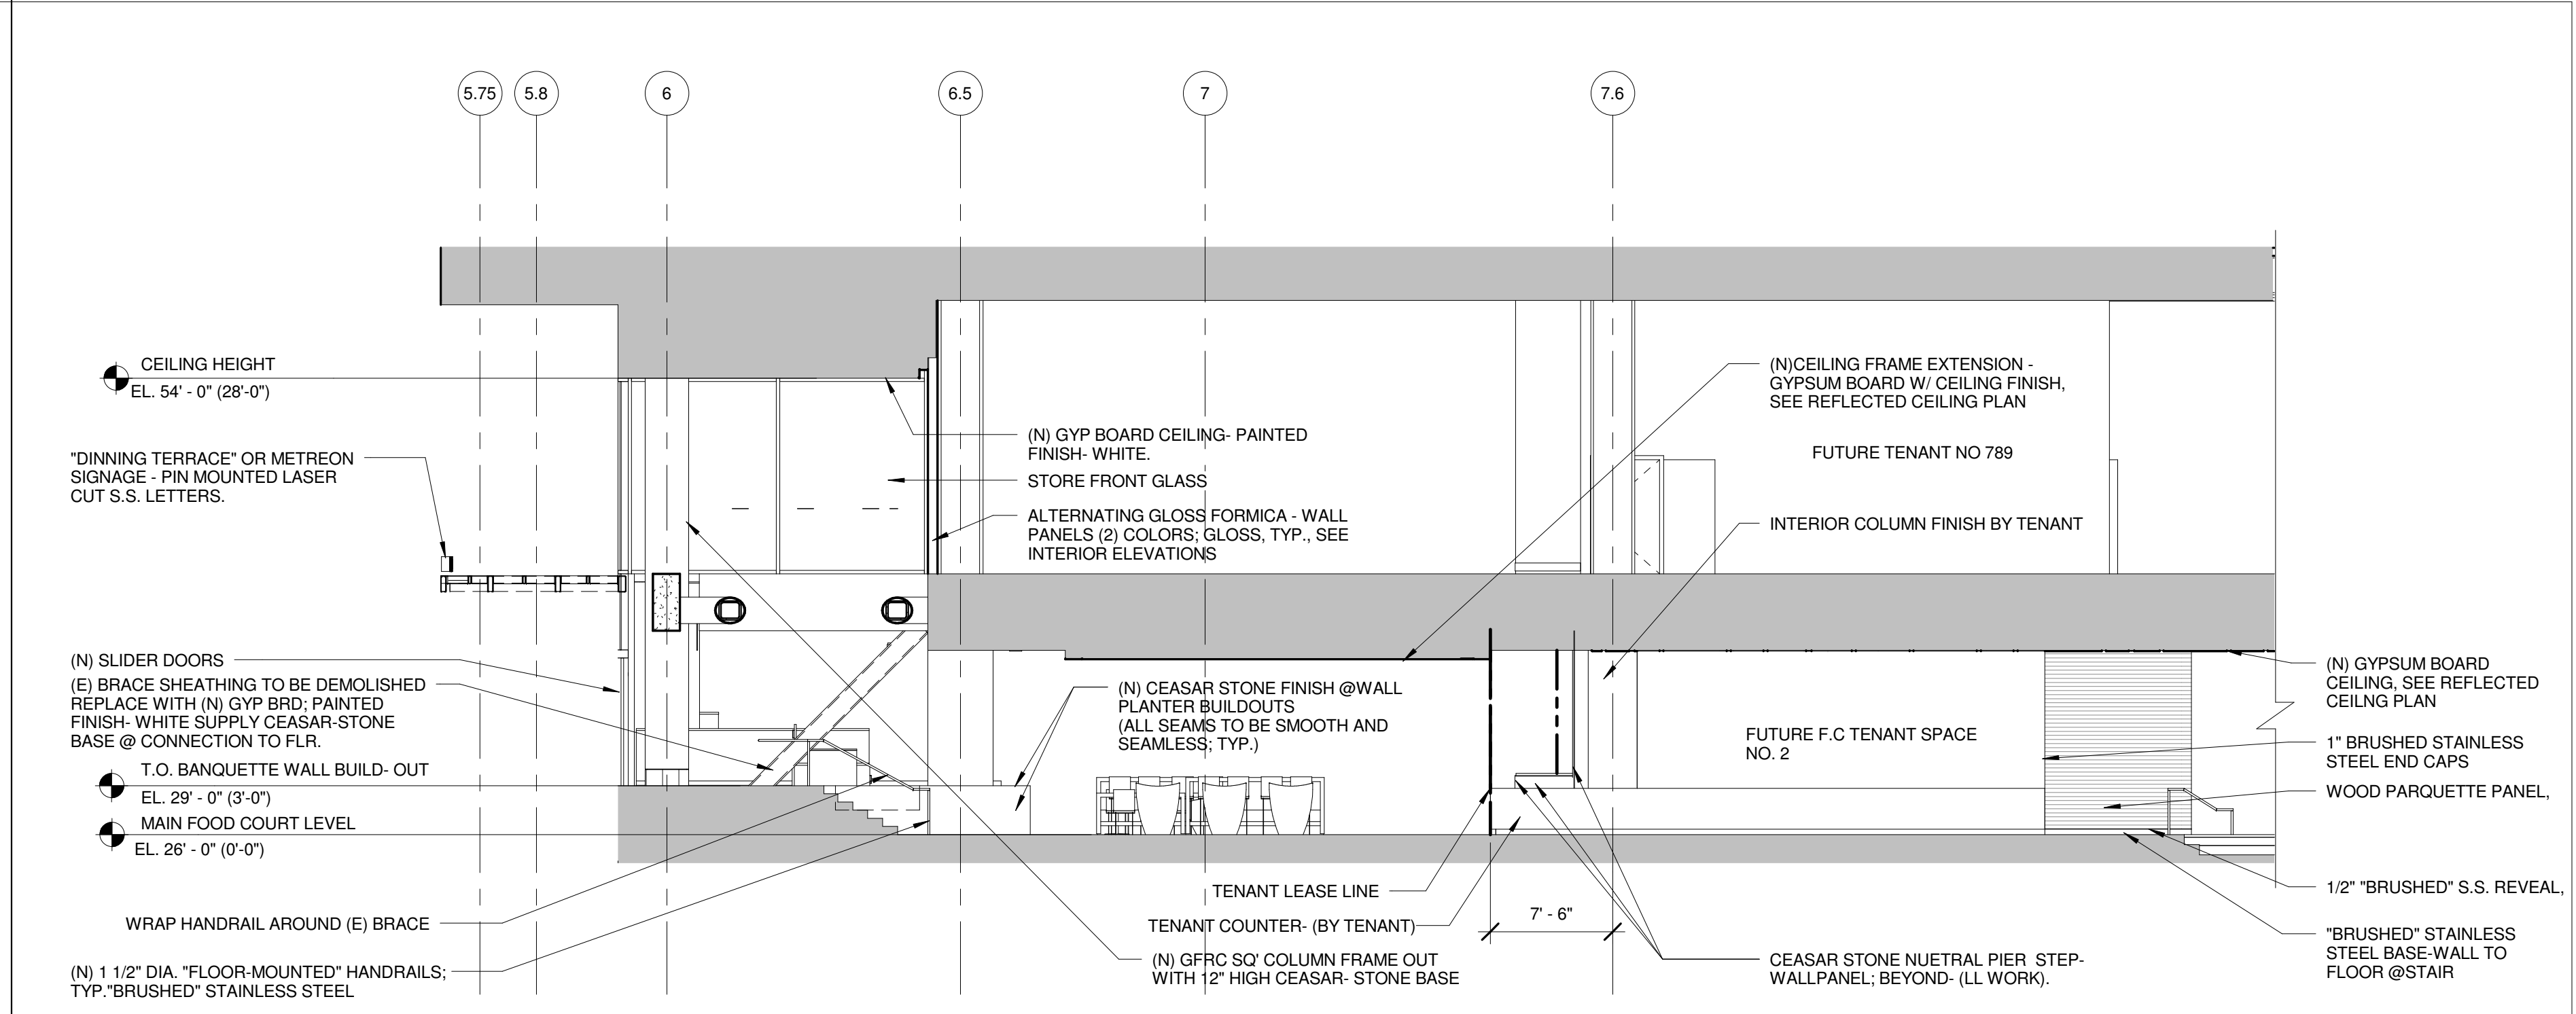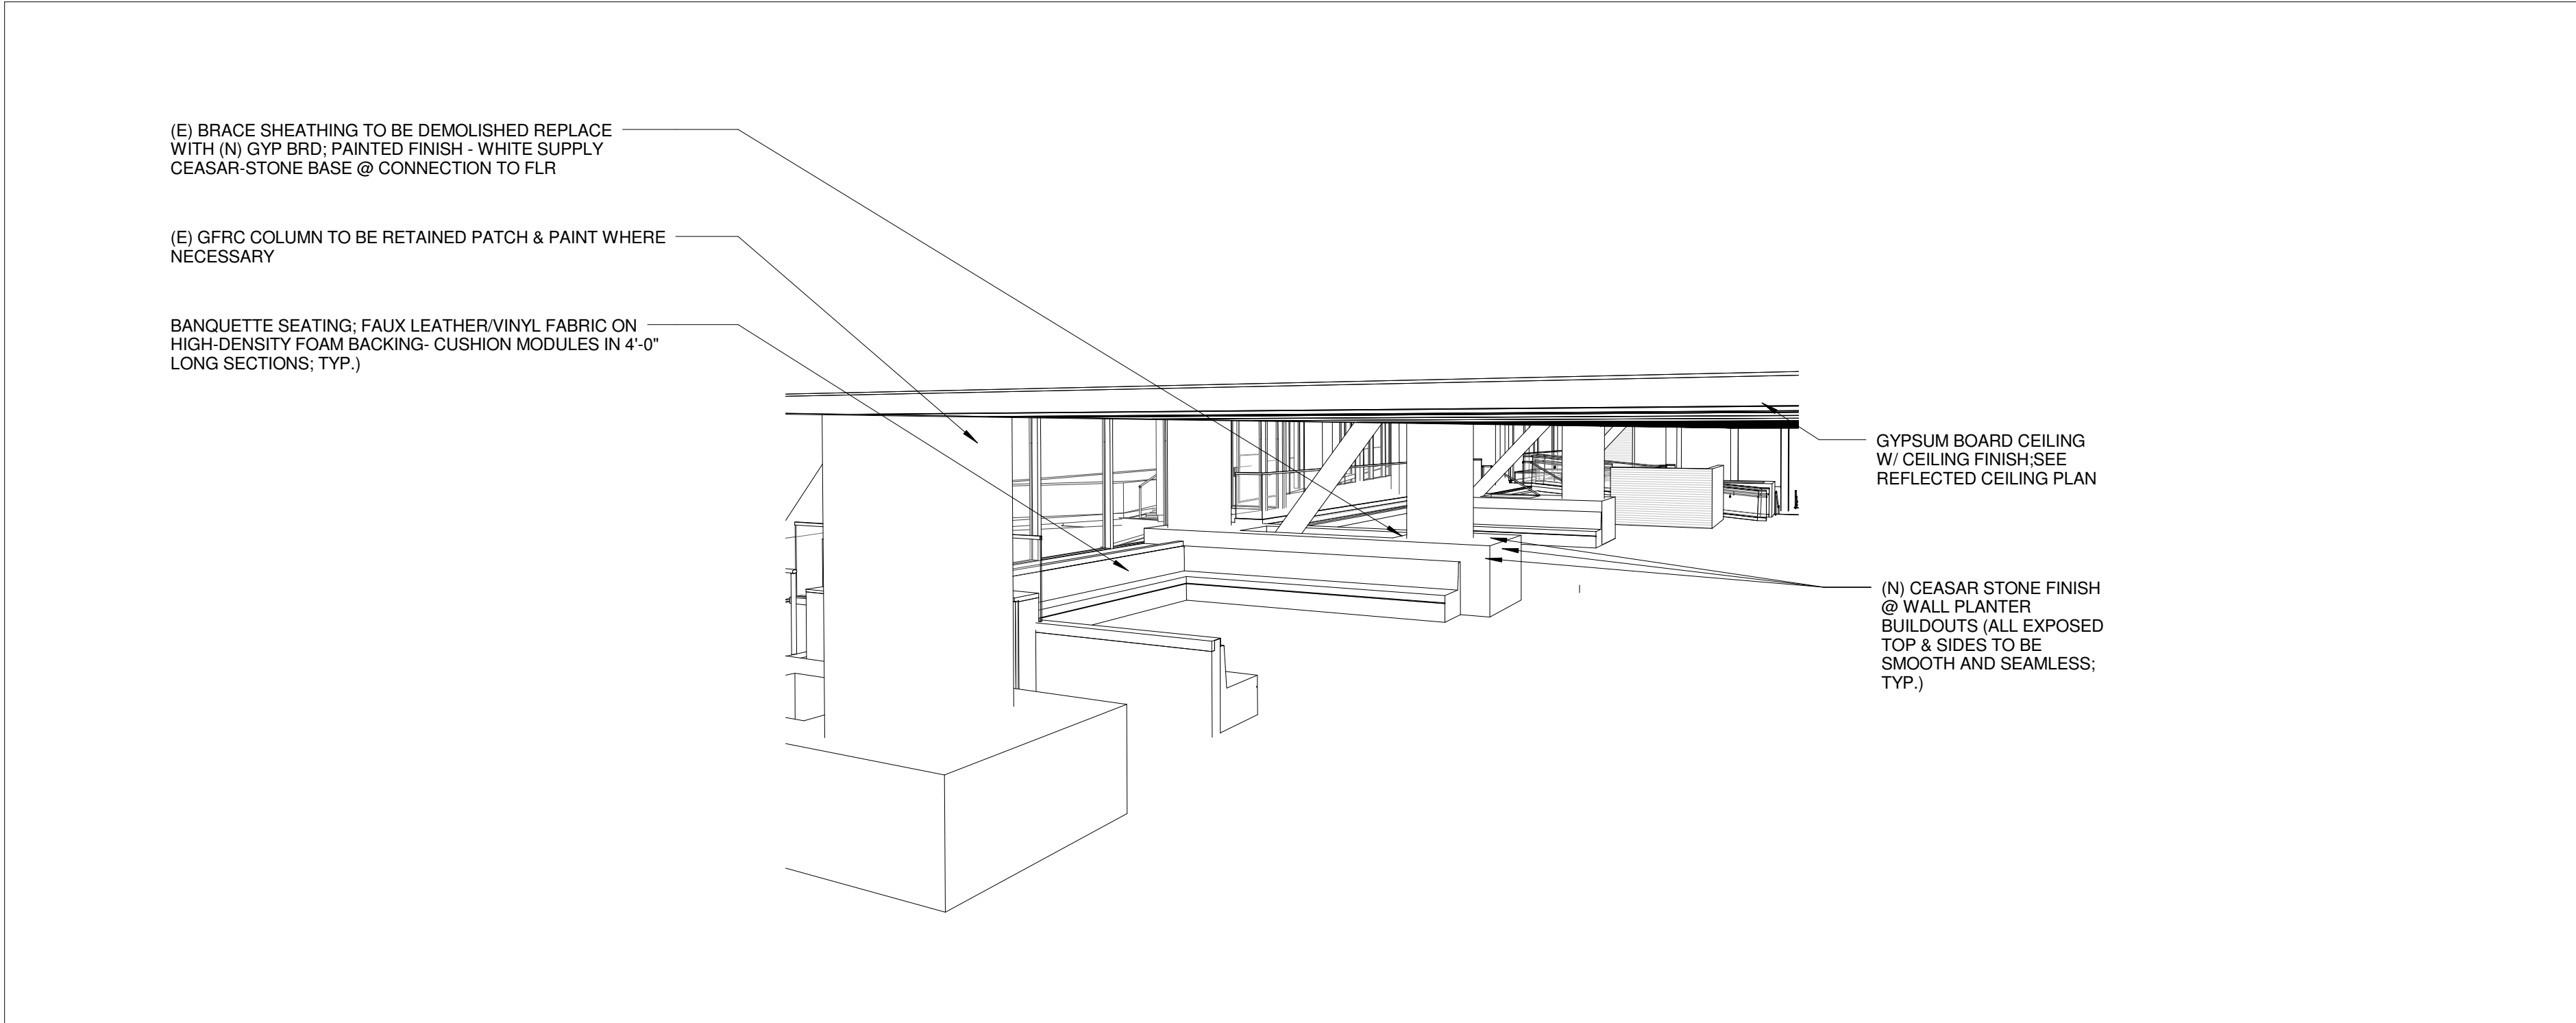


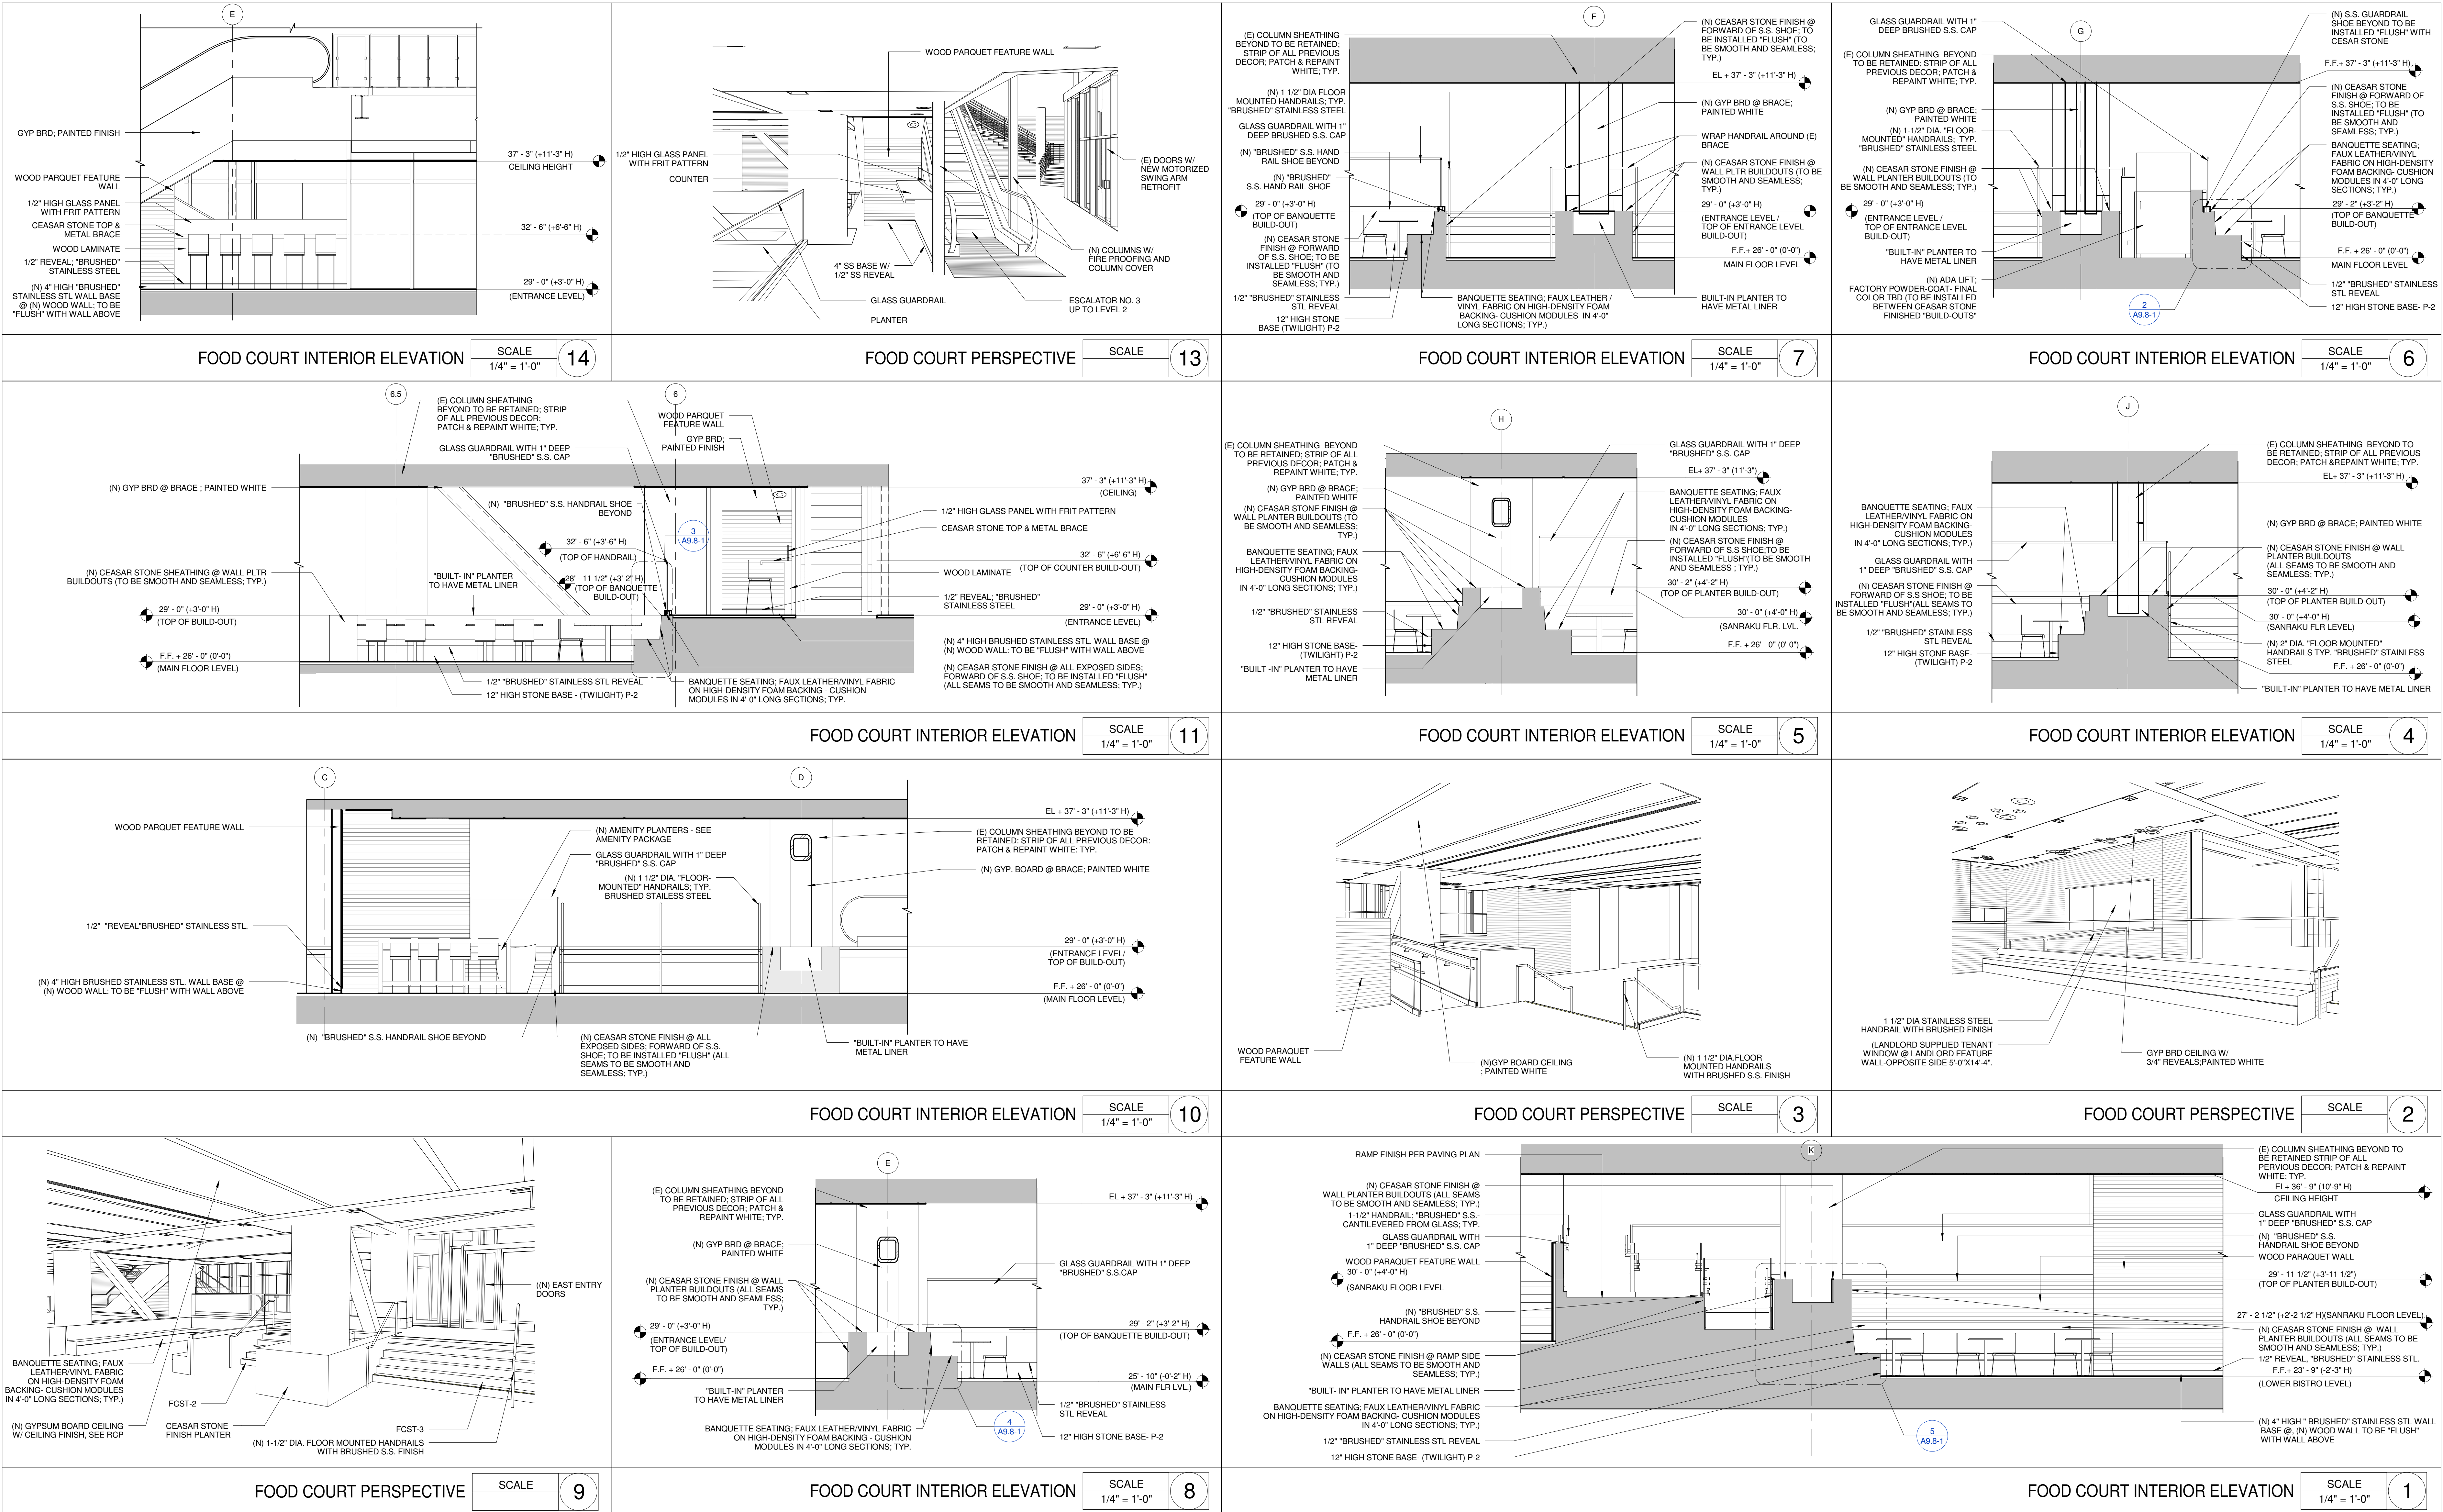

Consultants:

Registration No.

Key Plan

















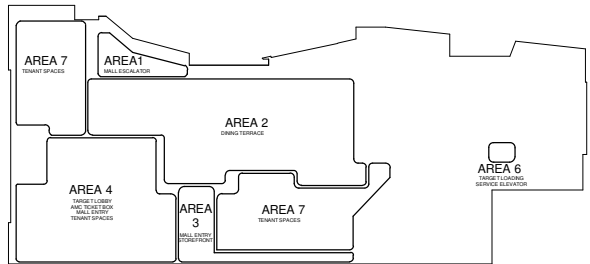



Sheet Title

FOOD COURT
INTERIOR
ELEVATIONS

Job No. Date Scale
1295 SEPT 01, 2010. 1/4" = 1'-0"

  A6.1-3

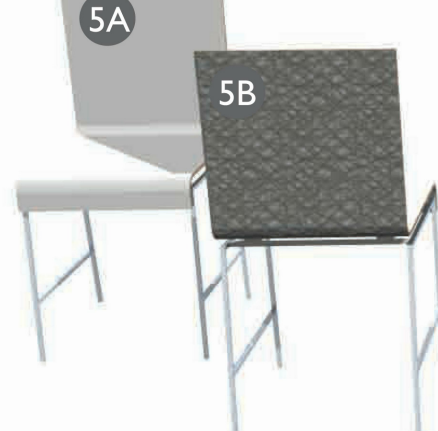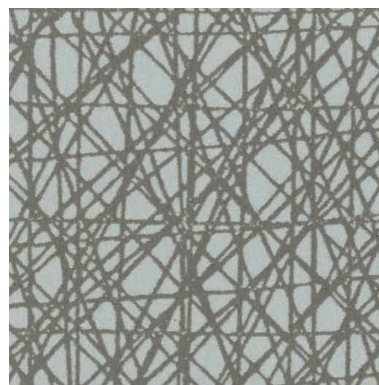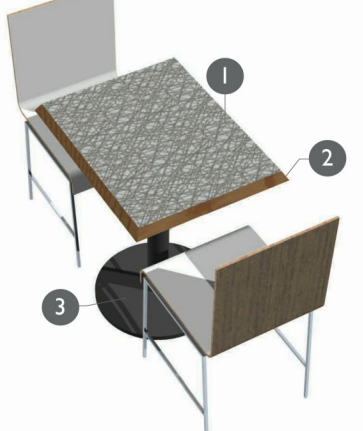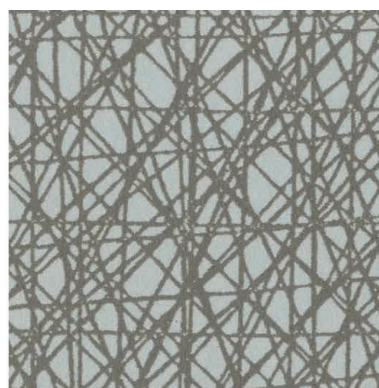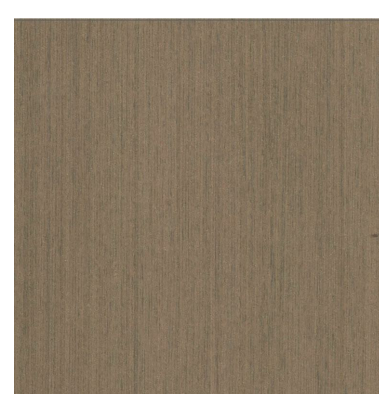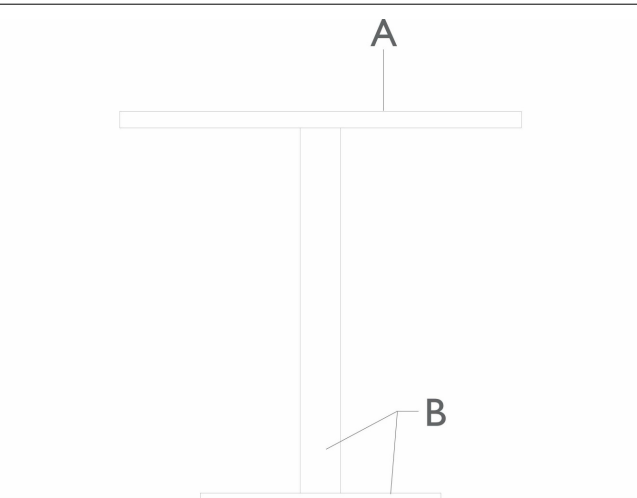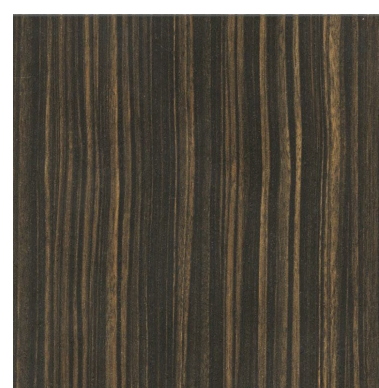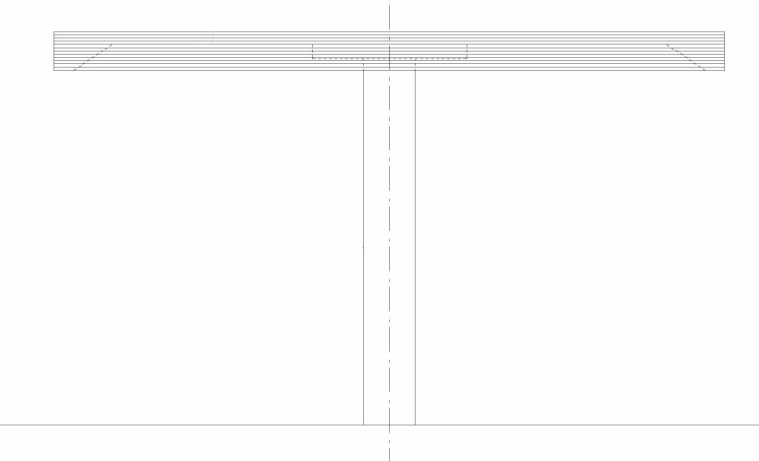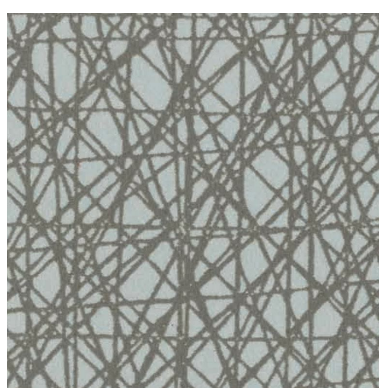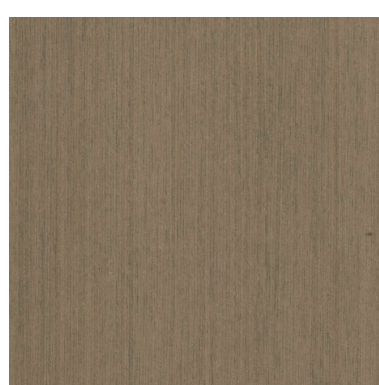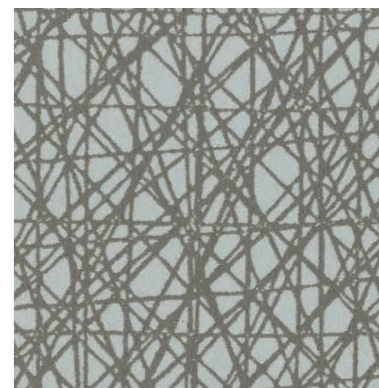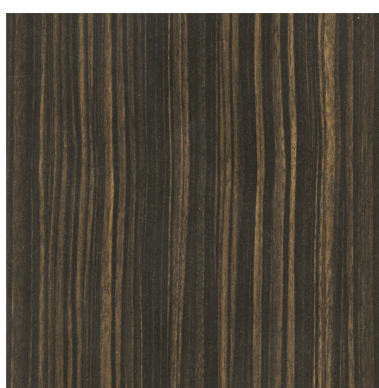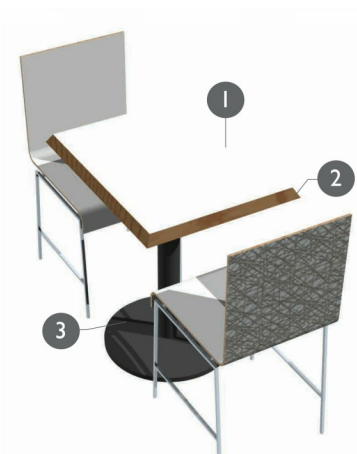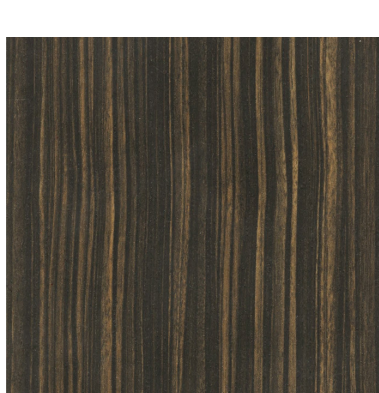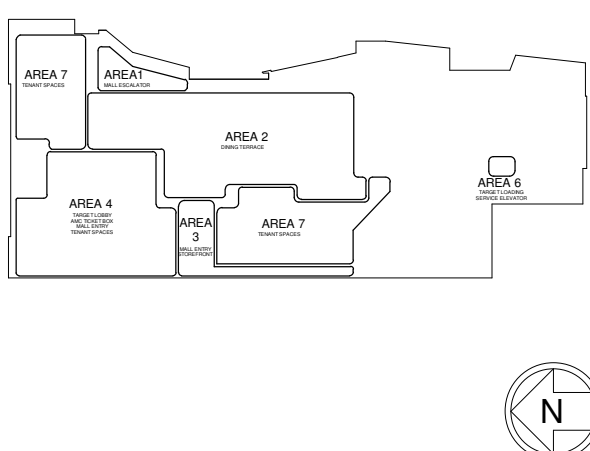
				CHR-01C-ASSEMBLY SHELL FRONT LAMINATE (@ SEAT) (5A)-FORMICA # 949-58 SHELL BACK LAMINATE (5B)-FORMICA # 6944-58 VIRRVARR LIGHT BLUE - MATTE FINISH METAL CHAIR BASE - POLISHED CHROME						TAB-01A-ASSEMBLY TABLETOP LAMINATE- FORMICA # 6944-58 VIRRVARR-LIGHT BLUE MATTE FINISH METAL BASE - CHARCOAL KRINKLE COAT TO MAATCH FORMICA LAMINATE # 837-58 GRAPHITE					
FOOD COURT AMENITIES - CHAIR SPECS						SCALE 12" = 1'-0"	14	FOOD COURT AMENITIES - CHAIR SPECS						SCALE 12" = 1'-0"	7
				CHR-01B-ASSEMBLY SHELL FRONT LAMINATE (@ SEAT) (5A)-FORMICA # 949-58 WHITE MATTE FINISH SHELL BACK LAMINATE (5B)-FORMICA # 9626-NT SMOKY WALNUT WOODLINE NATURELLE FINISH METAL CHAIR BASE - POLISHED CHROME								TAB-02-EXT A. 30" DIA SOLID SURFACE TOP CEASARSTONE, COLOR: 9601, OYSTER (NOTE: BASE PLATE CAN BE DIRECTLY SCREWED TO BOTTOM OF SOLID SURFACE PER FORMICA) B. "BRUSHED" STAINLESS STEEL 3" DIA. TUBE SUPPORT AMD 18" DIA. BASE PLATE			
FOOD COURT AMENITIES - CHAIR SPECS						SCALE 12" = 1'-0"	13	FOOD COURT AMENITIES - TABLE SPECS						SCALE 12" = 1'-0"	6
				CHR-01A-ASSEMBLY SHELL FRONT LAMINATE (@ SEAT) (5A)-FORMICA # 949-58 WHITE MATTE FINISH SHELL BACK LAMINATE (5B)-FORMICA # 9012-NT EBONY NATURELLE FINISH METAL CHAIR BASE - POLISHED CHROME						TAB-04- TABLE TOP ONLY "FIXED" 4'-4" DIA BISTRO TOPS AND POLE BASES FORMICA LAMINATE- # 6944-58 VIRRVARR LIGHT BLUE; MATTE FINISH (ALL FIXED TOP CONDITIONS)					
FOOD COURT AMENITIES - CHAIR SPECS						SCALE 12" = 1'-0"	12	FOOD COURT AMENITIES - TABLE SPECS						SCALE 12" = 1'-0"	5
				TAB-03-ASSEMBLY TABLETOP LAMINATE- FORMICA # 949-58 WHITE MATTE FINISH METAL BASE - CHARCOAL KRINKLE COAT TO MAATCH FORMICA LAMINATE # 837-58 GRAPHITE						COMM-TAB-04 3'-5" WIDE X 5'-5" LONG X 30.5" HIGH LAMINATE PANEL INSETS WHERE INDICATED-FORMICA # 9626-NTSMOKY WALNUT WOODLINE NATURELLE FINISH METAL FRAME- "BRUSHED" STAINLESS STEEL TYP.					
FOOD COURT AMENITIES - CHAIR SPECS						SCALE 12" = 1'-0"	11	FOOD COURT AMENITIES - TABLE SPECS						SCALE 12" = 1'-0"	4
				TAB-02B-ASSEMBLY TABLETOP LAMINATE- FORMICA # 6944-58 VIRRVARR-LIGHT BLUE MATTE FINISH METAL BASE - CHARCOAL KRINKLE COAT TO MAATCH FORMICA LAMINATE # 837-58 GRAPHITE						COMM-TAB-03 3'-5" WIDE X 5'-5" LONG X 42" HIGH LAMINATE PANEL INSETS WHERE INDICATED-FORMICA # 9012-NT EBONY NATURELLE FINISH METAL FRAME- "BRUSHED" STAINLESS STEEL TYP.					
FOOD COURT AMENITIES - CHAIR SPECS						SCALE 12" = 1'-0"	10	FOOD COURT AMENITIES - TABLE SPECS						SCALE 12" = 1'-0"	3
				TAB-02A-ASSEMBLY TABLETOP LAMINATE- FORMICA # 6926-NT SMOKY WALNUT WOODLINE NATURELLE FINISH METAL BASE - CHARCOAL KRINKLE COAT TO MAATCH FORMICA LAMINATE # 837-58 GRAPHITE						COMM-TAB-02 3'-5" WIDE X 8'-6" LONG X 30.5" HIGH (ACCOMODATES ADA REQUIREMENTS) LAMINATE PANEL INSETS WHERE INDICATED-FORMICA # 6926-NT SMOKY WALNUT WOODLINE NATURELLE FINISH METAL FRAME- "BRUSHED" STAINLESS STEEL TYP.					
FOOD COURT AMENITIES - CHAIR SPECS						SCALE 12" = 1'-0"	9	FOOD COURT AMENITIES - TABLE SPECS						SCALE 12" = 1'-0"	2
				TAB-01B-ASSEMBLY TABLETOP LAMINATE- FORMICA # 949-58 WHITE MATTE FINISH METAL BASE - CHARCOAL KRINKLE COAT TO MAATCH FORMICA LAMINATE # 837-58 GRAPHITE						COMM-TAB-01 3'-5" WIDE X 8'-6" LONG X 42" HIGH LAMINATE PANEL INSETS WHERE INDICATED-FORMICA # 9012-NT EBONY NATURELLE FINISH METAL FRAME- "BRUSHED" STAINLESS STEEL TYP.					
FOOD COURT AMENITIES - CHAIR SPECS						SCALE 12" = 1'-0"	8	FOOD COURT AMENITIES - TABLE SPECS						SCALE 12" = 1'-0"	1
		Consultants:		Registration No.		Key Plan								Sheet Title	
														FOOD COURT AMENITY	
														Job No. 1295 Date SEPT 01, 2010. Scale 12" = 1'-0"	
														A6.1-5	

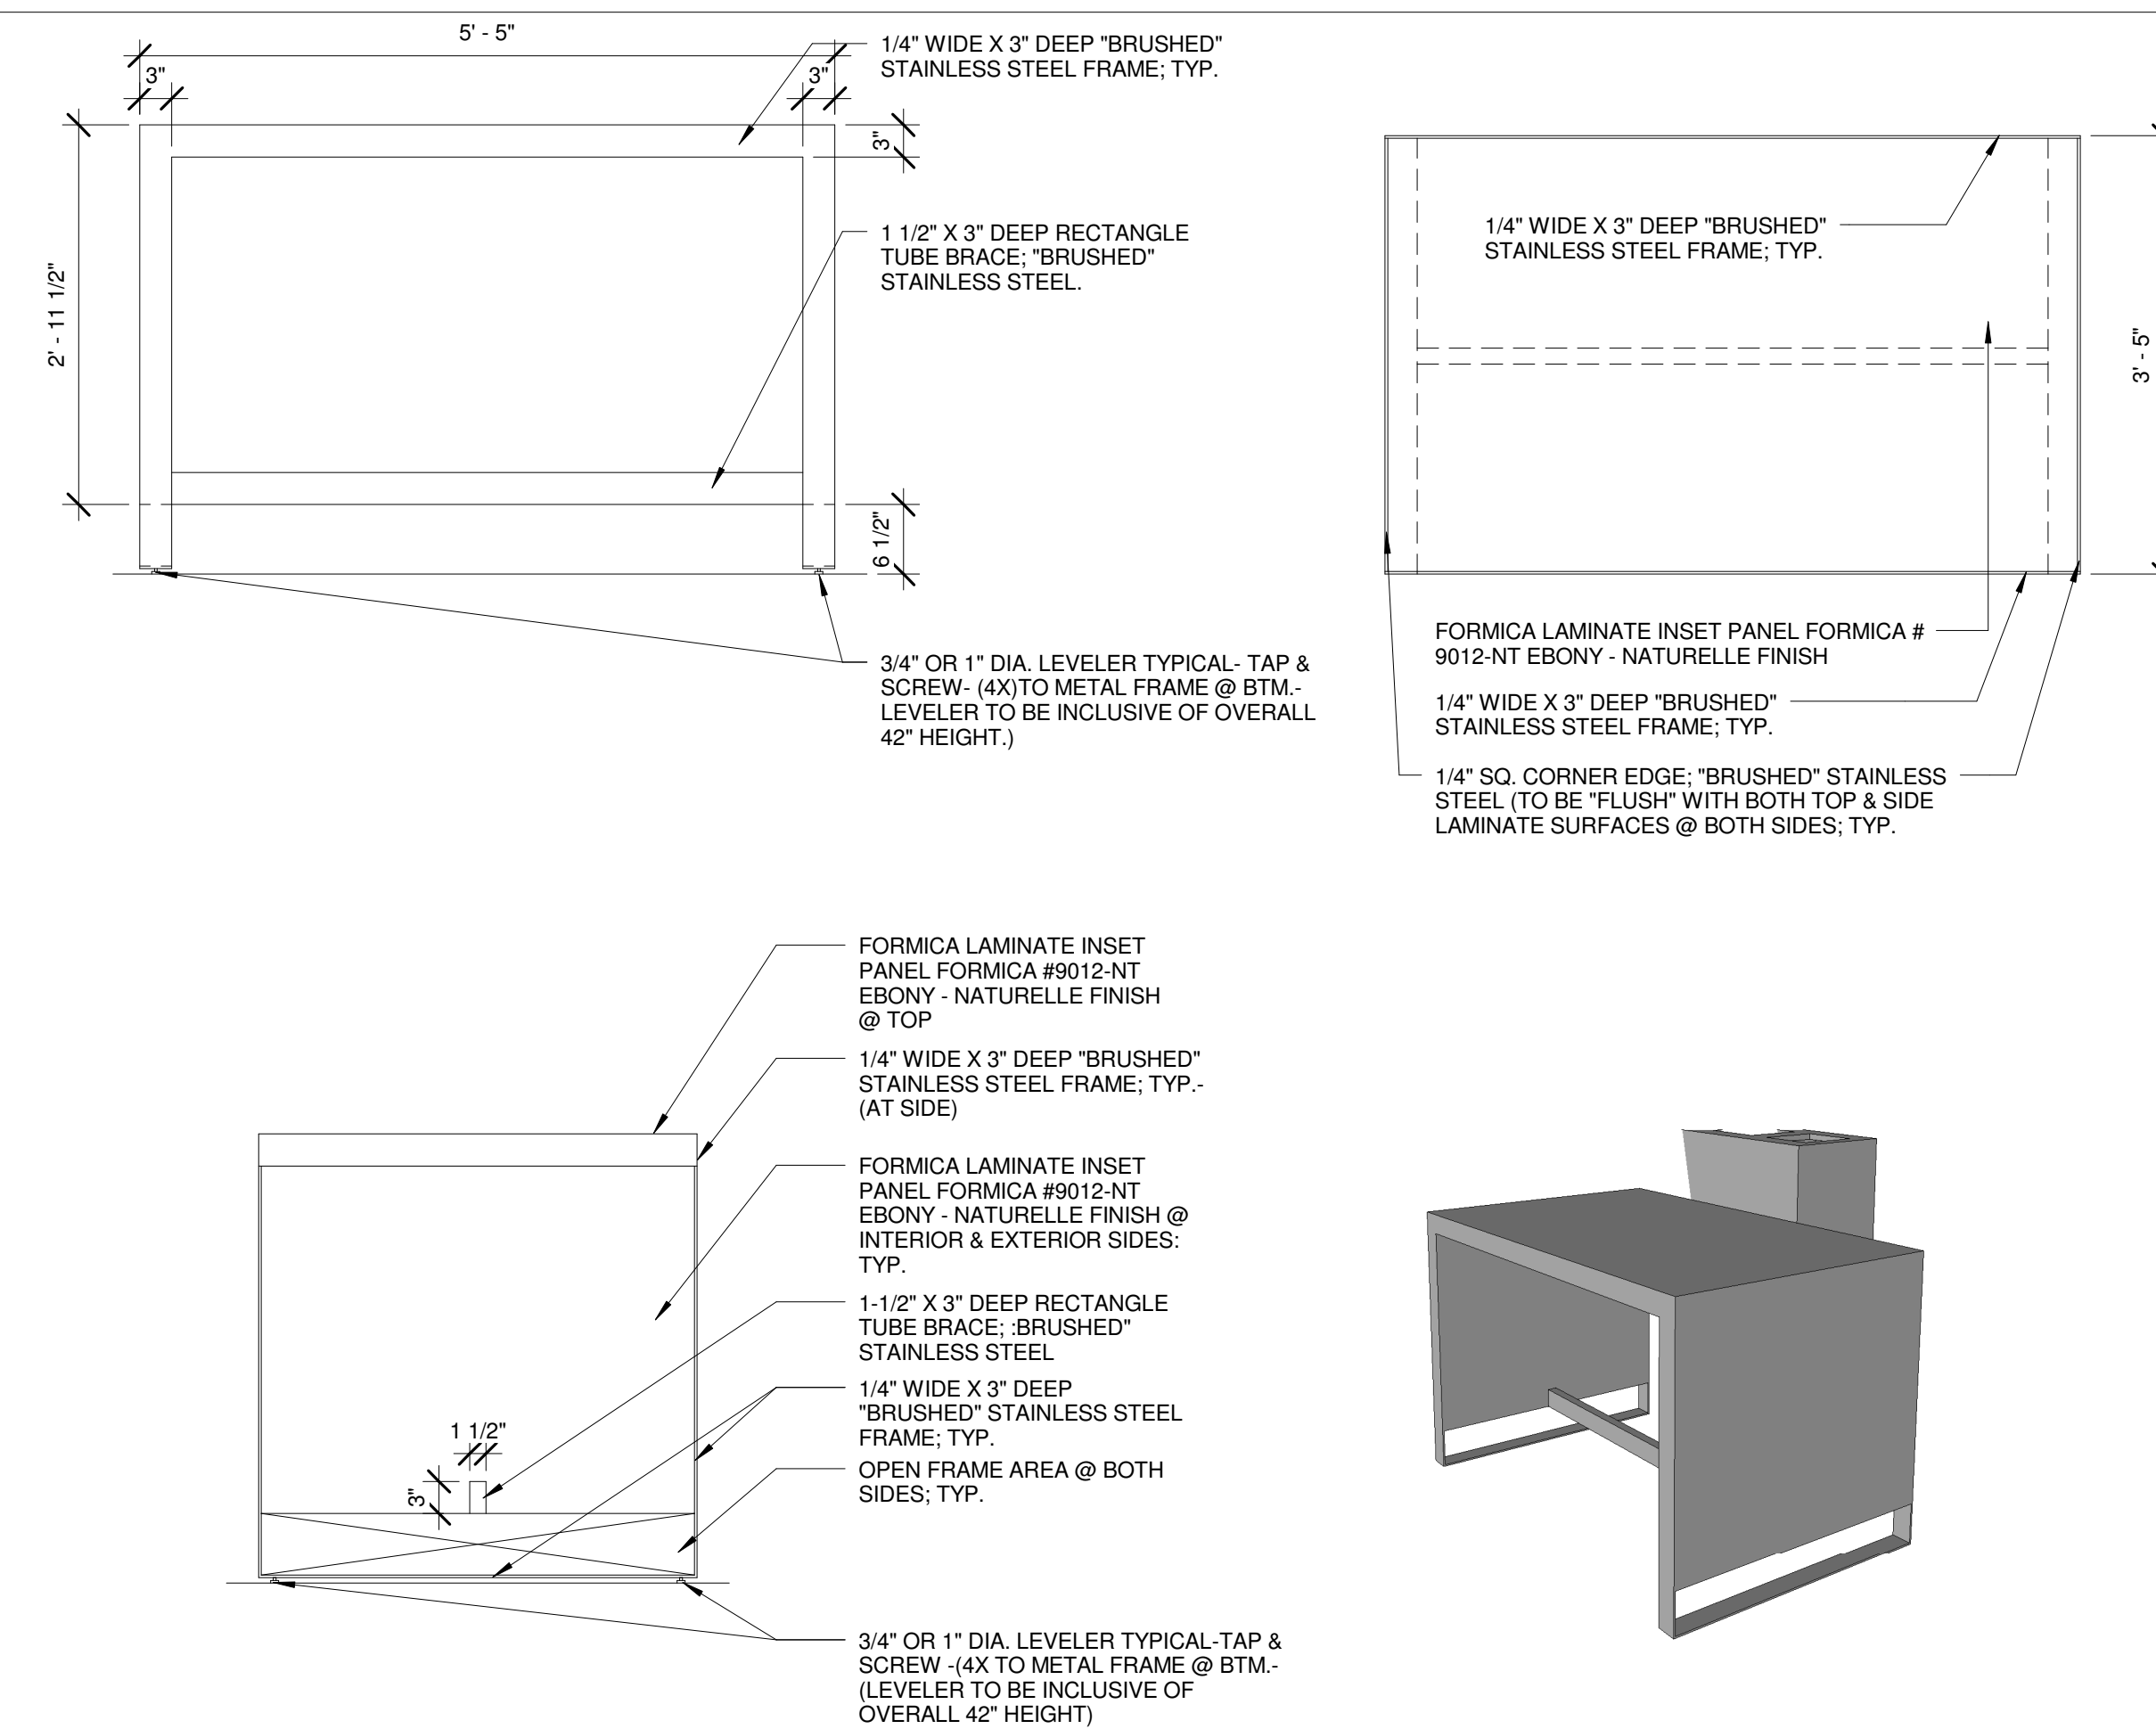

COMM-TAB-03 - PLAN, ELEVATIONS & PERSPECTIVE VIEW

SCALE


(3)

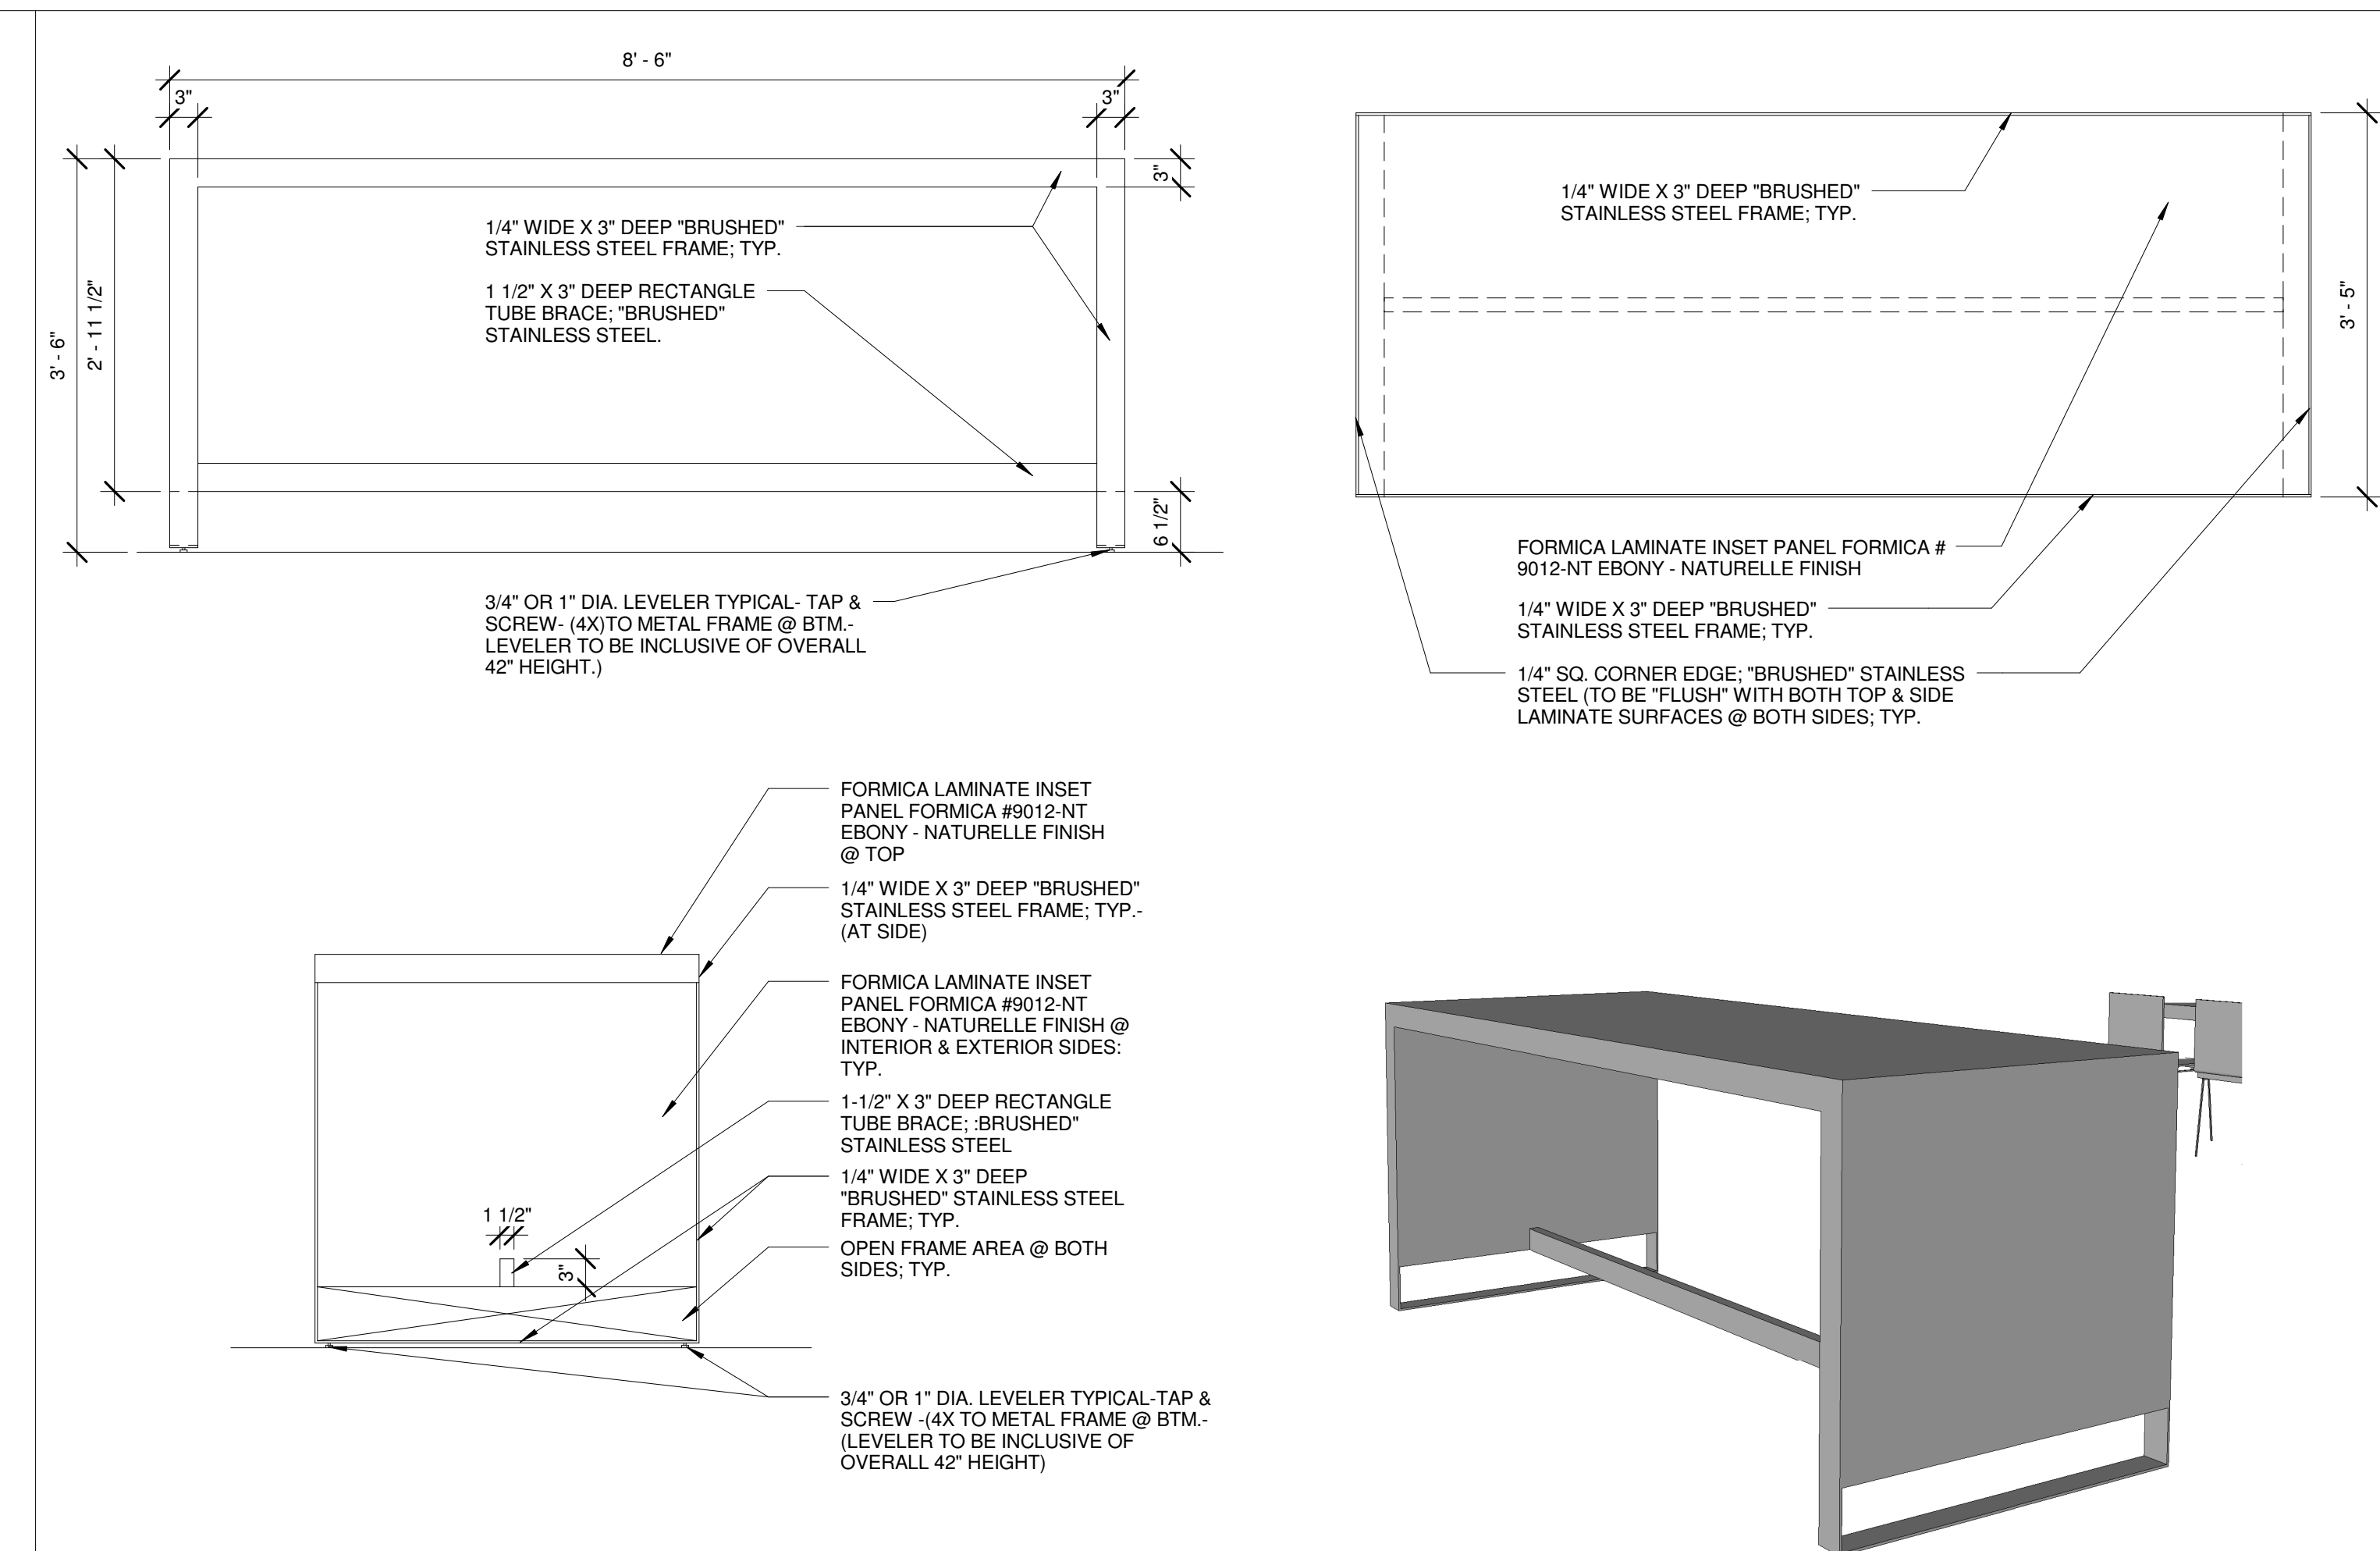

COMM-TAB-01 - PLAN, ELEVATIONS & PERSPECTIVE VIEW

SCALE


1)

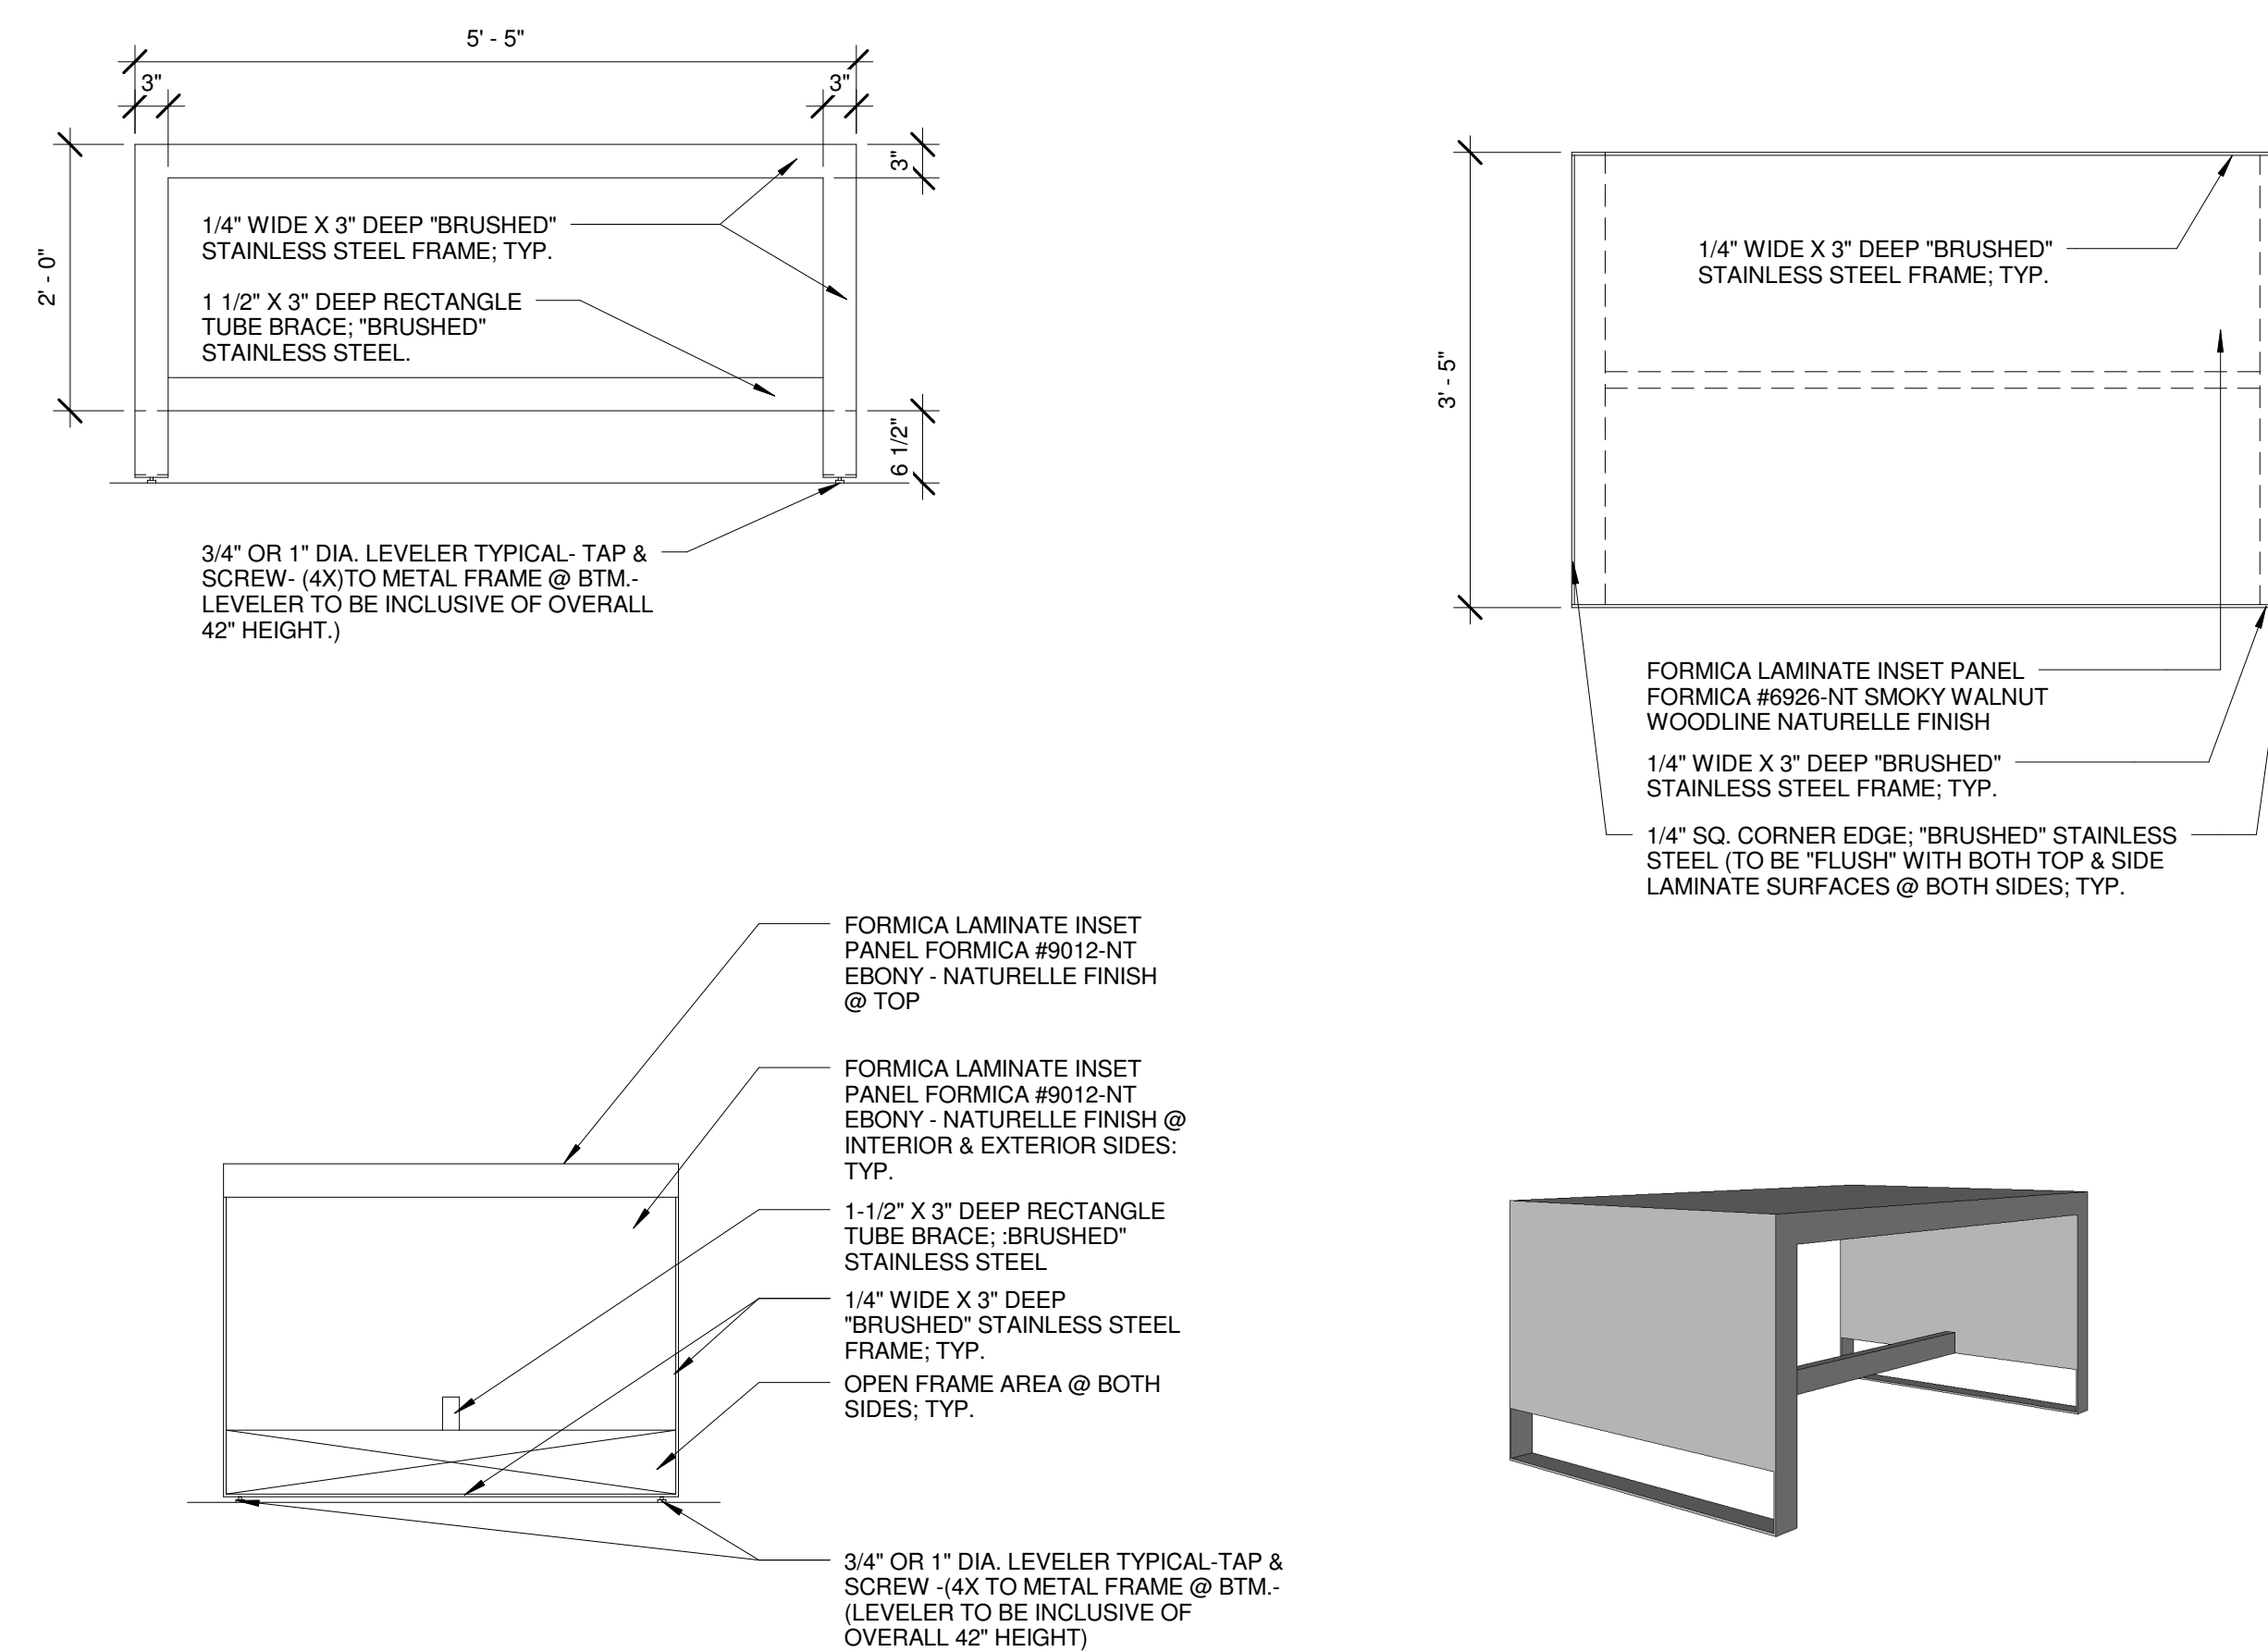

COMM-TAB-04 - PLAN, ELEVATIONS & PERSPECTIVE VIEW

SCALE

4

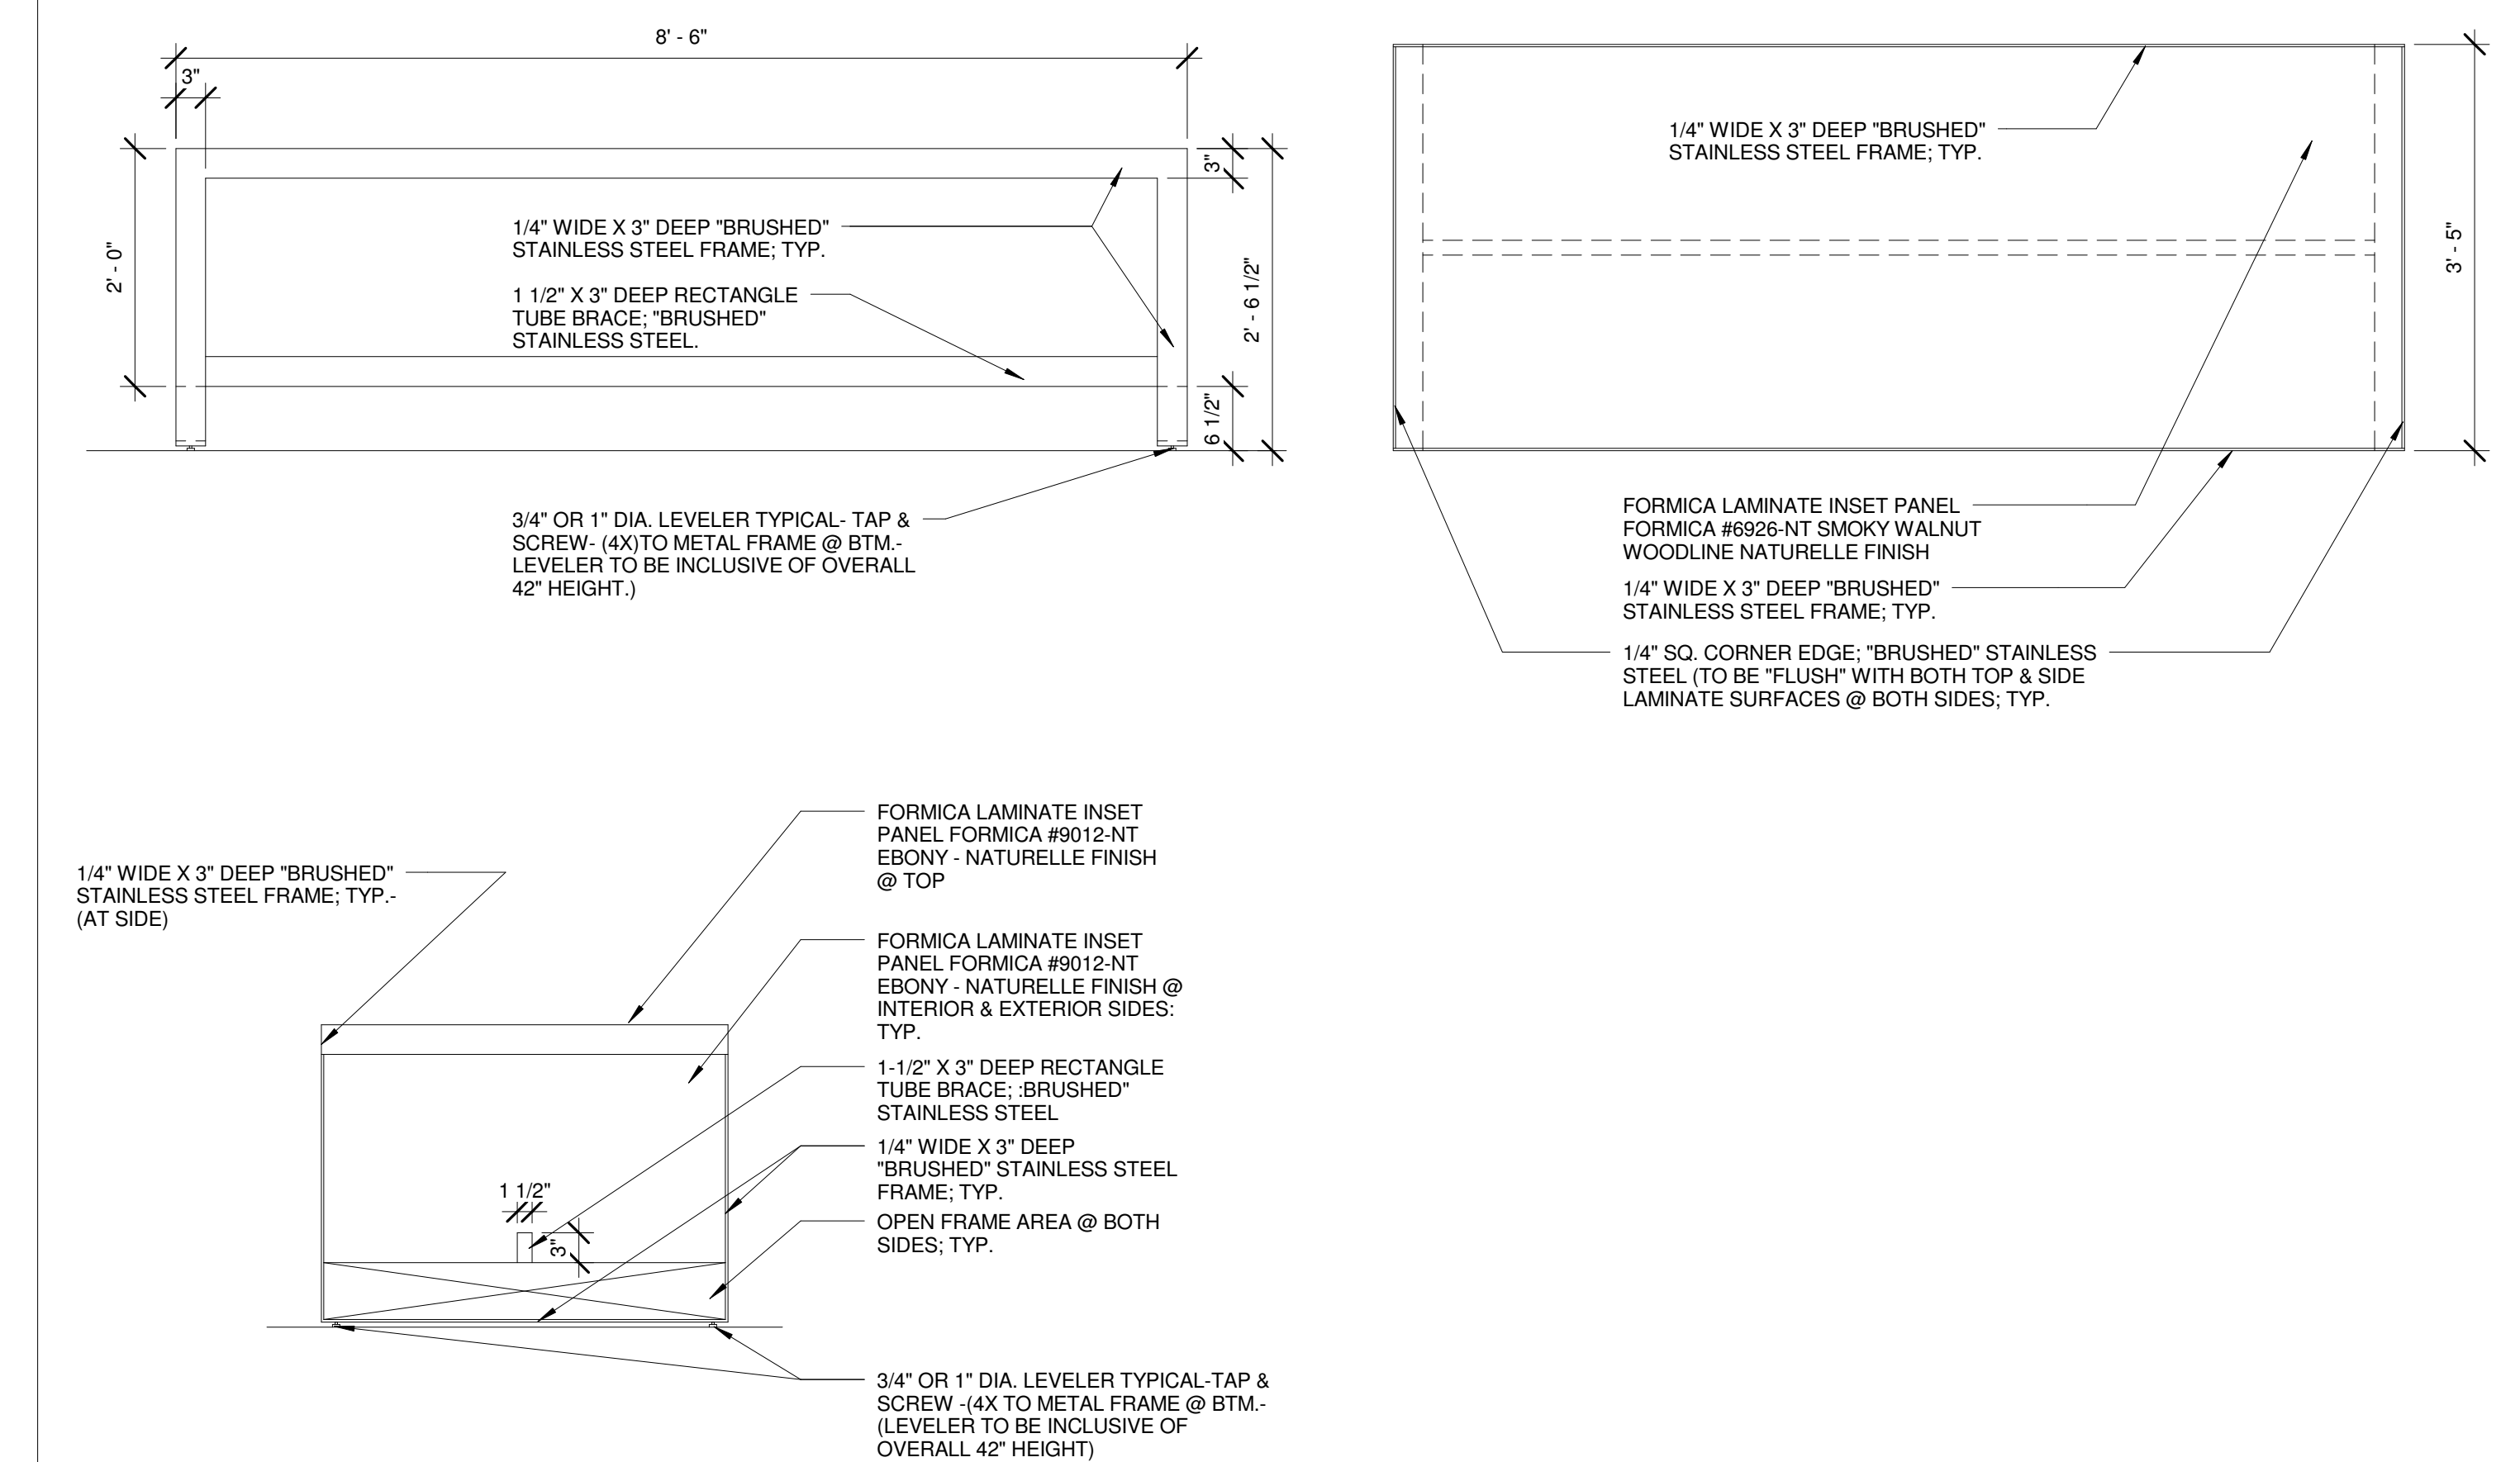

COMM-TAB-02 - PLAN, ELEVATIONS & PERSPECTIVE VIEW


SCALE

2

Consultants:

Registration No.

Key Plan

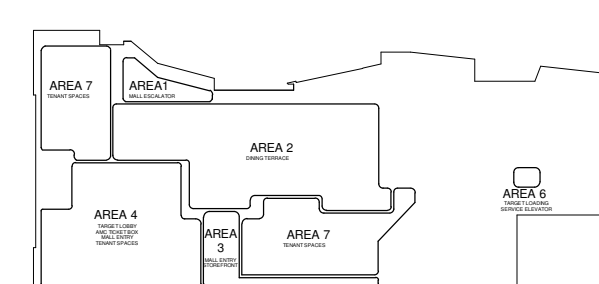


Sheet Title

FURNITURE PLANS
& ELEVATIONS


Job No.	Date	Scale
1295	SEPT 01, 2010.	3/4" = 1'-0"

A6.1-7

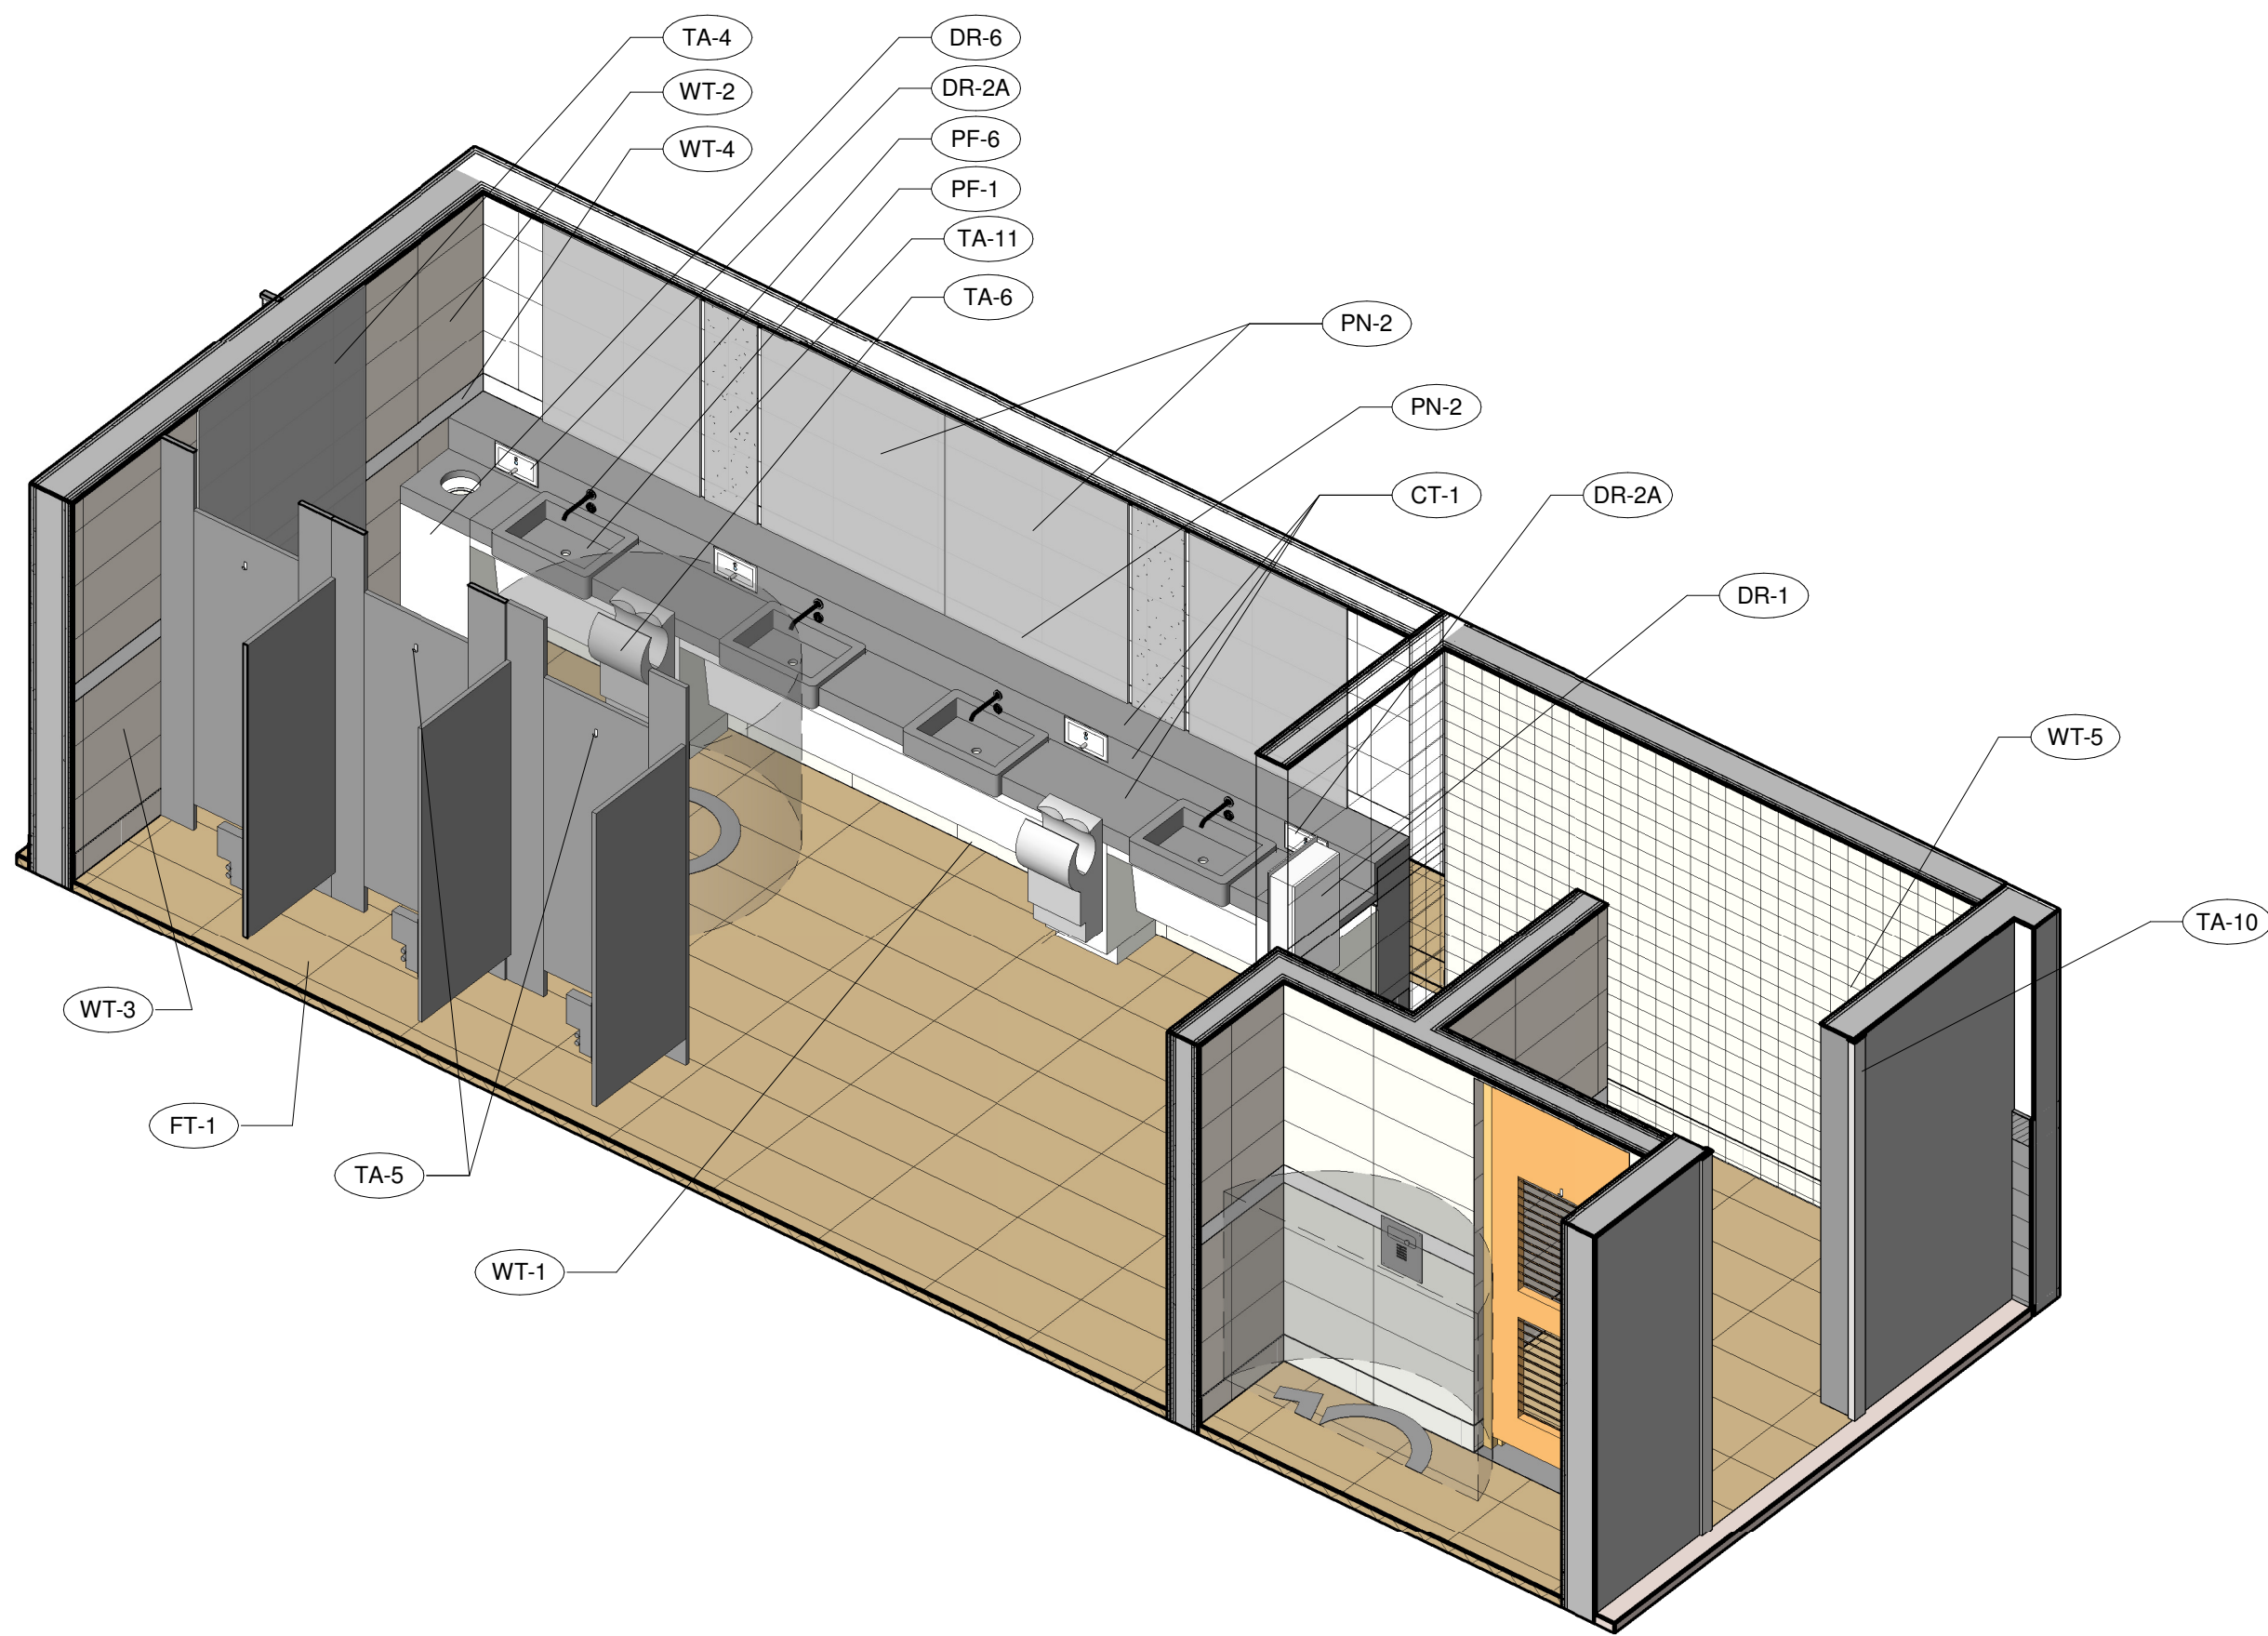


3D VIEW 1 - MEN'S RESTROOM

SCALE 5

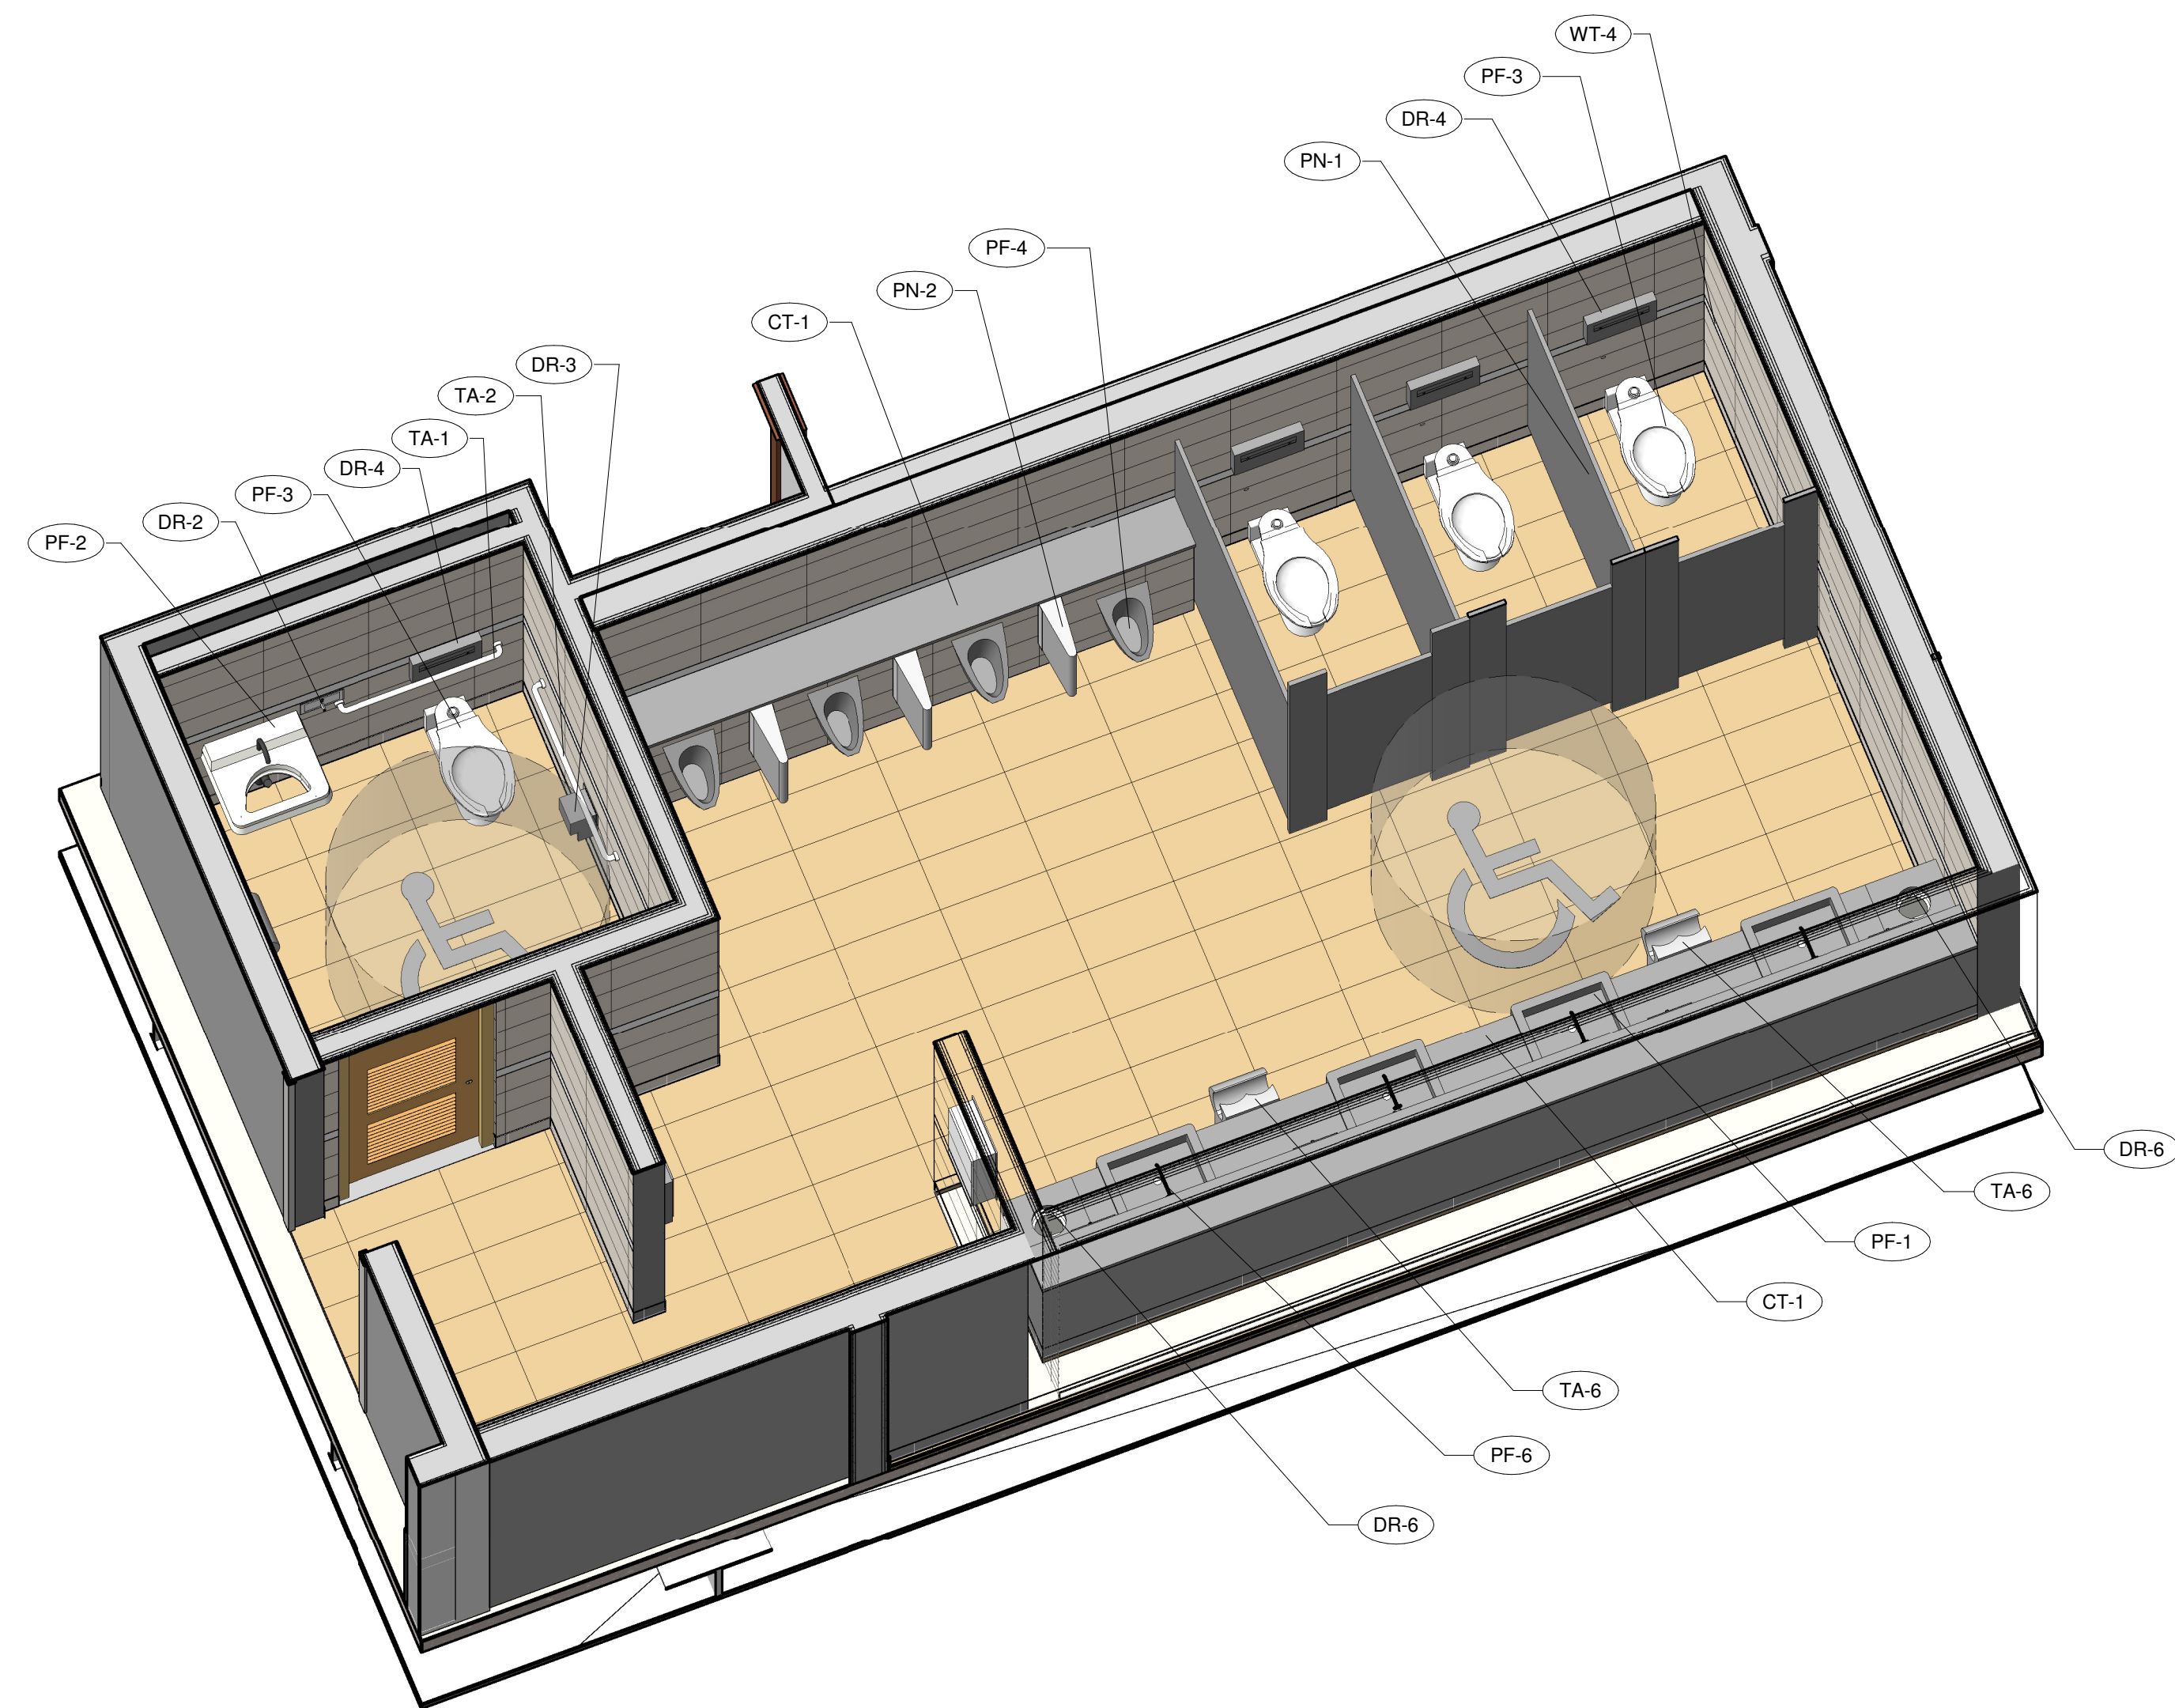


3D - MEN'S RESTROOM

SCALE 4

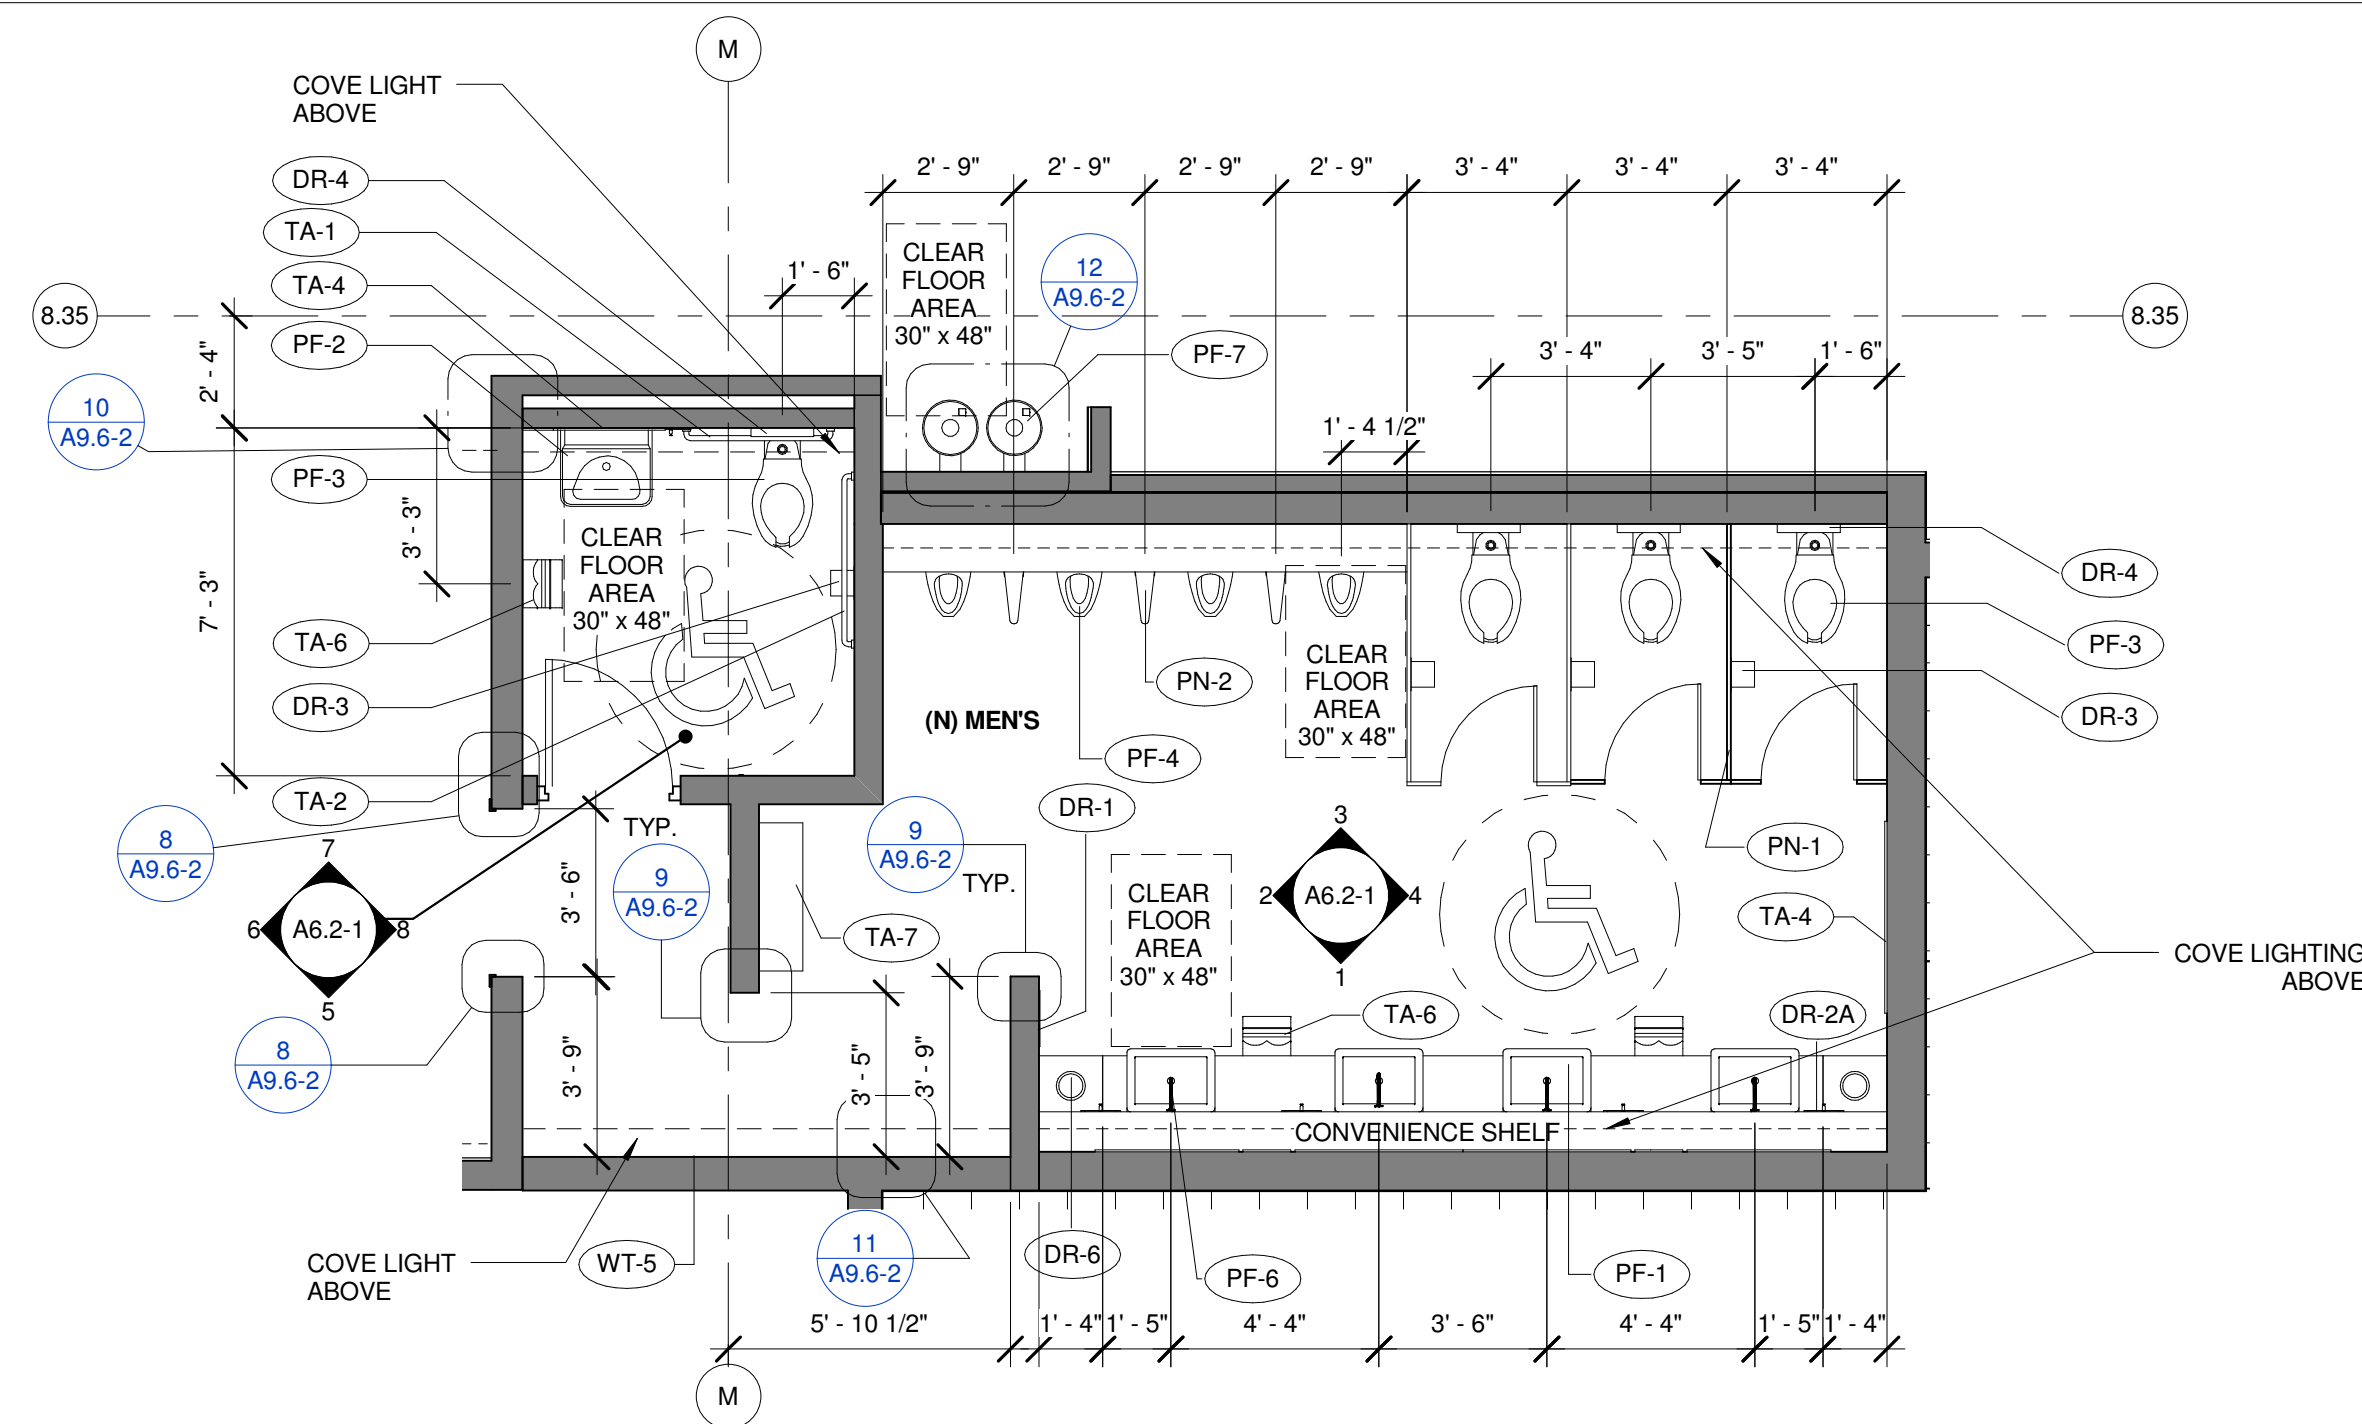


ENLARGED RESTROOM PLANS-MEN'S

SCALE 1/4" = 1'-0" 3

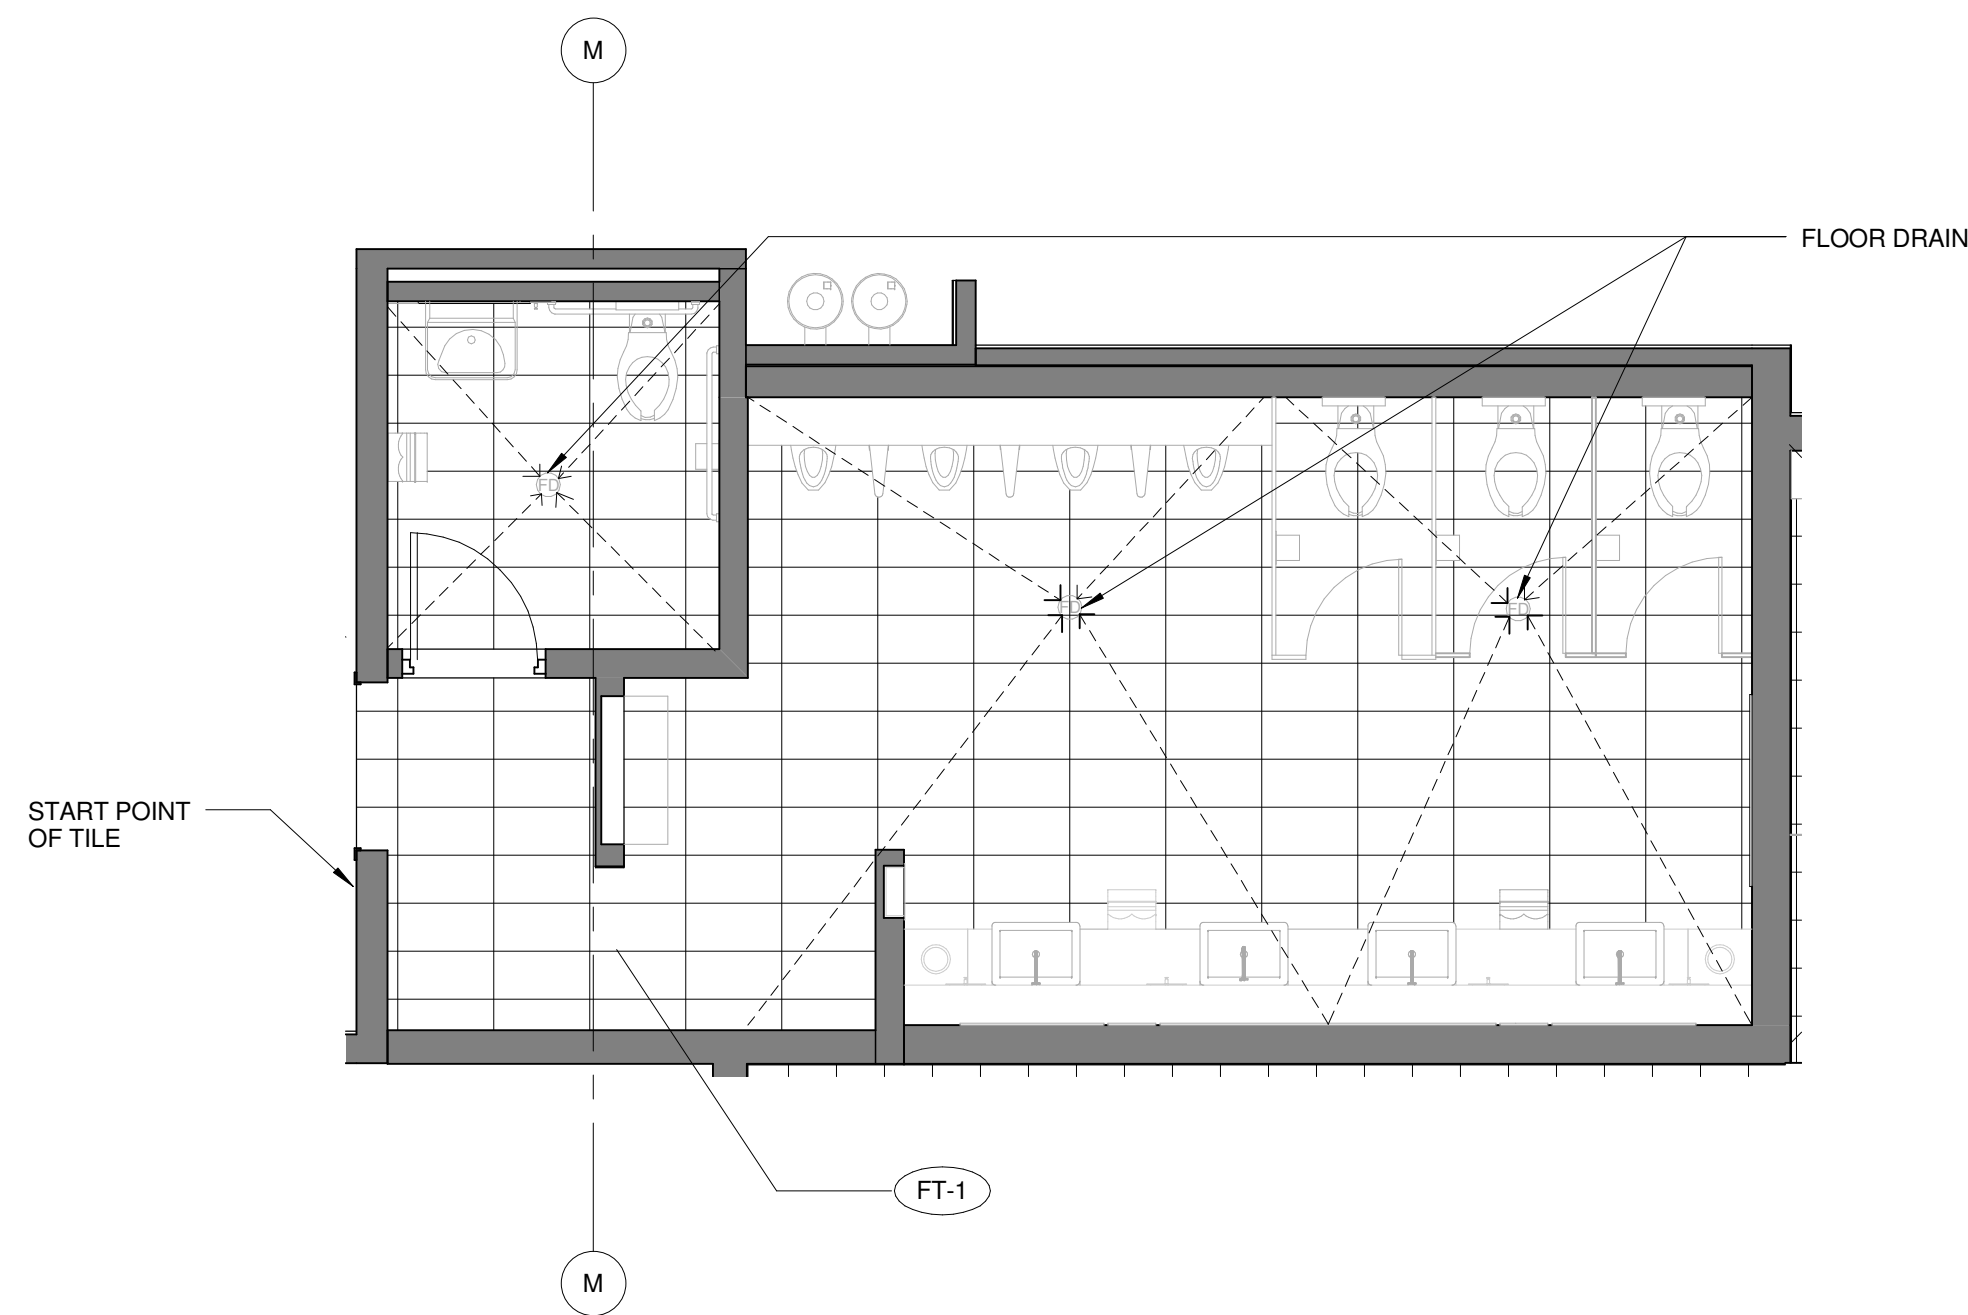

ENLARGED RESTROOMS PAVING PLAN-MEN'S

SCALE 1/4" = 1'-0" 2

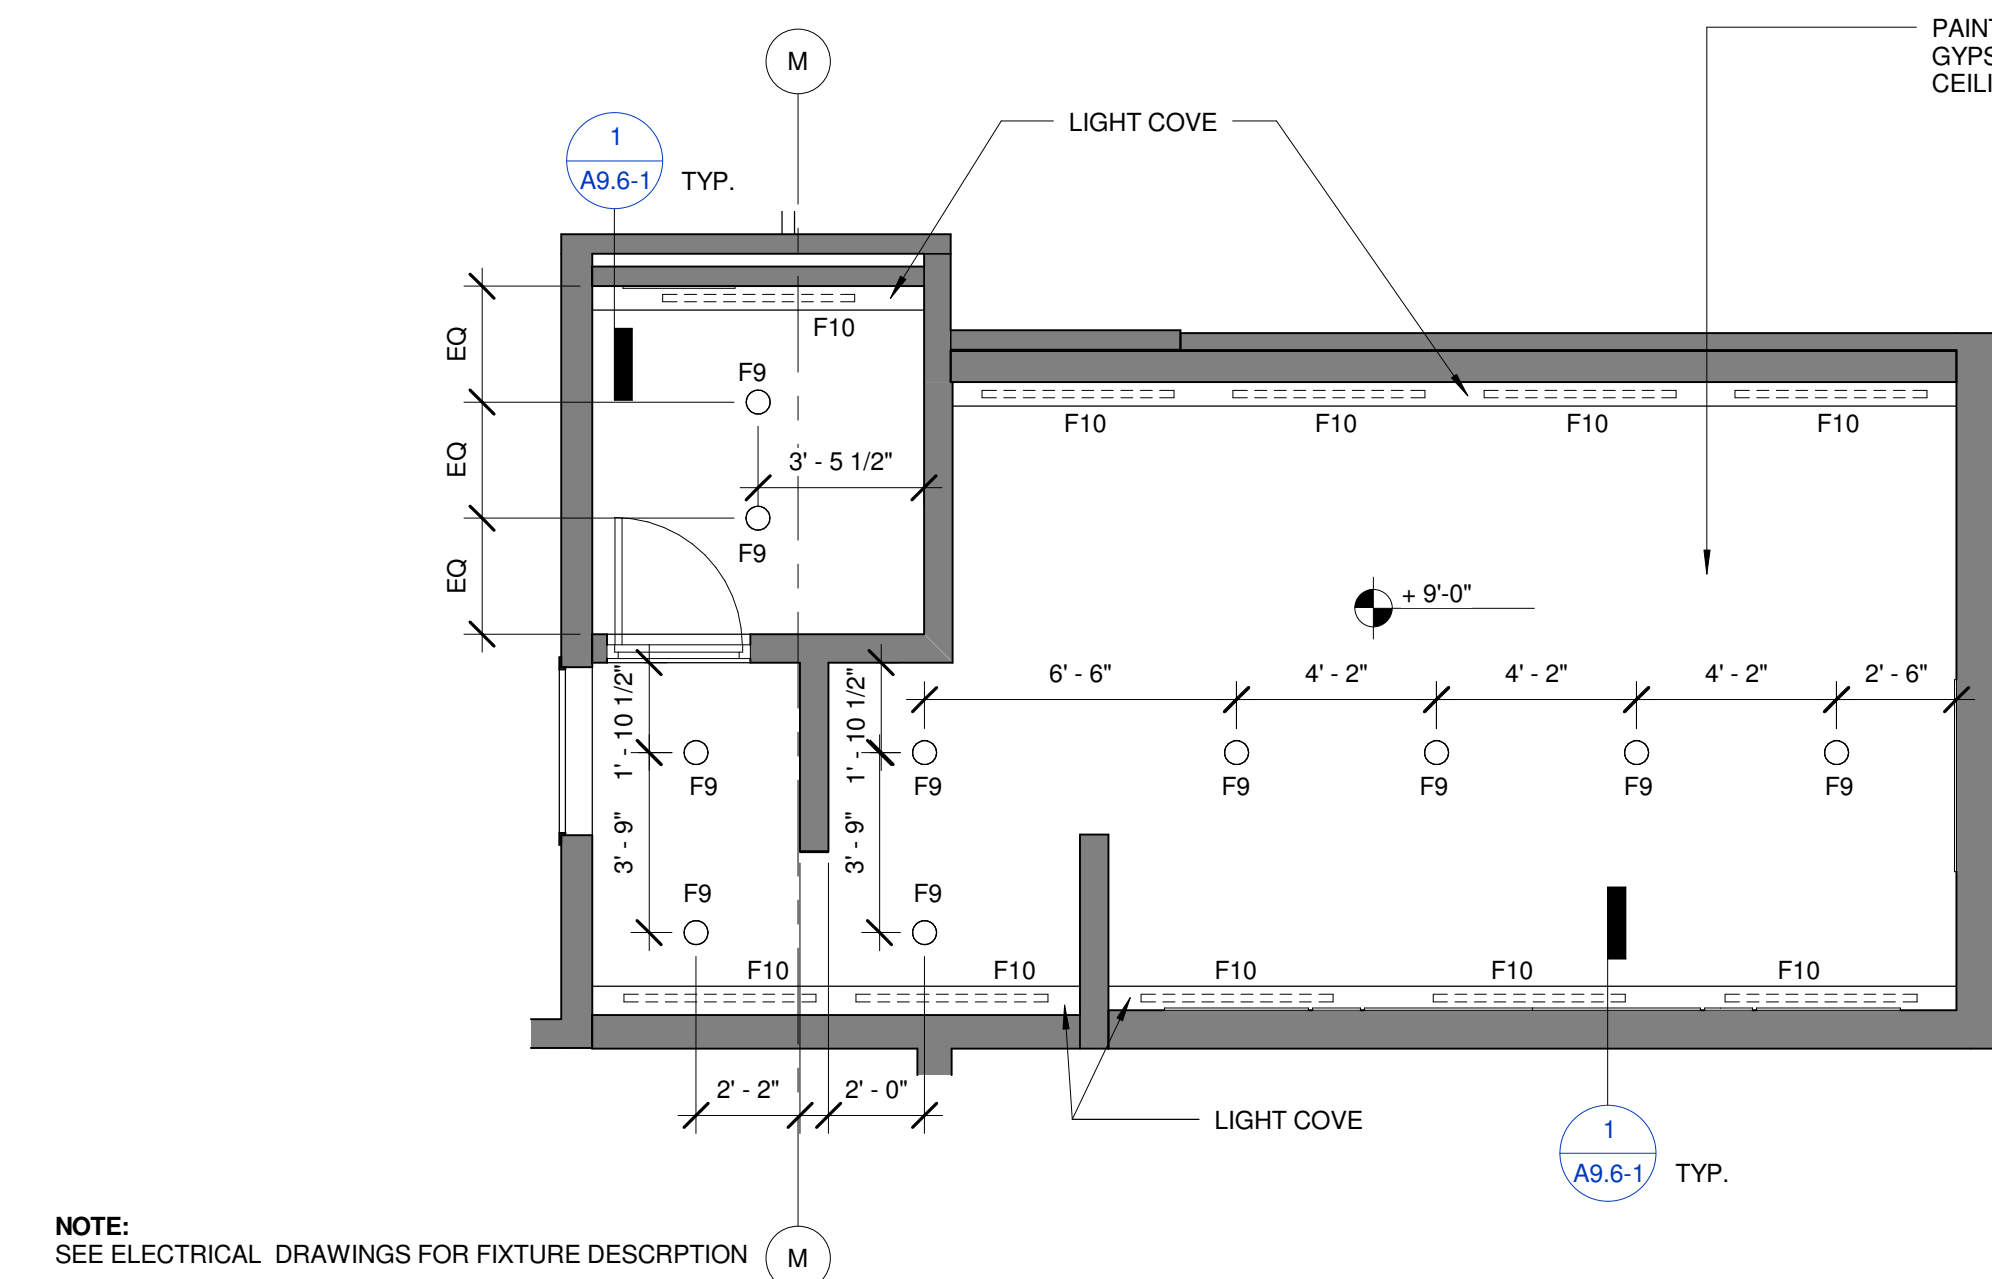

NOTE:

SEE ELECTRICAL DRAWINGS FOR FIXTURE DESCRIPTION

ENLARGED RESTROOMS RCP-MEN'S

SCALE 1/4" = 1'-0" 1

GENERAL NOTES:

- PLEASE SEE RESTROOM DETAILS ON SHEET NO. A6.2-1, 9.6-2.
- SEE HANDICAP ACCESSIBILITY NOTES (DRG. A0.0-3 TO A0.0-5) FOR ADA STANDARD.
- SEE ELECTRICAL & MECHANICAL DRAWINGS FOR FIXTURE DESCRIPTION.
- SEE A6.2-4 FOR FINISHES DETAIL.
- SANITARY NAPKIN DISPOSAL ONLY IN WOMEN'S RESTROOM.
- FOR LIGHTING FIXTURES SEE LIGHTING FIXTURES SCHEDULE.
- COORDINATE LOCATIONS FOR MECHANICAL EXHAUST, SUPPLY, AND RETURN WITH MECH. ENGINEER.
- FOR JANITOR ROOM SEE A6.2-4 FOR ADDITIONAL INFO.


TOILET FIXTURE SCHEDULE	
Key Value	Keynote Text

CT-1	COUNTERTOP & CONVENIENCE SHELF - CEASAR STONE
DR-1	RECESSED PAPER TOWEL DISPENSER - Bobrick B-35903
DR-2	RECESSED SOAP DISPENSER - Bradley - 6438
DR-2A	RECESSED SOAP DISPENSER - Bradley - 643
DR-3	SURFACE MOUNTED MULTI-ROLL TOILET TISSUE DISPENSER - Bobrick B-4288
DR-4	SURFACE MOUNTED SEAT COVER DISPENSER - Bobrick B-4221
DR-5	SURFACE MOUNTED SANITARY NAPKIN DISPOSAL - Bobrick B-270
DR-6	FLOOR STANDING STAINLESS STEEL WASTE RECEPTACLE - Bobrick B-2260 (Trash can inside of open top waste receptacle cabinet)
FT-1	FLOOR TILE - DAL TILE - P690 - MATTE FINISH (12"x24")
MW-1	LAMINATED MILLWORK FINISH OF ALL EXPOSED CABINETS (AIRBLADE & TRASH ENCLOSURE CABINET) - BRUSHED STAINLESS STEEL LAMINATE (CHEMETAL #710).LIGHTS
PF-1	LAVATORY - KINGSTON BRASS MODEL EV4335 + BOTTLE TRAP KOHLER K-9035
PF-2	LAVATORY - PRIVATE ROOM LOCATION (ADA COMPLIANT)- Toto LHT241G + TC MILANO AUTO FAUCET
PF-3	TOILET - Toto CT708 + TOILET SEAT COVER Toto-SC534 + SIDEMOUNT FLUSH SYSTEM Technical Concepts-401981
PF-4	URINAL - Falcon F9000SS
PF-5	JANITOR SINK - DURASTONE MODEL 63M - E.L. MUSTEE & SONS + SINK FAUCET 63.600A + HOSE/HOSE HOLDER #65.700 + MOP HANGER #65.600 + BUMPER GUARD #63.401 + HEAVY DUTY HOOKS
PF-6	SINK FAUCET, AEF-304 FROM ADVANCED MODERN TECHNOLOGIES COMPANY- CONTACT GABRIEL STARKMAN 818-874-7822
PF-7	DRINKING FOUNTAIN - 1011HPSMS/1011MS HAWS CORPORATION
PN-1	STAINLESS STEEL TOILET PARTITIONS - General Partitions Series 60-3
PN-2	URINAL PARTITIONS - General Partitions WHS-3
TA-1	36" GRAB BAR, Bobrick B-6806 SERIES
TA-2	42" GRAB BAR, Bobrick B-6806 SERIES
TA-4	SURFACE MOUNTED MIRROR W/ ANTI GRAFITTI FILM - SEE ELEVATION FOR SIZE
TA-5	SURFACE MOUNTED DOUBLE ROBE HOOK - Bobrick B-672
TA-6	HAND DRYER - DYSON AIRBLADE - AB-02
TA-7	RECESSED HORIZONTAL MOUNTED STAINLESS STEEL FINISH BABY CHANGING STATION - KOALA KARE KB110-SSRE
TA-8	RECESSED EMERGENCY TELEPHONE - TALK A PHONE - ETB-100EB
TA-9	SURFACE MOUNTED NAPKIN/TAMPON VENDOR - Bobrick B-2800
TA-10	BRUSHED SS304 CORNER - Schluter Rondec RO-100EB
TA-11	RESTROOM VERTICAL LIGHT POCKET W/FROSTED GLASS LENS & W/ ANTI GRAFITTI FILM
US-1	UTILITY SHELF - 12" WIDE X 3/4" THK. PARTICLE BD. WITH PLASTIC LAMINATE, SELF EDGED. INSTALL WALL TO WALL.
WT-1	WALL COVE BASE TILE - EURO WEST - DELUXE COLLECTION - HONED/PERLA FINISH
WT-2	WALL TILE ABOVE WAINSCOT - DAL TILE - P6985 - MATTE FINISH (12"x24")
WT-3	WALL TILE BELOW WAINSCOT - DAL TILE - P690 - MATTE FINISH (12"x24")
WT-4	WAINSCOT ACCENT - EUROWEST - FREEFORM COLLECTION - STAINLESS STEEL
WT-5	FEATURE WALL - INTERSTYLE - GLASS HUES - SUMMER WHITE FINISH

Consultants:

Registration No.

Key Plan

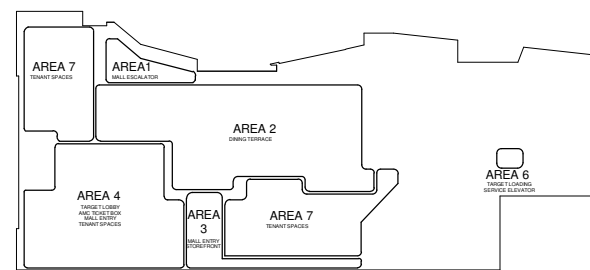


Sheet Title

MEN'S RESTROOMS
ENLARGED PLANS

Job No. Date Scale
1295 SEPT 01, 2010. 1/4" = 1'-0"


A6.2-0

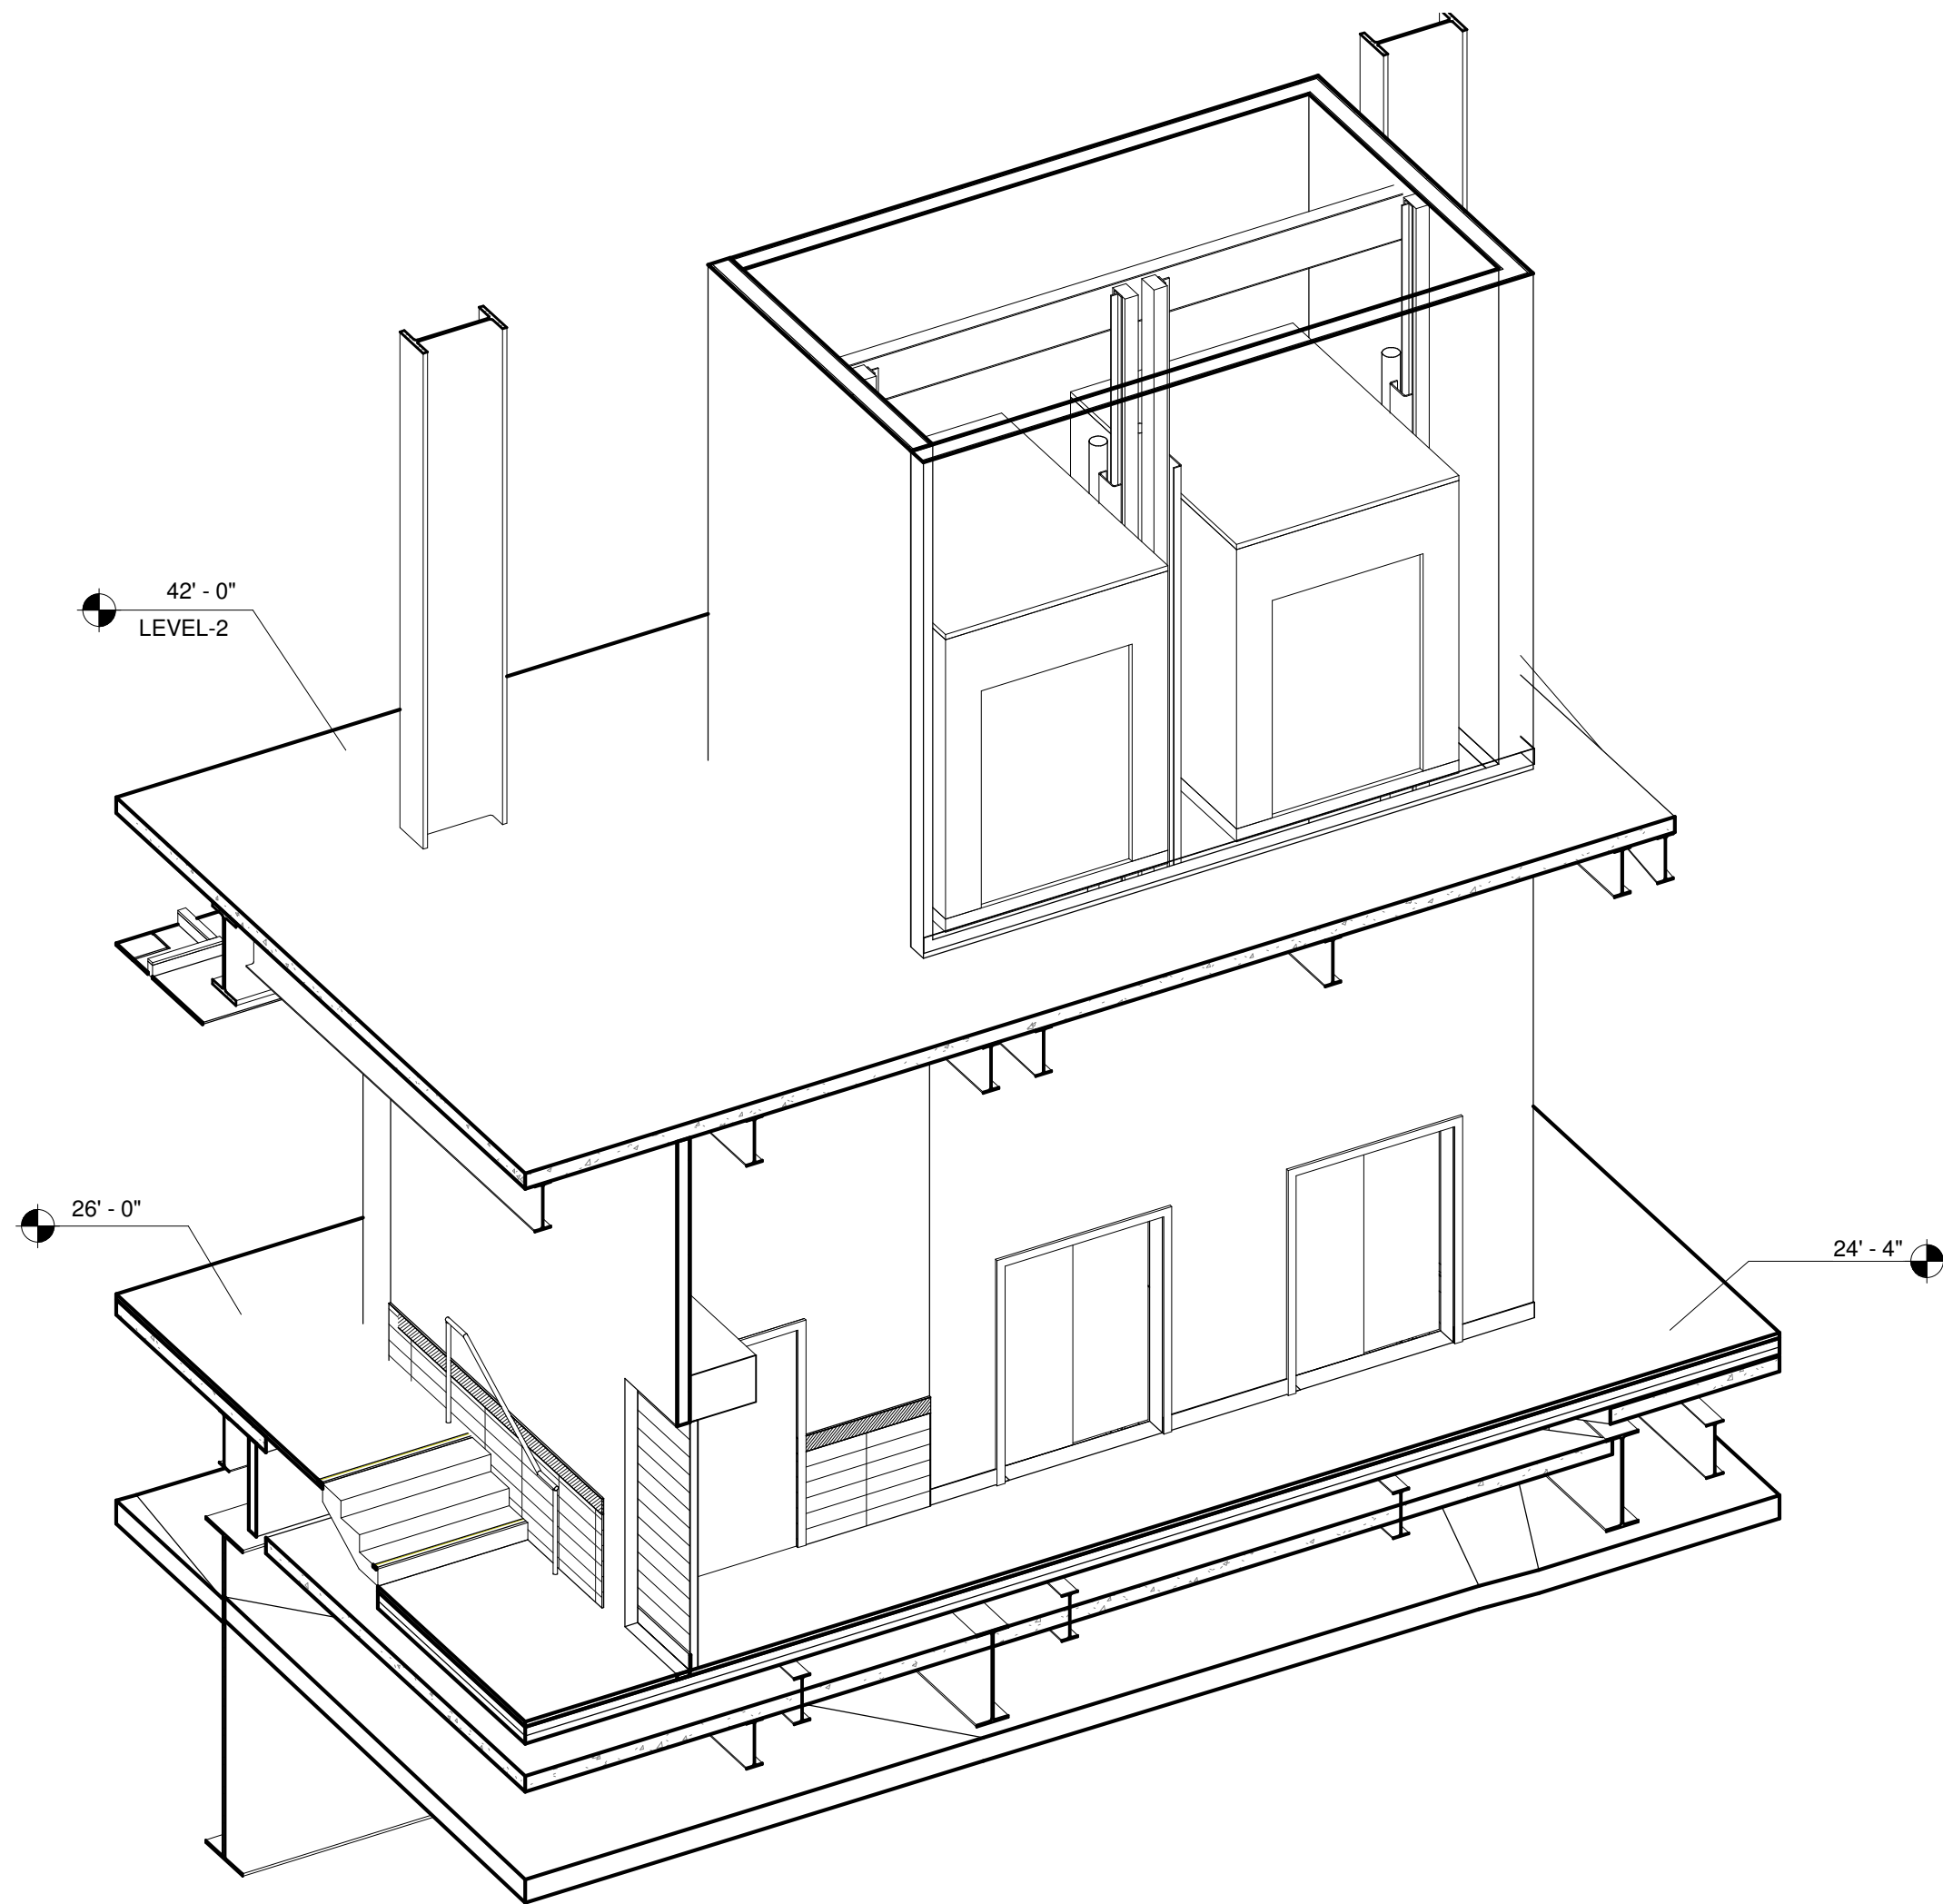

3D-AXONOMETRIC OF (N) ELEVATOR

SCALE

4

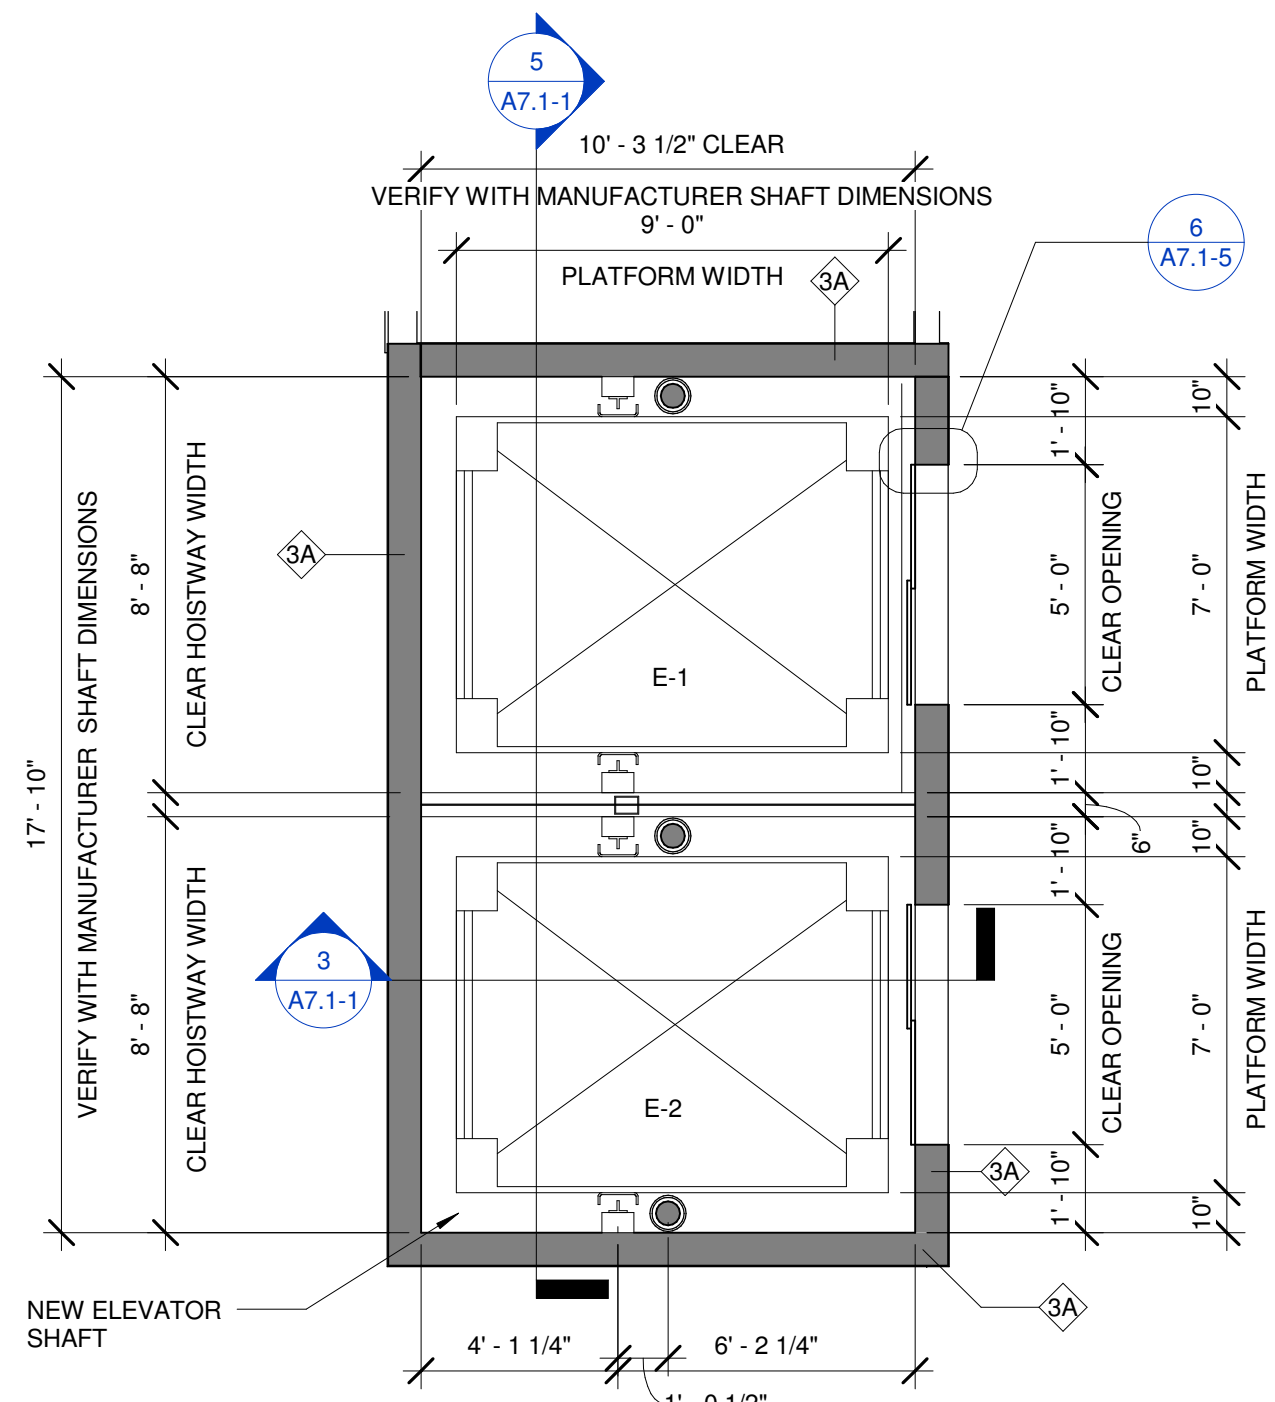


ELEVATOR (N) E1 & (N) E2 LEVEL-2

SCALE
1/4" = 1'-0"

2

GENERAL NOTES:


1. VERIFY IN FIELD ALL FLOOR LEVEL HEIGHTS
2. DETAILS AND INFORMATION OF THIS PACKAGE WAS BASED ON MEI ELEVATOR.
3. CHECK PIT SIZES WITH MANUFACTURER INFORMATION
4. SEE STRUCTUAL DRAWING FOR SLAB EDGE DIMENSIONS AND STRUCTUAL FRAMING FOR ELEVATOR.
5. SLAB EDGE AND OPENING TO BE VERIFIED AFTER FINAL SELECTION OF ELEVATOR MANUFACTURER.
6. VERIFY DIMENSIONS WITH ELEVATOR MFR. PRIOR TO INSTALLATION OF ELEVATOR AND FLOOR SLAB.
7. PROVIDE FIRE PROOFING ON ALL NEW STRUCTURAL FLOOR BEAMS PER LOCAL CODE. JURISDICTIONAL AUTHORITY.
8. FOR WALL TYPES REFER SHEET- A8.1-1 & A8.1-2.
9. PLEASE REPAIR ANY DAMAGE TO FIRE PROOFING.
10. PROVIDE VENT AS REQUIRED

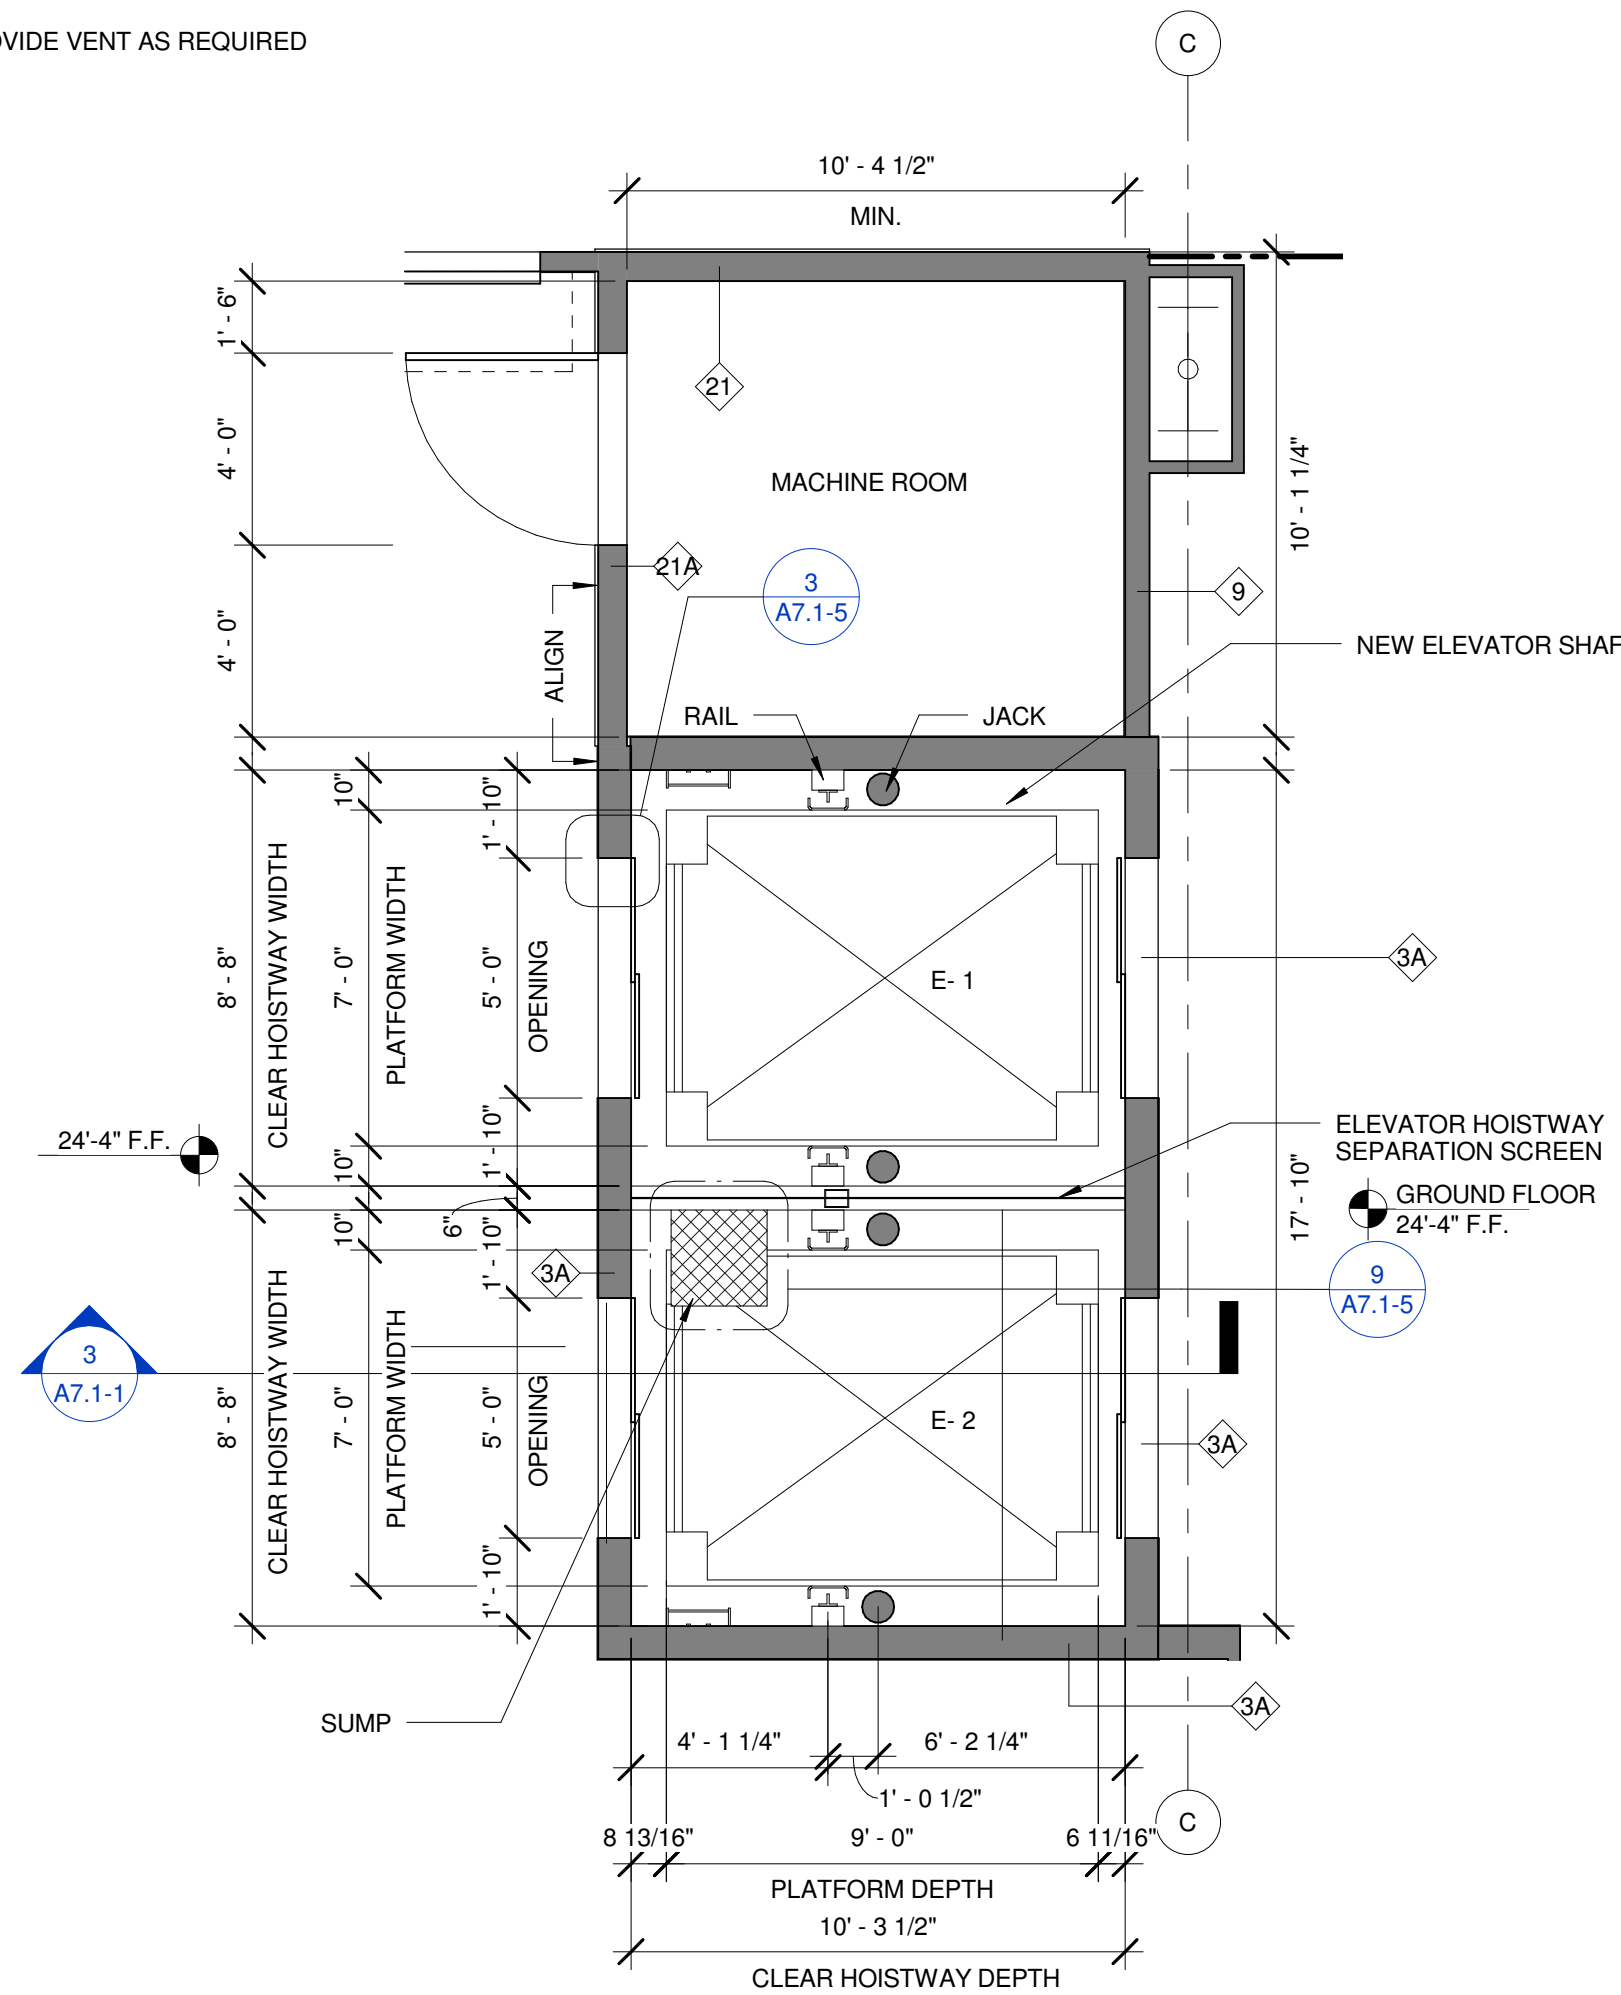

ELEVATOR (N) E1, (N) E2 AND MACHINE RM. LEVEL 1

SCALE
1/4" = 1'-0"


1

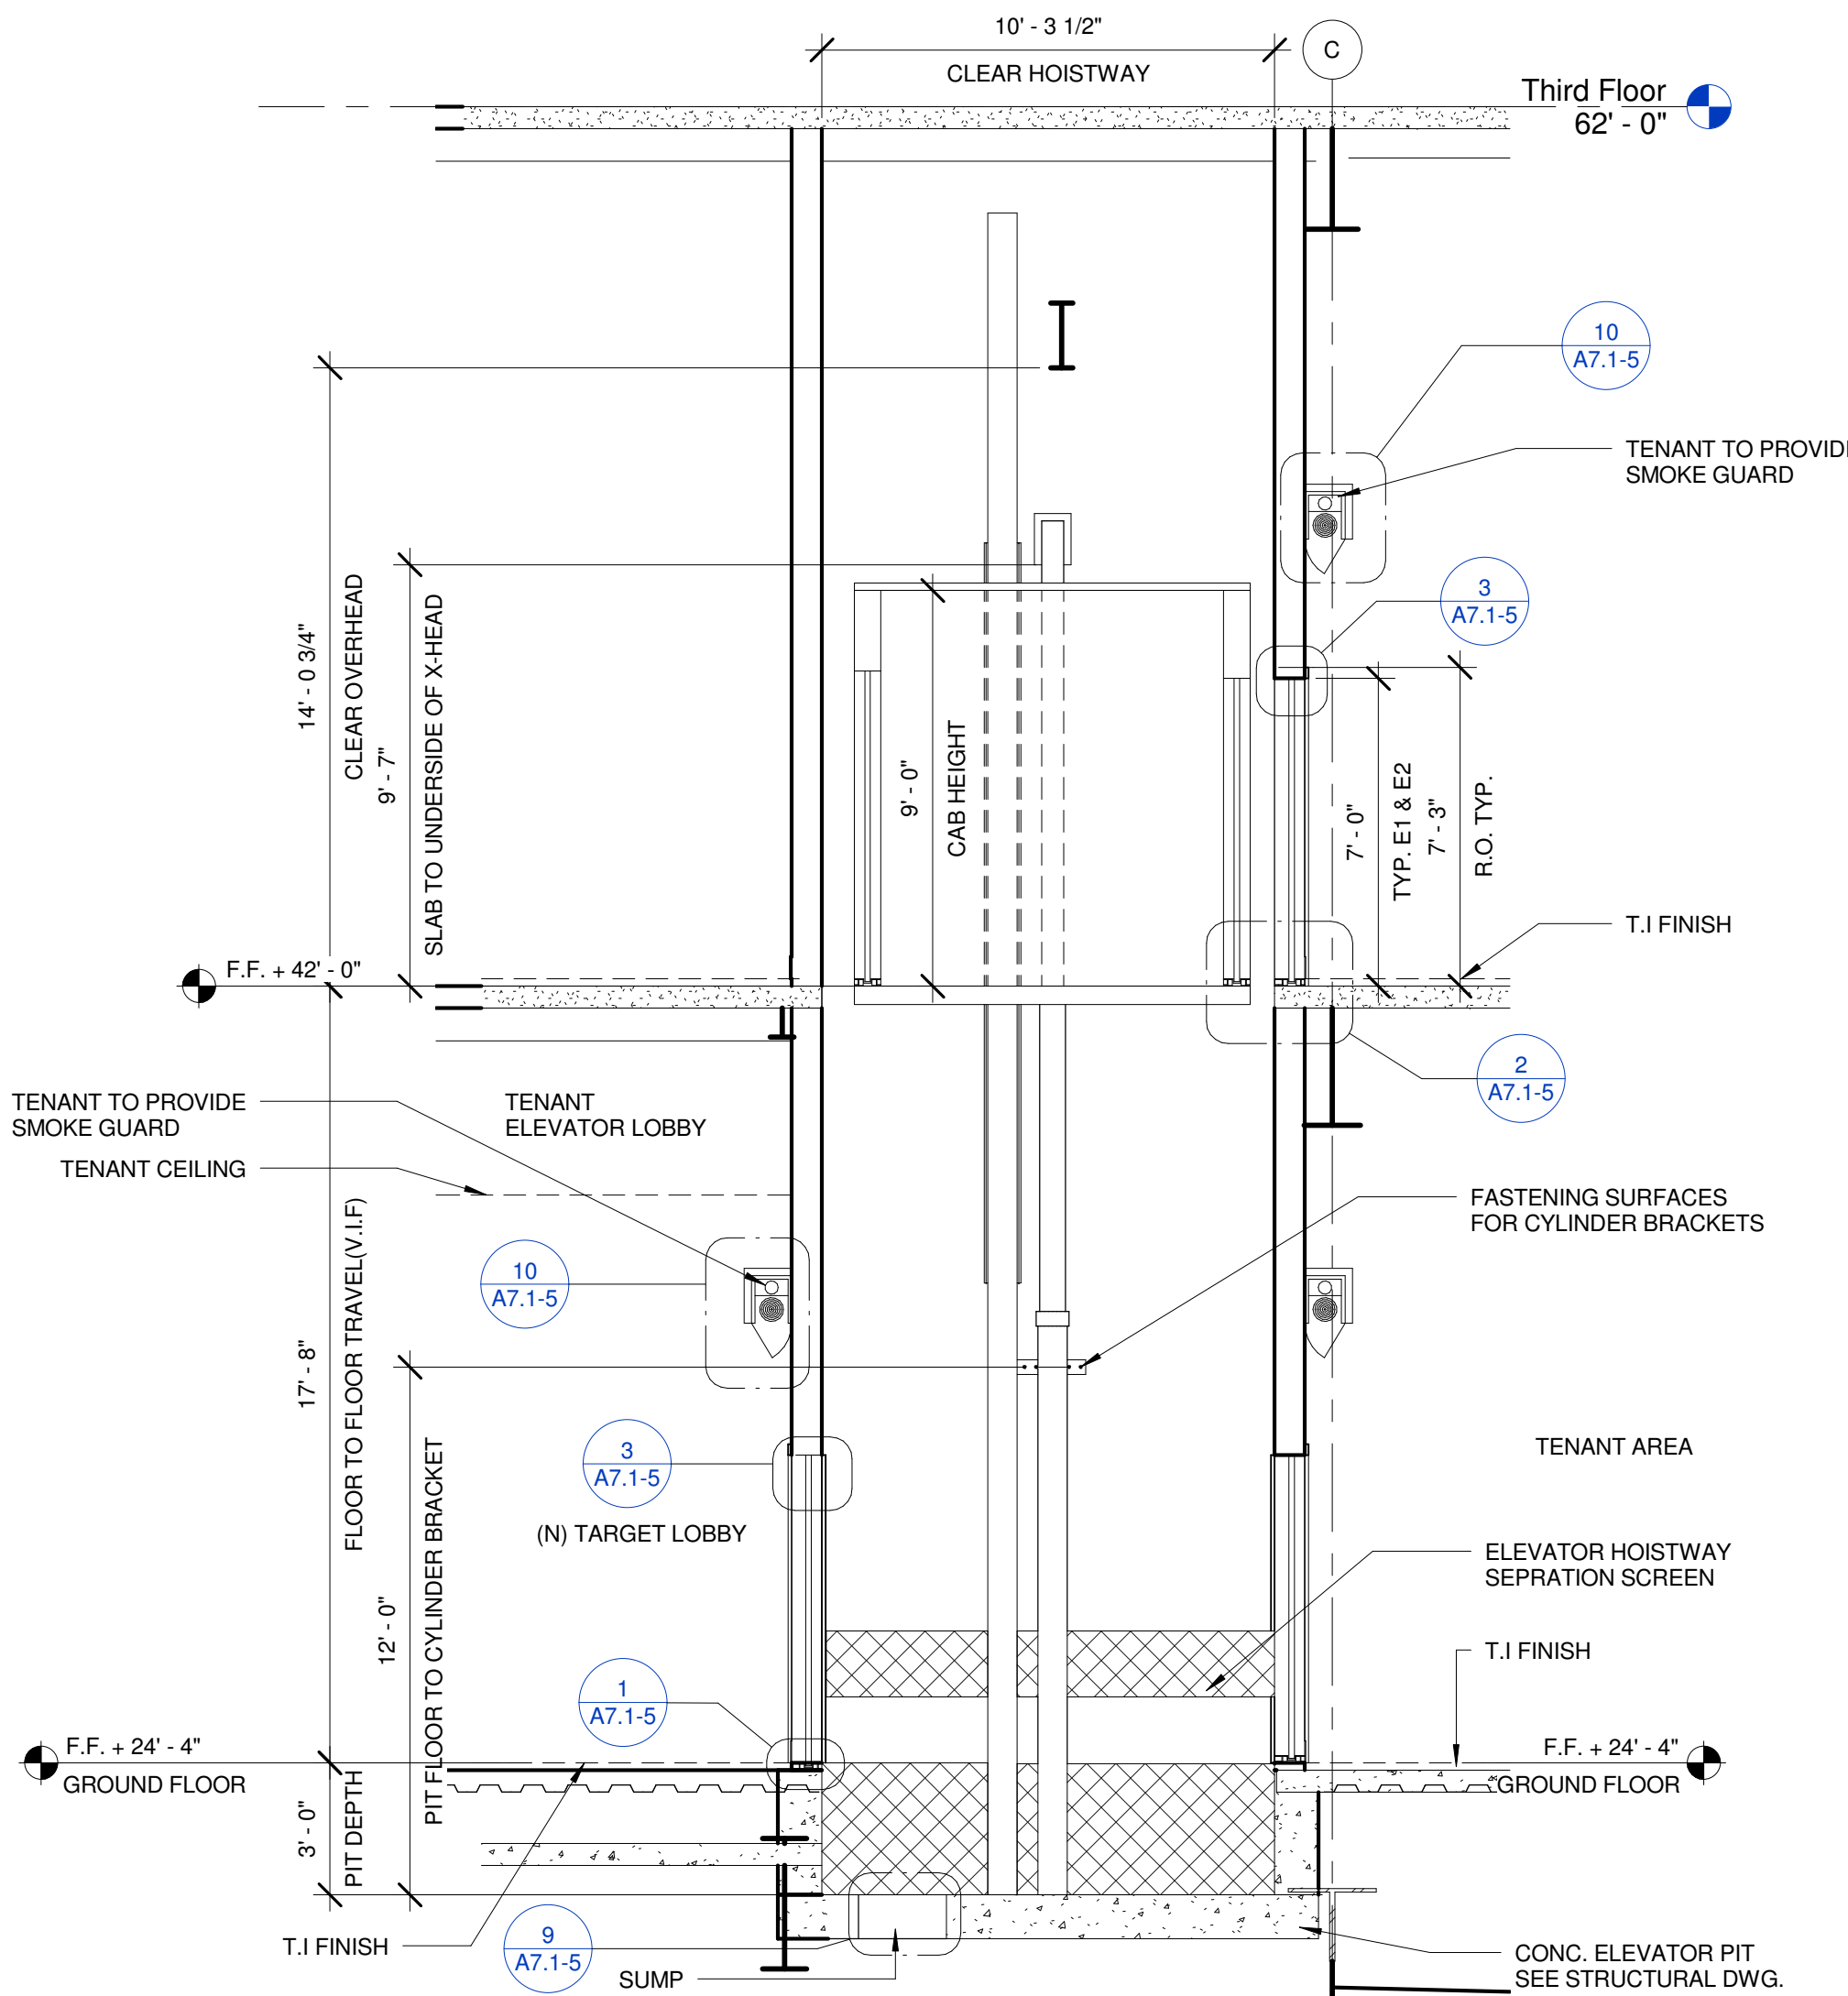

ELEVATOR SECTION-A

SCALE
1/4" = 1'-0"

3

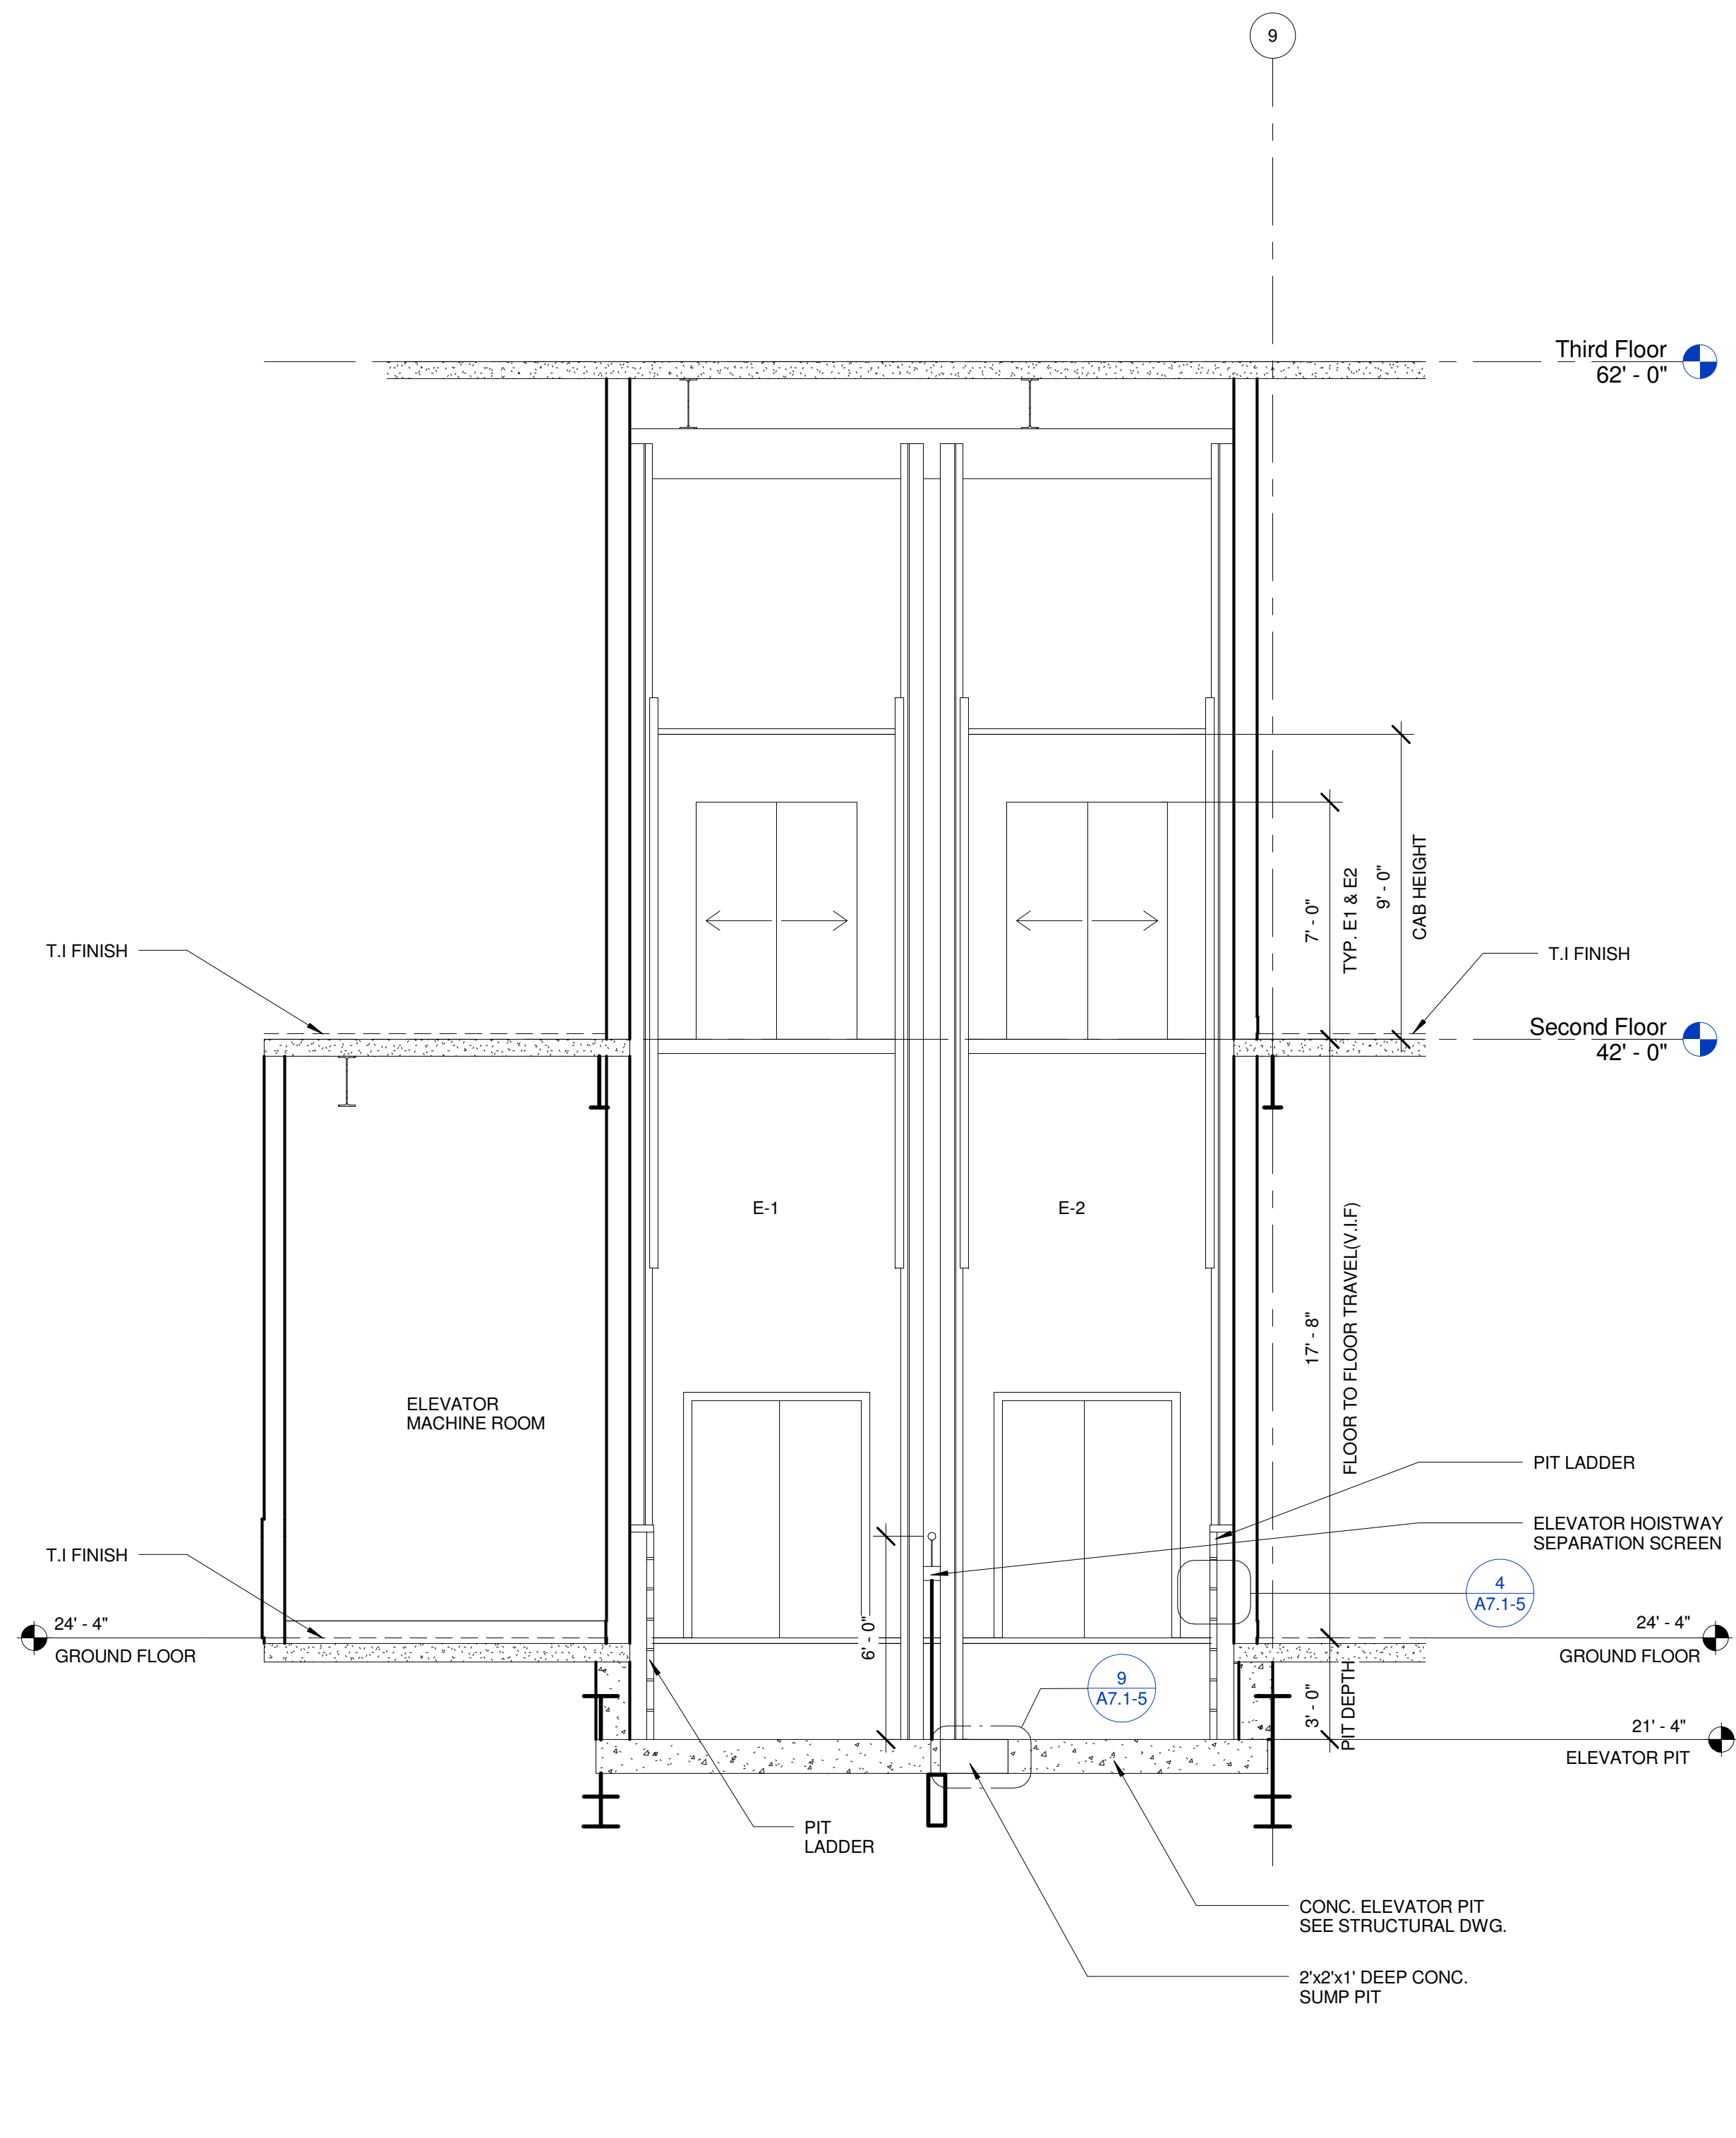

ELEVATOR SECTION-B


SCALE
1/4" = 1'-0"

5

Consultants:

Registration No.

Key Plan

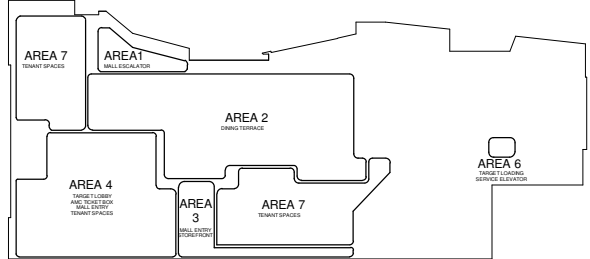


Sheet Title


ELEVATOR NO. 1 &
2 PLANS, SECTIONS
AND DETAILS

Job No. Date Scale
1295 SEPT 01, 2010. 1/4" = 1'-0"


A7.1-1

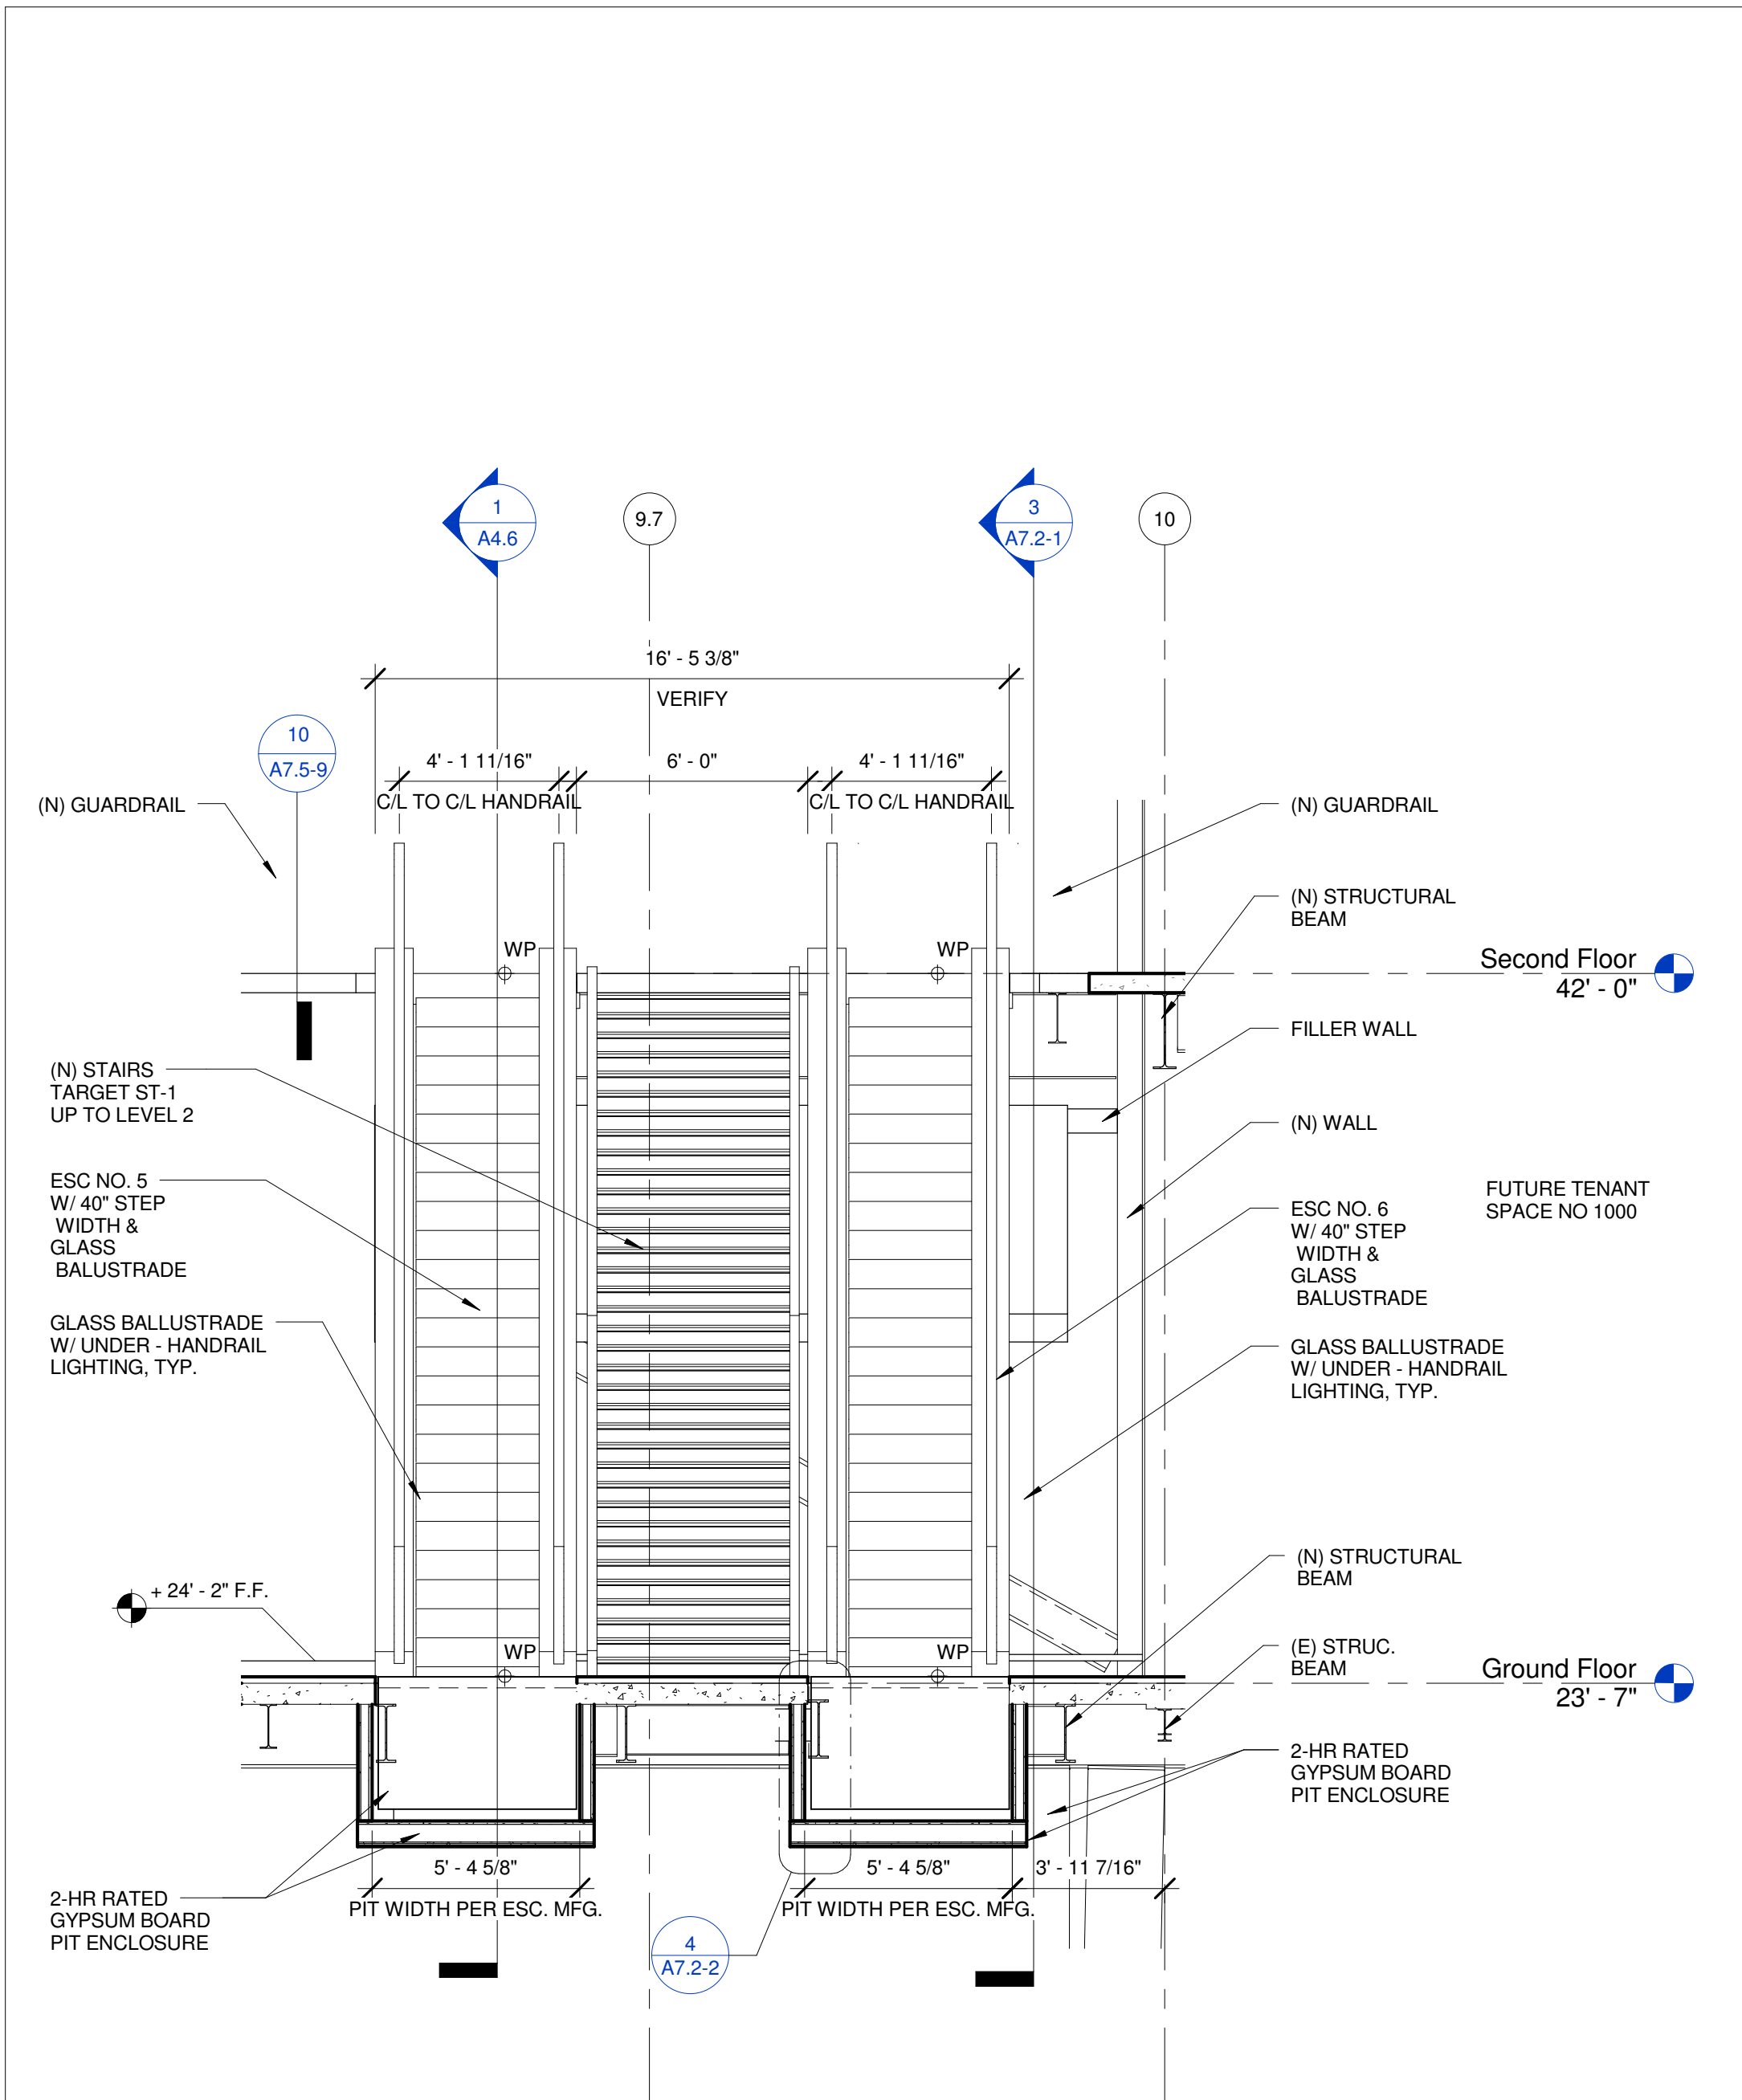


SECTION
SCALE
1/4" = 1'-0"

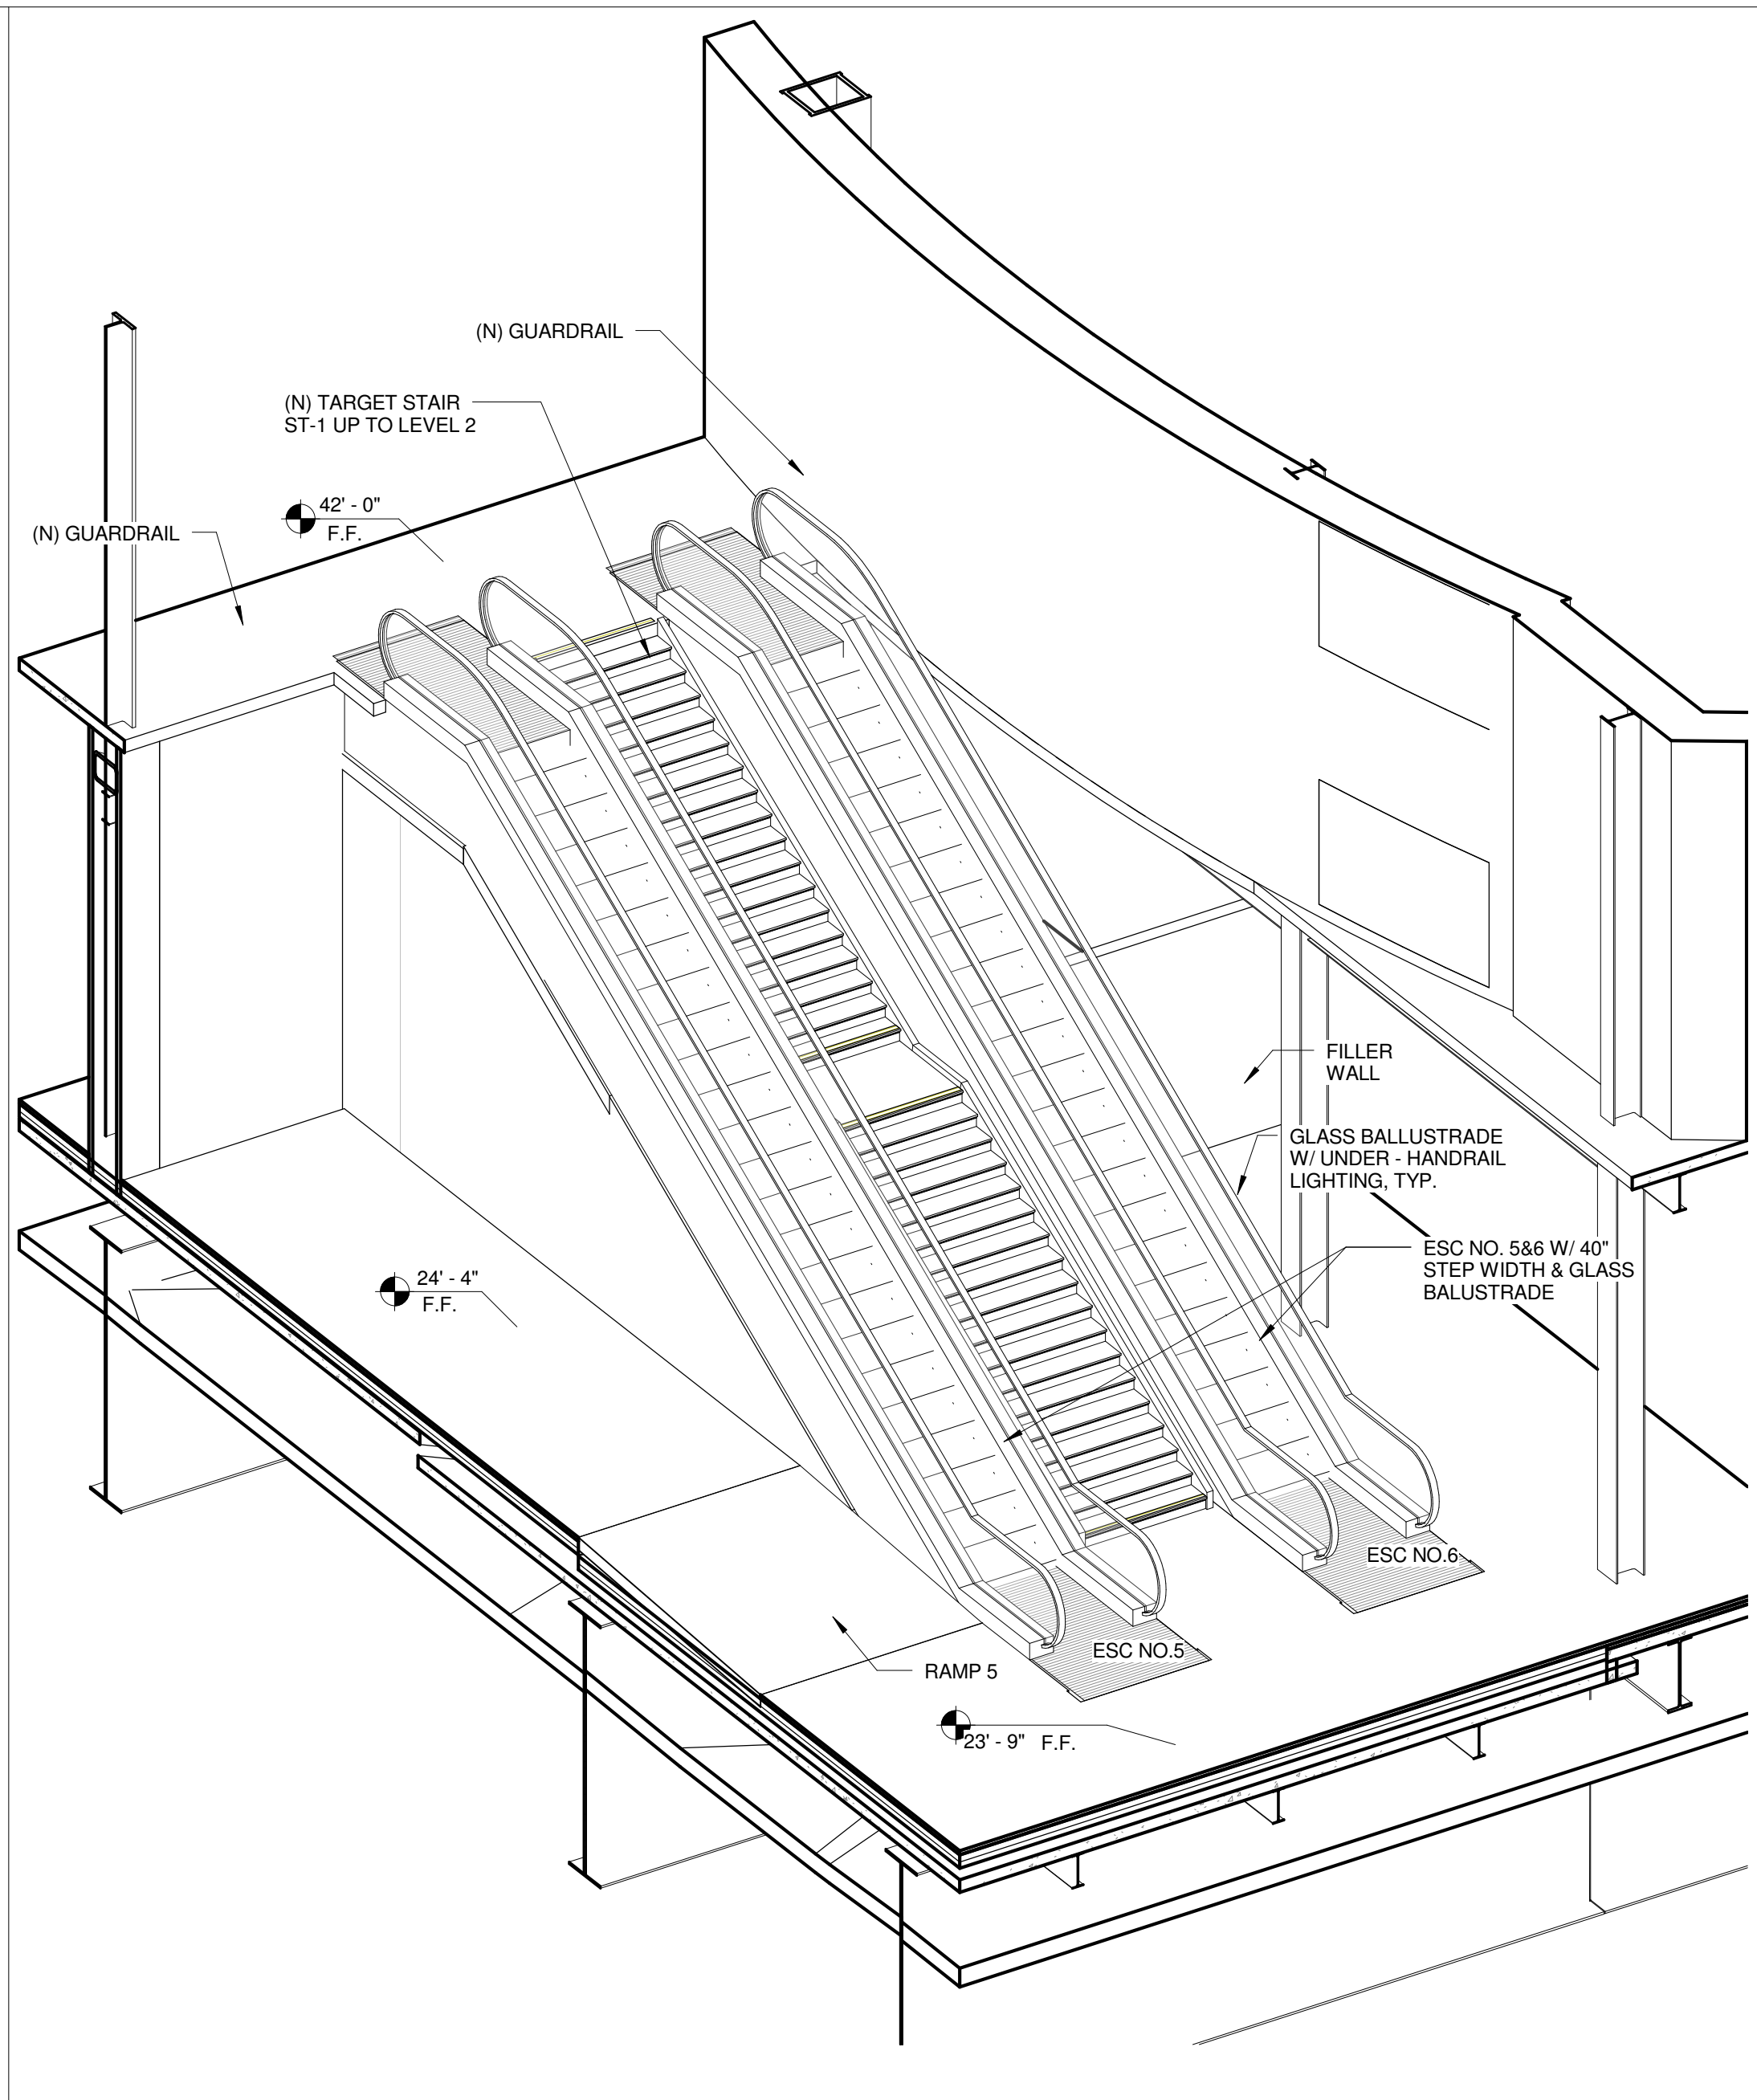

3D-AXONOMETRIC OF ESCALATOR
SCALE
1/4" = 1'-0"

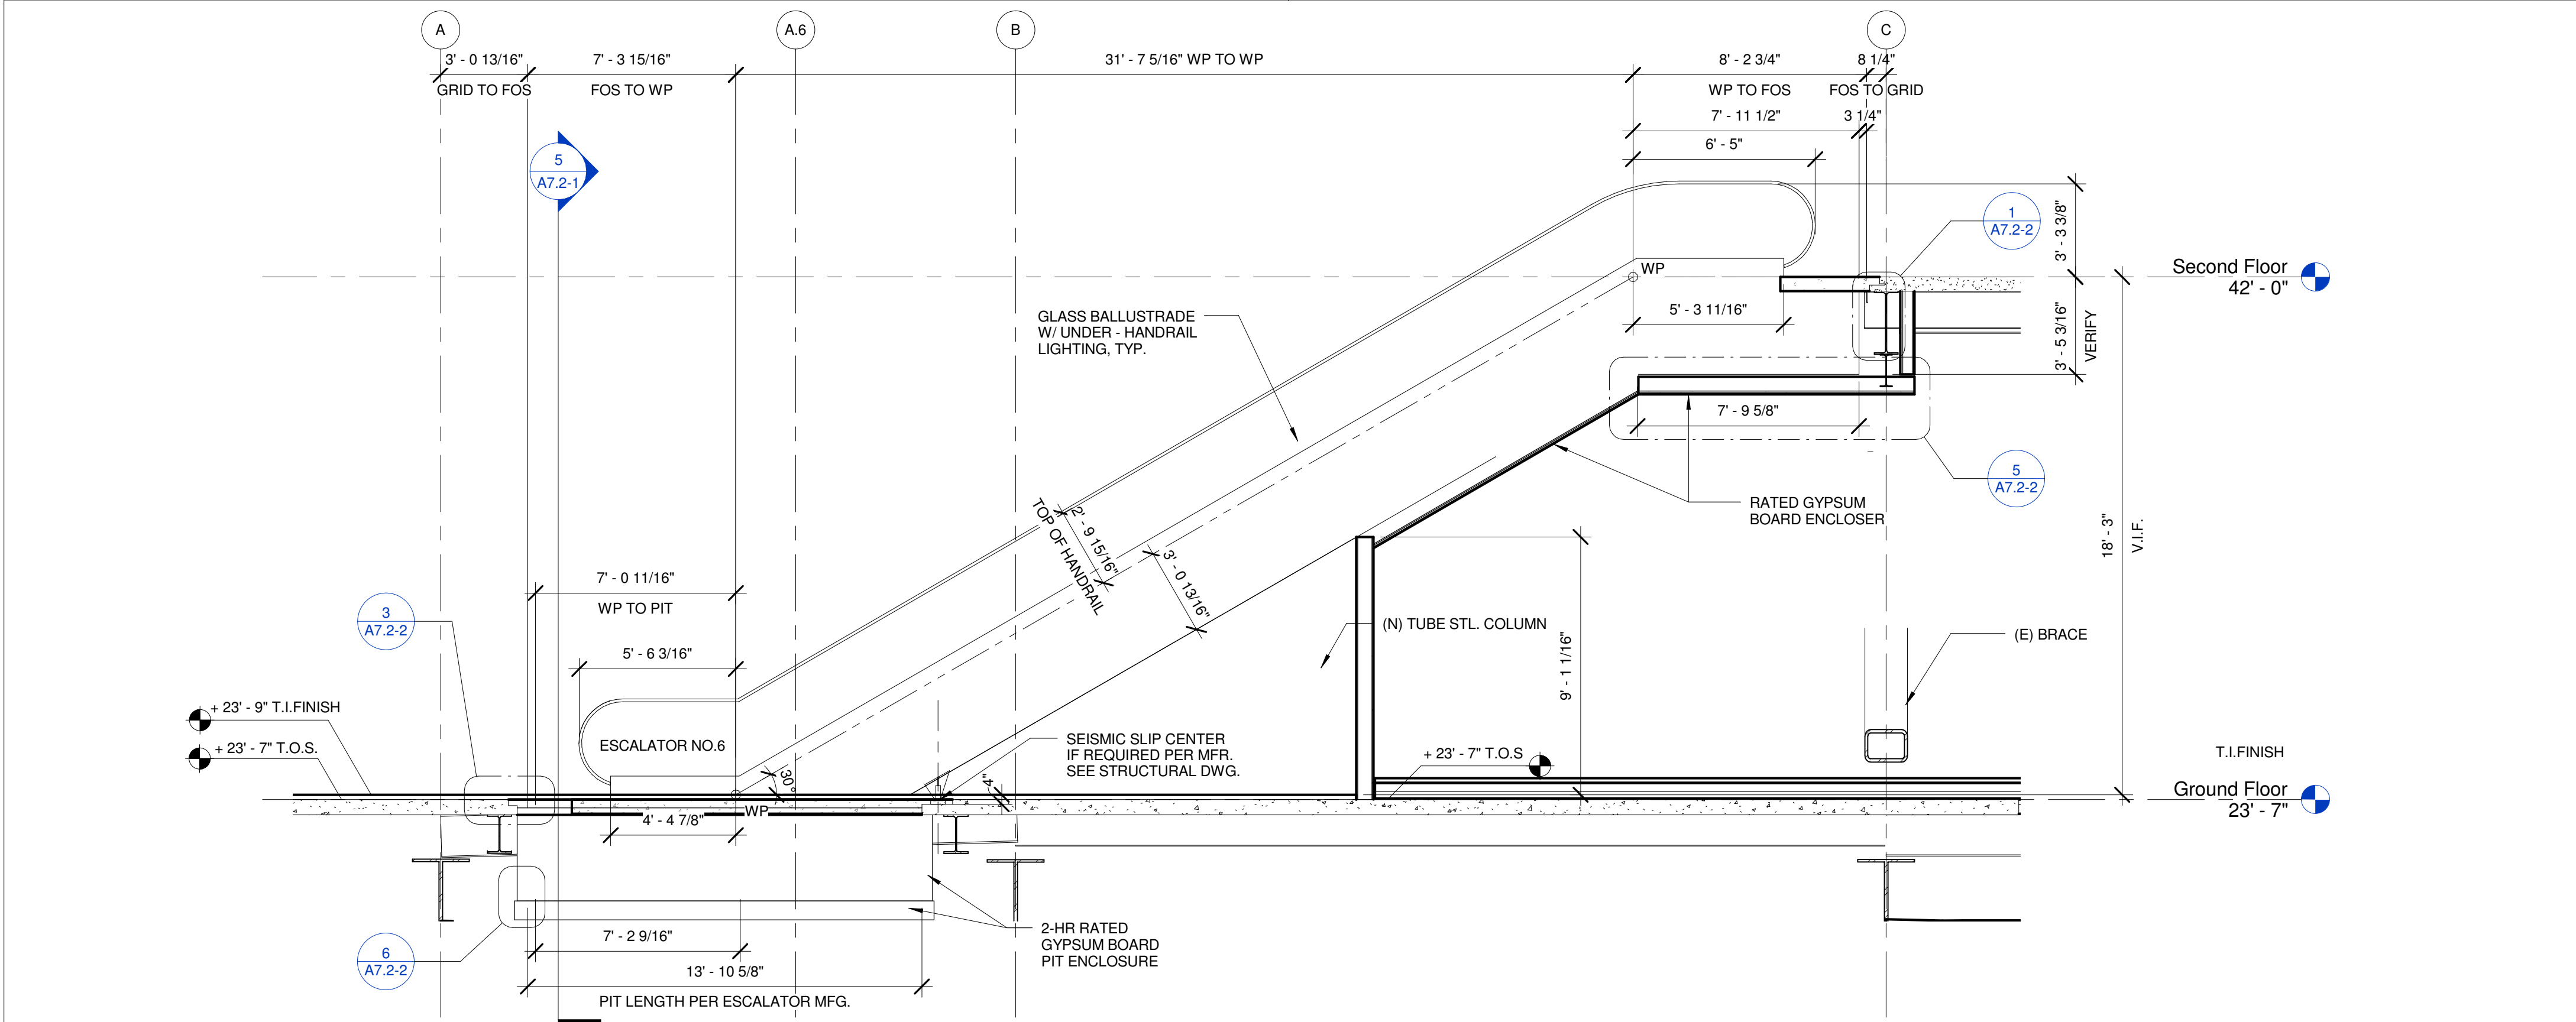


ESCALATOR SECTION
SCALE
1/4" = 1'-0"

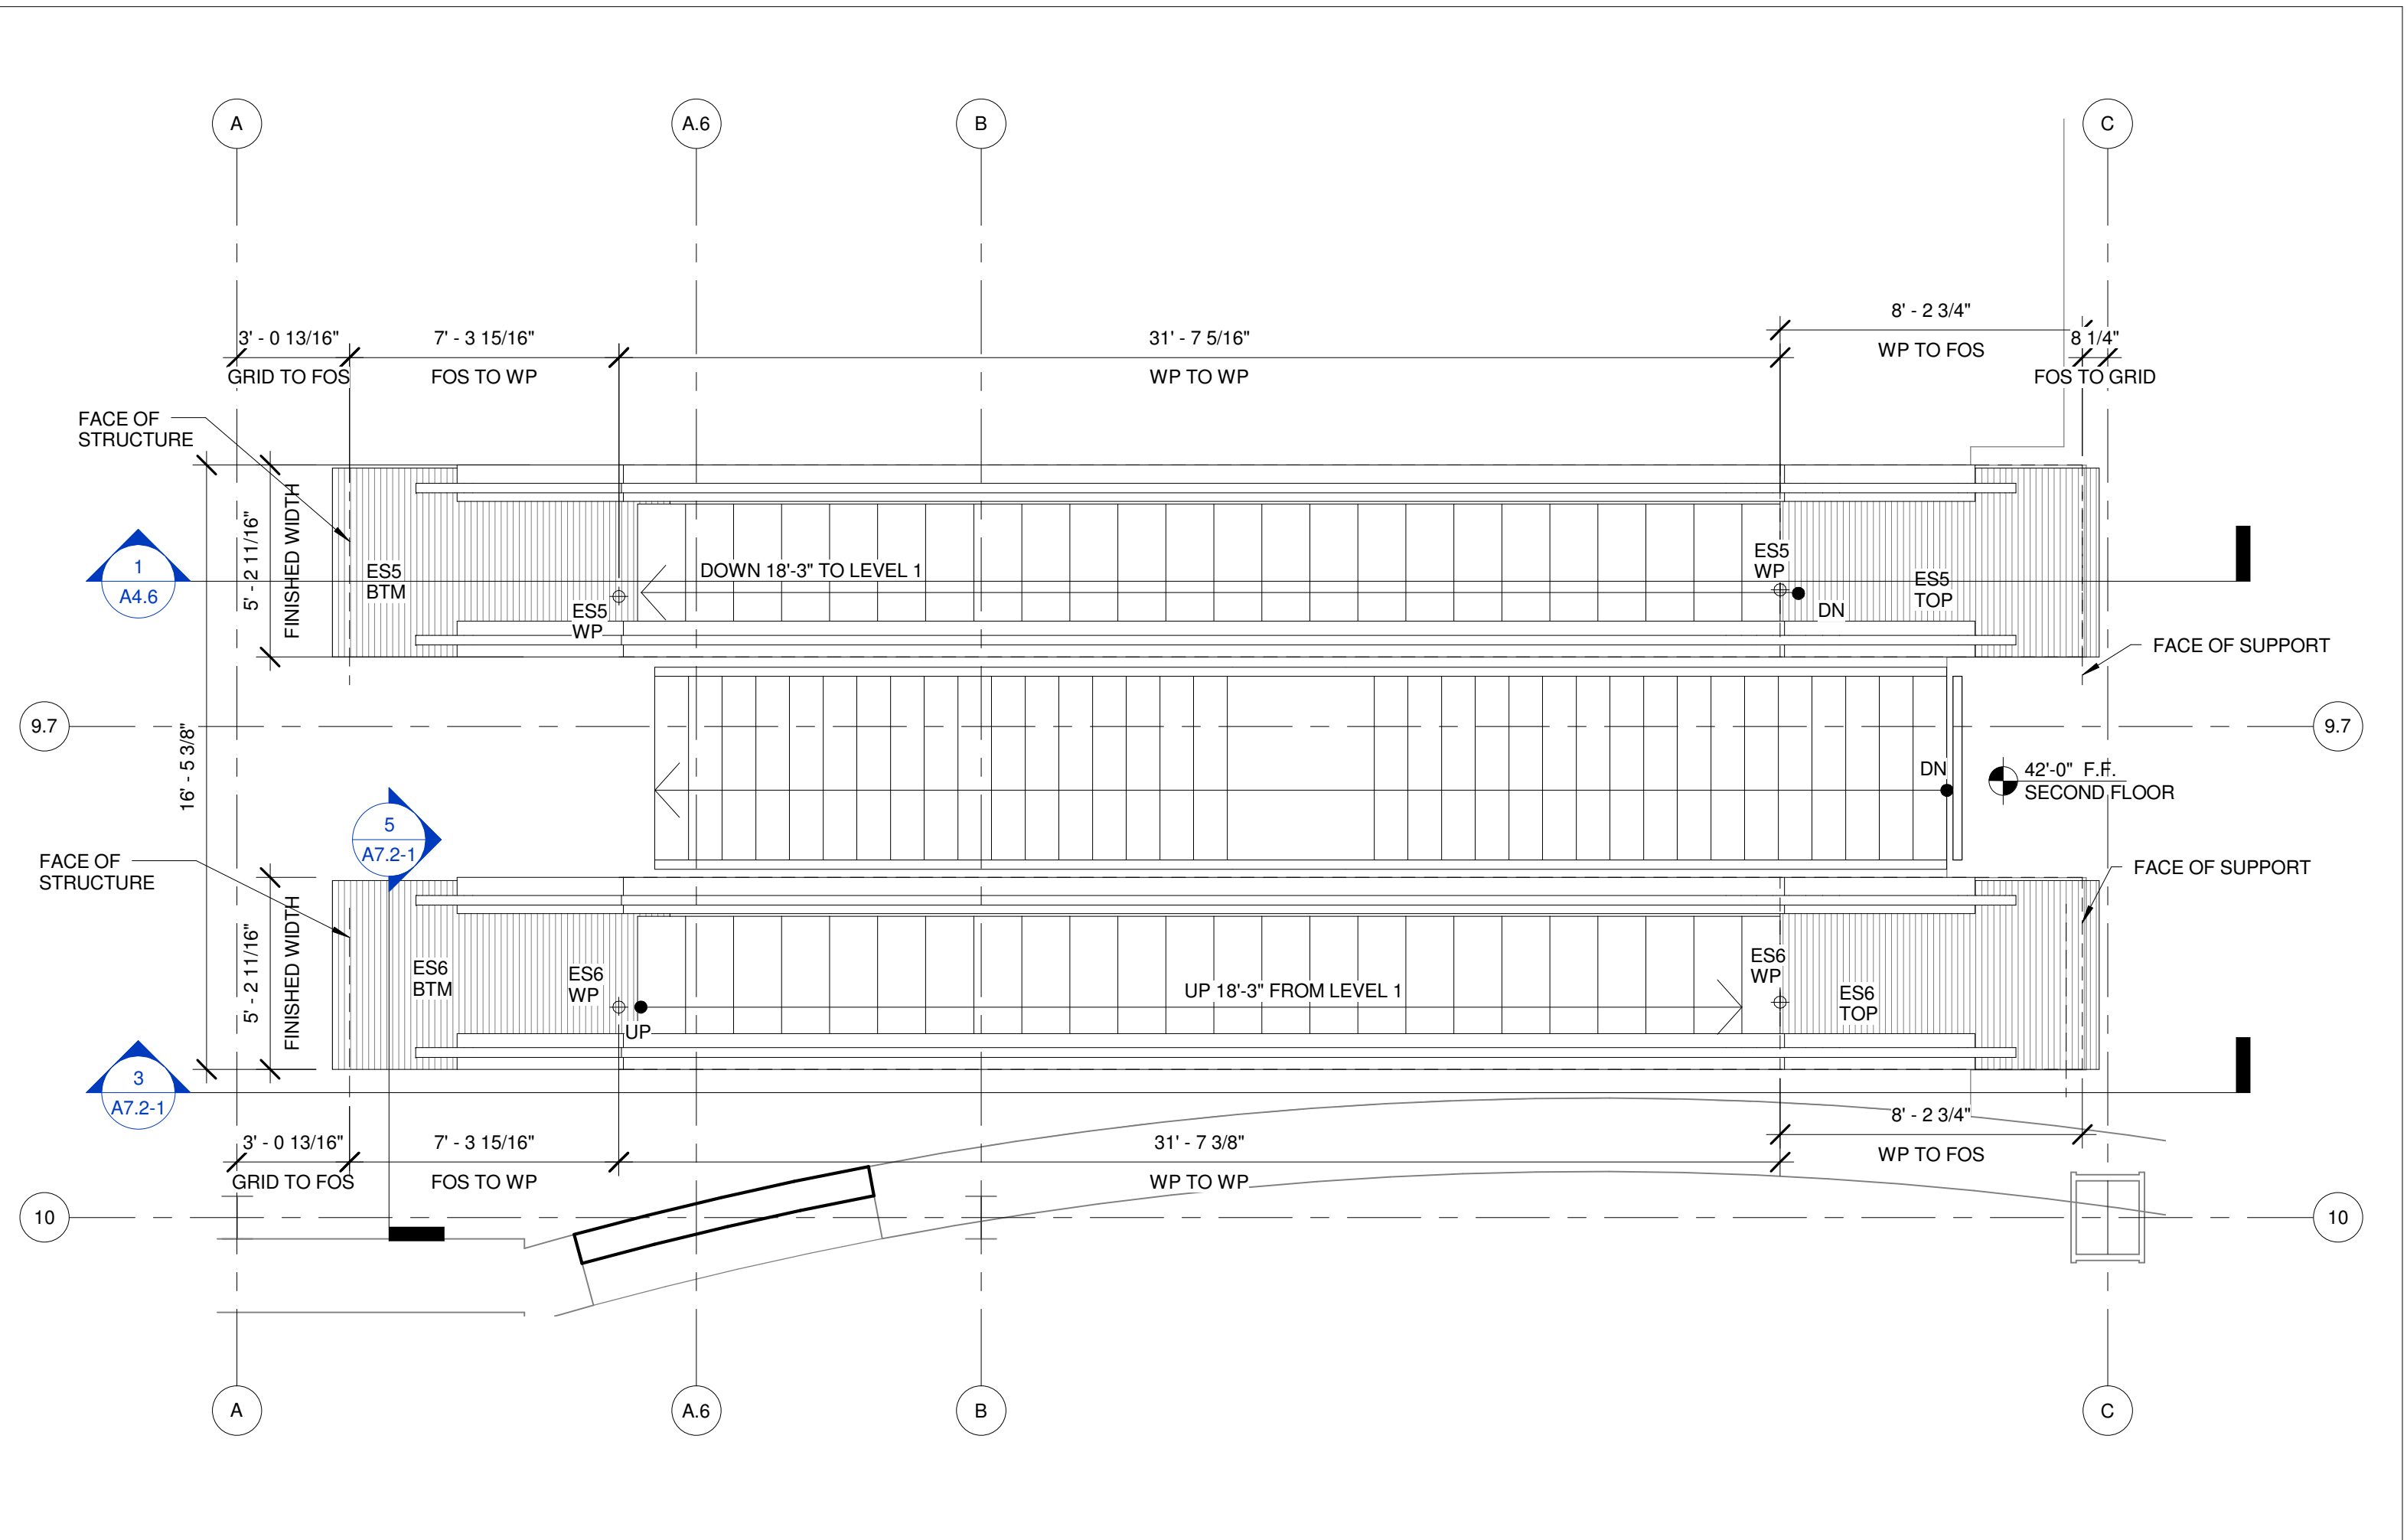

ESCALATOR NO. 5 AND 6 PLAN AT LEVEL 2
SCALE
1/4" = 1'-0"

- GENERAL NOTES:
1. VERIFY IN FIELD ALL FLOOR LEVEL HEIGHTS.
 2. LOCATION AND DIMENSIONS OF ESCALATOR WORK POINTS ARE AFFECTED BY THE HEIGHT OF THE ESCALATOR.
 3. DETAILS AND INFORMATION OF THIS PACKAGE WAS BASED ON KONE ESCALATOR.
 4. SEE STRUCTURAL DRAWING FOR SLAB EDGE DIMENSIONS AND STRUCTURAL FRAMING FOR ESCALATOR.
 5. SLAB EDGE AND OPENING TO BE VERIFIED AFTER FINAL SELECTION OF ESCALATOR MANUFACTURER.
 6. VERIFY DIMENSIONS WITH ESCALATOR MFR. PRIOR TO INSTALLATION OF ESCALATOR AND FLOOR SLAB.
 7. PAINT (E) PIPE COLUMN W/ INTUMESCENT PAINT IF REQUIRED BY LOCAL CODE JURISDICTIONAL AUTHORITY.
 8. PROVIDE FIRE PROOFING ON ALL NEW STRUCTURAL FLOOR BEAMS PER LOCAL CODE JURISDICTIONAL AUTHORITY.
 9. PROVIDE 1 1/2" GUARDRAIL FRAME 36" A.F.F. (MATCH EXISTING HEIGHT) CAPABLE OF WITHSTANDING HORIZONTAL LOAD OF 50 LBS P.L.F. GUARDRAIL FRAME TO MATCH (E) GUARDRAIL W/O GLASS PANELS.
 10. IF FIRE PROOFING IS NEEDED ON (E) PIPE COLUMNS FOR COLUMNS INDICATED ON PLAN, THEN PAINT ALL OTHER (E) PIPE COLUMN TO MATCH INTUMESCENT PAINT COLOR. COORDINATE W/ ARCHITECT ON PAINT TYPE AND COLOR.
 11. DRAFT STOPS TO EXTEND DOWNWARD AT LEAST 12" BELOW THE CEILING. FIRE SPRINKLERS SHALL BE INSTALLED IN THE CEILING WITHIN 2' OF THE
 12. SEE 3/A7.2.3 FOR ADDITIONAL INFORMATION ON THE (E) GLASS GUARDRAIL.
 13. SEE SHEET NO. A7.2.2 FOR ESCALATOR TECHNICAL INFORMATION.

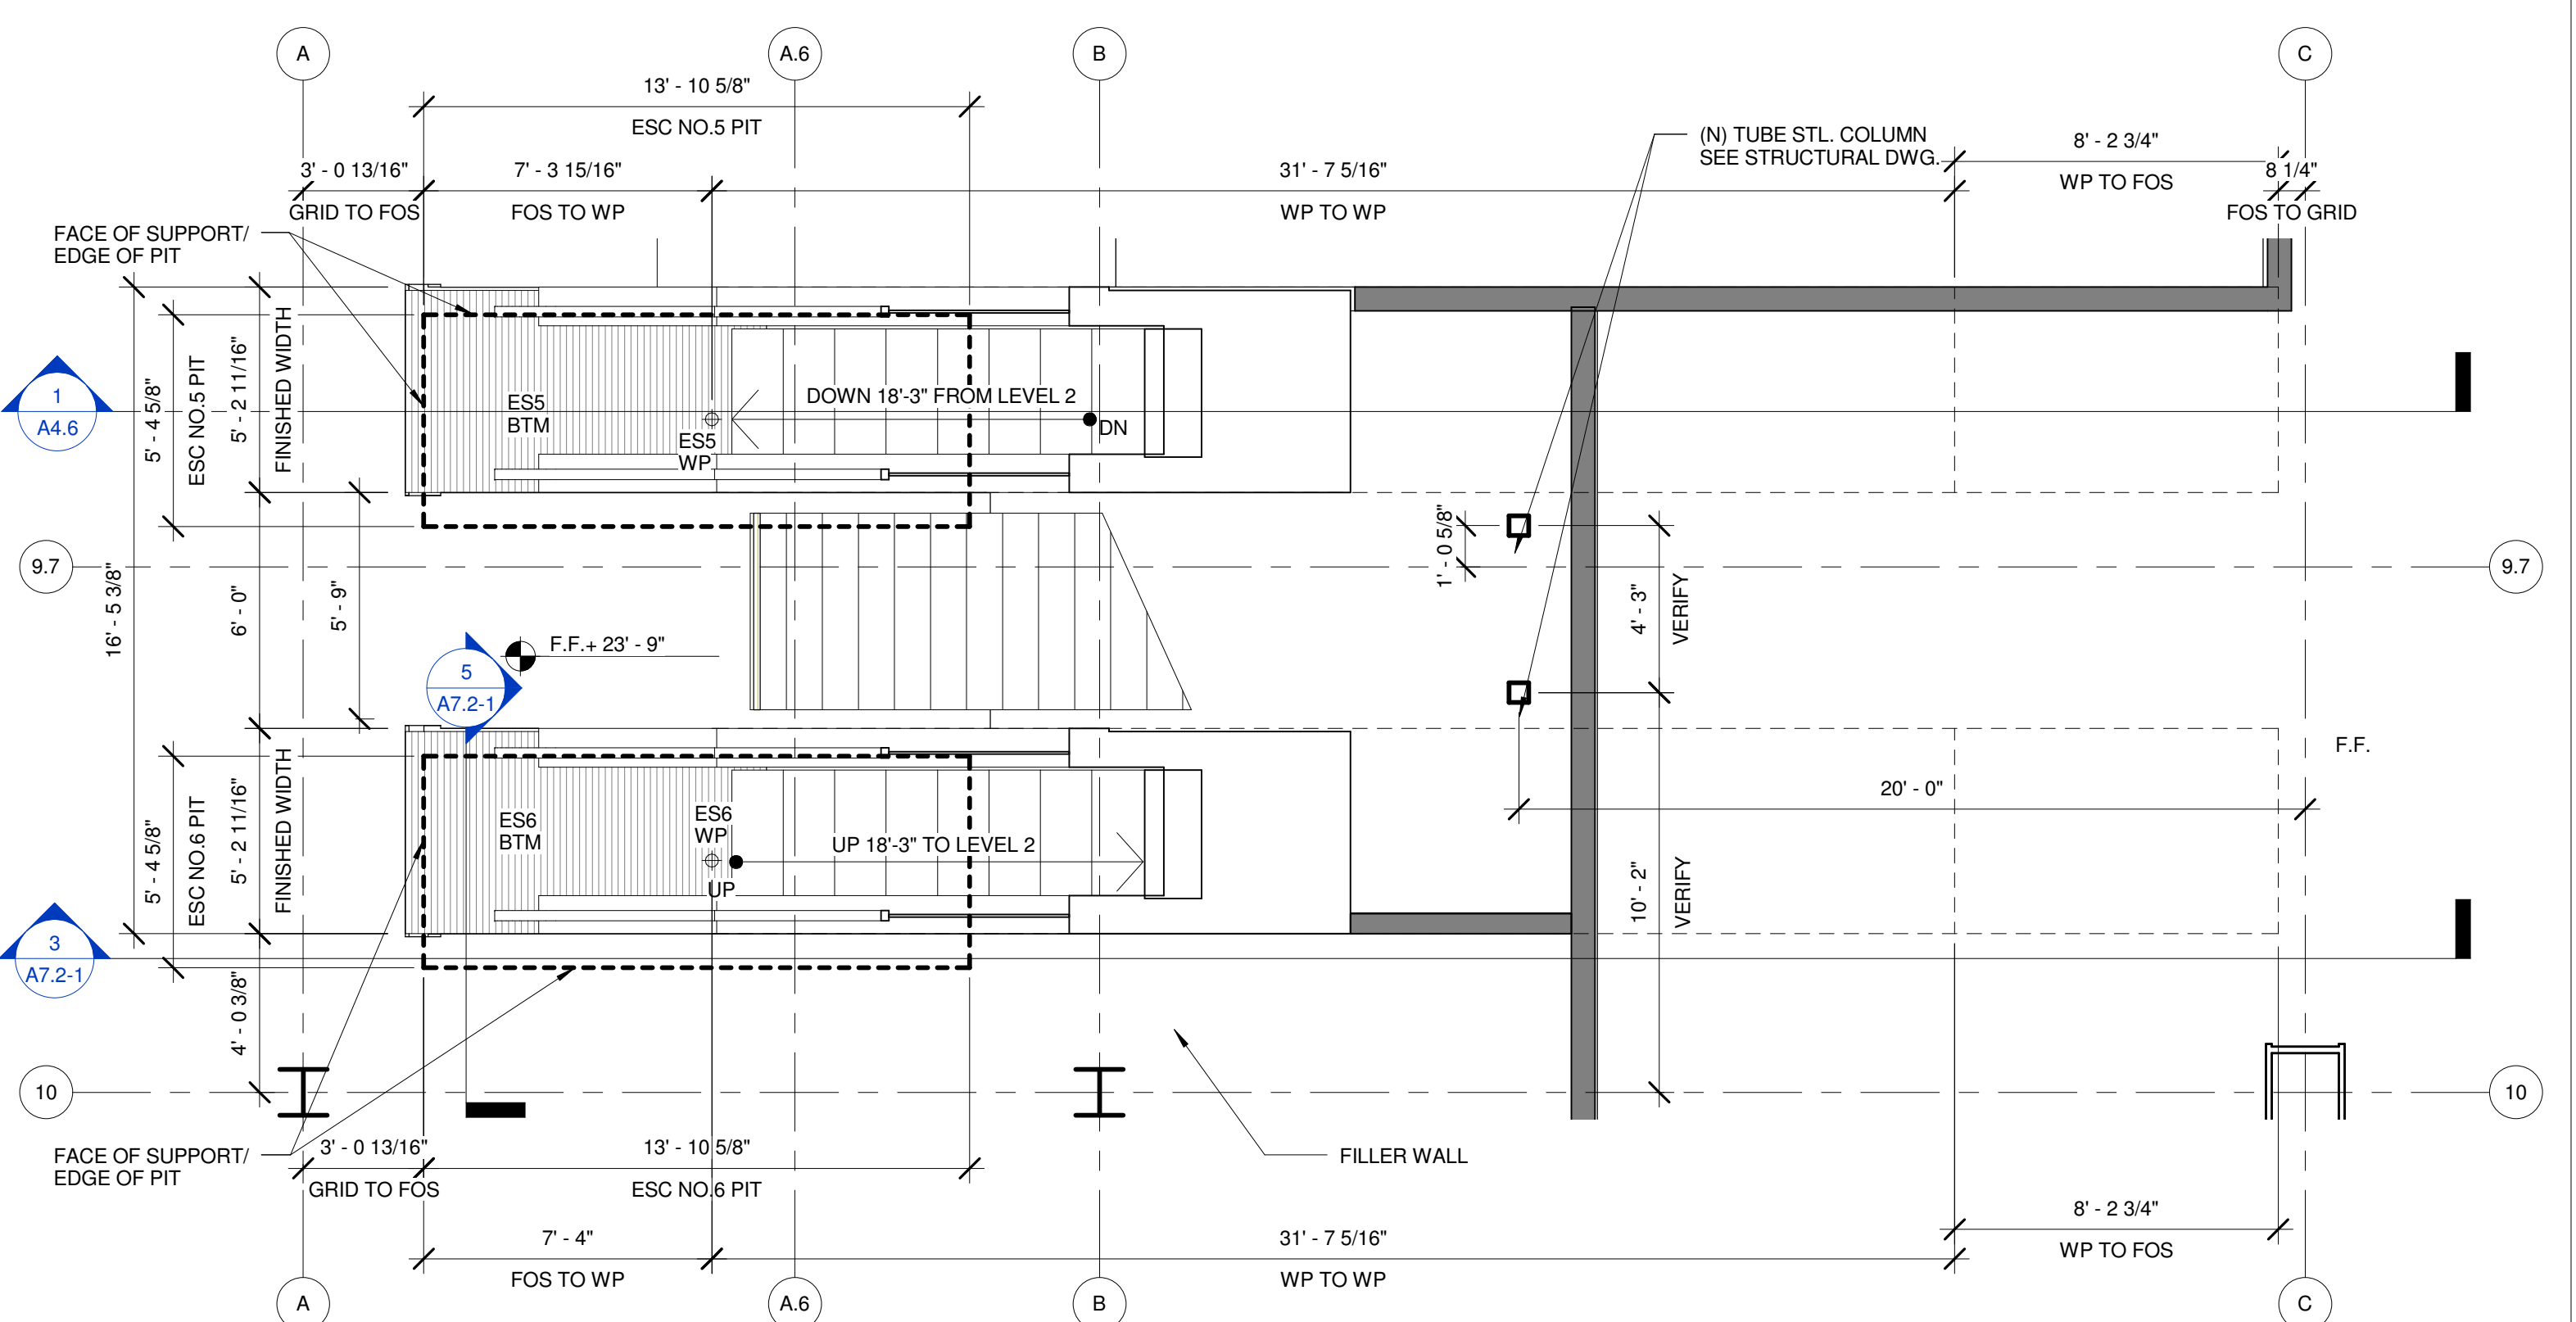

ESCALATOR NO. 5 AND 6 PLAN AT LEVEL 1
SCALE
1/4" = 1'-0"

Consultants:	Registration No.	Key Plan

Sheet Title
ESCALATOR NO. 5 & 6 PLANS, SECTIONS, AND 3D-AXONOMETRICS

Job No. Date Scale
1295 SEPT 01, 2010. 1/4" = 1'-0"

A7.2-1

Sheet Title
**RELOCATED
STAIRS 6,6.5,7 & 7.5
PLANS &
PERSPECTIVES**

Job No.	Date	Scale
1295	SEPT 01, 2010.	1/4" = 1'-0"

A7.5-5